
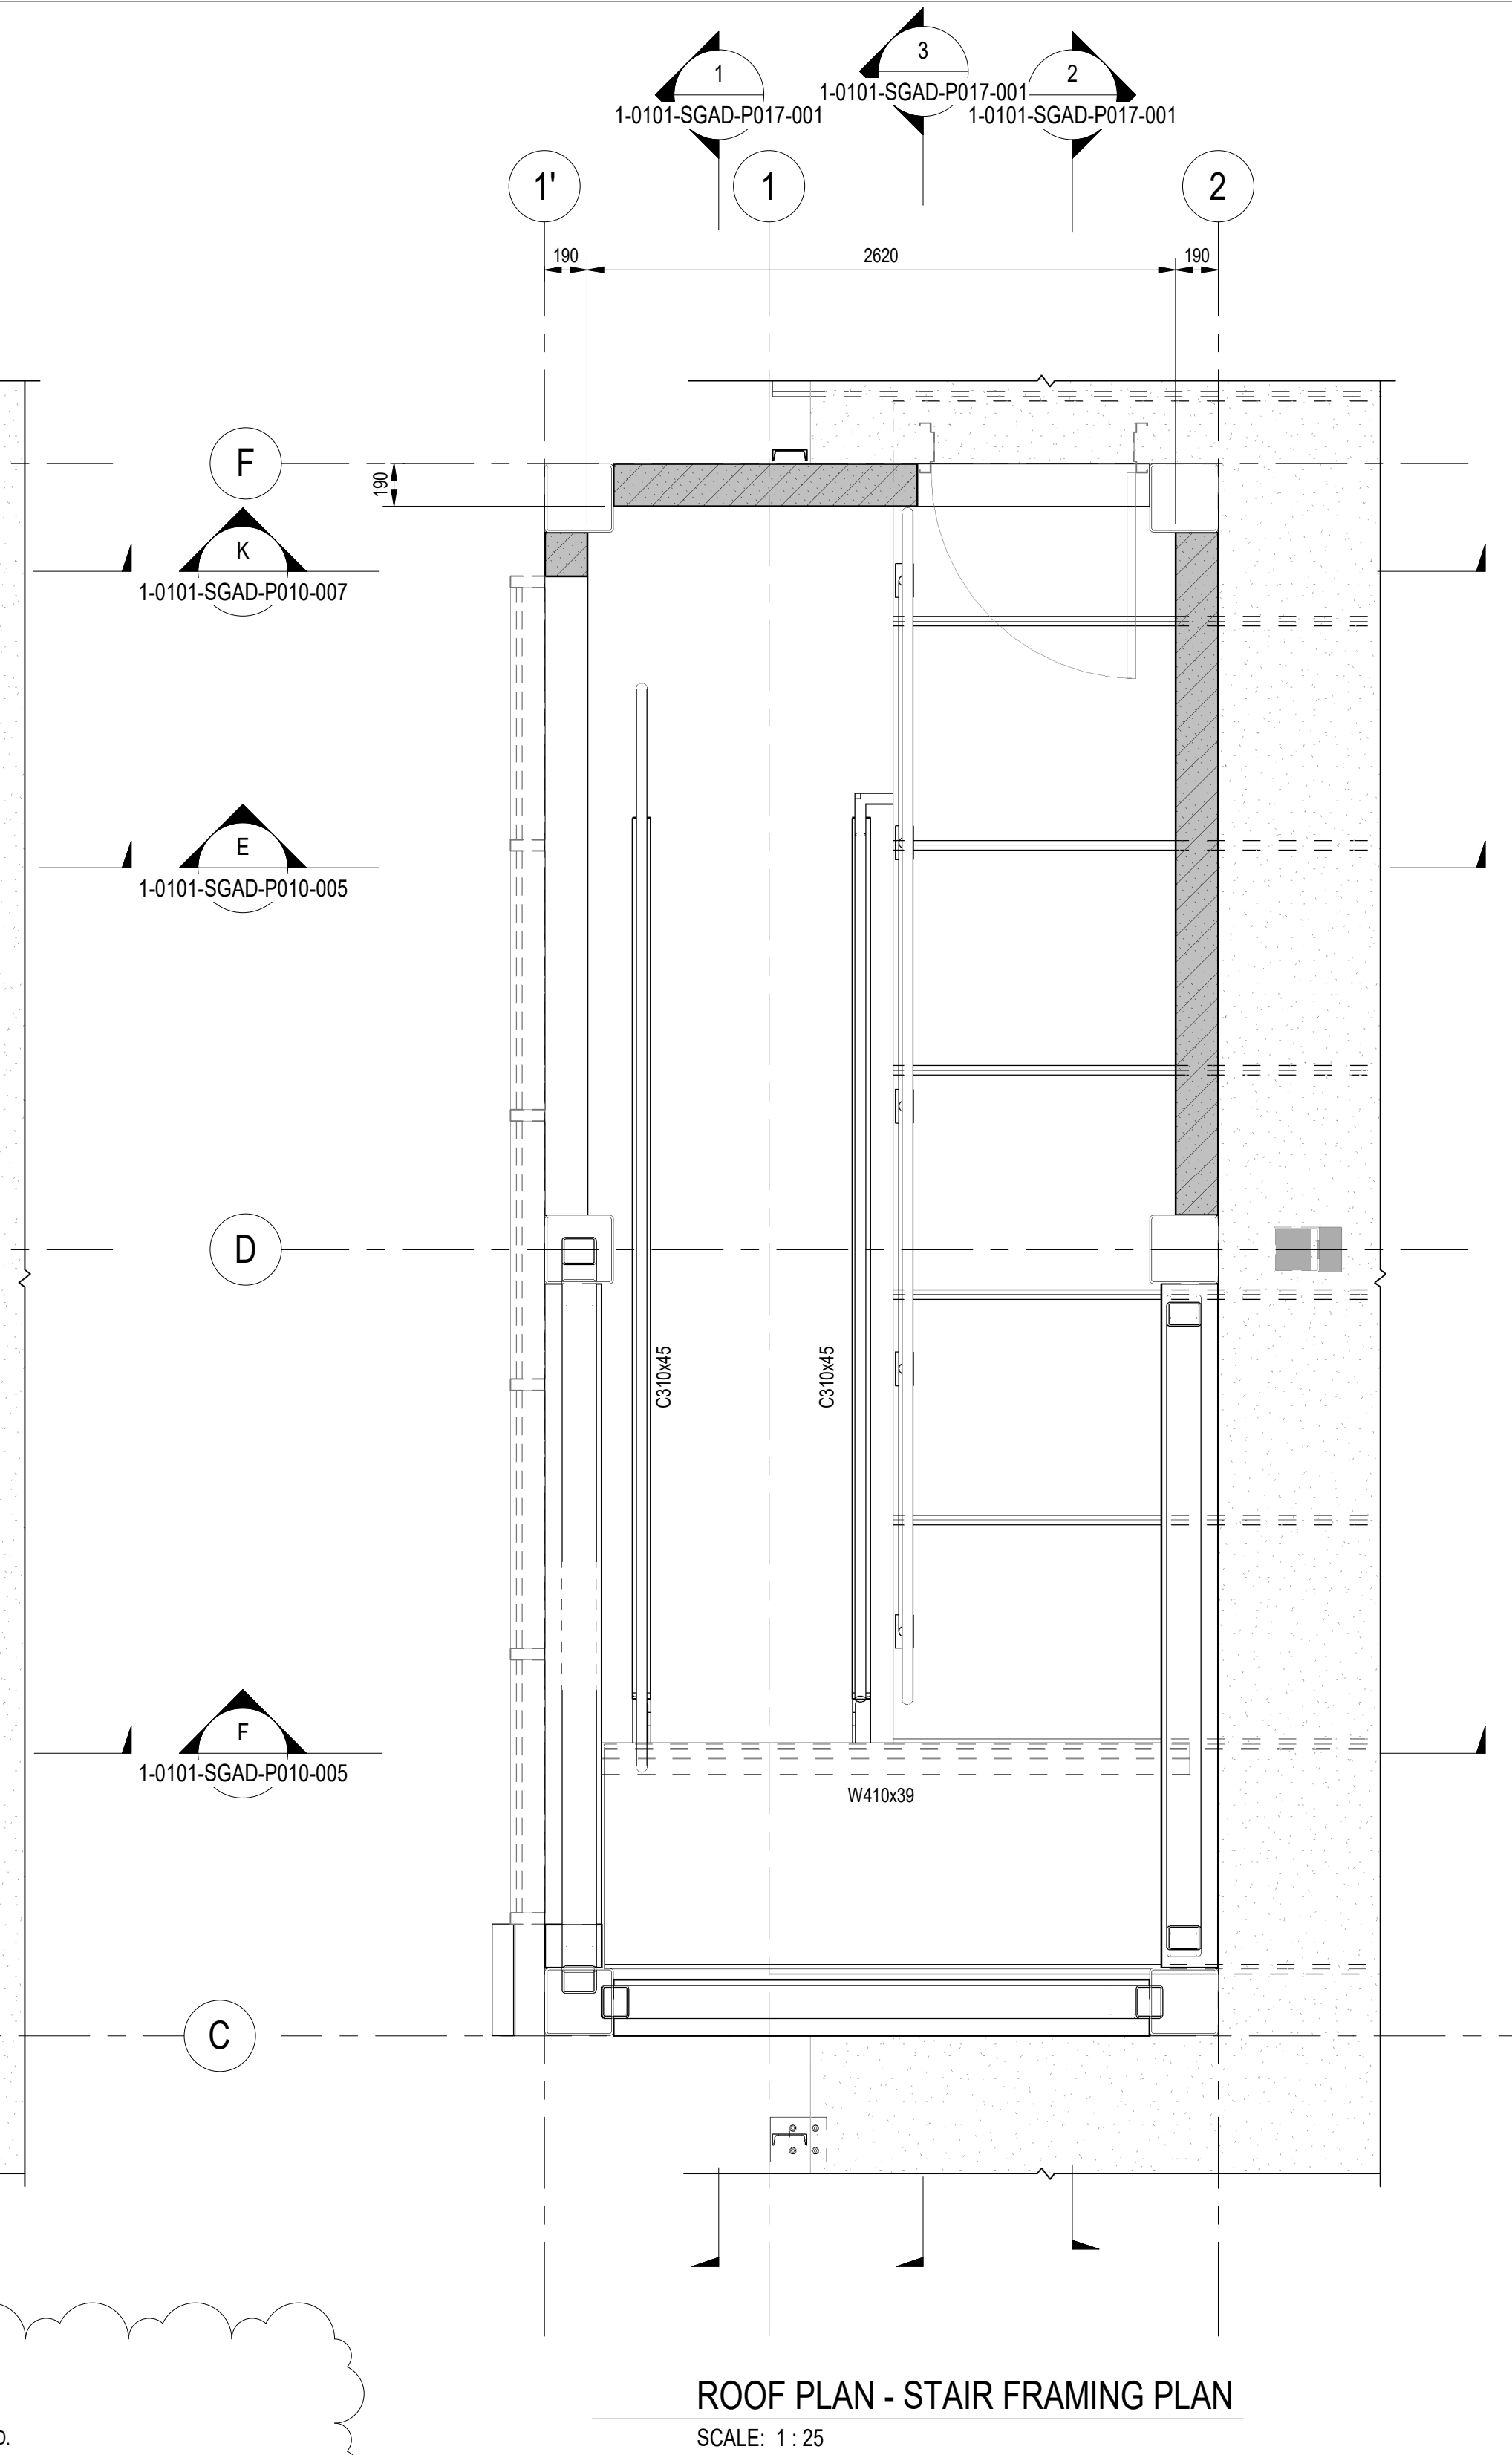
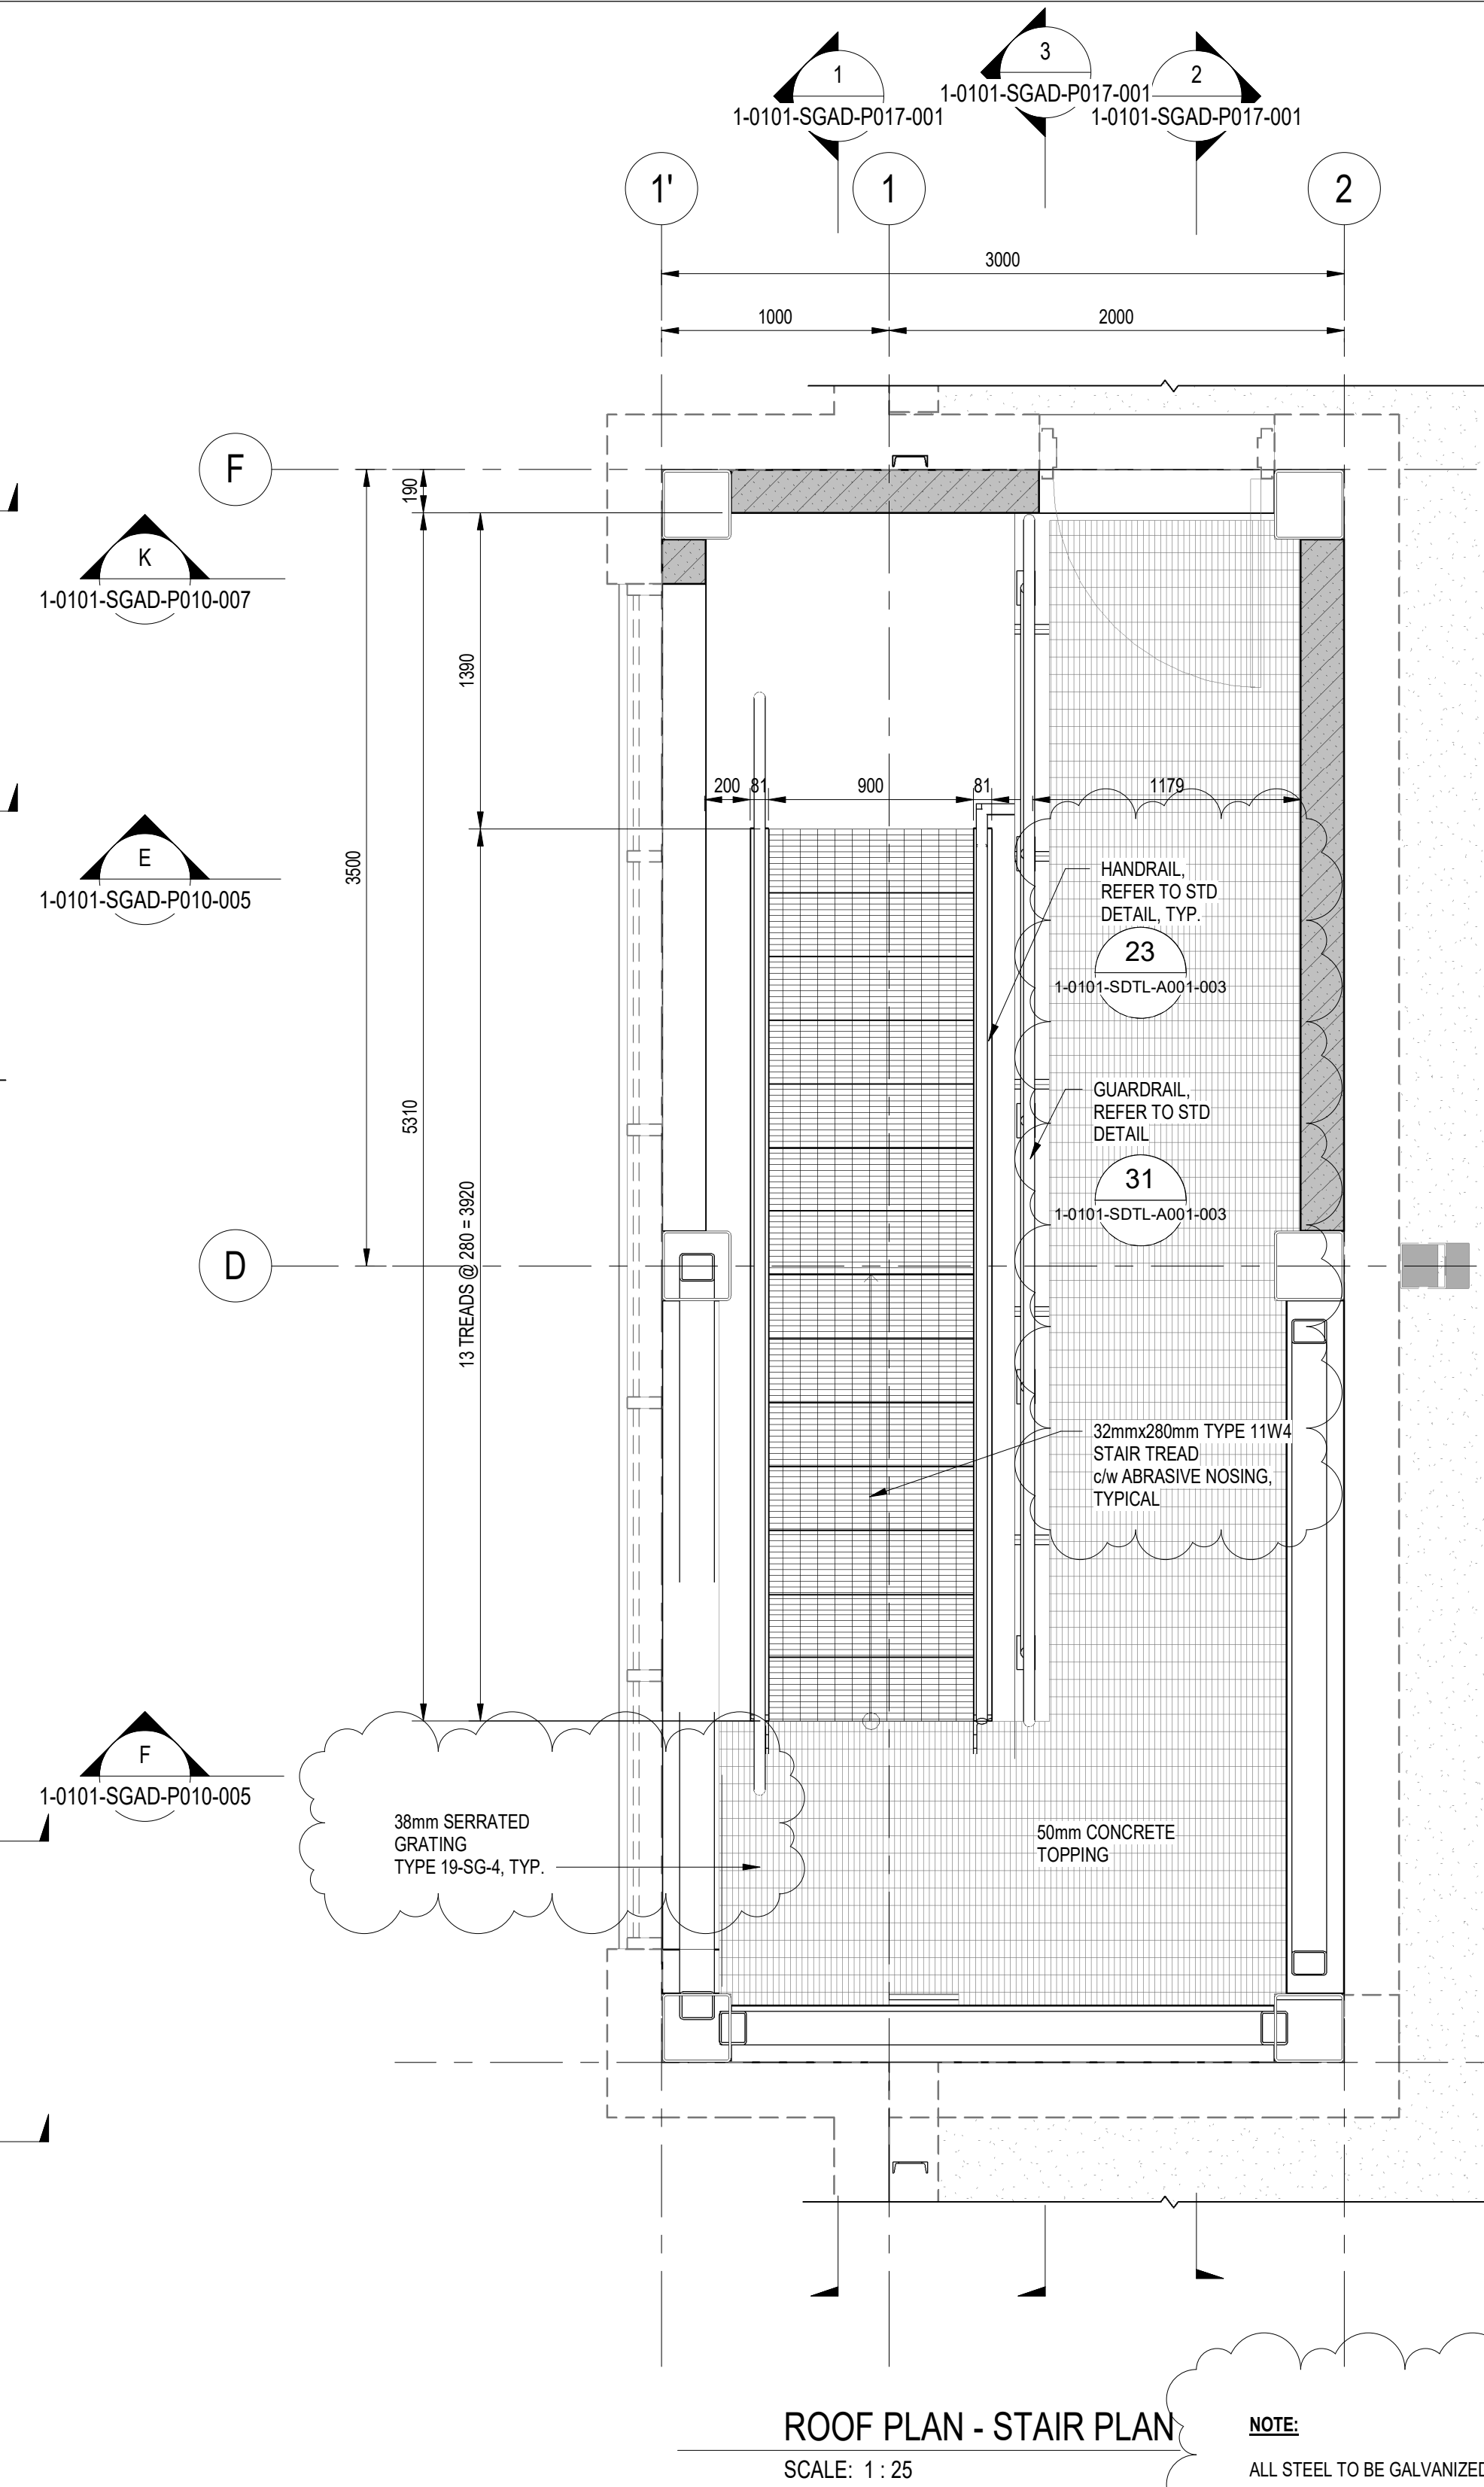
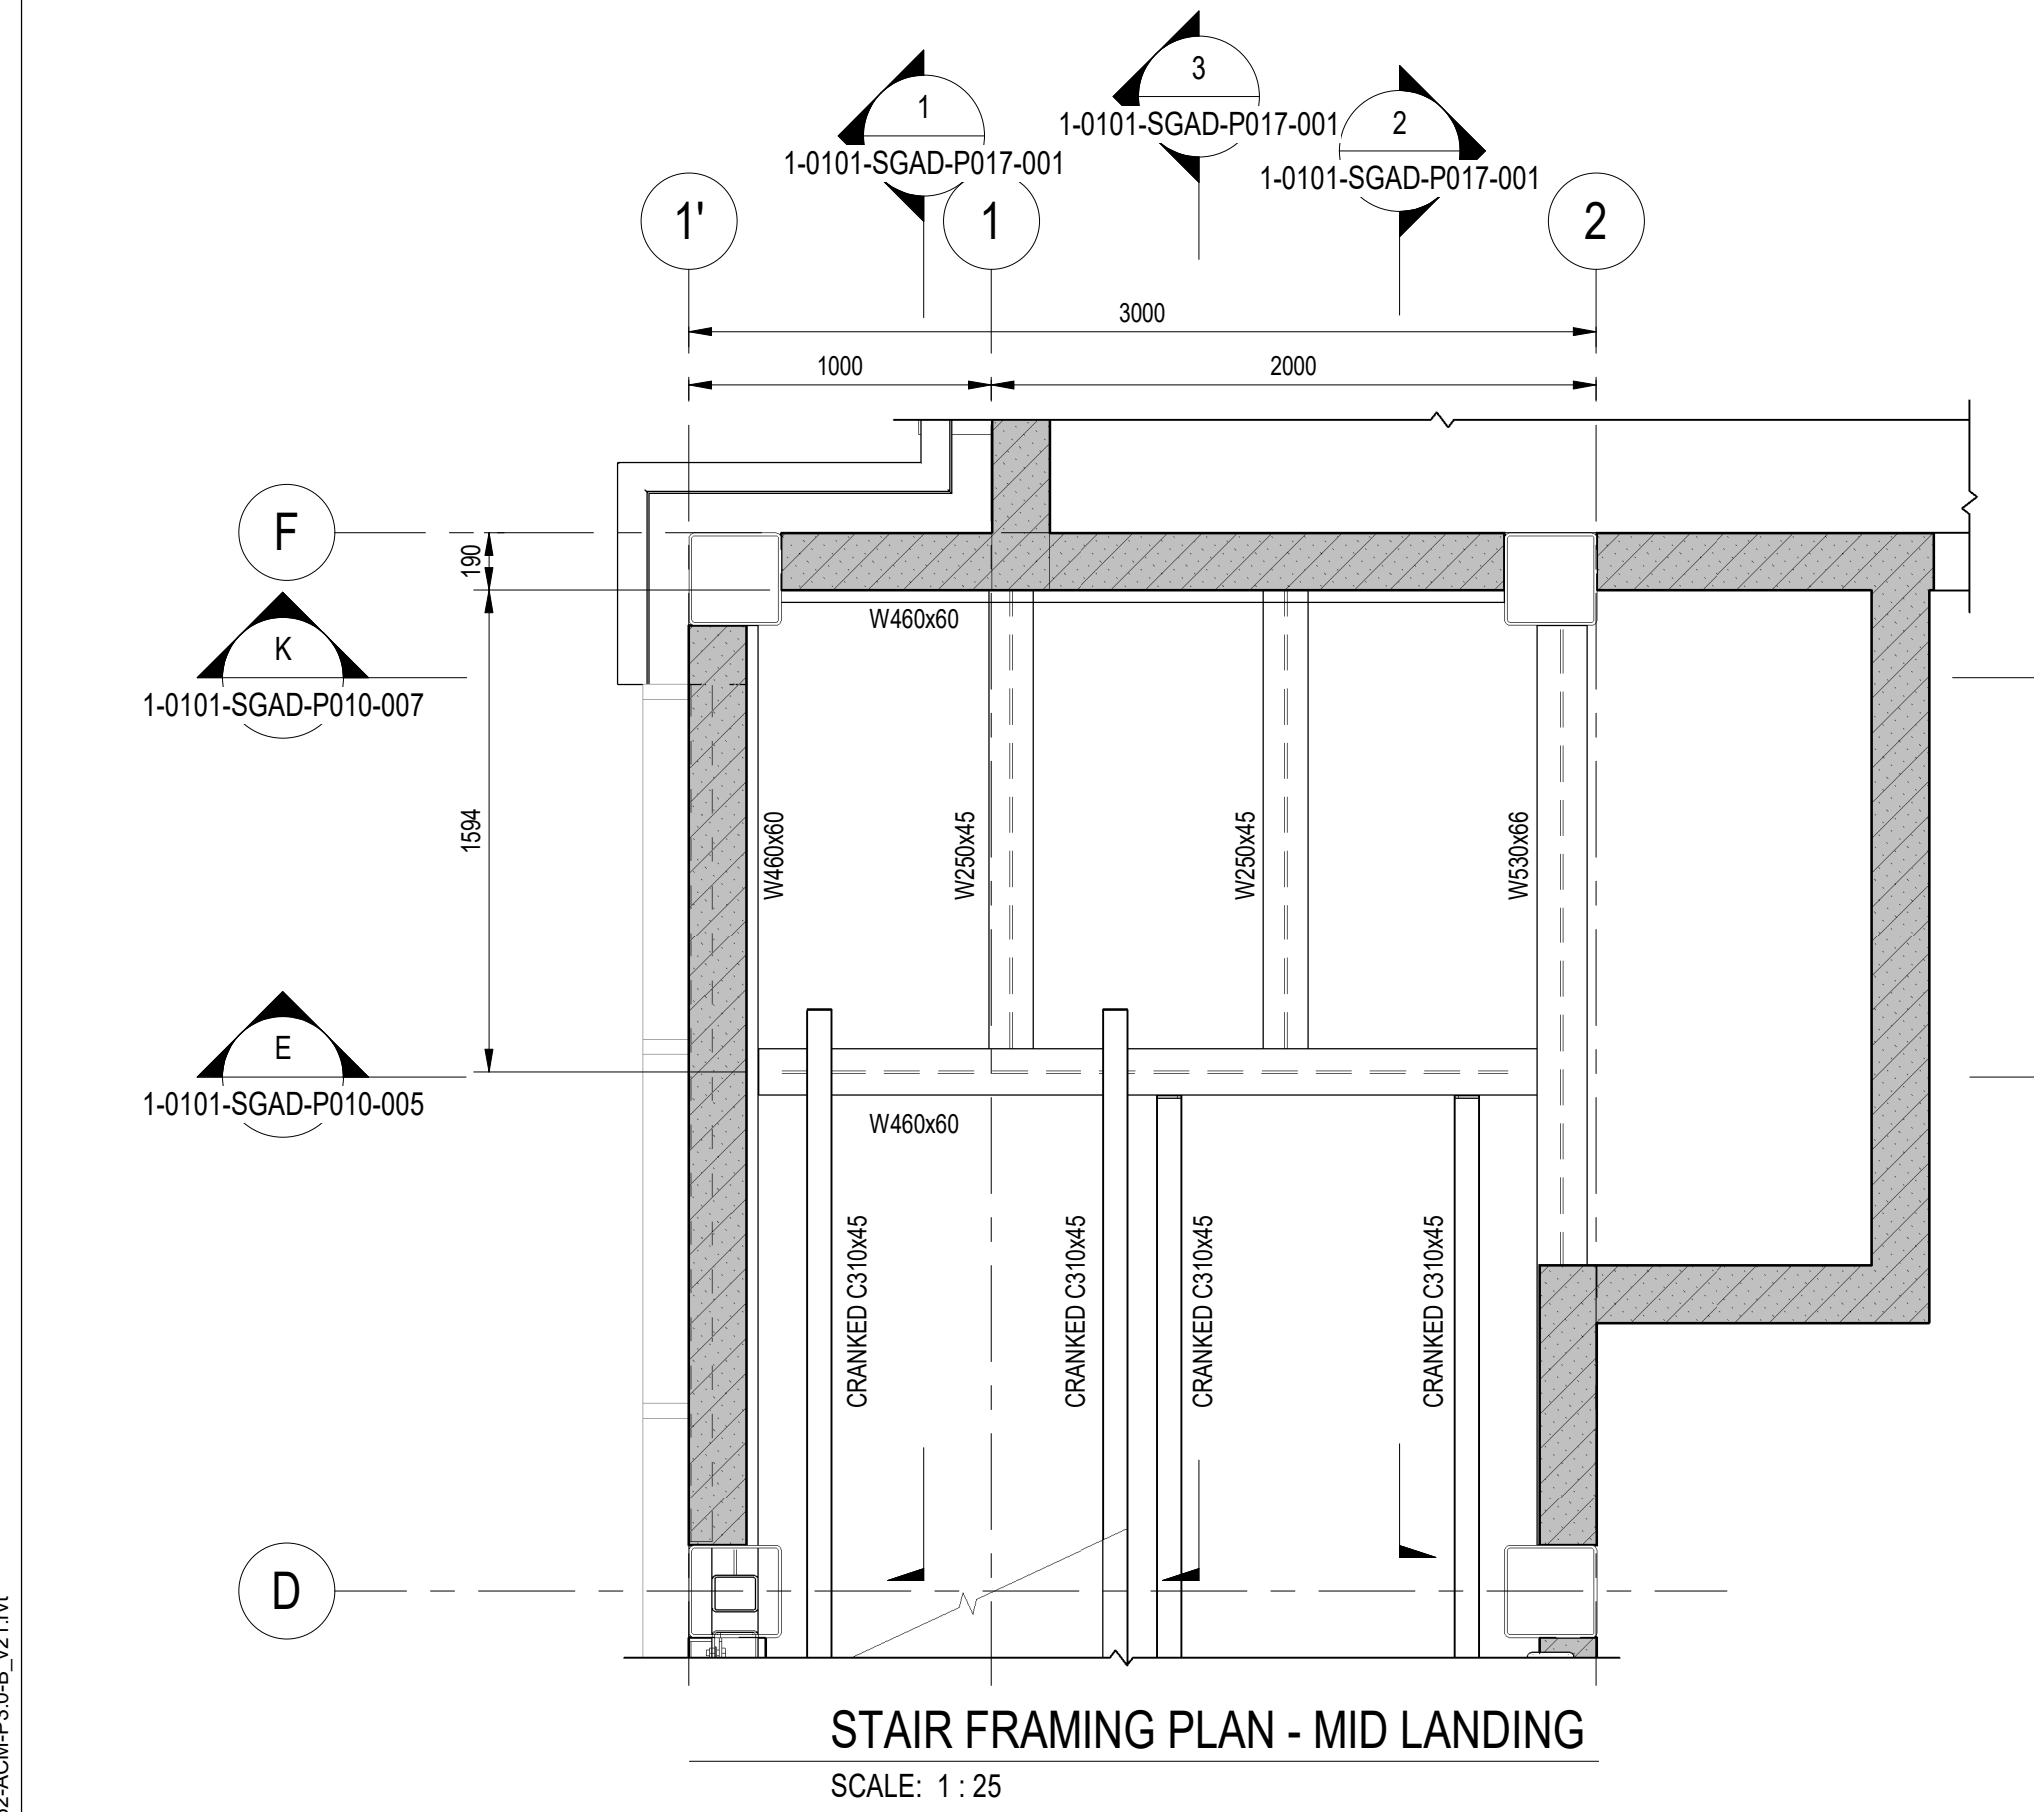


REFERENCE DRAWINGS STRUCTURAL	
DWG NO.	REFERENCE DRAWING TITLE
1-0101-BSCH-P001-001	SCHEDULES
1-0101-BSCH-P001-002	SCHEDULES
1-0101-SAAA-A002-001	GENERAL NOTES
1-0101-SDTL-A001-001	STANDARD DETAILS
1-0101-SDTL-A001-002	STANDARD DETAILS
1-0101-SDTL-A001-003	STANDARD DETAILS
1-0101-SDTL-A002-001	STANDARD BACKFILL DETAILS
1-0101-SFDW-P001-001	PILING PLAN
1-0101-SGAD-A020-001	STAIR 2 SECTION
1-0101-SGAD-A021-001	MONORAIL DETAILS
1-0101-SGAD-P001-001	LOWER LEVEL PLAN
1-0101-SGAD-P002-001	MAIN FLOOR FRAMING PLAN MAIN FLOOR CMU WALLS PLAN
1-0101-SGAD-P003-001	SECOND FLOOR FRAMING PLAN SECOND FLOOR CMU WALLS PLAN
1-0101-SGAD-P004-001	MECHANICAL PLATFORM FRAMING

REFERENCE DRAWINGS STRUCTURAL	
DWG NO.	REFERENCE DRAWING TITLE
1-0101-SGAD-P005-001	ROOF FRAMING PLAN PENTHOUSE FRAMING PLAN
1-0101-SGAD-P006-001	PENTHOUSE FRAMING PLAN
1-0101-SGAD-P007-001	FRAMING ELEVATIONS
1-0101-SGAD-P007-002	FRAMING ELEVATIONS
1-0101-SGAD-P007-003	FRAMING ELEVATIONS
1-0101-SGAD-P010-001	SECTIONS
1-0101-SGAD-P010-002	SECTION
1-0101-SGAD-P010-003	SECTION
1-0101-SGAD-P010-004	SECTIONS
1-0101-SGAD-P010-005	SECTIONS
1-0101-SGAD-P010-006	SECTIONS
1-0101-SGAD-P010-007	SECTIONS
1-0101-SGAD-P011-001	SECTIONS
1-0101-SGAD-P011-002	SECTIONS

REFERENCE DRAWINGS STRUCTURAL	
DWG NO.	REFERENCE DRAWING TITLE
1-0101-SGAD-P012-001	WALL SECTIONS
1-0101-SGAD-P014-001	DETAILS
1-0101-SGAD-P014-002	DETAILS
1-0101-SGAD-P014-003	DETAILS
1-0101-SGAD-P015-001	EMBED WEAR PLATES
1-0101-SGAD-P015-002	DETAILS
1-0101-SGAD-P016-001	STAIR 1 PLANS
1-0101-SGAD-P016-002	STAIR 1 PLANS
1-0101-SGAD-P016-003	STAIR 1 PLANS
1-0101-SGAD-P016-004	STAIR 1 PLANS
1-0101-SGAD-P017-001	STAIR 1 SECTIONS
1-0101-SGAD-P018-001	STAIR DETAILS
1-0101-SGAD-P019-001	STAIR 2 PLANS
1-0101-SSCH-A001-001	SCHEDULES

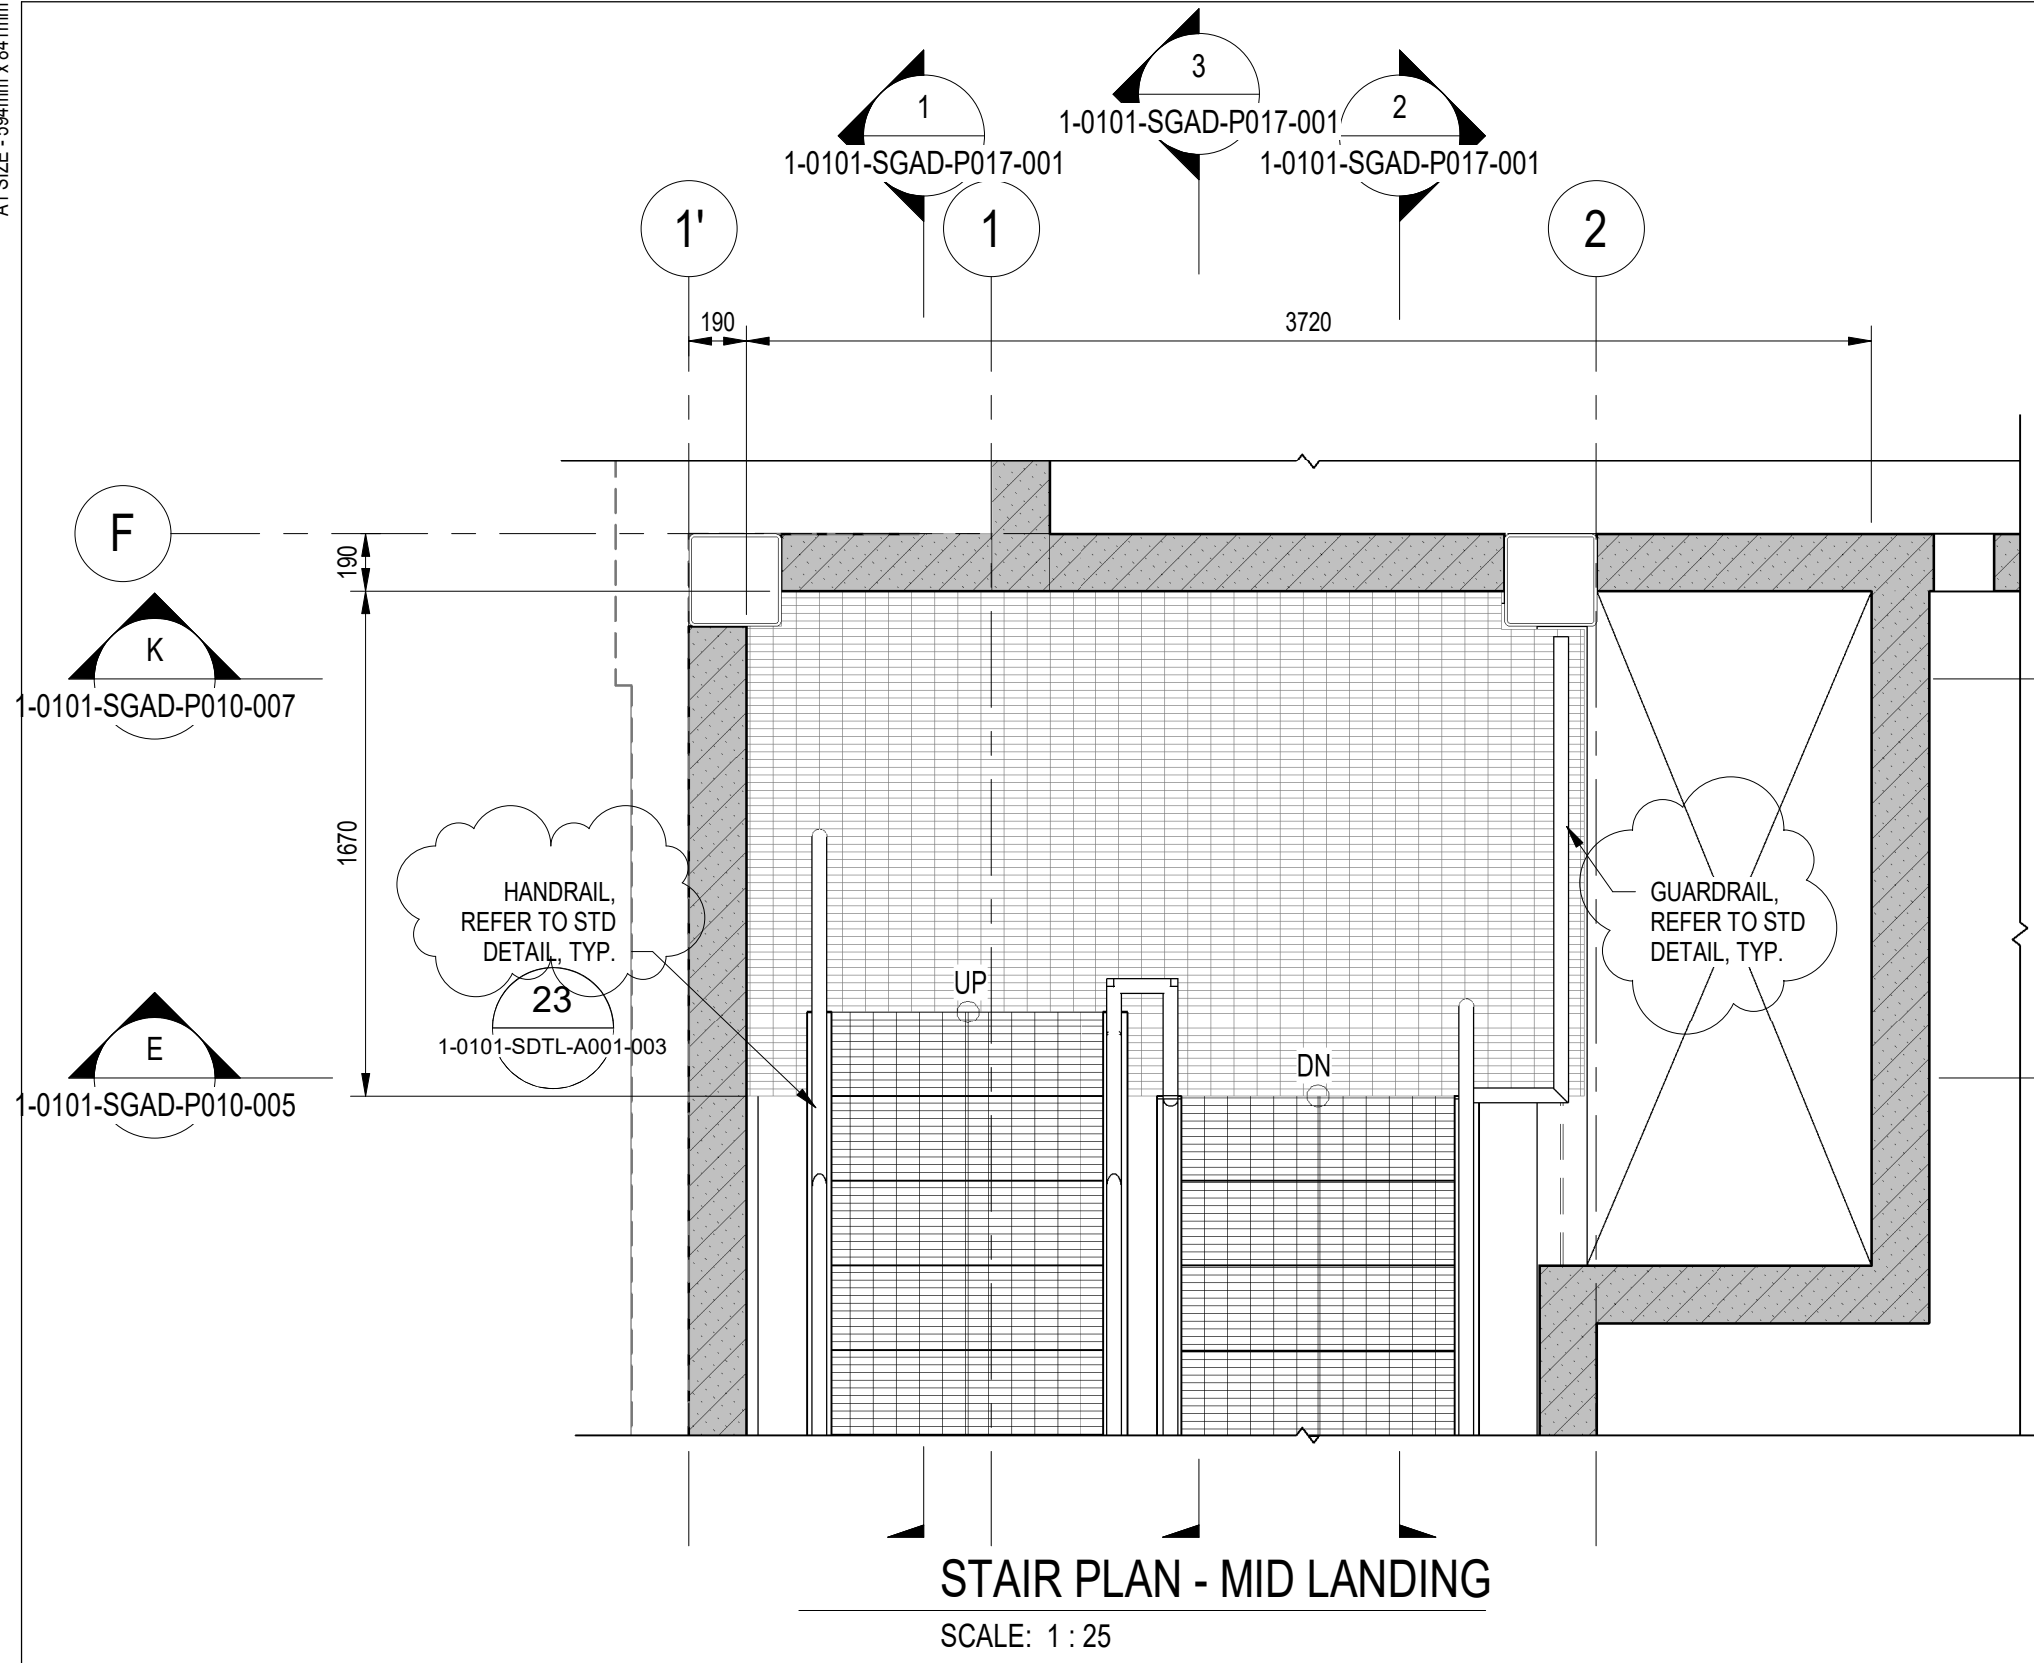

NOTE:
ALL STEEL TO BE GALVANIZED.

GRATING STAIR NOTES:
ALL STAIR FRAMING, STRINGERS, GRATING AND TREADS ARE GALVANIZED STEEL.

STAIRS LIVE LOAD = 4.8 kPa

**ENGINEERS
GEOSCIENTISTS
MANITOBA**
Certificate of Authorization
AECOM Canada Ltd.
No. 4671 Date: 2025-01-31

TENDER NO. 721-2024

AECOM				ENGINEER'S SEAL 		THE CITY OF WINNIPEG WATER AND WASTE DEPARTMENT NORTH END SEWAGE TREATMENT PLANT PRIMARY CLARIFICATION PROJECT STRUCTURAL STAIR 1 PLANS			
DESIGNED BY: CT	CHECKED BY: MB	DRAWN BY: BF	APPROVED BY: NW	SCALE: As indicated	RELEASED FOR CONSTRUCTION BY:	CITY DRAWING NUMBER	SHEET	REV.	SIZE
DATE: 2020-12-09	DATE:	CONSULTANT NO.: P3-S407				1-0101-SGAD-P016	004	01	A1
01 ISSUED FOR ADDENDUM 11	2025-04-04	CT	MB						
00 ISSUED FOR TENDER	2025-01-31	CT	MB						
NO. REVISIONS	DATE	DESIGN	CHECK						