




LAST SAVE: 2025-03-17 8:34:02 AM
PATH: \\B:\360\City of Winnipeg - NEWPCC Upgrades 2021\60861262-ACM-IP3-D-B_V21.rvt
A1 SIZE: 594mm x 841mm

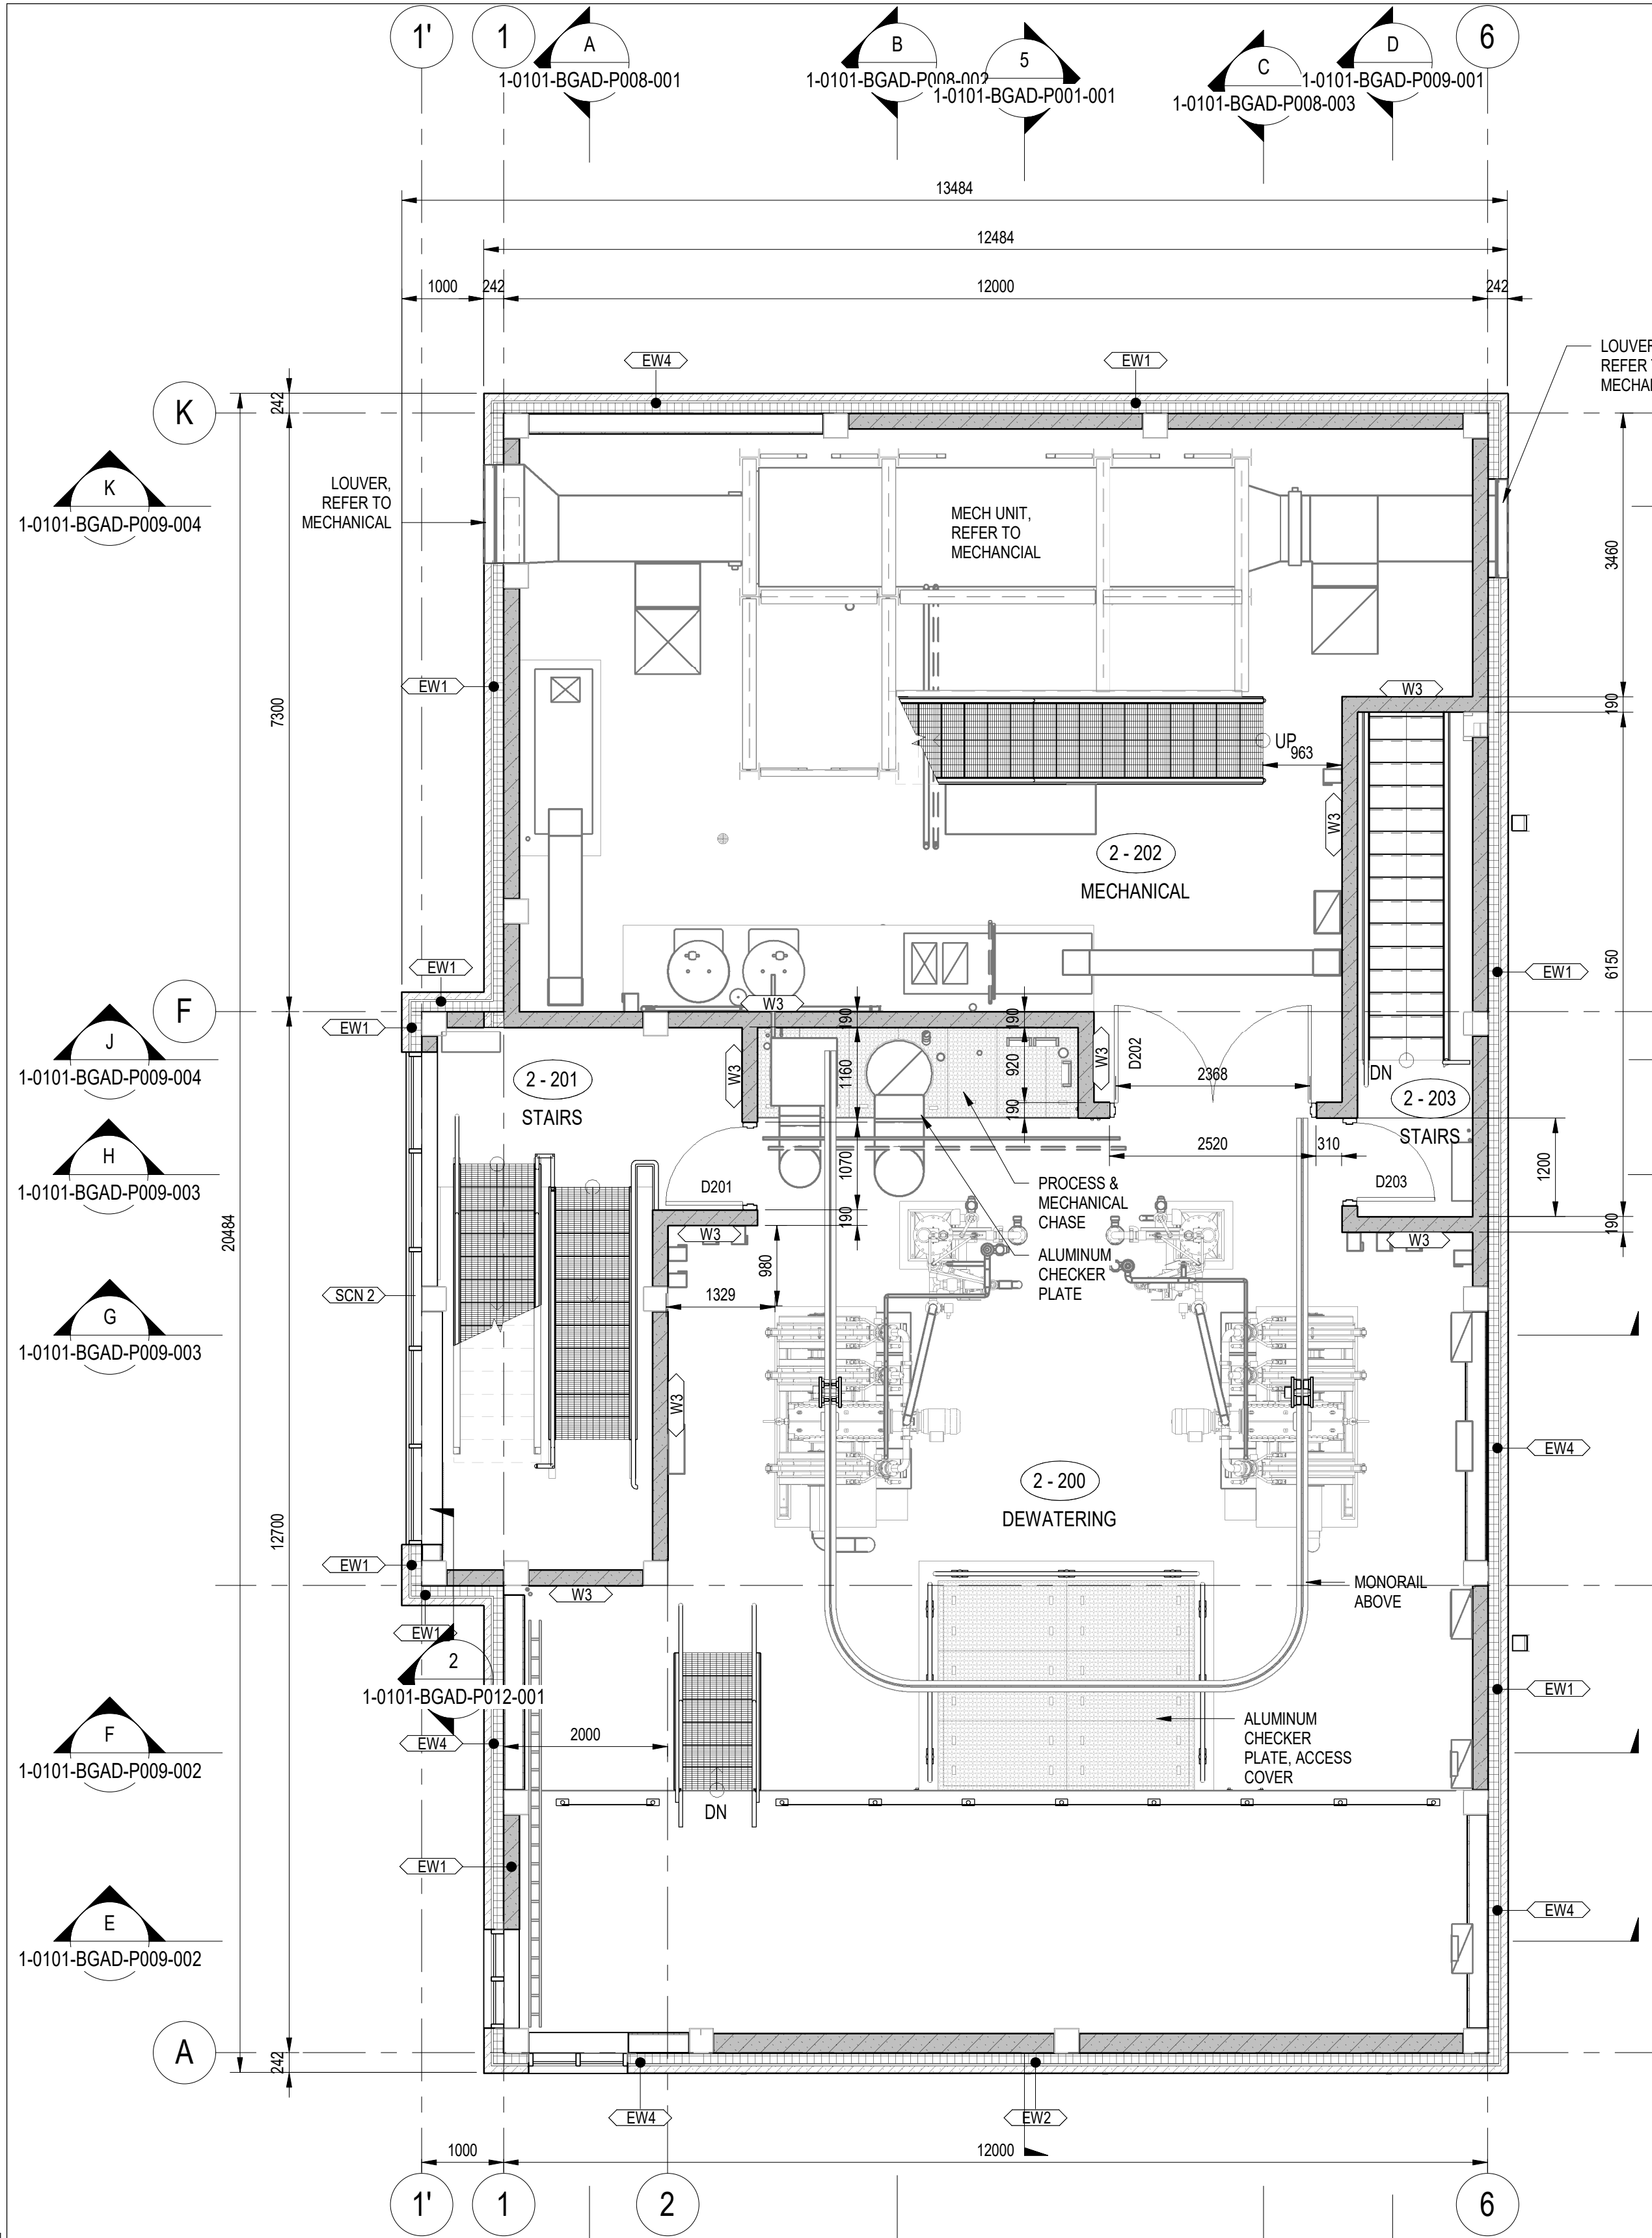

SECOND FLOOR PLAN
SCALE: 1 : 60

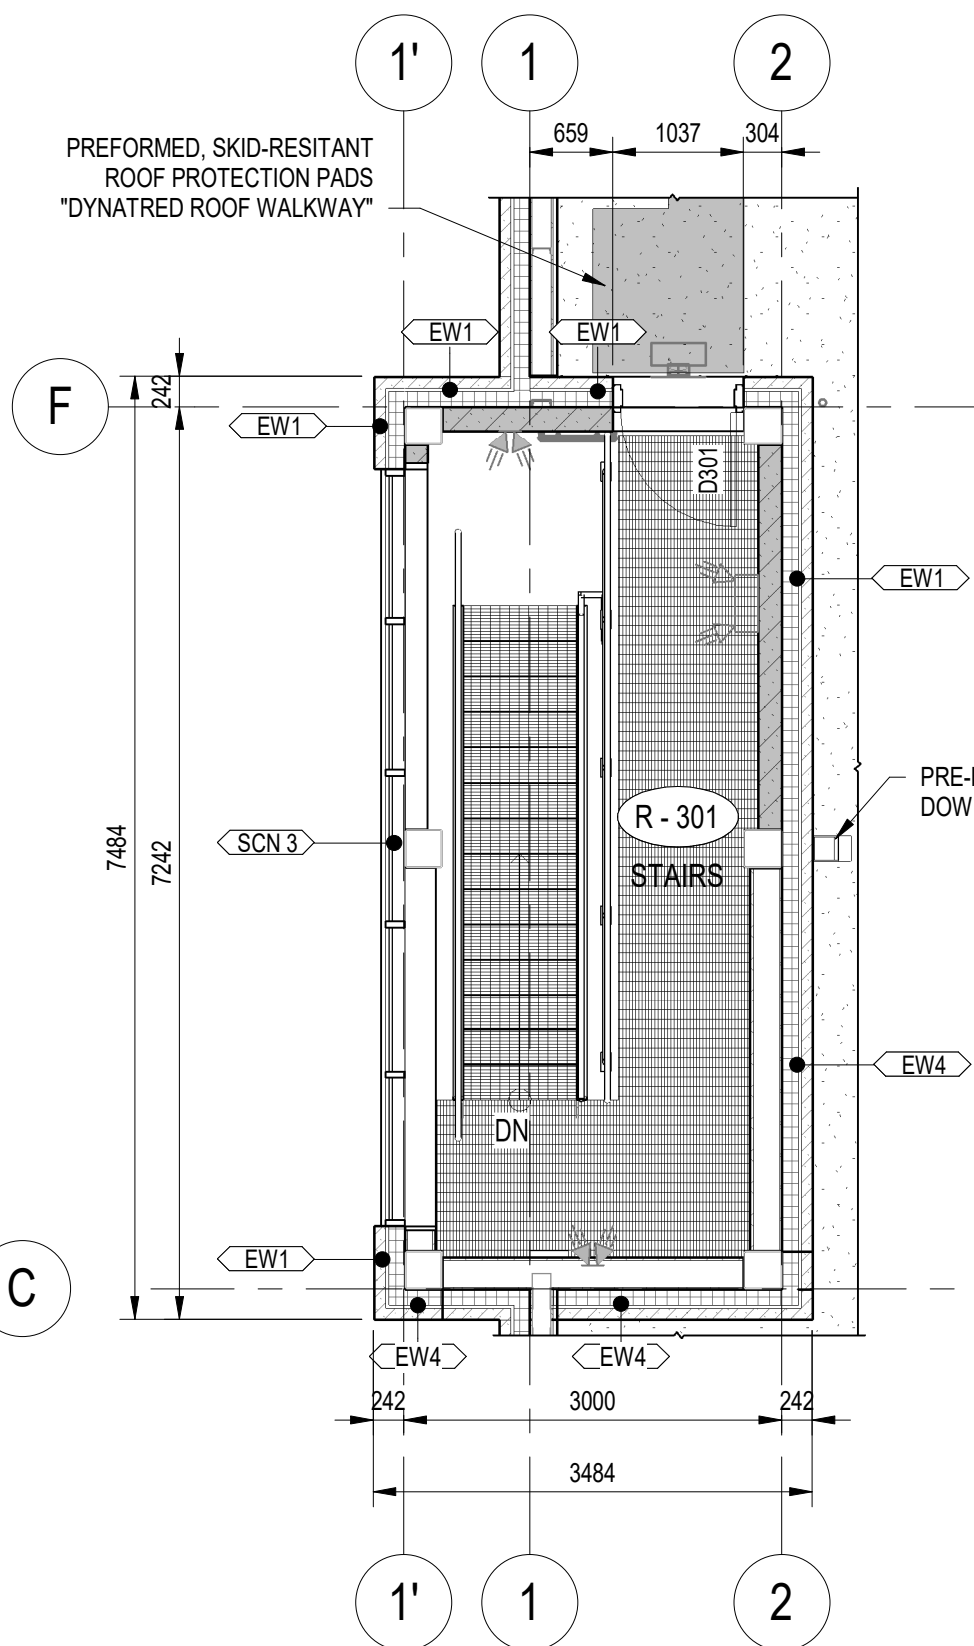

ROOF LEVEL PLAN
SCALE: 1 : 60

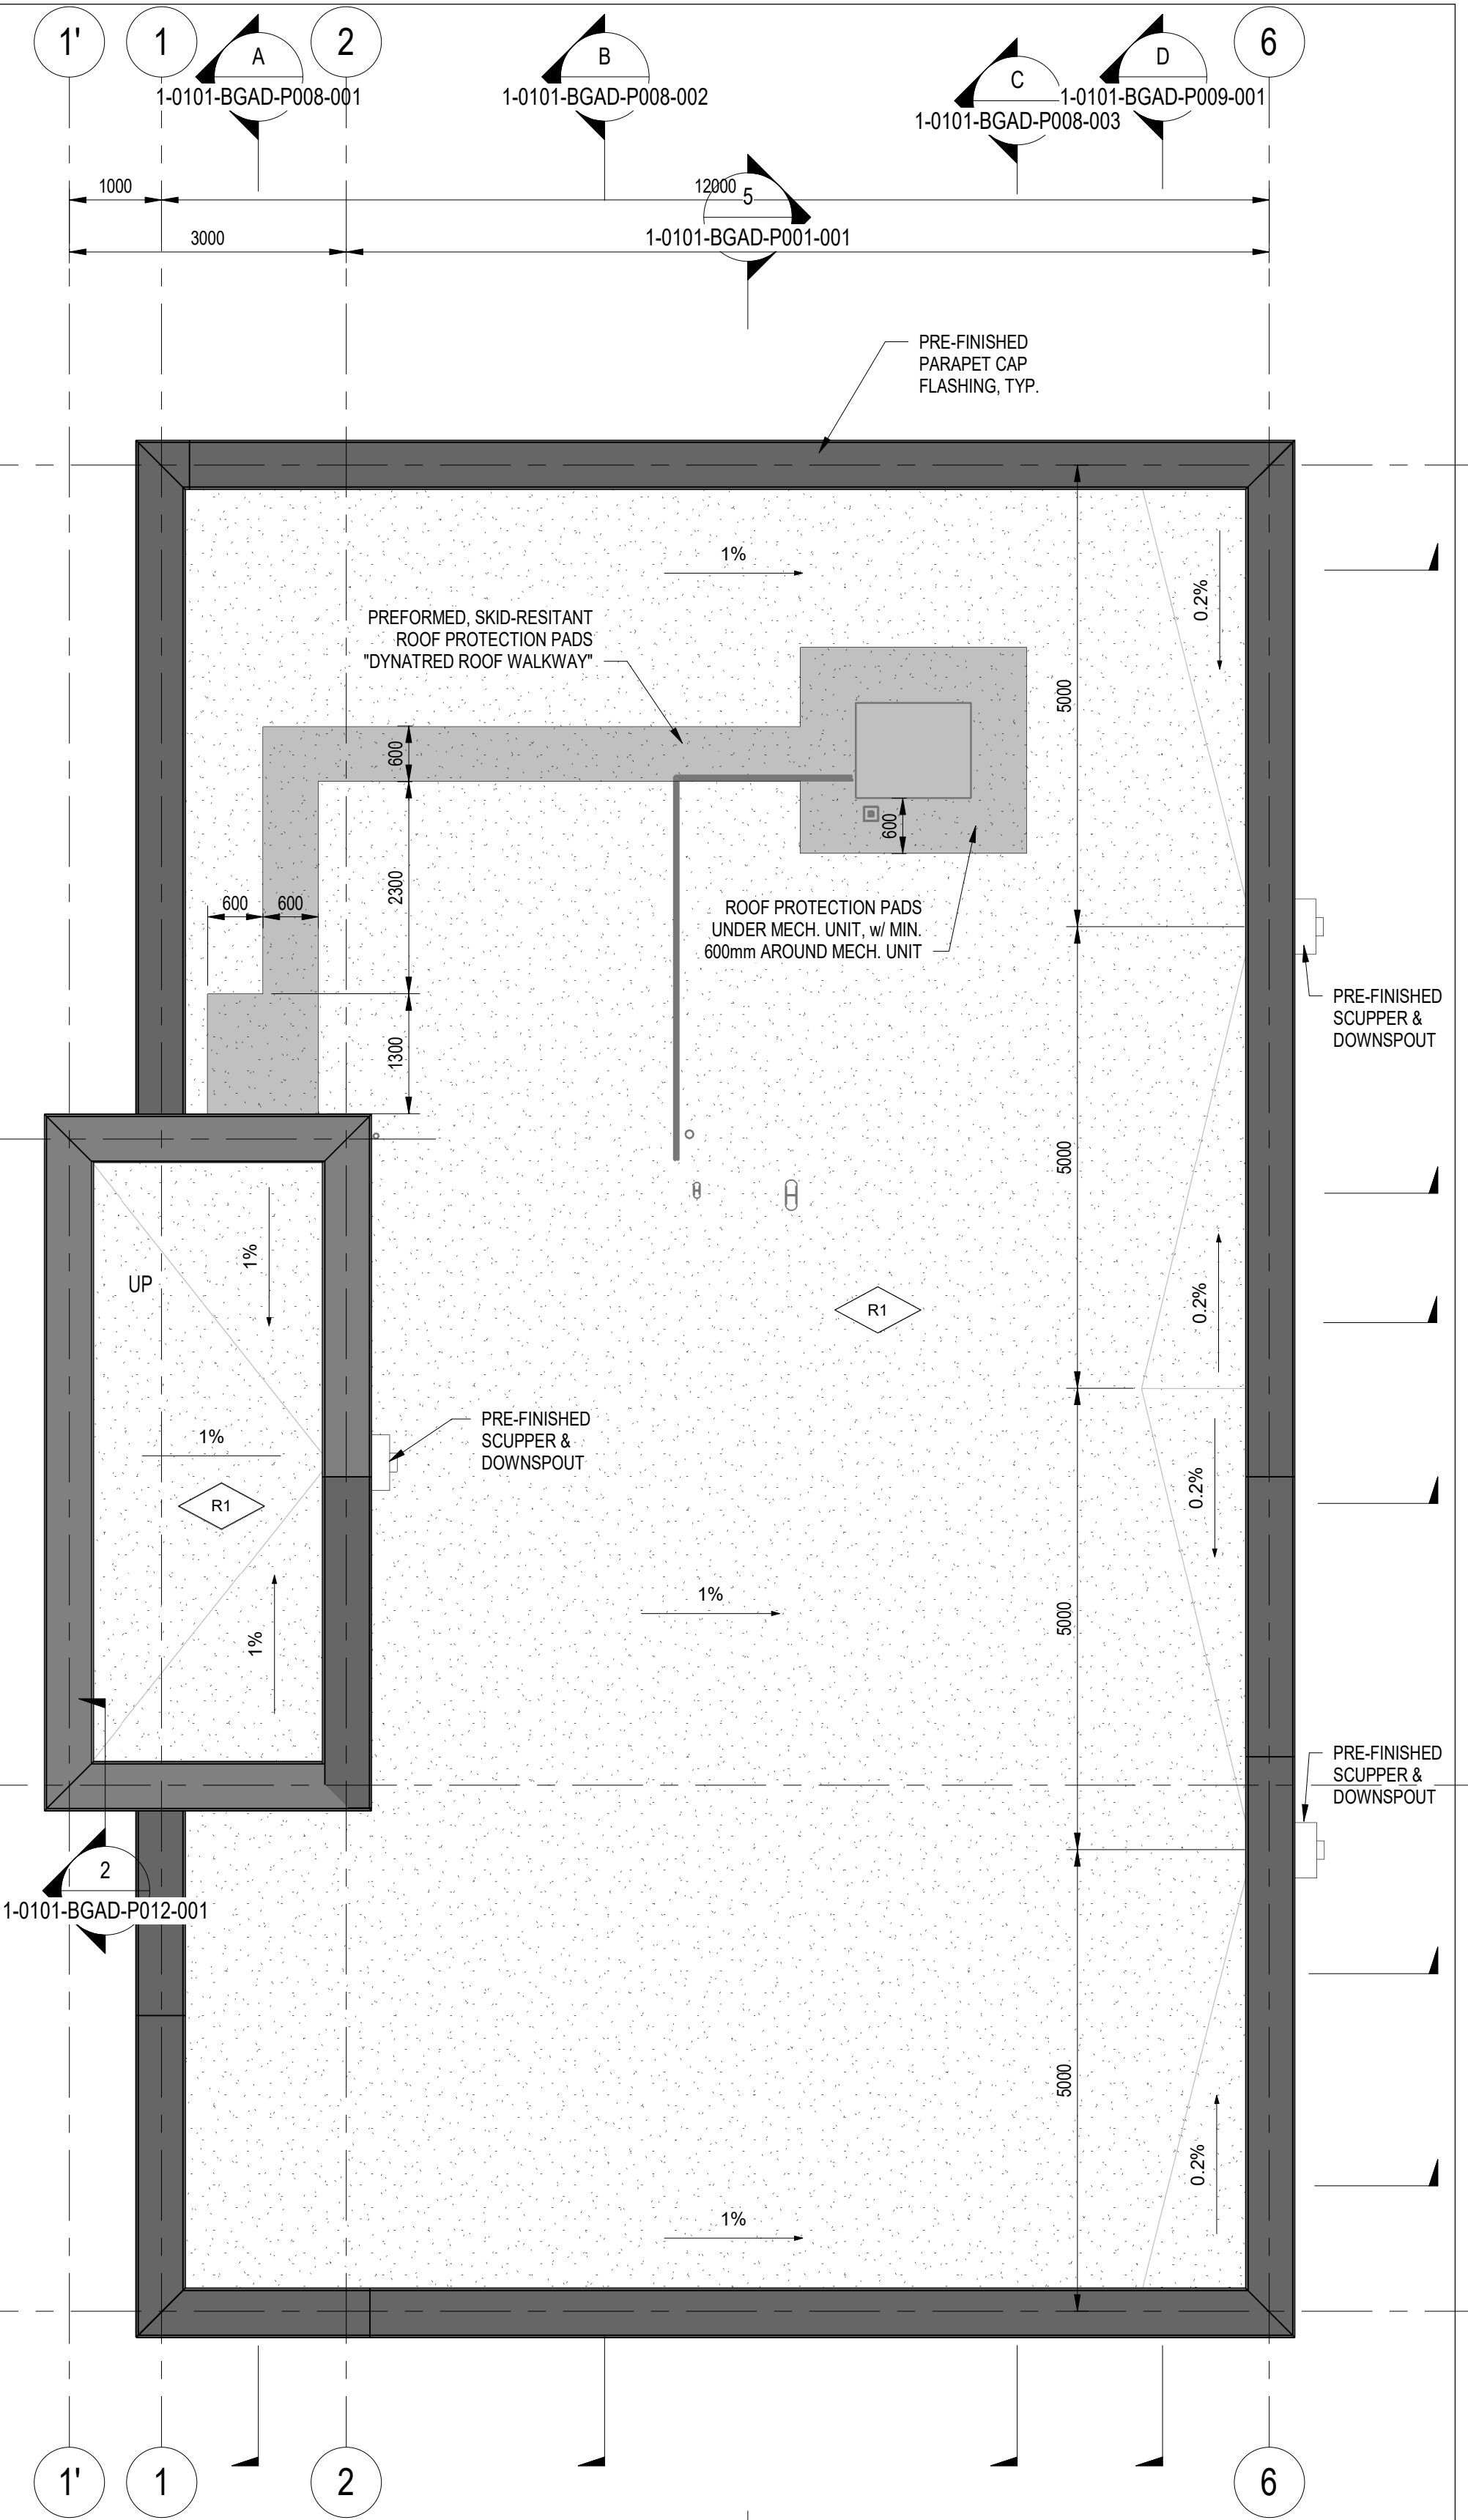

ROOF PLAN
SCALE: 1 : 60

REFERENCE DRAWINGS ARCHITECTURAL	
DWG NO.	REFERENCE DRAWING TITLE
1-0101-BAAA-A001-001	GENERAL NOTES
1-0101-BDTL-A001-001	STANDARD DETAILS
1-0101-BDTL-A001-002	STANDARD DETAILS
1-0101-BGAD-P001-001	LIFE SAFETY PLAN
1-0101-BGAD-P002-001	BASEMENT PLAN MAIN FLOOR PLAN
1-0101-BGAD-P003-001	SECOND FLOOR PLAN ROOF PLAN
1-0101-BGAD-P004-001	BASEMENT REFLECTED CEILING PLAN
1-0101-BGAD-P005-001	MAIN FLOOR REFLECTED CEILING PLAN SECOND FLOOR REFLECTED CEILING PLAN
1-0101-BGAD-P006-001	EXTERIOR ELEVATIONS
1-0101-BGAD-P008-001	SECTION
1-0101-BGAD-P008-002	SECTION
1-0101-BGAD-P008-003	SECTION

REFERENCE DRAWINGS ARCHITECTURAL	
DWG NO.	REFERENCE DRAWING TITLE
1-0101-BGAD-P009-001	SECTIONS
1-0101-BGAD-P009-002	SECTIONS
1-0101-BGAD-P009-003	SECTIONS
1-0101-BGAD-P009-004	SECTIONS
1-0101-BGAD-P010-001	SECTIONS
1-0101-BGAD-P012-001	WALL SECTIONS
1-0101-BGAD-P012-002	WALL SECTIONS
1-0101-BGAD-P012-003	WALL SECTIONS
1-0101-BGAD-P015-001	DETAILS
1-0101-BGAD-P016-001	FIRESTOP DETAILS
1-0101-BSCH-P001-001	SCHEDULES
1-0101-BSCH-P001-002	SCHEDULES

01	ISSUED FOR ADDENDUM 7	2025-03-17	CT	MB
00	ISSUED FOR TENDER	2025-01-31	CT	MB
NO.	REVISIONS	DATE	DESIGN	CHECK

AECOM	
DESIGNED BY: AC	CHECKED BY: KS
DRAWN BY: AC	APPROVED BY: NW
SCALE: 1 : 60	RELEASED FOR CONSTRUCTION BY:
DATE: 2020-12-09	DATE:
CONSULTANT NO.: P3-B102	

ENGINEER'S SEAL

TENDER NO. 721-2024		
 THE CITY OF WINNIPEG WATER AND WASTE DEPARTMENT		
NORTH END SEWAGE TREATMENT PLANT PRIMARY CLARIFICATION PROJECT ARCHITECTURAL SECOND FLOOR PLAN ROOF PLAN		
CITY DRAWING NUMBER 1-0101-BGAD-P003	SHEET 001	REV. 01 SIZE A1