


LAST SAVE: 2025-03-17 8:34:04 AM  
PATH: \\B:\360\City of Winnipeg - NEWPCC Upgrades 2022\60861262-ACM-P3-D-B\_V21.rvt  
A1 SIZE - 594mm x 841mm

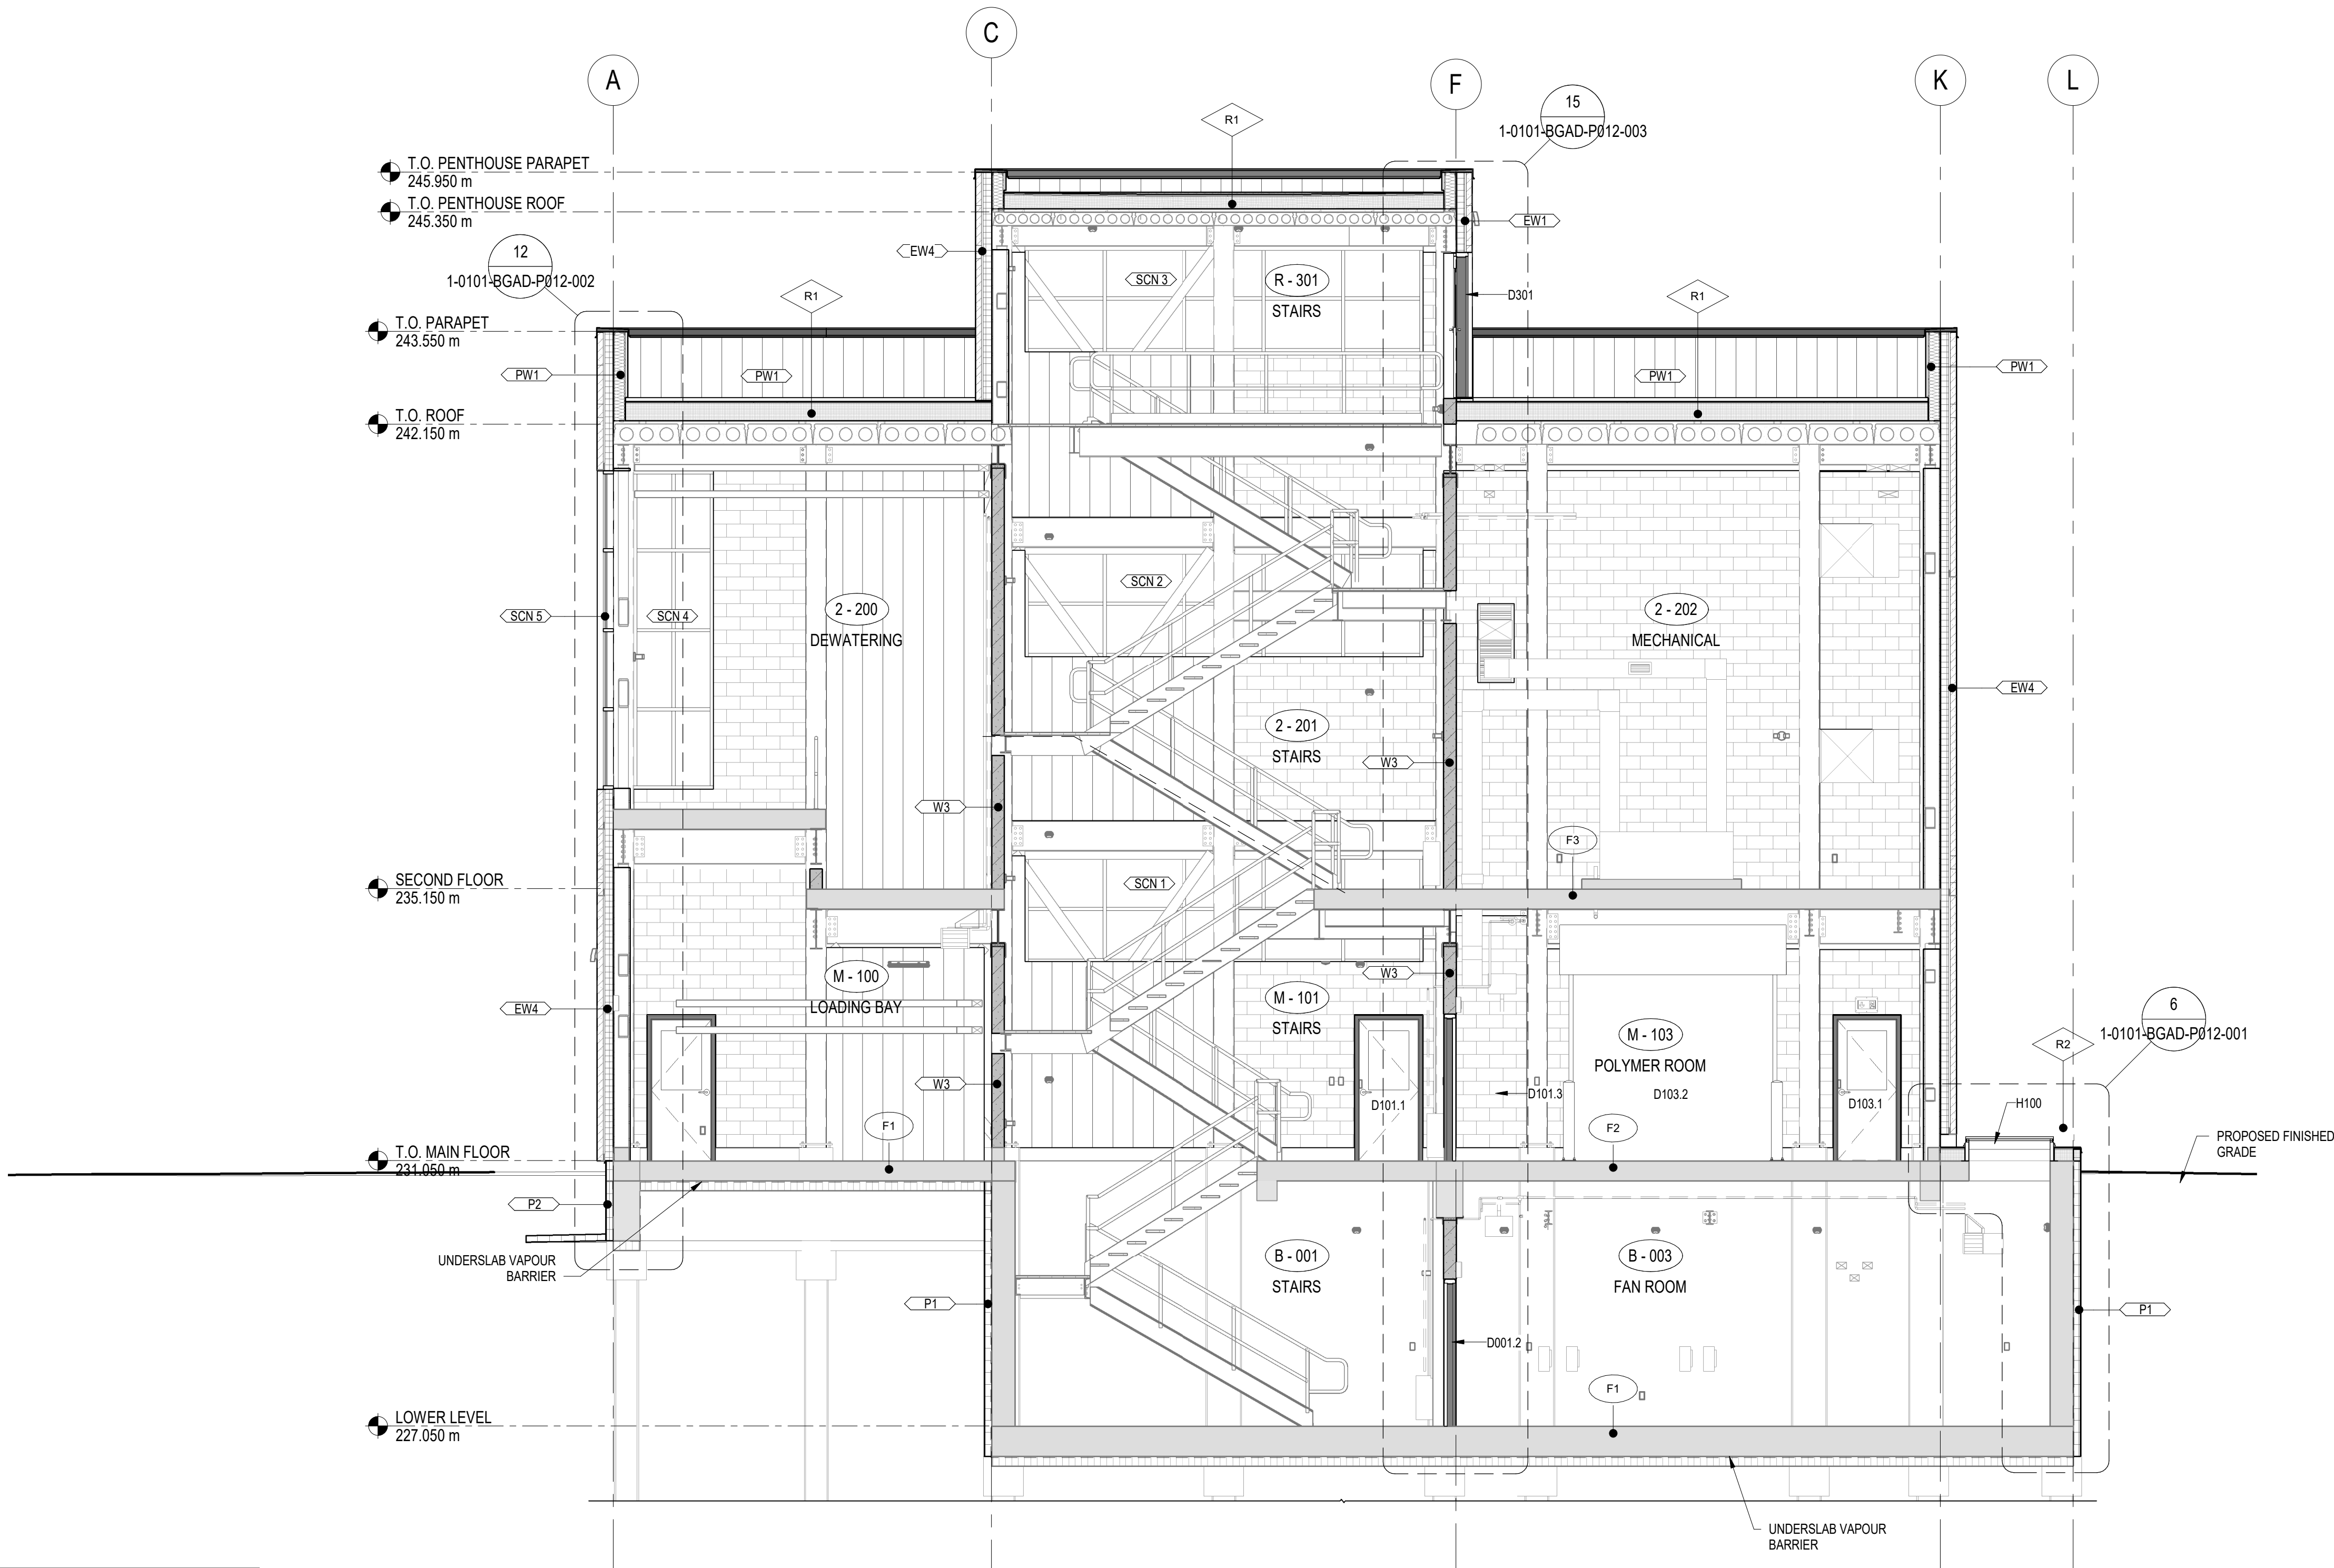

A | SECTION

1-0101-BGAD-P002-001 SCALE: 1 : 60

NOTES:  
- REFER TO STRUCTURAL FOR STAIR, RAILING AND GUARDRAIL DETAILS

| REFERENCE DRAWINGS ARCHITECTURAL |                                                                       |
|----------------------------------|-----------------------------------------------------------------------|
| DWG NO.                          | REFERENCE DRAWING TITLE                                               |
| 1-0101-BAAA-A001-001             | GENERAL NOTES                                                         |
| 1-0101-BDTL-A001-001             | STANDARD DETAILS                                                      |
| 1-0101-BDTL-A001-002             | STANDARD DETAILS                                                      |
| 1-0101-BGAD-P001-001             | LIFE SAFETY PLAN                                                      |
| 1-0101-BGAD-P002-001             | BASEMENT PLAN MAIN FLOOR PLAN                                         |
| 1-0101-BGAD-P003-001             | SECOND FLOOR PLAN ROOF PLAN                                           |
| 1-0101-BGAD-P004-001             | BASEMENT REFLECTED CEILING PLAN                                       |
| 1-0101-BGAD-P005-001             | MAIN FLOOR REFLECTED CEILING PLAN SECOND FLOOR REFLECTED CEILING PLAN |
| 1-0101-BGAD-P006-001             | EXTERIOR ELEVATIONS                                                   |
| 1-0101-BGAD-P008-001             | SECTION                                                               |
| 1-0101-BGAD-P008-002             | SECTION                                                               |
| 1-0101-BGAD-P008-003             | SECTION                                                               |
| 1-0101-BGAD-P009-001             | SECTIONS                                                              |
| 1-0101-BGAD-P009-002             | SECTIONS                                                              |
| 1-0101-BGAD-P009-003             | SECTIONS                                                              |
| 1-0101-BGAD-P009-004             | SECTIONS                                                              |
| 1-0101-BGAD-P010-001             | SECTIONS                                                              |
| 1-0101-BGAD-P012-001             | WALL SECTIONS                                                         |
| 1-0101-BGAD-P012-002             | WALL SECTIONS                                                         |
| 1-0101-BGAD-P012-003             | WALL SECTIONS                                                         |
| 1-0101-BGAD-P015-001             | DETAILS                                                               |
| 1-0101-BGAD-P016-001             | FIRESTOP DETAILS                                                      |
| 1-0101-BSCH-P001-001             | SCHEDULES                                                             |
| 1-0101-BSCH-P001-002             | SCHEDULES                                                             |

|  |  |  |  |                         |                                                |
|--|--|--|--|-------------------------|------------------------------------------------|
|  |  |  |  | <b>AECOM</b>            |                                                |
|  |  |  |  | DESIGNED BY: AC         | CHECKED BY: KS                                 |
|  |  |  |  | DRAWN BY: AC            | APPROVED BY: NW                                |
|  |  |  |  | SCALE: 1 : 60           | RELEASED FOR CONSTRUCTION BY: DATE: 2020-12-09 |
|  |  |  |  | DATE: 2025-03-17        | DATE: 2025-01-31                               |
|  |  |  |  | CT                      | MB                                             |
|  |  |  |  | CT                      | MB                                             |
|  |  |  |  | CONSULTANT NO.: P3-B300 |                                                |
|  |  |  |  | NO. REVISIONS           | DATE DESIGN CHECK                              |

|                                                                                               |                     |                                                           |                   |
|-----------------------------------------------------------------------------------------------|---------------------|-----------------------------------------------------------|-------------------|
| ENGINEER'S SEAL                                                                               |                     | TENDER NO. 721-2024                                       |                   |
|          |                     | <b>THE CITY OF WINNIPEG</b><br>WATER AND WASTE DEPARTMENT |                   |
| NORTH END SEWAGE TREATMENT PLANT<br>PRIMARY CLARIFICATION PROJECT<br>ARCHITECTURAL<br>SECTION |                     |                                                           |                   |
| CITY DRAWING NUMBER<br><b>1-0101-BGAD-P008</b>                                                | SHEET<br><b>001</b> | REV.<br><b>01</b>                                         | SIZE<br><b>A1</b> |