


4			
3			
2			
1			
0	ISSUED FOR CONSTRUCTION	BH	BH 24.12.24
	Revision	By	Appd. YY.MM.DD
E			
D			
C			
B			
A			
	Issued	By	Appd. YY.MM.DD
	File Name: 22050_mech_plumbing_ph3_20241122		24.11.23
		Dwn.	Chkd.
		Dign.	YY.MM.DD




Client/Project
 WINNIPEG TRANSIT
 GARAGE BUILDING
 HOIST REPLACEMENT PROGRAM
 PHASE 3 - HOISTS 2 - 7
 421 Osborne Street, Winnipeg Manitoba

Title
 MAIN FLOOR SANITARY DRAINAGE AND
 VENTILATION CONSTRUCTION PLAN

Project No.	Scale
115422050	1:100
Drawing No.	Sheet
	Revision

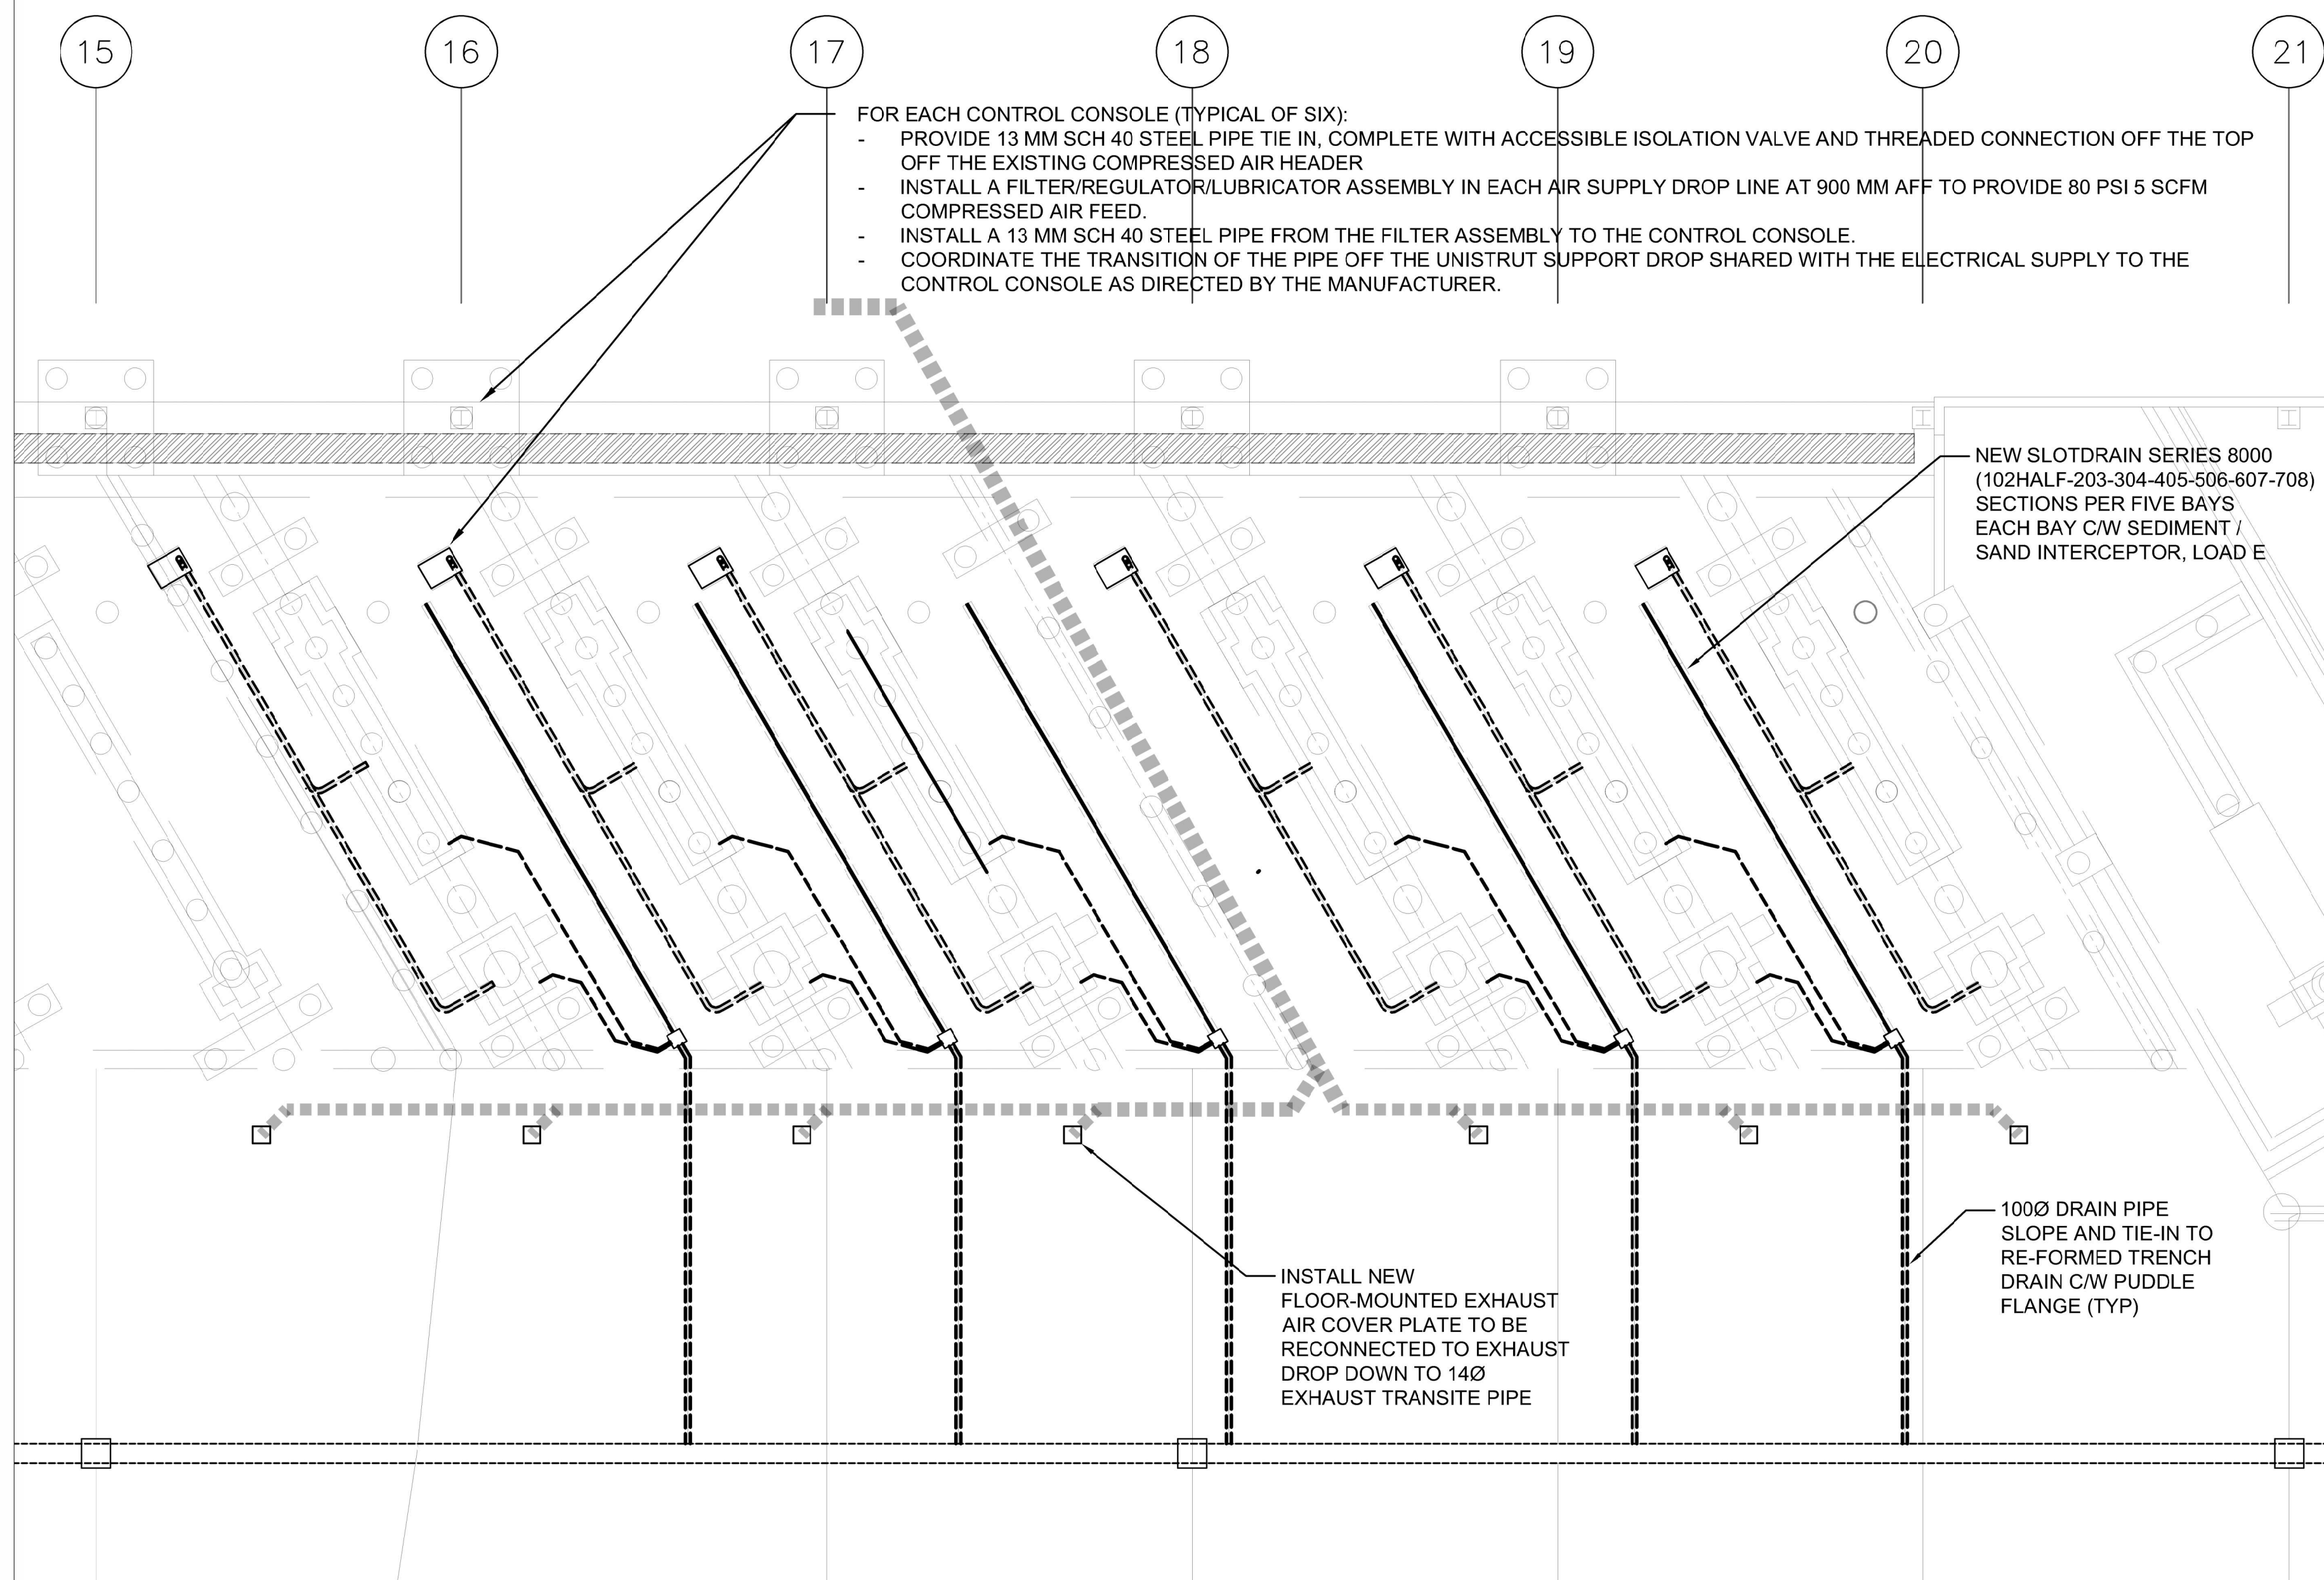


1 MAIN FLOOR PLUMBING PLAN
 M-102 1:100

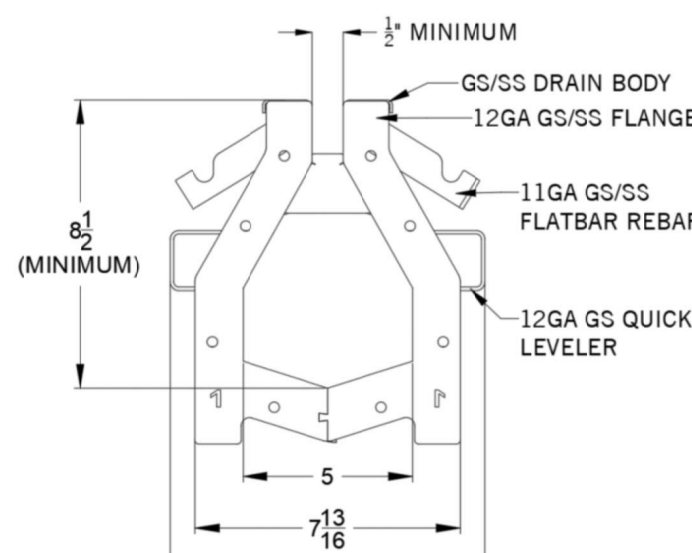

2 SLOT DRAIN ELEVATION VIEW 1
 M-102 NTS

102	203	304	405	506	607	708
8 1/2	9 1/8	9 3/4	10 3/8	11	11 5/8	12 1/4

3 SLOT DRAIN INVERT DEPTH
 M-102 NTS

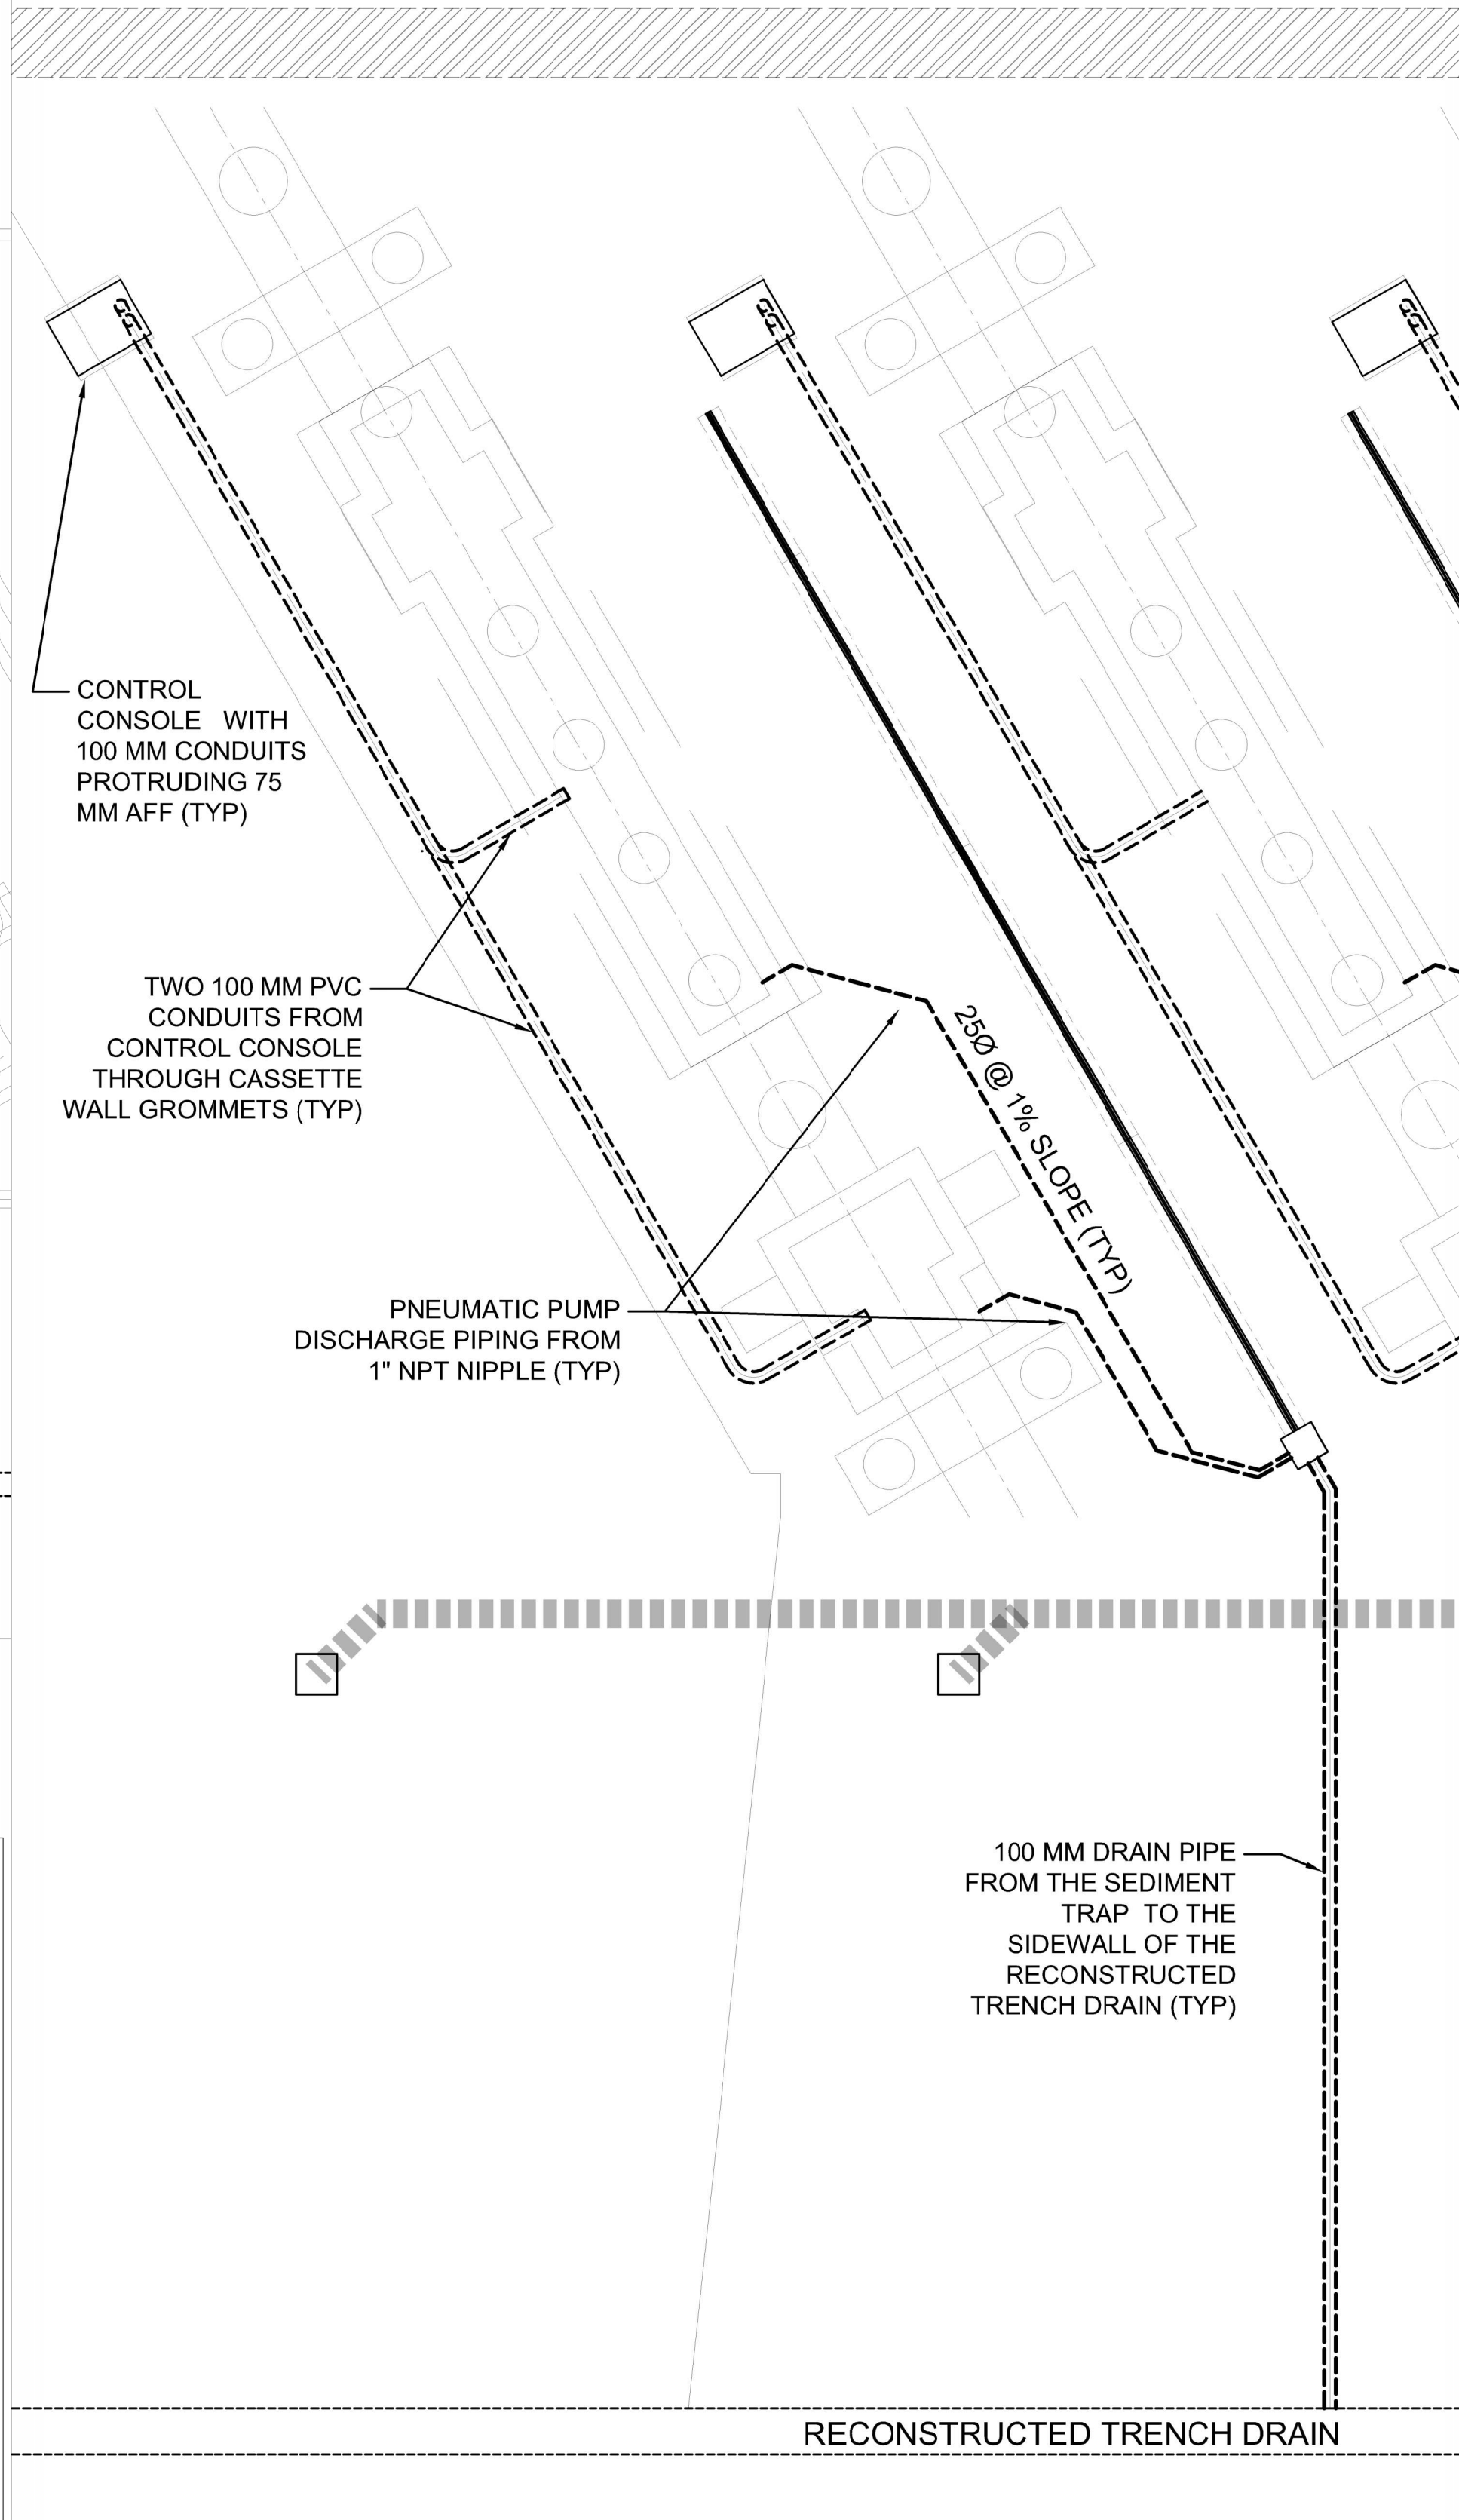

4 ENLARGED PIT INSTALLATION
 M-102 1:50