


LEGEND:

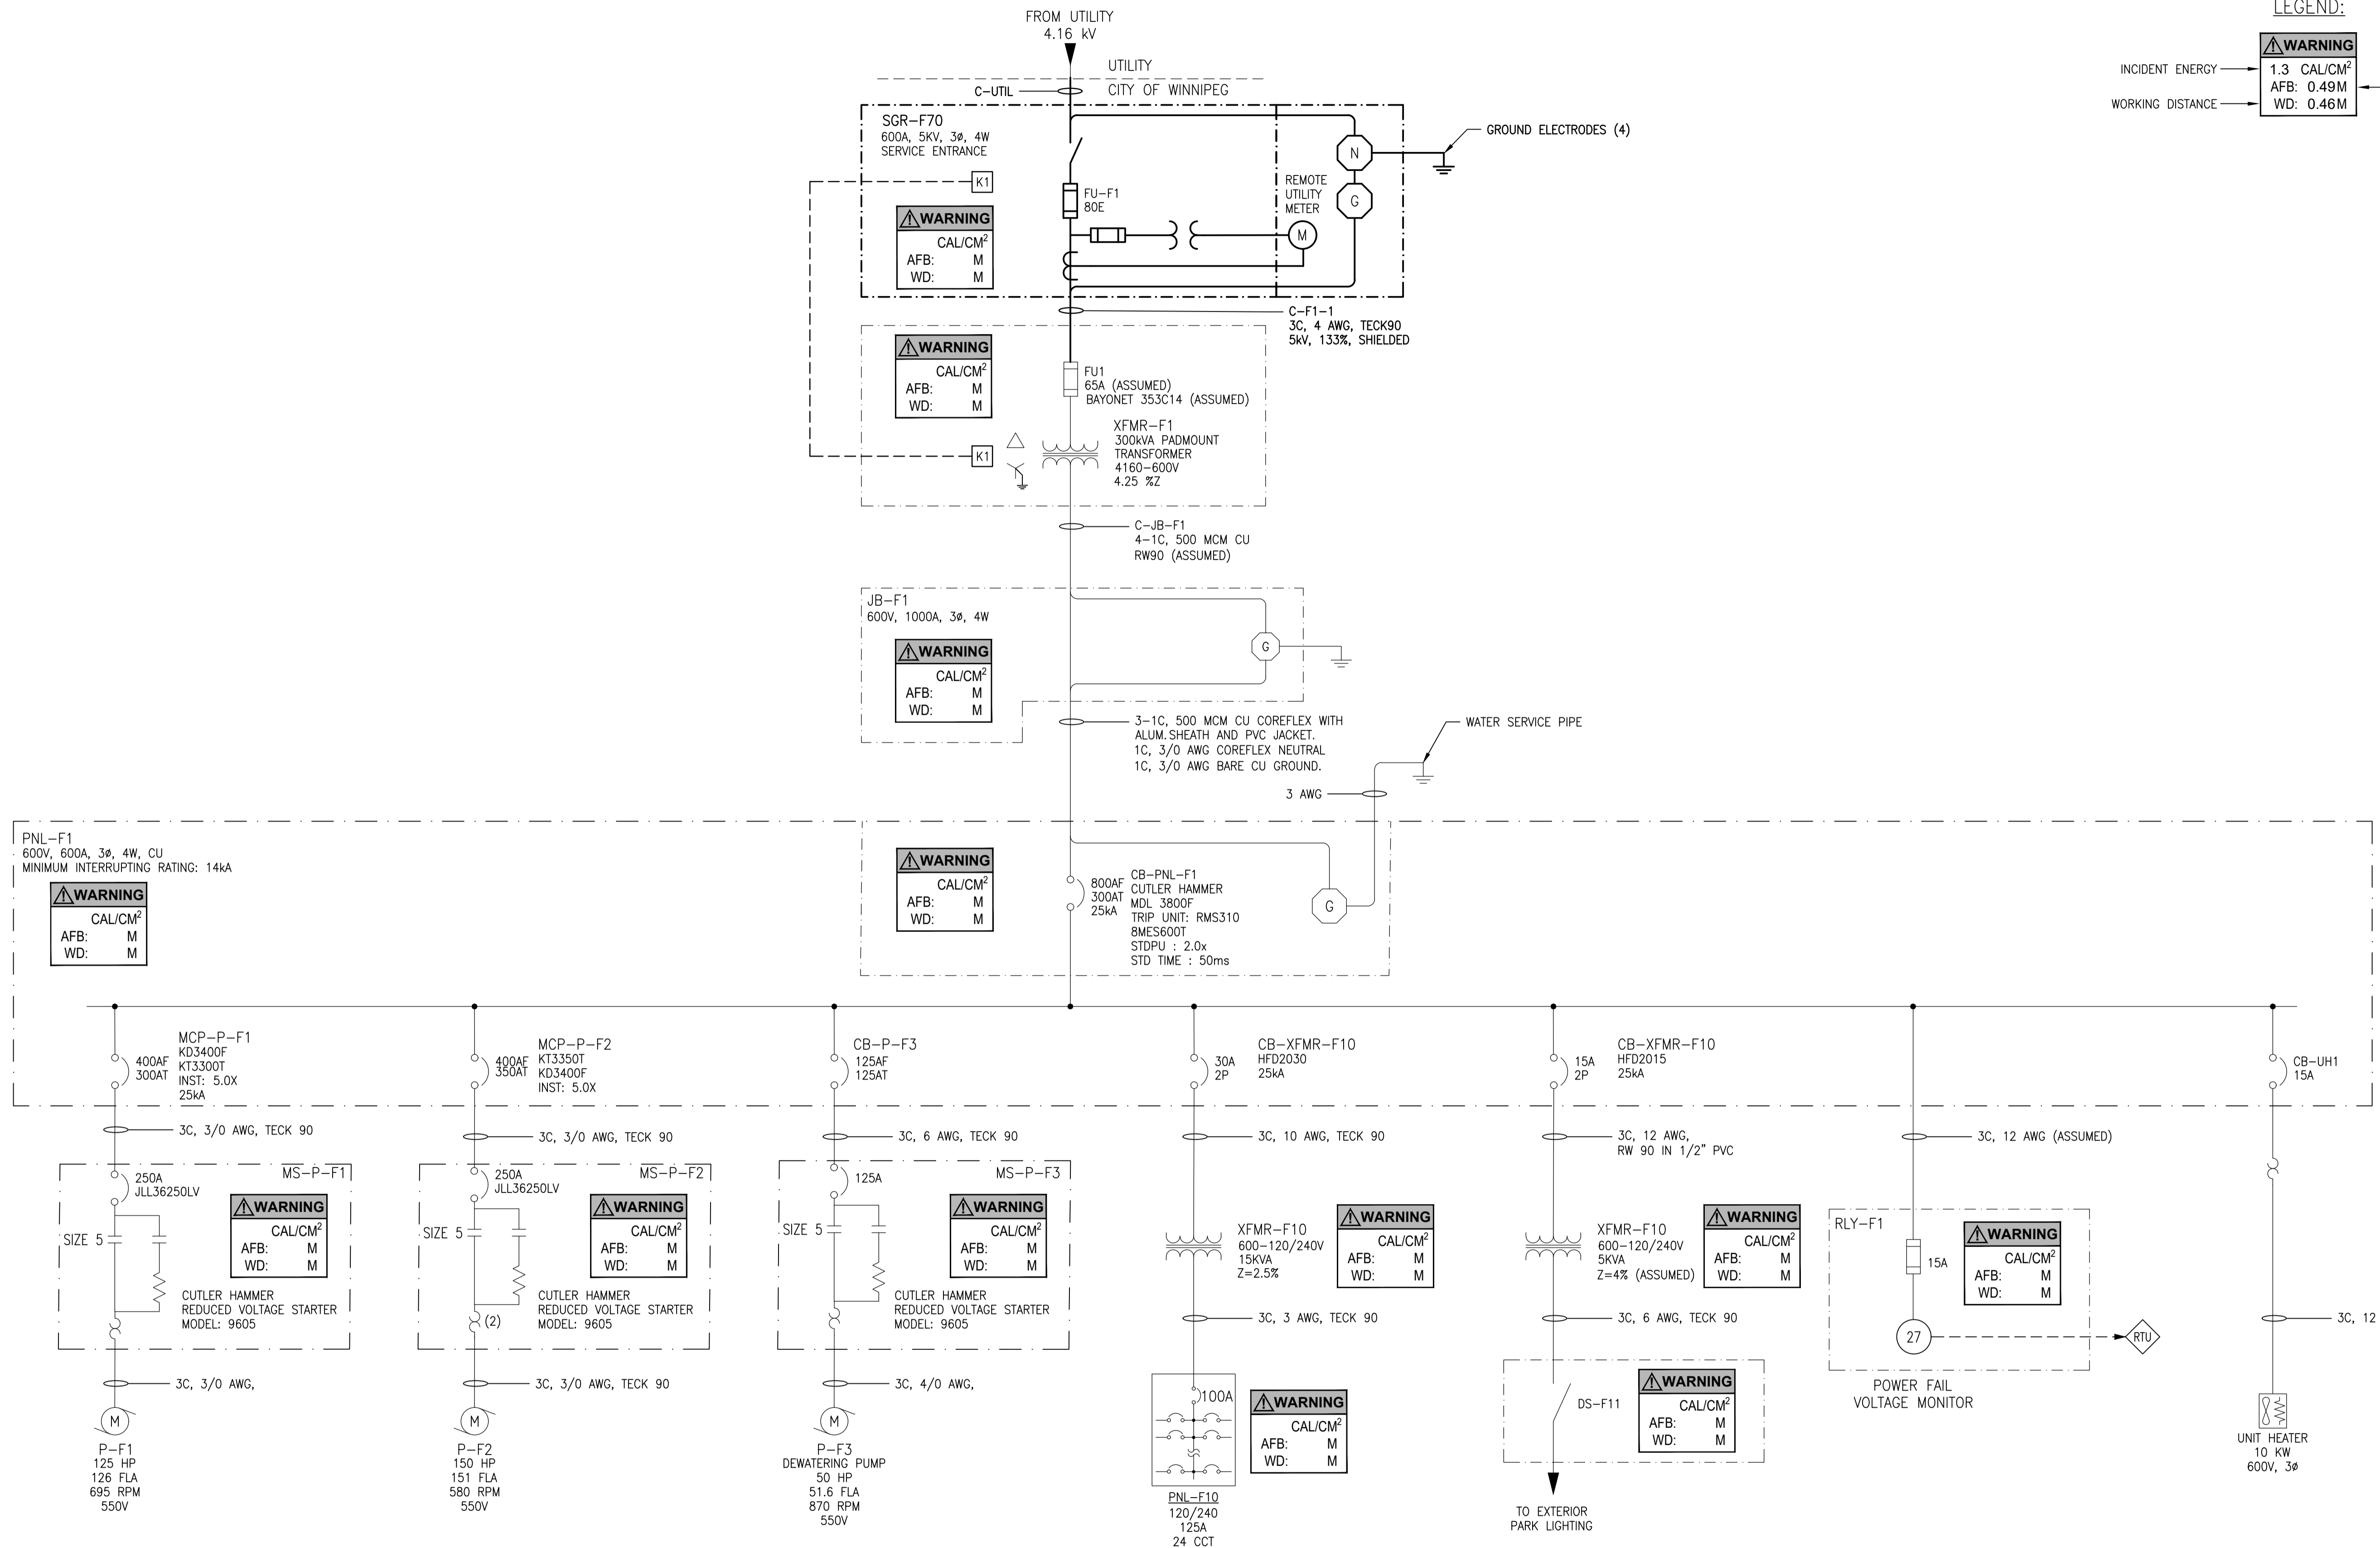

**ENGINEERS  
GEOSCIENTISTS  
MANITOBA**  
Certificate of Authorization  
**AtkinsRéalis Canada Inc.**  
No. 4489

NO.	REVISIONS	DATE	DESIGN	CHECK
00	ISSUED FOR TENDER AND CONSTRUCTION	2024/12/20	PG	VE

<b>AtkinsRéalis</b> 148 Nature Park Way, Winnipeg, Manitoba Canada R3P 0X7 204-786-8080		ENGINEER'S SEAL
DESIGNED BY: P. GILL	CHECKED BY: V. ELIMBAN	
DRAWN BY: K. MOHAMMED	APPROVED BY: D. BECKER	
SCALE: N.T.S.	ISSUED FOR CONSTRUCTION BY: B. SOLOWAY	
DATE: 2024/09/26	DATE: 2024/12/20	
CONSULTANT NO.: 701408		

**THE CITY OF WINNIPEG**  
WATER AND WASTE DEPARTMENT

CORNISH FLOOD PUMPING STATION  
2025 TRANSFORMER REMEDIATION UPGRADES  
SINGLE LINE DIAGRAM  
ARC FLASH STUDY

CITY DRAWING NUMBER	SHEET	REV.	SIZE
1-0132F-E0001	002	00	A1