

Copyright Reserved  
The Contractor shall verify and be responsible for all dimensions.  
DO NOT scale the drawing - any errors or omissions shall be reported to Stantec without delay.  
The Copyrights to all designs and drawings are the property of Stantec. Reproduction or use for any purpose other than that authorized by Stantec is forbidden.

Consultants

Legend

1	ISSUED FOR ADDENDUM #2	CB	AA	25.07.17
Revision		By	Appd.	YY.MM.DD

Permit-Seal

ORIGINAL  
DRAWING  
SEALED BY  
A. AROUTIOUNOV  
MEMBER  
31095  
Stantec Consulting Ltd.  
2025-06-04



**ENGINEERS  
GEOSCIENTISTS  
MANITOBA**  
Certificate of Authorization  
Stantec Consulting Ltd.  
No. 1301

Client/Project  
WINNIPEG TRANSIT MAINTENANCE FACILITY  
OFFICE REDEVELOPMENT

421 OSBORNE ST. SOUTH, WINNIPEG, MB

Title  
PARTIAL FLOOR PLAN - POWER AND  
SYSTEMS - DEMOLITION

Project No. 115421006	Scale 1/8"=1'-0"	Revision 1
Drawing No. E-104	Sheet 6 of 18	

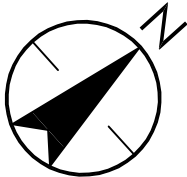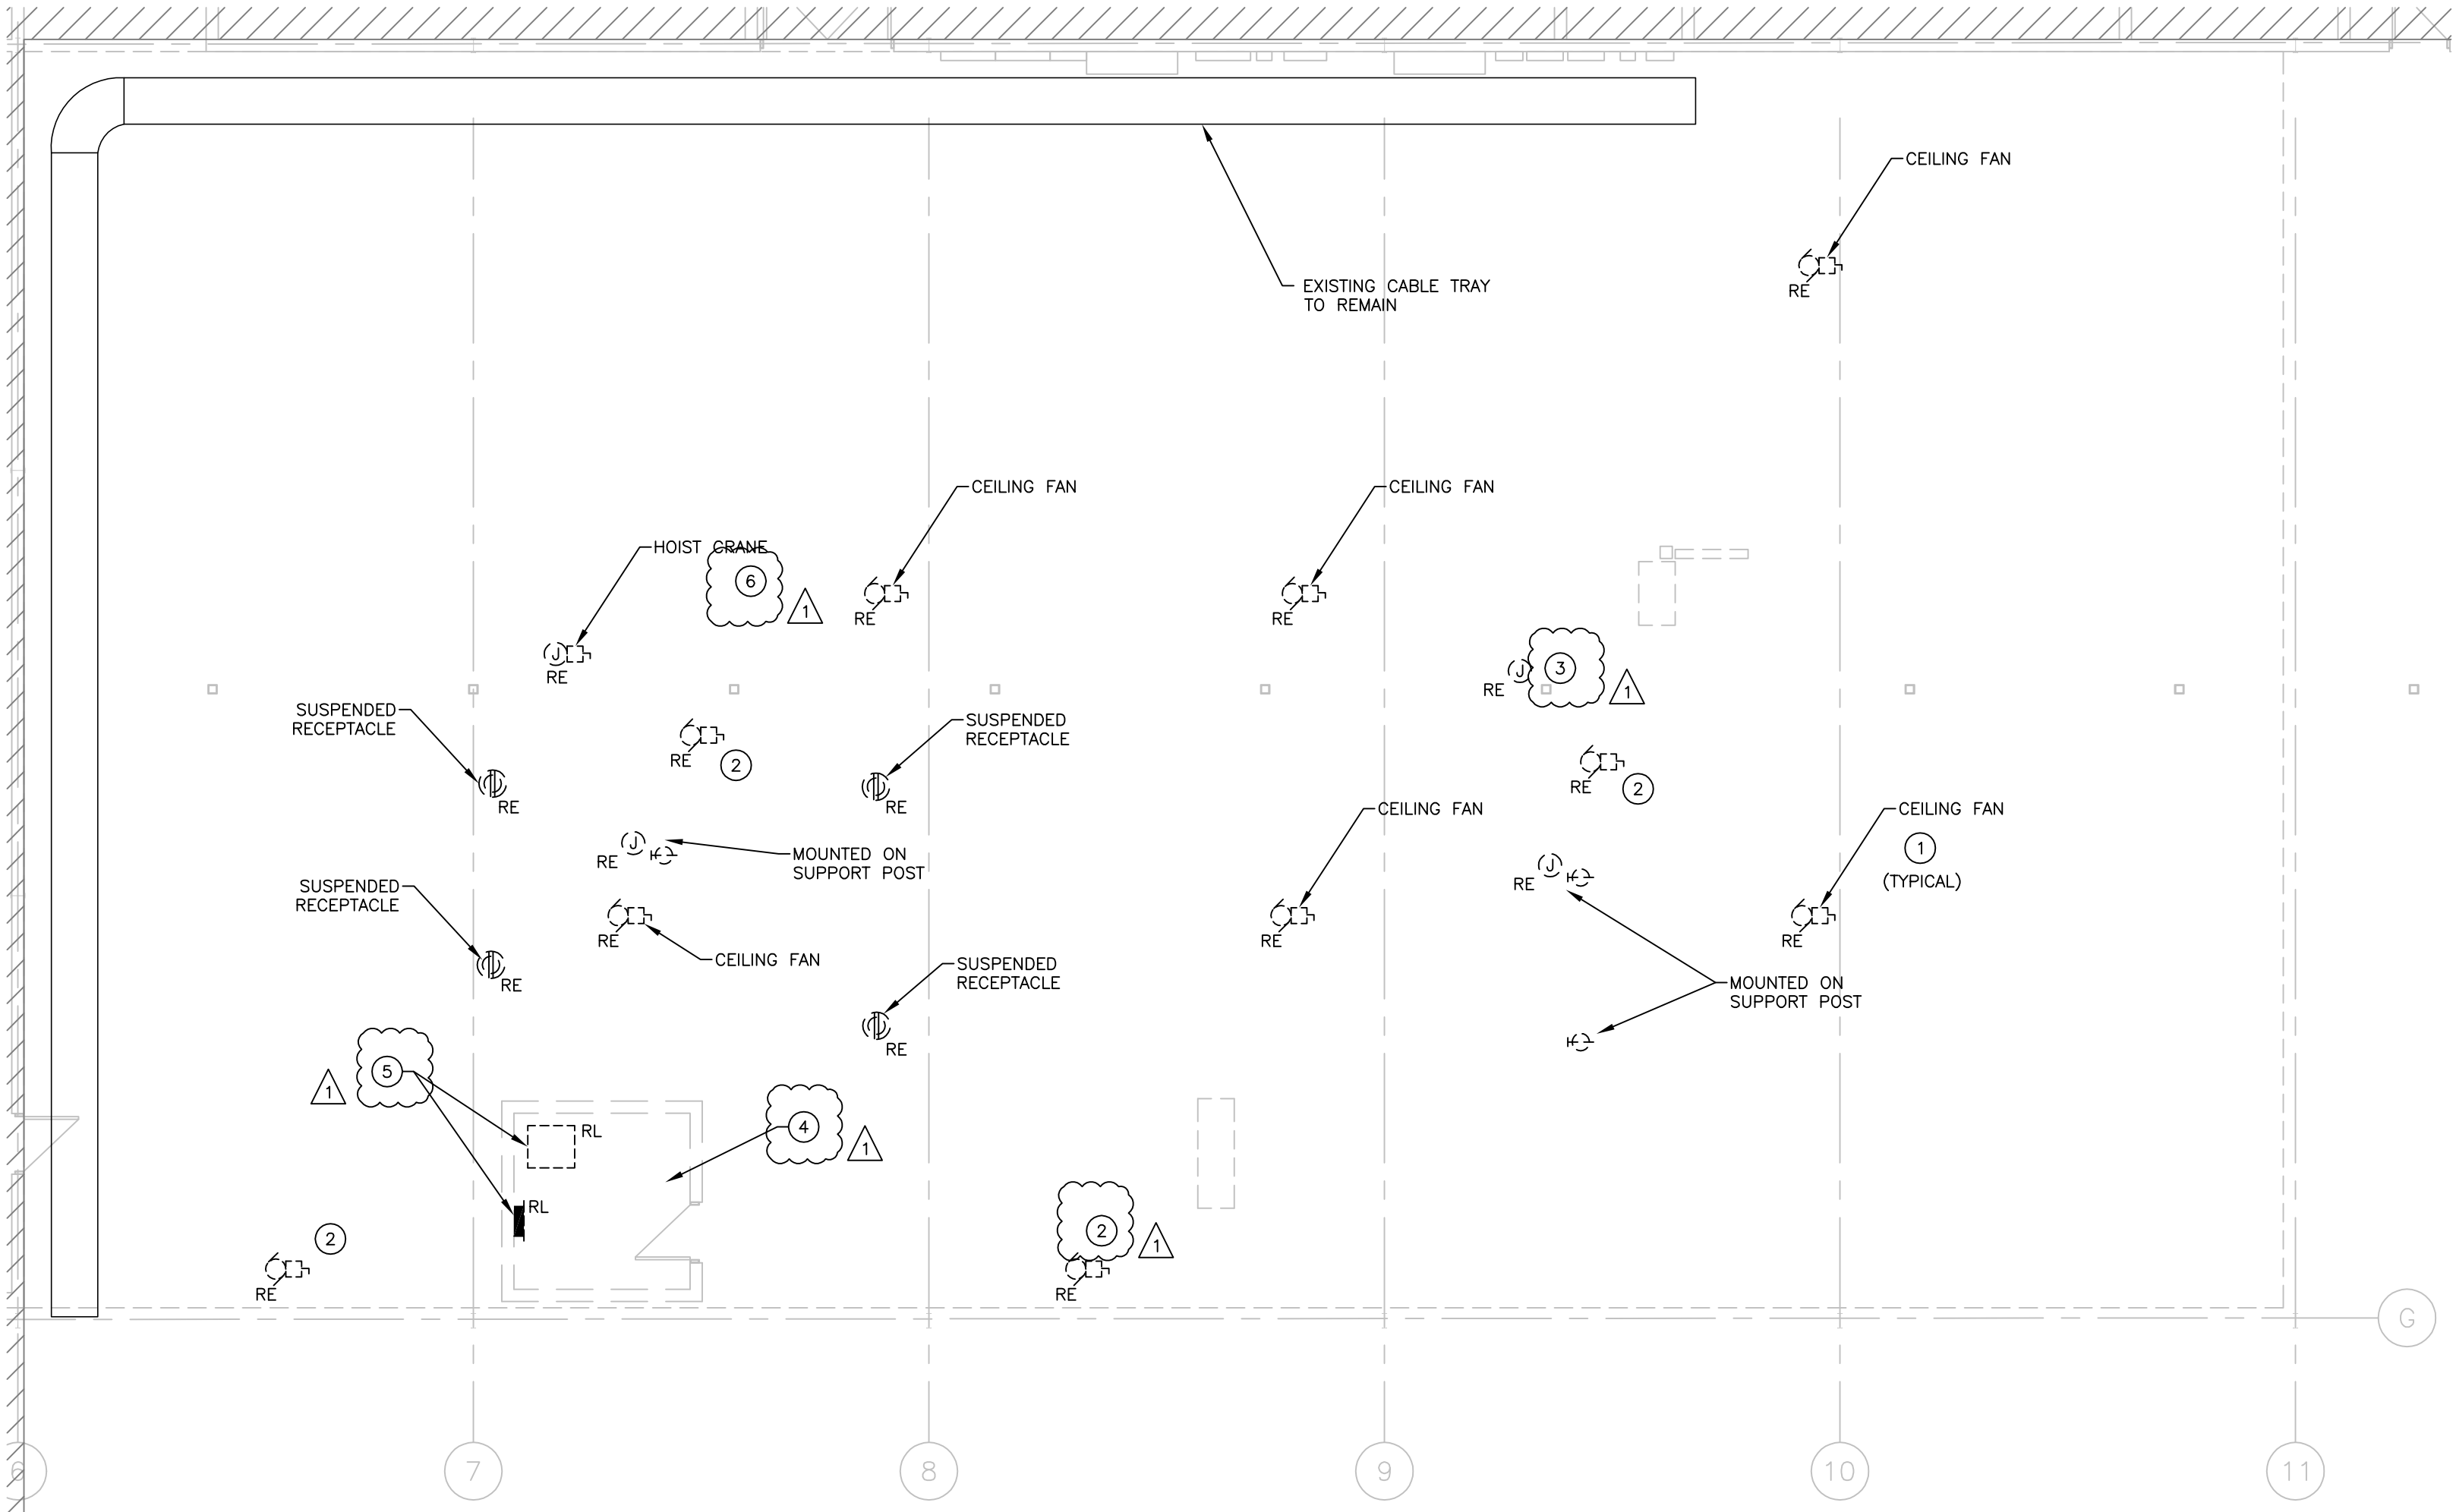

1  
E-104

**PARTIAL FLOOR PLAN – POWER AND SYSTEMS – DEMOLITION**

1/8" = 1'-0"

**GENERAL NOTES:**

- CEILING FAN TO BE REMOVED BY MECHANICAL. ELECTRICAL CONTRACTOR TO REMOVE POWER, WIRE, CONDUIT, ETC. BACK TO SOURCE.
- DISCONNECT AND REMOVE SUSPENDED RECEPTACLES. REMOVE WIRE, CONDUIT, ETC. BACK TO SOURCE.
- DISCONNECT ALL ADDITIONAL SWITCH, RECEPTACLES AND OTHER DEVICES LOCATED IN THE RENOVATION AREA. REMOVE WIRE AND CONDUIT BACK TO SOURCE.
- PROVIDE BONDING FOR EXISTING CABLE TRAY IF NOT PRESENT IN ACCORDANCE WITH CEC 12-2208.

**KEY NOTES:**

- EXISTING EXHAUST FAN TO BE REMOVED BY MECHANICAL. ELECTRICAL CONTRACTOR TO REMOVE POWER, WIRE, CONDUIT, ETC. BACK TO SOURCE.
- EXISTING EXHAUST HOOD TO BE REMOVED BY MECHANICAL. ELECTRICAL CONTRACTOR TO REMOVE POWER, WIRE, CONDUIT, ETC. BACK TO SOURCE.
- EXISTING WATER FOUNTAIN TO BE REMOVED BY MECHANICAL. ELECTRICAL CONTRACTOR TO REMOVE POWER, WIRE, CONDUIT, ETC. BACK TO SOURCE.
- EXISTING DEVICES INSIDE OFFICE TO BE DISCONNECTED AND REMOVED. REMOVE POWER, WIRE, CONDUIT, ETC. BACK TO SOURCE.
- EXISTING TRANSFORMER AND PANEL (FEEDING DOCK PORTS) LOCATED ON TOP OF OFFICE TO BE RELOCATED.
- DISCONNECT AND REMOVE POWER TO HOIST CRANE. REMOVE WIRE AND CONDUIT BACK TO PANEL.