

Copyright Reserved

The Contractor shall verify and be responsible for all dimensions.
DO NOT scale the drawing - any errors or omissions shall be
reported to Stantec without delay.
The Copyrights to all designs and drawings are the property of
Stantec. Reproduction or use for any purpose other than that
authorized by Stantec is forbidden.

Consultants

Legend

1	ISSUED FOR ADDENDUM #3	CB	AA	25.07.30
Revision		By	Appd.	YY.MM.DD
ISSUED FOR CONSTRUCTION		CB	AA	25.06.04
Issued		By	Appd.	YY.MM.DD

File Name:		Dwn.	Chkd.	Dsgn.	YY.MM.DD
------------	--	------	-------	-------	----------

Permit-Seal

**ENGINEERS
GEOSCIENTISTS
MANITOBA**
Certificate of Authorization
Stantec Consulting Ltd.
No. 1301

Client/Project
WINNIPEG TRANSIT MAINTENANCE FACILITY
OFFICE REDEVELOPMENT

421 OSBORNE ST. SOUTH, WINNIPEG, MB

Title
PARTIAL FLOOR PLAN - FIRE ALARM AND -
SECURITY - NEW CONSTRUCTION



Project No. 115421006	Scale 1/8"=1'-0"
Drawing No. E-205	Sheet 11 of 18
	Revision 1

GENERAL NOTES:

1. PROVIDE AND CONNECT FIRE ALARM DEVICES TO EXISTING FIRE ALARM CIRCUIT SERVING AREA WITH CAPACITY. ENSURE NEW FIRE ALARM DEVICES ARE COMPATIBLE WITH EXISTING FIRE ALARM MANUFACTURER 'NOTIFIER'.
2. FIRE ALARM AS-BUILT RECORD DRAWINGS TO BE COMPLETE WITH CONDUIT ROUTING CLEARLY INDICATED AND ALL FIRE ALARM ADDRESSES DENOTED WITH THE RESPECTIVE DEVICE.
3. FIRE ALARM TESTING TO BE CONDUCTED IN ACCORDANCE WITH THE CITY OF WINNIPEG INTEGRATED LIFE SAFETY SYSTEM TESTING.
4. ENSURE CO DETECTORS CONFORM WITH THE LATEST VERSION OF THE MANITOBA BUILDING CODE.

KEY NOTES:

1. CONTRACTOR TO WIRE CARD READER AND ASSOCIATED ACCESS CONTROL DEVICES AS NECESSARY. UTILIZE DOOR CONTROLLER LOCATED IN ALTRONIX ACCESS CONTROL SYSTEM PANEL LOCATED IN SAFETY OFFICERS ROOM 114.
2. PROVIDE DUCT DETECTOR WITHIN THE SUPPLY AIR DUCT. DUCT DETECTOR TO BE CONNECTED TO FIRE ALARM SHUT DOWN RELAY TO SHUT DOWN RTU-2 / ERV-2 UPON ACTIVATION. COORDINATE DUCT LOCATION WITH MECHANICAL.

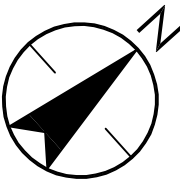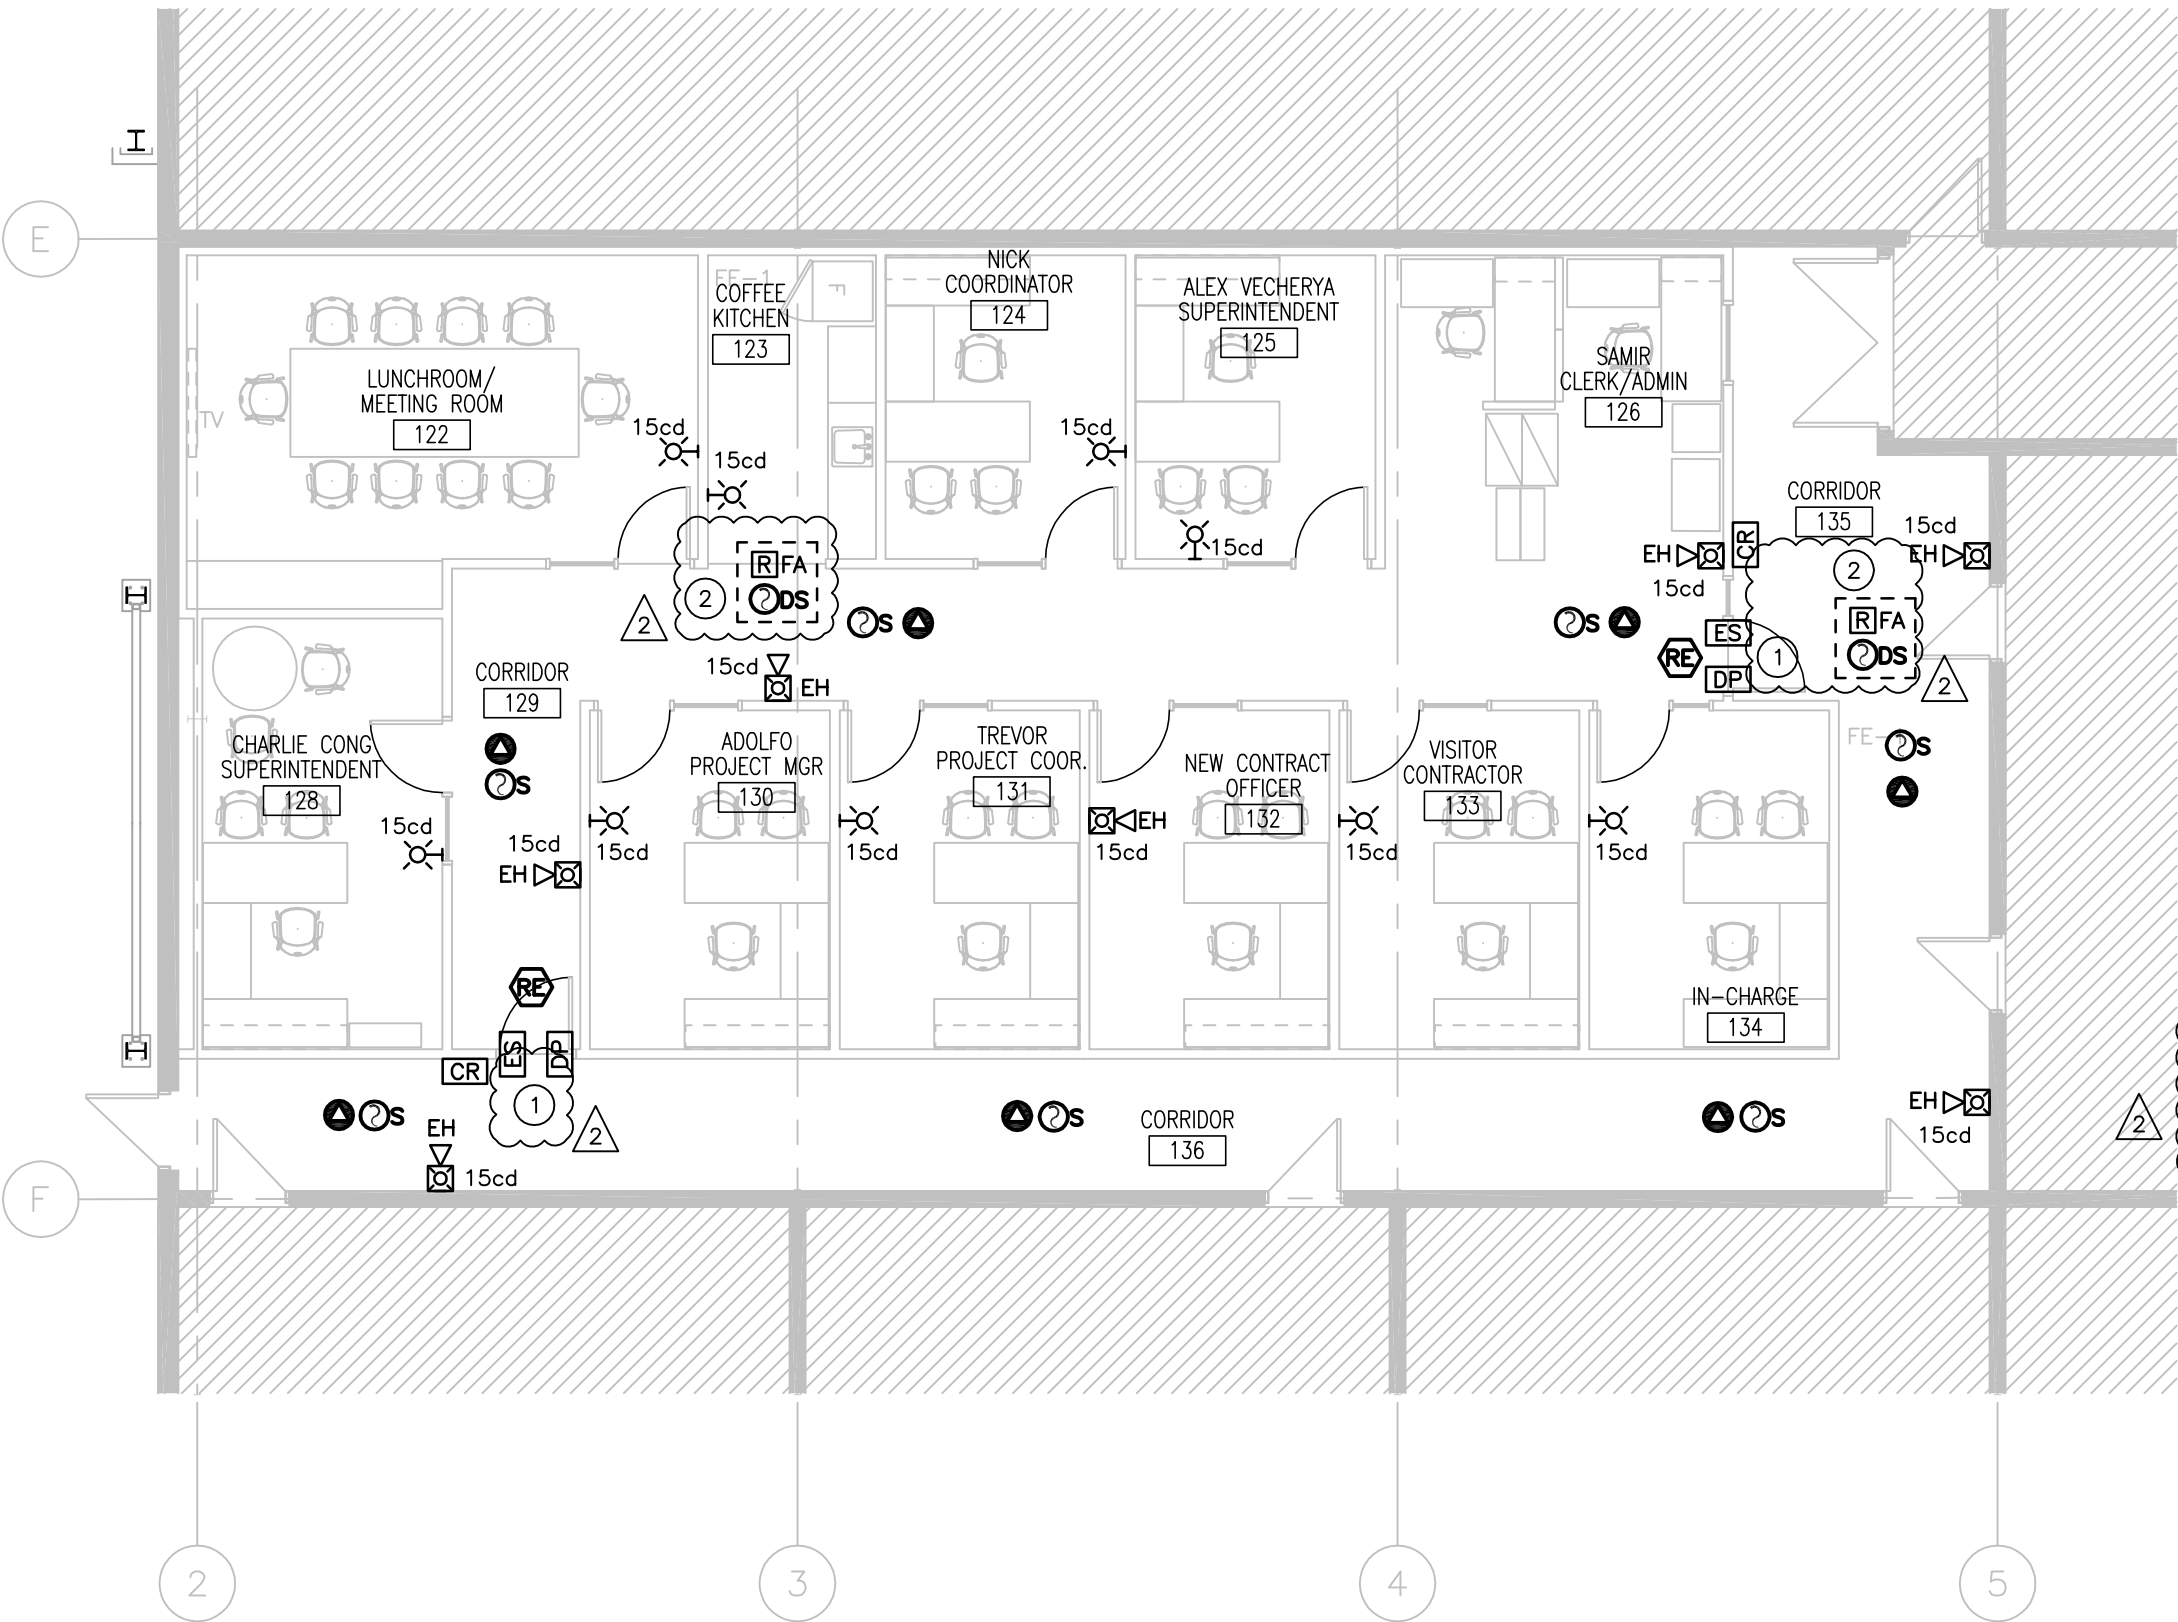

1 PARTIAL FLOOR PLAN – FIRE ALARM AND SECURITY– NEW CONSTRUCTION
E-205
1/8" = 1'-0"