



The Contractor shall verify and be responsible for all dimensions. DO NOT scale the drawing - any errors or omissions shall be reported to Stantec without delay.

The Copyrights to all designs and drawings are the property of Stantec. Reproduction or use for any purpose other than that authorized by Stantec is forbidden.

Legend

Revision	By	Appd.	YY.MM.DD
ISSUED FOR CONSTRUCTION	CB	AA	25.06.04
Issued	By	Appd.	YY.MM.DD

File Name:	_____	_____	_____	_____
	Dwn.	Chkd.	Dsgn.	YY.MM.DD



**ENGINEERS
GEOSCIENTISTS
MANITOBA**

Certificate of Authorization
Stantec Consulting Ltd.
No. 1301

WINNIPEG TRANSIT MAINTENANCE FACILITY OFFICE REDEVELOPMENT

Title
SITE PLAN - ELECTRICAL

Project No. 115421006	Scale 1/64" = 1'-0"	
Drawing No. E-002	Sheet 2 of 18	Revision 0

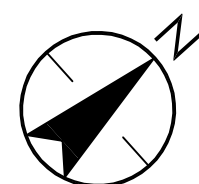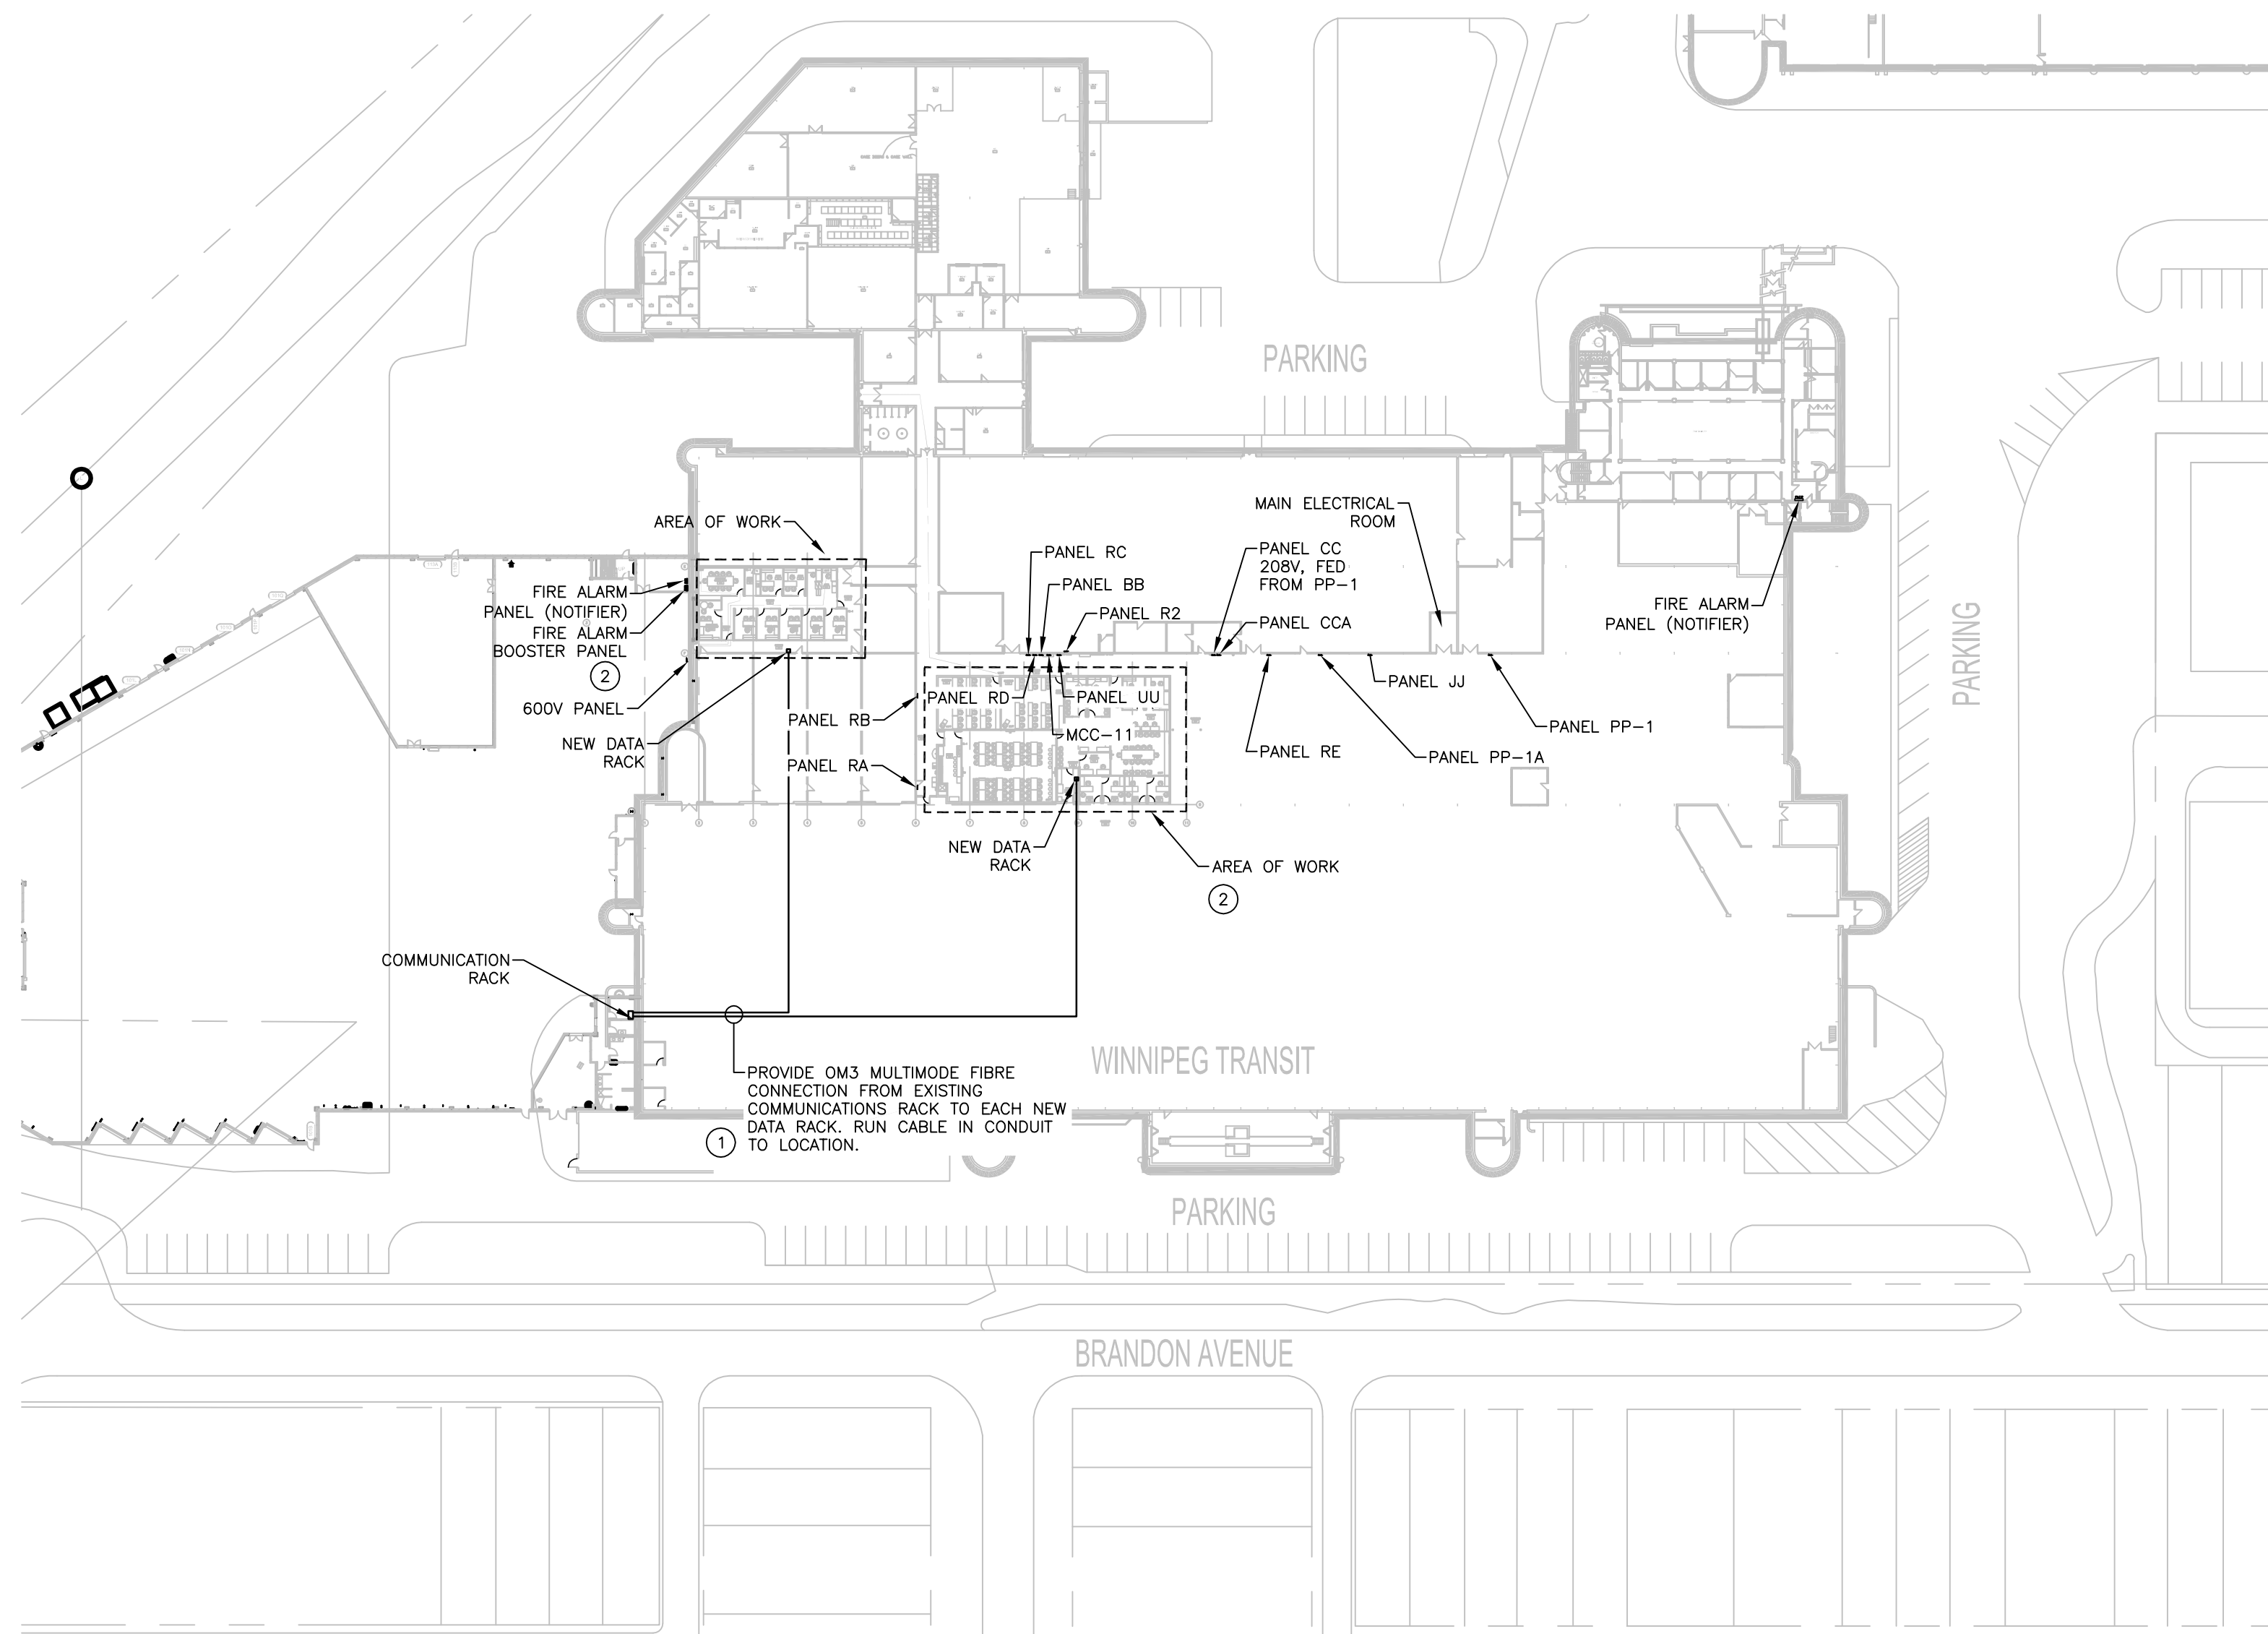

1 MAIN PLAN - ELECTRICAL
E-002 1/64" = 1'-0"

1. ALL DEVICES SHOWN IN VIEW ARE EXISTING UNLESS OTHERWISE STATED.

- ① FIBRE OPTIC CABLE TO BE MANUFACTURED WITH CORNING GLASS, CONTRACTOR TO PROVIDE COPPER TO FIBRE CONVERTERS FOR FIBRE (1GPS). CONVERTERS TO BE CORNING AND CONNECTORS TO BE TYPE ST. COORDINATE WITH EXISTING EQUIPMENT AND WITH OWNER.
- ② PROVIDE FIRE ALARM BOOSTER PANEL AS NECESSARY TO SERVE LARGE OFFICE AREA.