

Copyright Reserved

The Contractor shall verify and be responsible for all dimensions.
DO NOT scale the drawing - any errors or omissions shall be
reported to Stantec without delay.
The Copyrights to all designs and drawings are the property of
Stantec. Reproduction or use for any purpose other than that
authorized by Stantec is forbidden.

Consultants

Legend

Revision

ISSUED FOR CONSTRUCTION
Issued

| | | |
|----|-------|----------|
| By | Appd. | YY.MM.DD |
| | | |
| | | |
File Name:

| | | | |
|------|-------|-------|----------|
| Dwn. | Chkd. | Dsgn. | YY.MM.DD |
|------|-------|-------|----------|

Permit-Seal



Client/Project

WINNIPEG TRANSIT MAINTENANCE FACILITY
OFFICE REDEVELOPMENT

421 OSBORNE ST. SOUTH, WINNIPEG, MB

Title

PARTIAL FLOOR PLAN - POWER AND
SYSTEMS - DEMOLITION

Project No.
115421006

Scale
1/8"=1'-0"

Drawing No.



Sheet

Revision

E-104

6 of 18

0

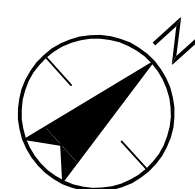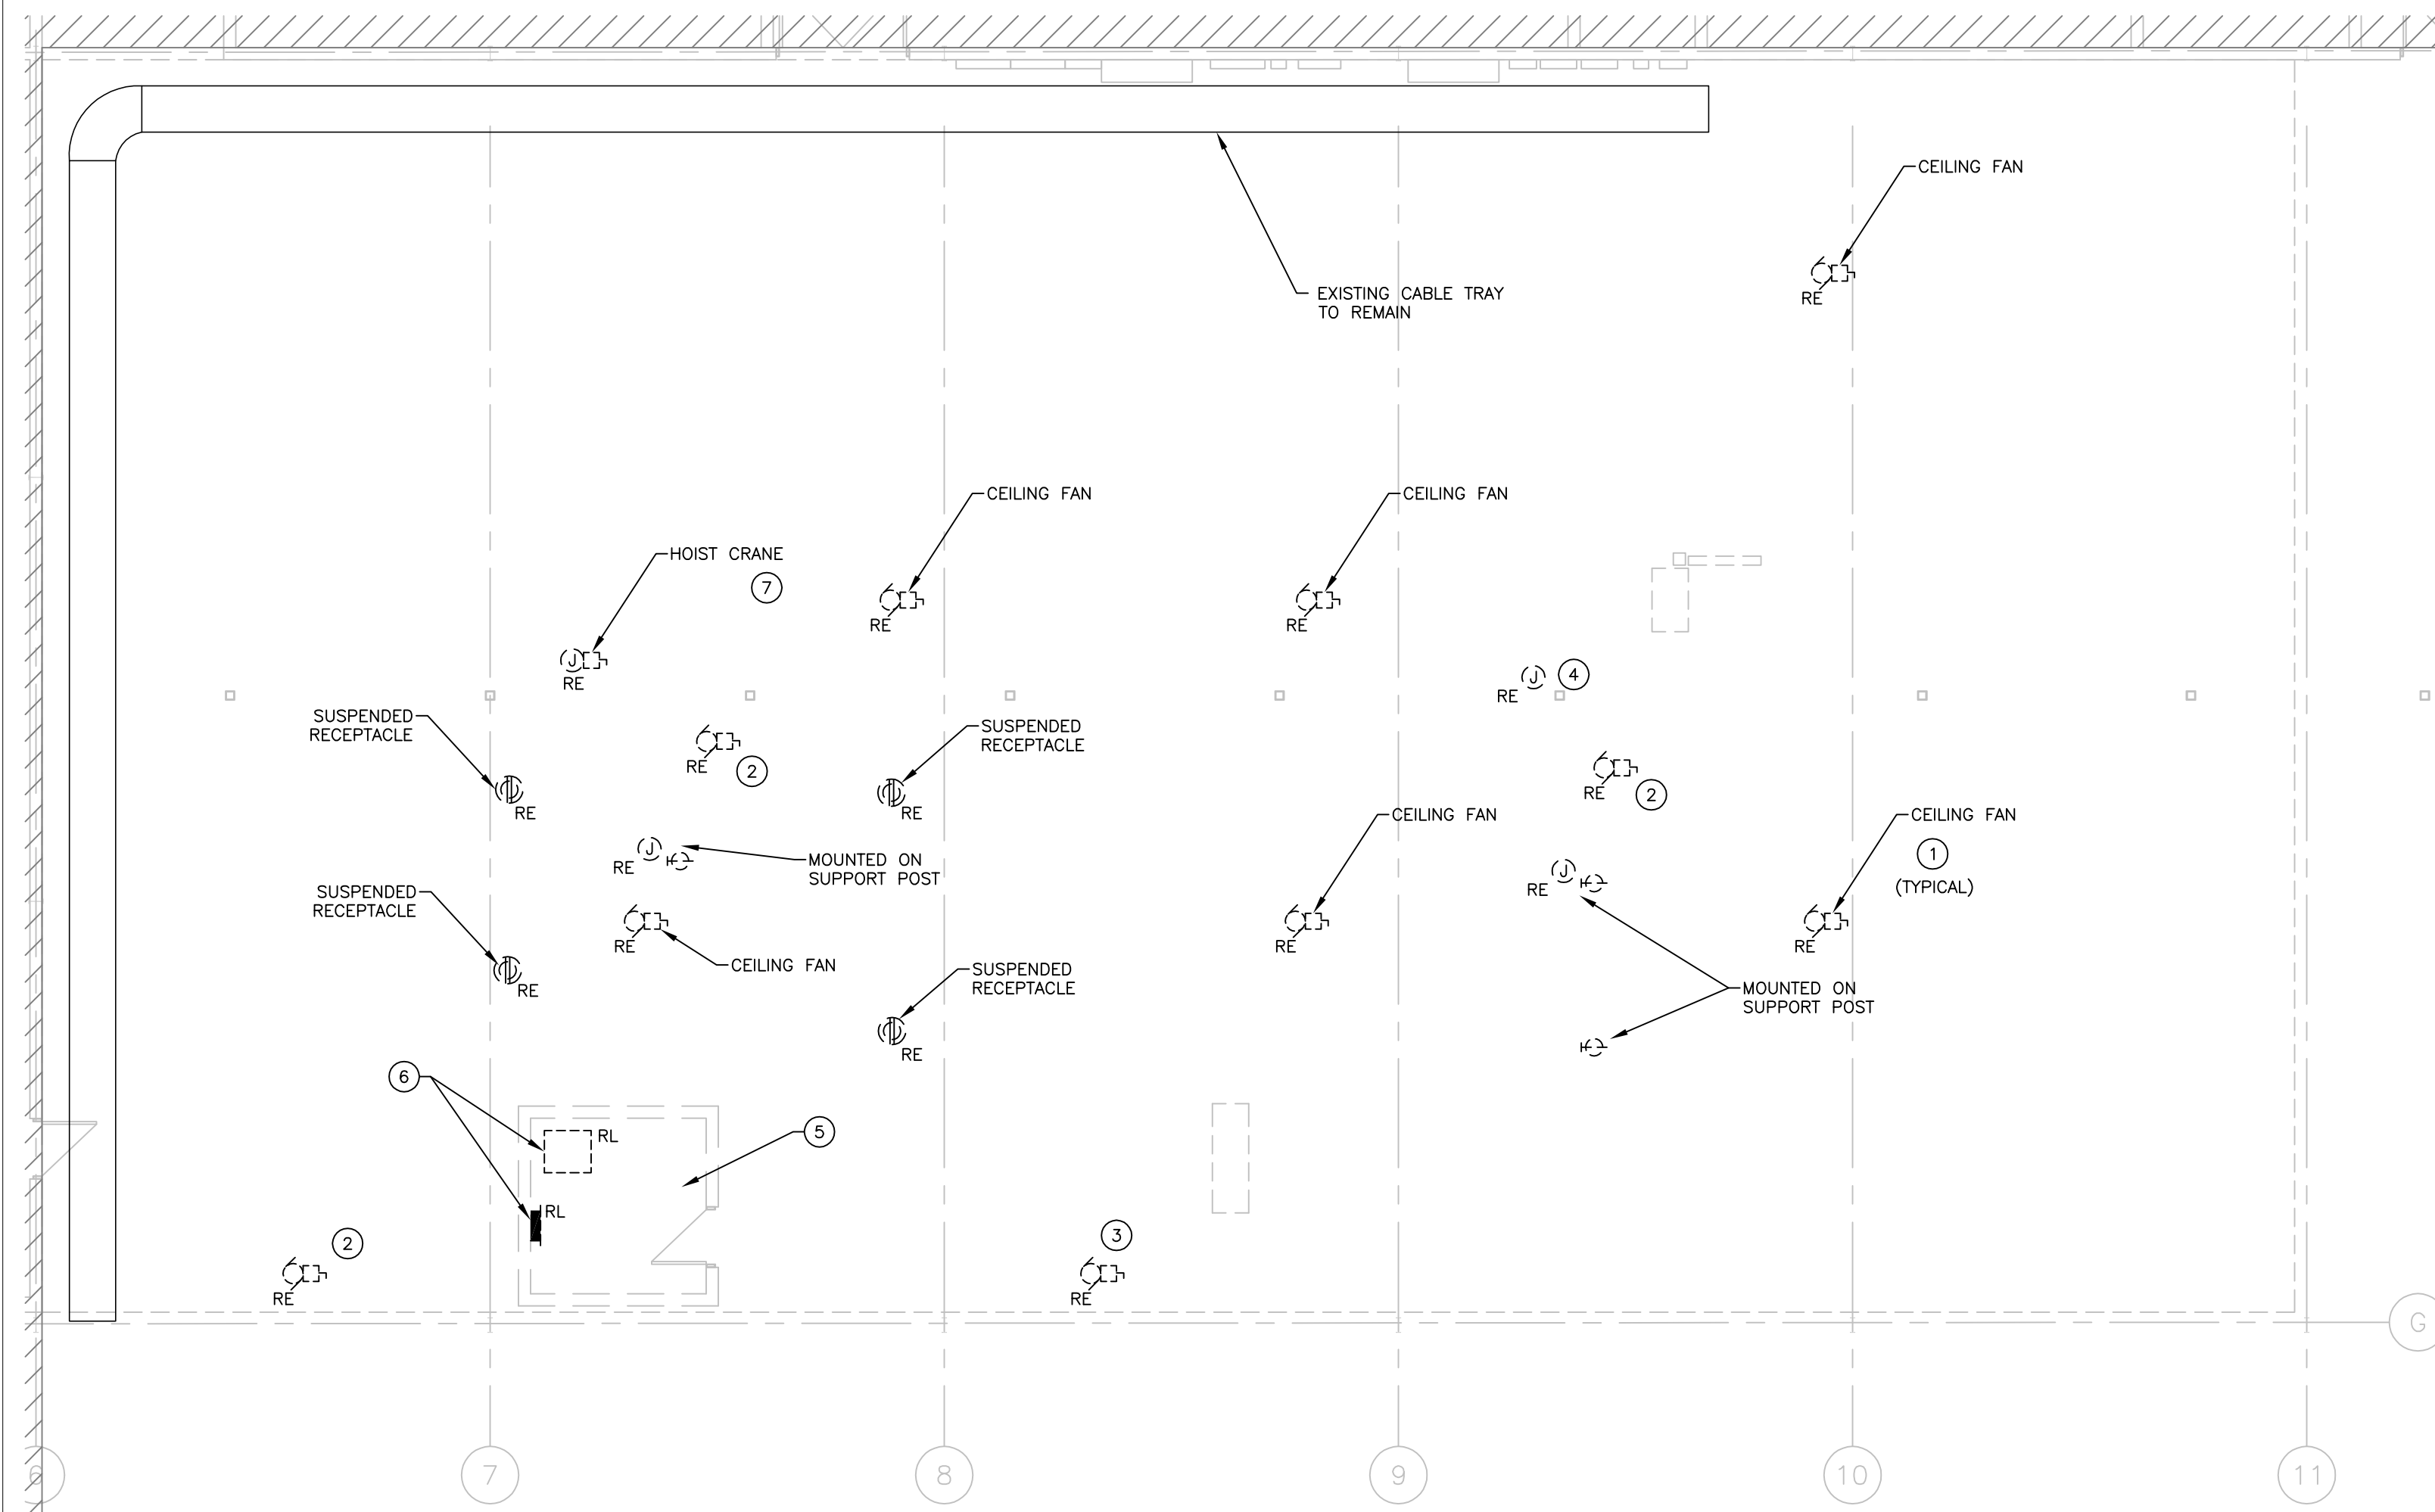

1
E-104

PARTIAL FLOOR PLAN – POWER AND SYSTEMS – DEMOLITION
1/8" = 1'-0"

GENERAL NOTES:

- CEILING FAN TO BE REMOVED BY MECHANICAL. ELECTRICAL CONTRACTOR TO REMOVE POWER, WIRE, CONDUIT, ETC. BACK TO SOURCE.
- DISCONNECT AND REMOVE SUSPENDED RECEPTACLES. REMOVE WIRE, CONDUIT, ETC. BACK TO SOURCE.
- DISCONNECT ALL ADDITIONAL SWITCH, RECEPTACLES AND OTHER DEVICES LOCATED IN THE RENOVATION AREA. REMOVE WIRE AND CONDUIT BACK TO SOURCE.
- PROVIDE BONDING FOR EXISTING CABLE TRAY IF NOT PRESENT IN ACCORDANCE WITH CEC 12-2208.

KEY NOTES:

- EXISTING EXHAUST FAN TO BE REMOVED BY MECHANICAL. ELECTRICAL CONTRACTOR TO REMOVE POWER, WIRE, CONDUIT, ETC. BACK TO SOURCE.
- EXISTING EXHAUST HOOD TO BE REMOVED BY MECHANICAL. ELECTRICAL CONTRACTOR TO REMOVE POWER, WIRE, CONDUIT, ETC. BACK TO SOURCE.
- EXISTING WATER FOUNTAIN TO BE REMOVED BY MECHANICAL. ELECTRICAL CONTRACTOR TO REMOVE POWER, WIRE, CONDUIT, ETC. BACK TO SOURCE.
- EXISTING DEVICES INSIDE OFFICE TO BE DISCONNECTED AND REMOVED. REMOVE POWER, WIRE, CONDUIT, ETC. BACK TO SOURCE.
- EXISTING TRANSFORMER AND PANEL (FEEDING DOCK PORTS) LOCATED ON TOP OF OFFICE TO BE RELOCATED.
- DISCONNECT AND REMOVE POWER TO HOIST CRANE. REMOVE WIRE AND CONDUIT BACK TO PANEL.