
 





The Contractor shall verify and be responsible for all dimensions. DO NOT scale the drawing - any errors or omissions shall be reported to Stantec without delay. The Copyrights to all designs and drawings are the property of Stantec. Reproduction or use for any purpose other than that authorized by Stantec is forbidden.

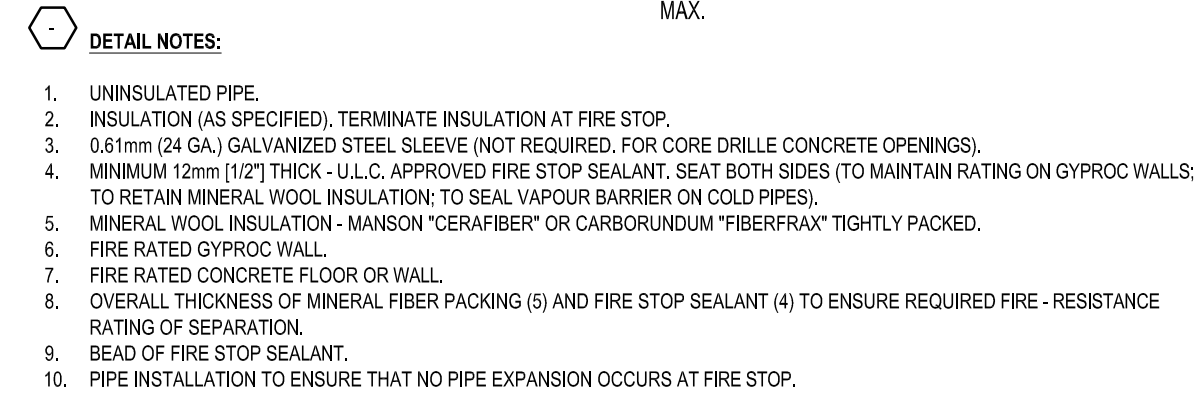

3  
M-502



 1 PIPE C  
M-502 SCALE: N.T.S.



4  
M-502



7 FLOOR  
M-502 SCALE: N.T.S.



8 PITCH  
M-502 SCALE: N.T.S.

Revision	By	Appd.	YY.MM.DD

File Name: 21006-M	GS	WD	MA	25.03.28
	Dwn.	Chkd.	Dsgn.	YY.MM.DD

**ENGINEERS  
GEOSCIENTISTS  
MANITOBA**

Certificate of Authorization  
Stantec Consulting Ltd.  
No. 1301

WINNIPEG TRANSIT MAINTENANCE FACILITY  
OFFICE REDEVELOPMENT

Title  
MECHANICAL DETAILS

Drawing No.	Sheet	Revision
-------------	-------	----------

0