
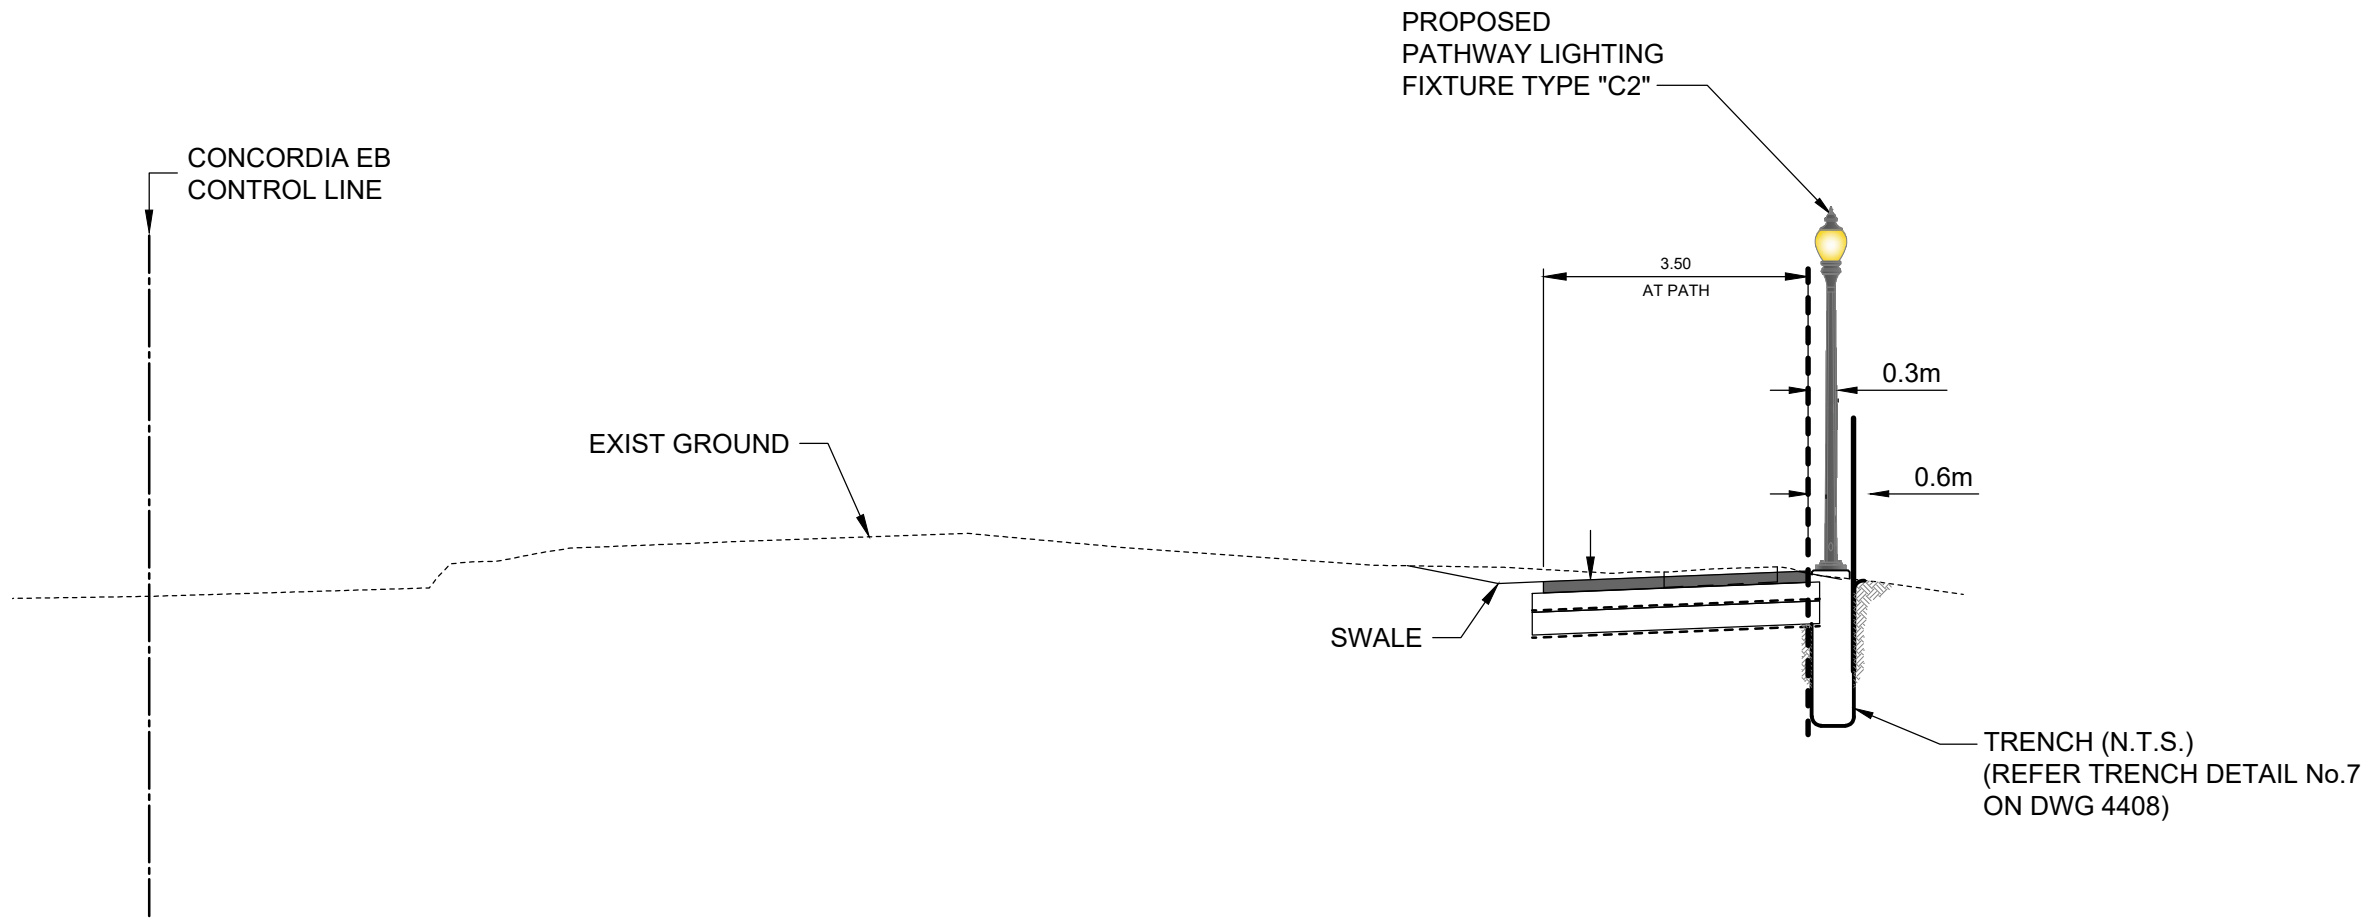


LEGEND	
	EXISTING UTILITY SERVICE POLE
	EXISTING UTILITY O/H PRIMARY POWER LINE
	NEW OUTDOOR PAD-MOUNTED CUSTOMER SERVICE TERMINATION ENCLOSURE
	PEDESTRIAN PATHWAY NEW LIGHTING FIXTURE TYPE "C1"
	PEDESTRIAN PATHWAY NEW LIGHTING FIXTURE TYPE "C2" C/W HOUSE SHIELD
	EXISTING STREET LIGHTING POLE MOUNTED 60W FIXTURE TYPE "D"

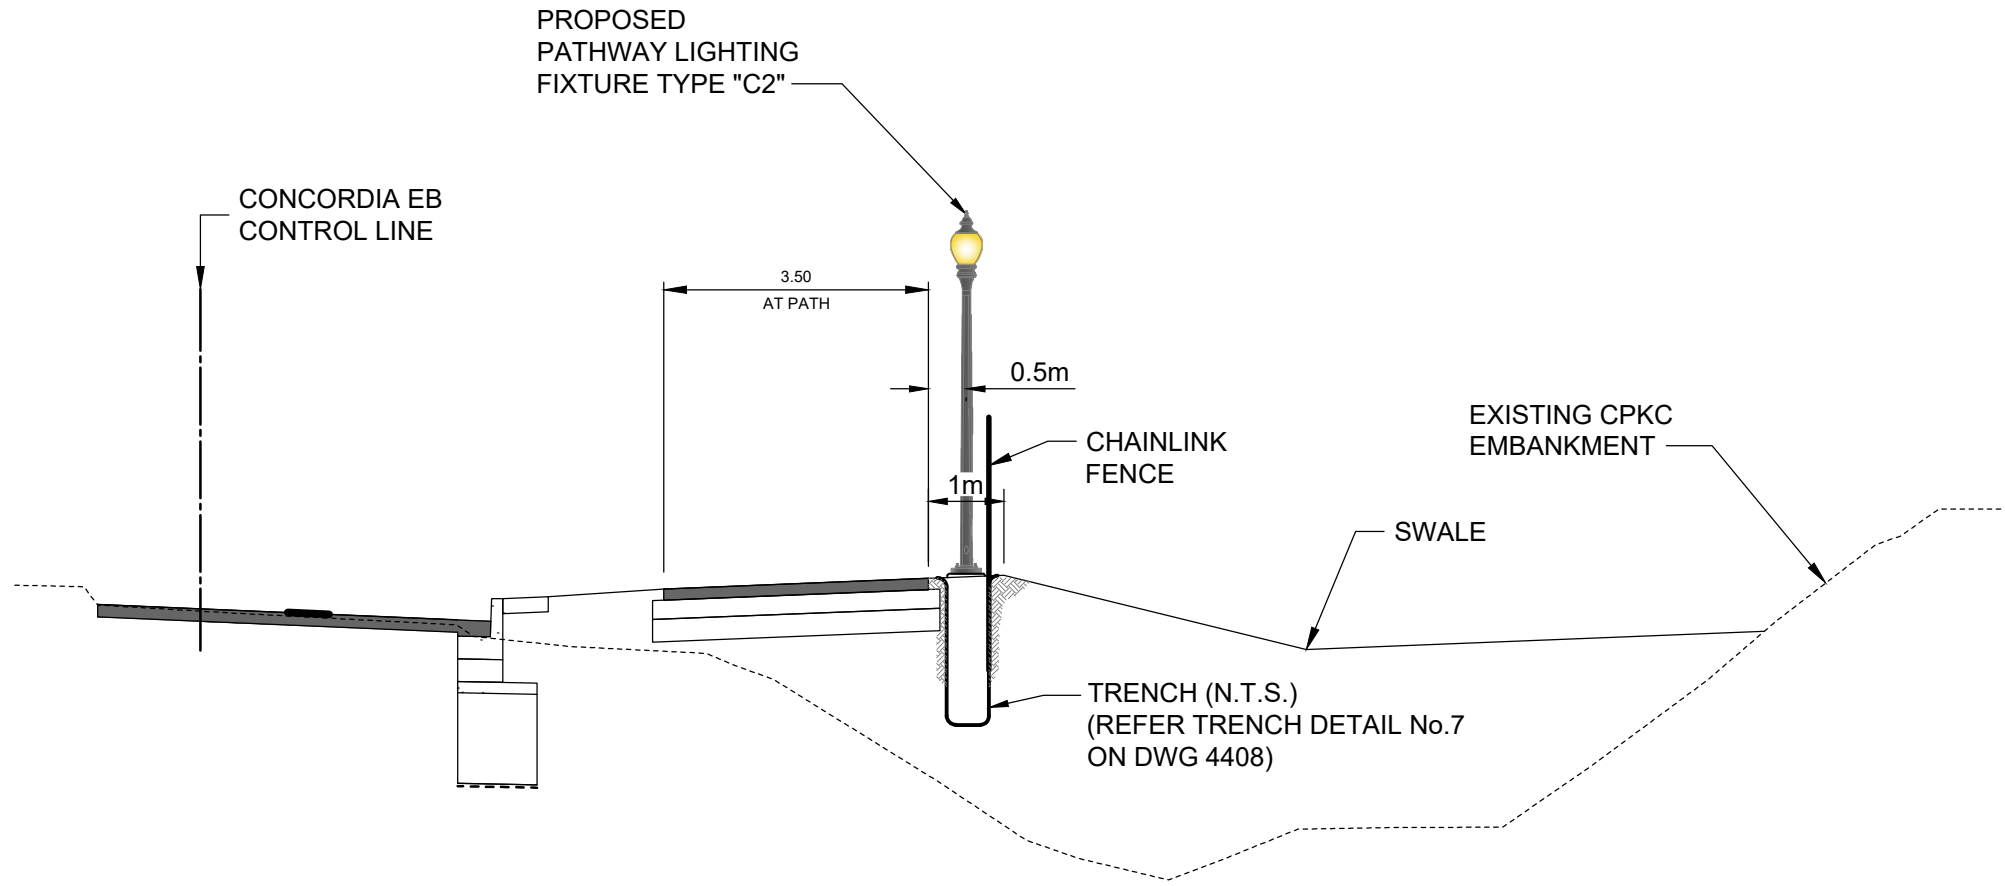

GENERAL NOTES:

- THE LOCATION AND ROUTING OF ALL PROPOSED CSTE'S, LIGHTING FIXTURES, AND CONDUIT/TRENCH LINES SHOWN ON THIS DRAWING ARE FOR SCHEMATIC PURPOSES ONLY. REFER TO PAVING AND GRADING PLANS FOR INTENDED LOCATIONS.


- CONTRACTOR TO DETERMINE FINAL ALIGNMENT OF CONDUIT/TRENCH IN THE FIELD, SUBJECT TO APPROVAL BY THE CONTRACT ADMINISTRATOR.

- ALL UNDERGROUND CONDUIT INSTALLATIONS SHALL BE BY THE HORIZONTAL DIRECTIONAL DRILLING (HDD) METHOD WITH THE EXCEPTION OF TRENCHING SECTIONS REQUIRING THE EXPOSURE OF EXISTING UNDERGROUND UTILITIES WHEREBY THE OPEN CUT TRENCHING METHOD SHALL BE UTILIZED. CONTRACTOR SHALL CONFIRM PRECISE LOCATIONS OF ALL HDD AND OPEN CUT TRENCHING SECTIONS PRIOR TO COMMENCEMENT OF WORK AND OBTAIN FORMAL APPROVAL FROM SITE INSPECTOR AND ENGINEER FOR ALL OPEN CUT TRENCHING.

- COORDINATE WITH MANITOBA HYDRO STREET LIGHTING DEPARTMENT FOR THE PROVISION OF A NEW 100A, 1Ø, 3W, 120/240V UNDERGROUND POWER SERVICE TO NEW CSTE "C". PRIOR TO COMMENCEMENT OF WORK CONTRACTOR TO FINALIZE ARRANGEMENTS WITH MANITOBA HYDRO INCLUDING STAKING FINAL GRADES OF THE AREA IN ADDITION TO CONFIRMING LOCATIONS OF UTILITY SERVICE POLE(S), TRANSFORMERS, ROUTING OF UNDERGROUND UTILITY POWER SERVICE CONDUCTORS, TRENCHING AND BACKFILLING, ETC. ALL WORK SHALL BE IN ACCORDANCE WITH MANITOBA HYDRO CUSTOMER METERING STANDARDS. 3. RD. EDITION. AUGUST 1, 2015.

- MAINTAIN 1.0 METER (MIN.) SEPARATION BETWEEN MB HYDRO U/G UTILITY SERVICE CONDUCTORS AND CUSTOMER'S SUPPLIED U/G SITE LIGHTING CIRCUIT POWER FEEDER CONDUCTORS. NO SHARING TRENCHING SHALL BE PERMITTED.



B.M. ELEV.				<div> TETRA TECH</div>			
				DESIGNED BY	DWD	CHECKED BY	DWD
				DRAWN BY	ABA	APPROVED BY	JNC
1	ISSUED FOR ADDENDUM 5	25.09.22	DWD	HOR. SCALE: AS NOTED		ACCEPTED BY	DATE
0	ISSUED FOR TENDER	25.08.07	DWD	VERTICAL:		CAM WARD, P.ENG.	25.08.07
NO.	REVISIONS	DATE	BY	DATE 25.08.07			



LAGIMODIERE TWIN OVERPASSES OVER CONCORDIA AVE. & CPR KEEWATIN REHABILITATION AND RELATED WORKS		CITY DRAWING NUMBER P123-25-4404
ACTIVE TRANSPORTATION - CONCORDIA AVE E PATHWAY LIGHTING LAGIMODIERE OVERPASS TO PEGUIS ST.		4404