


DR. JOSIE RIZAL WAY

- GENERAL NOTES:
1. VERIFY LOCATIONS OF UTILITIES AND PROTECT ALL ELECTRICAL EQUIPMENT AGAINST DAMAGE DURING CONSTRUCTION.
 2. COORDINATE POLE BASE AND POWER LOCATIONS WITH CIVIL AND LANDSCAPE DRAWINGS.
 3. TRENCHLINE IS SHOWN FOR APPROXIMATE ROUTING. CONTRACTOR SHALL CONFIRM AND COORDINATE ROUTING OF CONDUIT WITH SITE CONDITIONS.
 4. ELECTRICAL TRENCH INSTALL ATLEAST 1m AWAY FROM GAS LINE AS SHOWN.

1 OLD COMMONWEALTH - ELECTRICAL SITE PLAN
Scale: 1:250

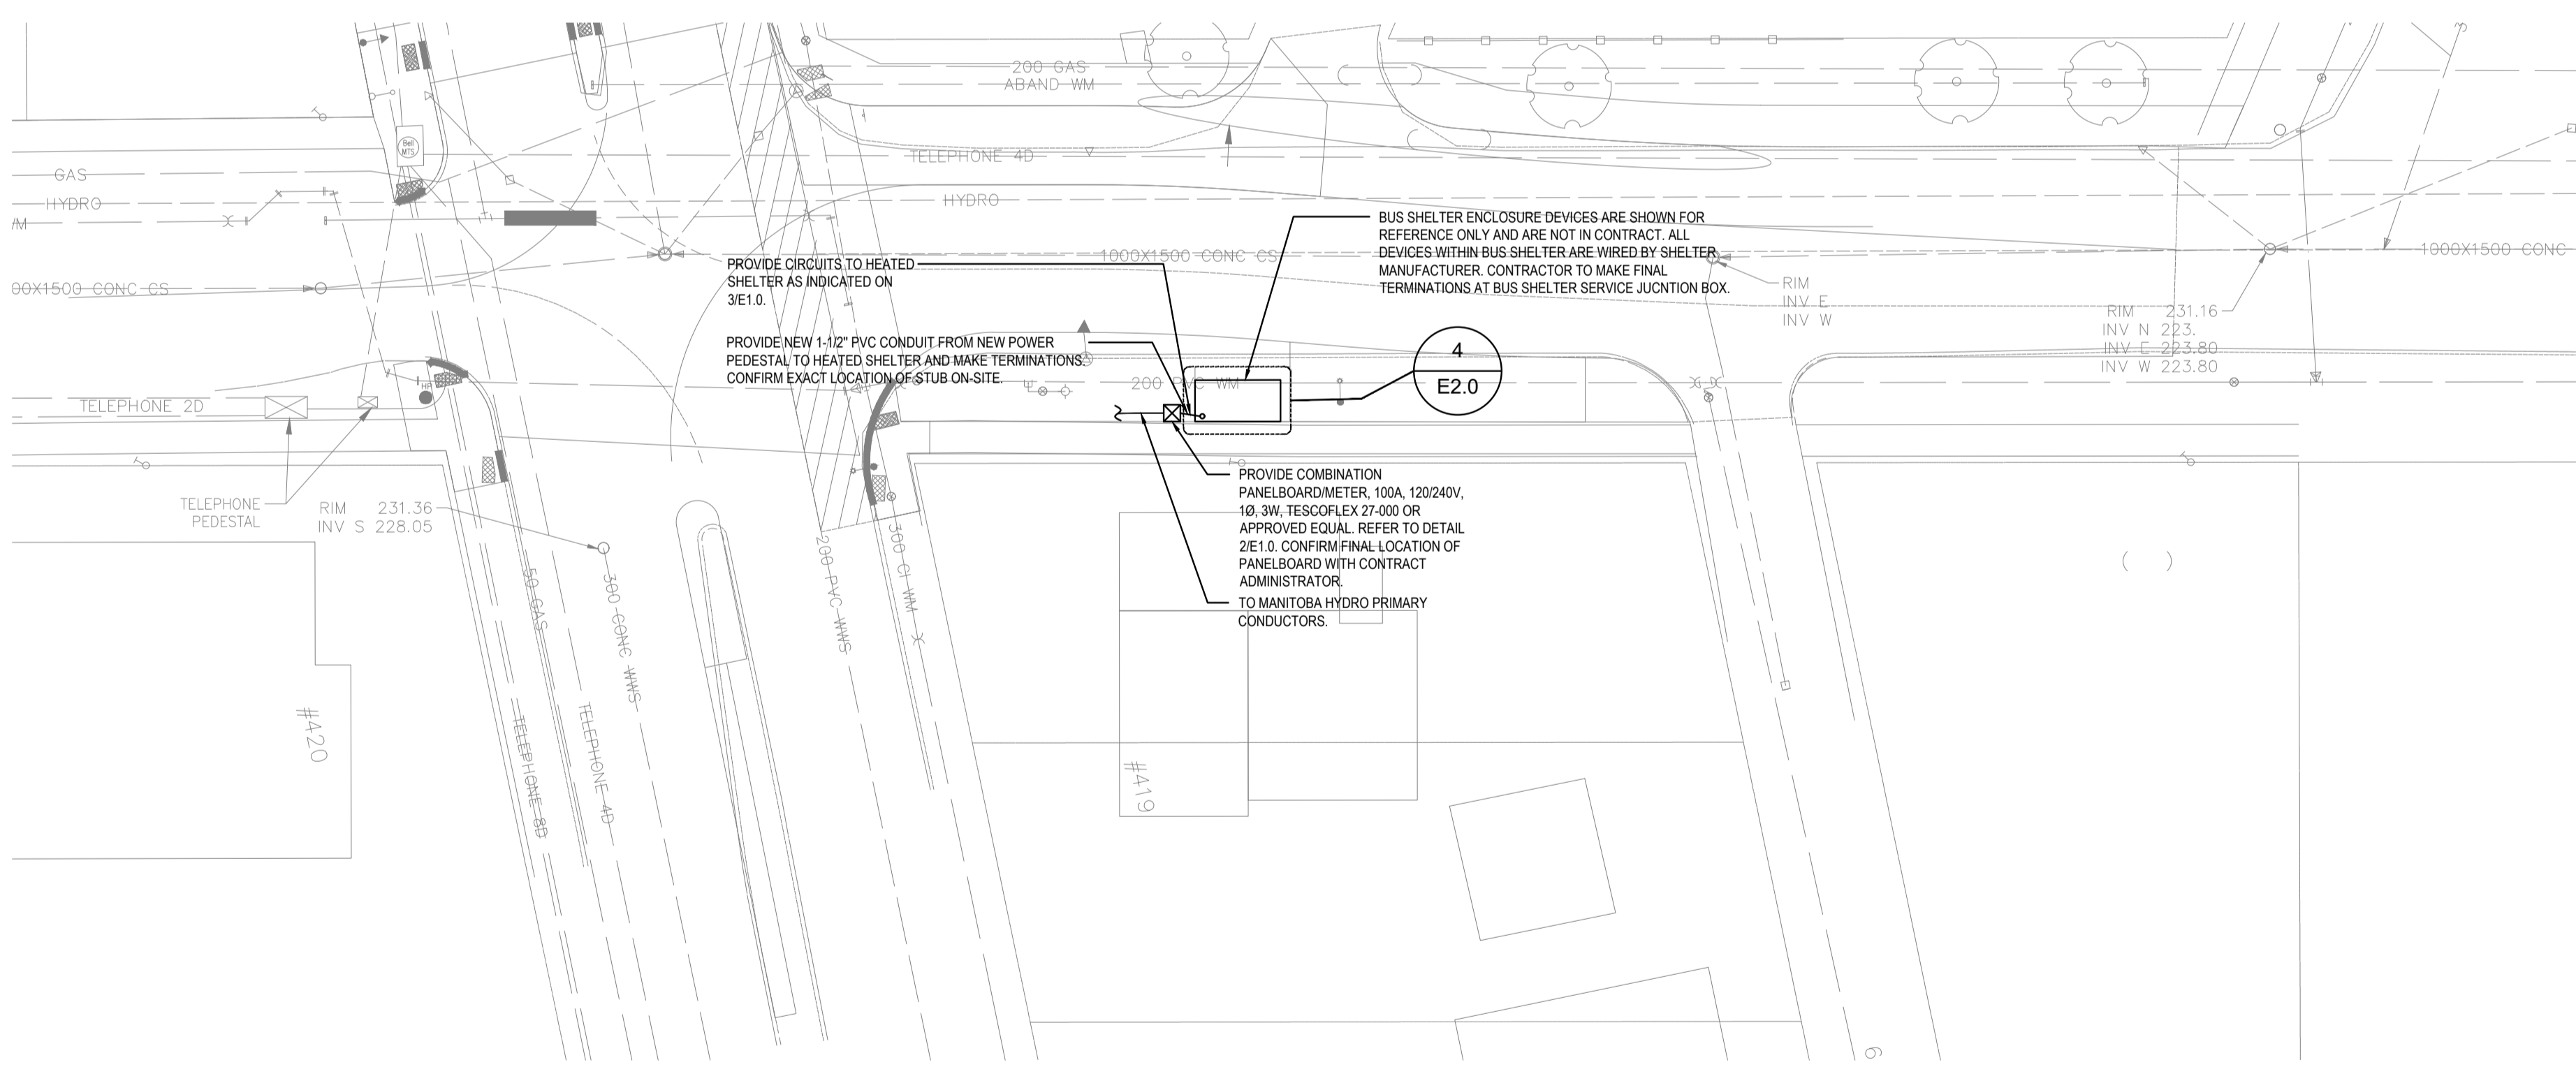

2 CARRIERE AVE - ELECTRICAL SITE PLAN
Scale: 1:250



MCW Consultants Ltd.
 Vancouver Calgary
 Edmonton Dauphin
 Winnipeg Toronto
 Thunder Bay
 Ottawa Moncton
 Saint John Truro
 Halifax

210-1821 Wellington Avenue
 Winnipeg, Manitoba
 R3H 0G4
 Tel: 204-779-7900
 Fax: 204-779-1119
 www.mcw.com

LOCATIONS APPROVED UNDERGROUND STRUCTURES

SIGNED BY: _____ DATE: _____

SUPV UG STRUCTURES _____ DATE: _____

LOCATION OF UNDERGROUND STRUCTURES AS SHOWN ARE BASED ON THE BEST INFORMATION AVAILABLE BUT NO GUARANTEE IS GIVEN THAT ALL EXISTING UTILITIES ARE SHOWN OR THAT THE GIVEN LOCATIONS ARE EXACT CONFIRMATION OF EXISTANCE AND EXACT LOCATION OF ALL SERVICES MUST BE OBTAINED FROM THE INDIVIDUAL UTILITIES BEFORE PROCEEDING

NO.	ISSUED FOR TENDER	DATE	BY
0	ISSUED FOR TENDER	2025-02-18	MJB

DESIGNED BY	JDV	CHECKED BY	MJB
DRAWN BY	JDV	APPROVED BY	MJB
HOR. SCALE		RELEASED FOR CONSTRUCTION	
VERTICAL		DATE	2025-02-18

WSP Canada Inc.
 1600 Buffalo Place
 Winnipeg, MB R3T 6B8
 t. 204.477.6650
 f. 204.474.2864
 www.wsp.com

PROVINCE OF MANITOBA
M. J. BORODY
 Member
 36277
 2025-02-18
 REGISTERED PROFESSIONAL ENGINEER

CONSULTANT ACAD DWG. NO.
 E3.0

THE CITY OF WINNIPEG
 PUBLIC WORKS DEPARTMENT
 ENGINEERING SERVICES DIVISION

2025 TRANSIT INFRASTRUCTURE IMPROVEMENTS
 VARIOUS LOCATIONS - ELECTRICAL

TRANSIT INFRASTRUCTURE IMPROVEMENTS

CITY DRAWING NUMBER
 SHEET 12 OF 12
 TENDER NO.
 33-2025