


GENERAL NOTES:

1. EXISTING UPSTREAM DISTRIBUTION IS NOT INCLUDED IN SCOPE OF WORK. REFER TO AS BUILT DRAWING 02-E-002, REVISION 11, DATED 2020-05-01 FOR UPSTREAM DISTRIBUTION INFORMATION AND CONFIRM ON SITE.
2. EXISTING LOADS NOT VERIFIED. FOR EXISTING LOAD INFORMATION REFER TO AS BUILT DRAWING 02-E-0003, REVISION 14, DATED 2020-07-22 AND CONFIRM ON SITE.
3. EXISTING LOADS NOT VERIFIED. FOR EXISTING LOAD INFORMATION REFER TO AS BUILT DRAWING 02-E-0004, REVISION 10, DATED 2020-05-01 AND CONFIRM ON SITE.
4. SPLICE AND EXTEND EXISTING CONNECTED INCOMING FEEDER AND ALL OUTGOING BRANCHES AS REQUIRED TO SUIT NEW LOCATION OF EXISTING PANELS. CONFIRM ON SITE AND MATCH CABLES'S GAUGE AND TYPE TO EXISTING.
5. PROJECTED LOAD AS PROVIDED BY AZOLLA IS 400A.
6. PROJECTED LOAD AS PROVIDED BY AZOLLA IS 130A.
7. INSTALL UNDERGROUND CABLE AS PER CSA C22.1, TABLE D10A, DIAGRAM D10 DETAIL 2.
8. INSTALL UNDERGROUND CABLE AS PER CSA C22.1, TABLE D10A, DIAGRAM D10 DETAIL 1.

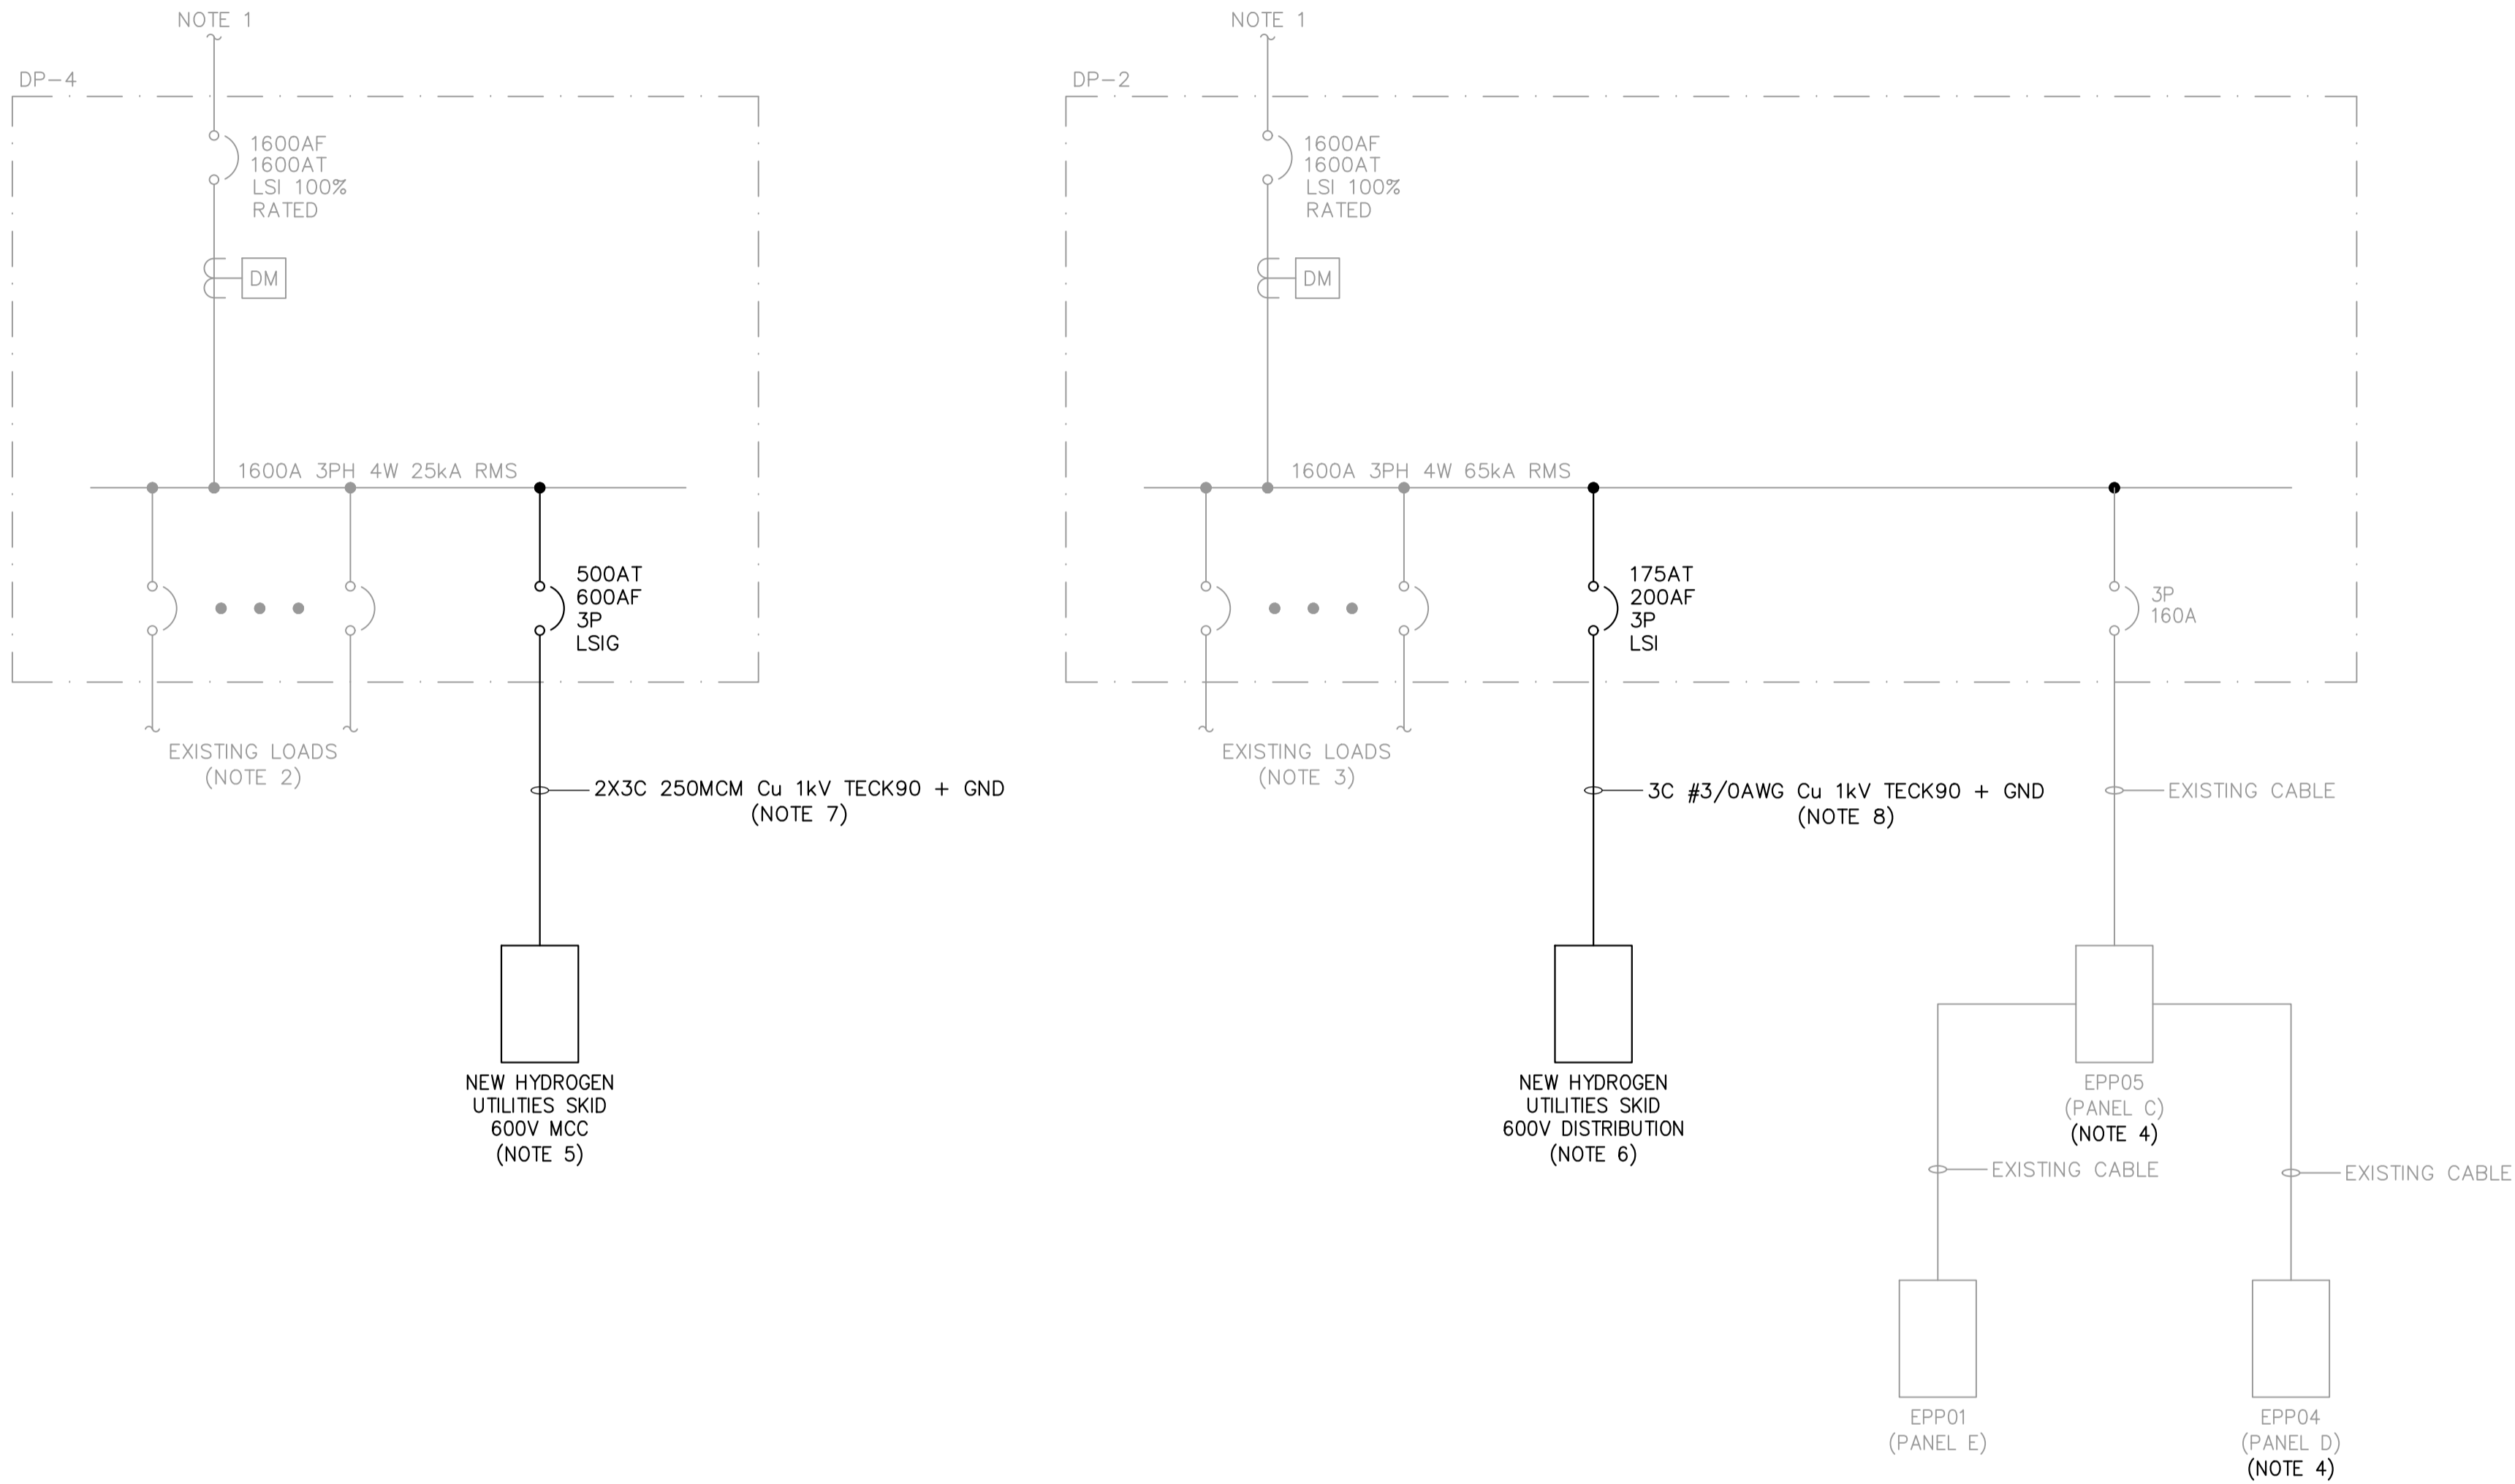

10	-	-
9	-	-
8	-	-
7	-	-
6	-	-
5	-	-
4	-	-
3	-	-
2	-	-
1	-	-
NO.	DRAWING NUMBER	REFERENCE DRAWING TITLE
REFERENCE DRAWINGS		



B.M. ELEV.			
CONSTRUCTION COMPLETION DATE: YYYY MM DD			
0	ISSUED FOR CONSTRUCTION	2025 07 08	
NO.	REVISIONS	DATE	BY

<b>KGS</b> GROUP	
DESIGNED BY	KO
CHECKED BY	
DRAWN BY	DIS
APPROVED BY	
SCALE:	AS SHOWN
DATE	2024 08 27
DATE	

ENGINEER'S SEAL	
CONSULTANT DRAWING NUMBER	
24-0107-04_E01	

		THE CITY OF WINNIPEG	
		TRANSIT DEPARTMENT ENGINEERING DIVISION	
		WINNIPEG TRANSIT – FORT ROUGE FACILITY HYDROGEN REFUELLING STATION ELECTRICAL PARTIAL SINGLE LINE DIAGRAM	
CITY DRAWING NUMBER		465-2025-E0001	SHEET 1 OF 1