




1 CABLE TRENCH DETAIL – 1 CABLE
SCALE: N.T.S.

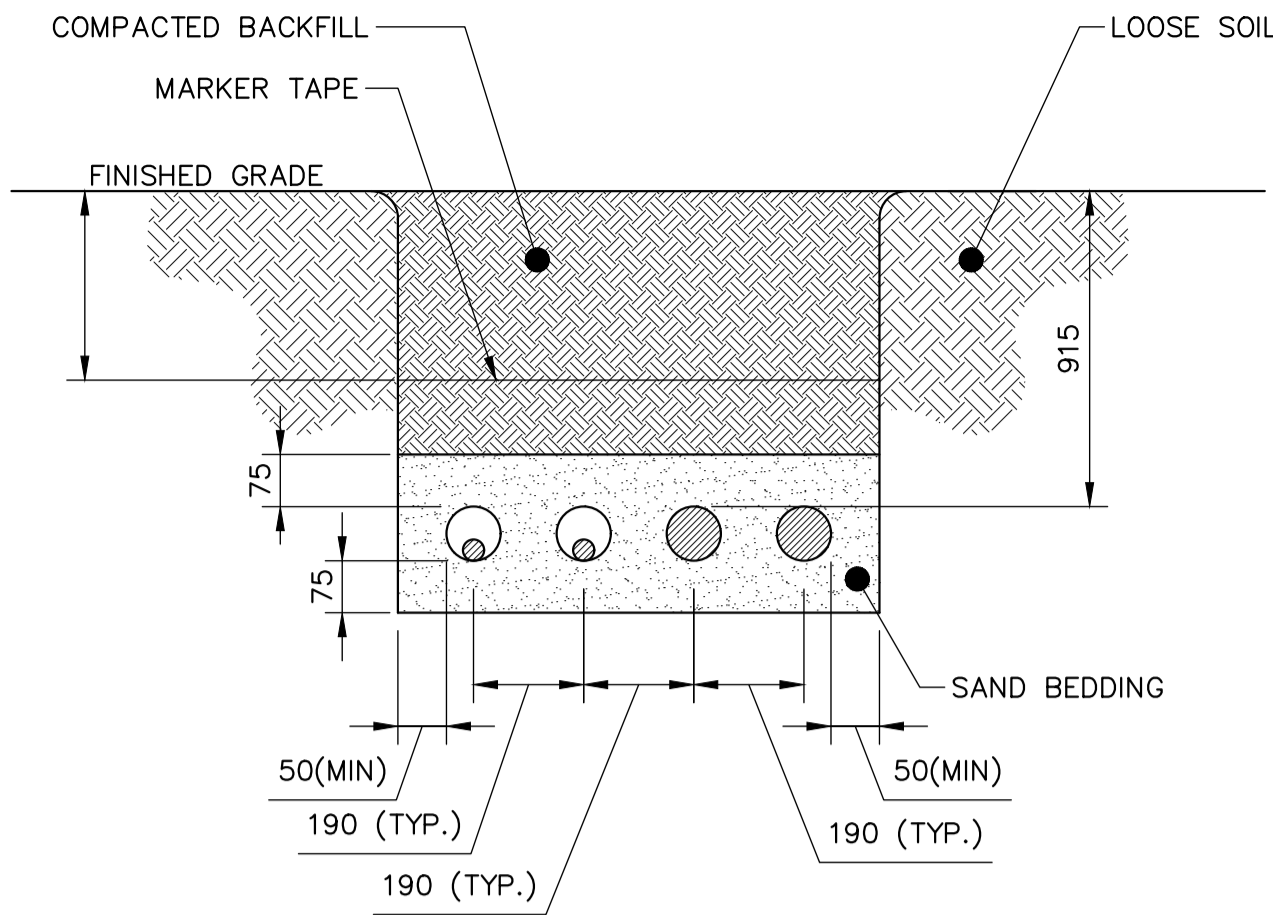

2 CABLE TRENCH DETAIL – 4 CABLES
SCALE: N.T.S.

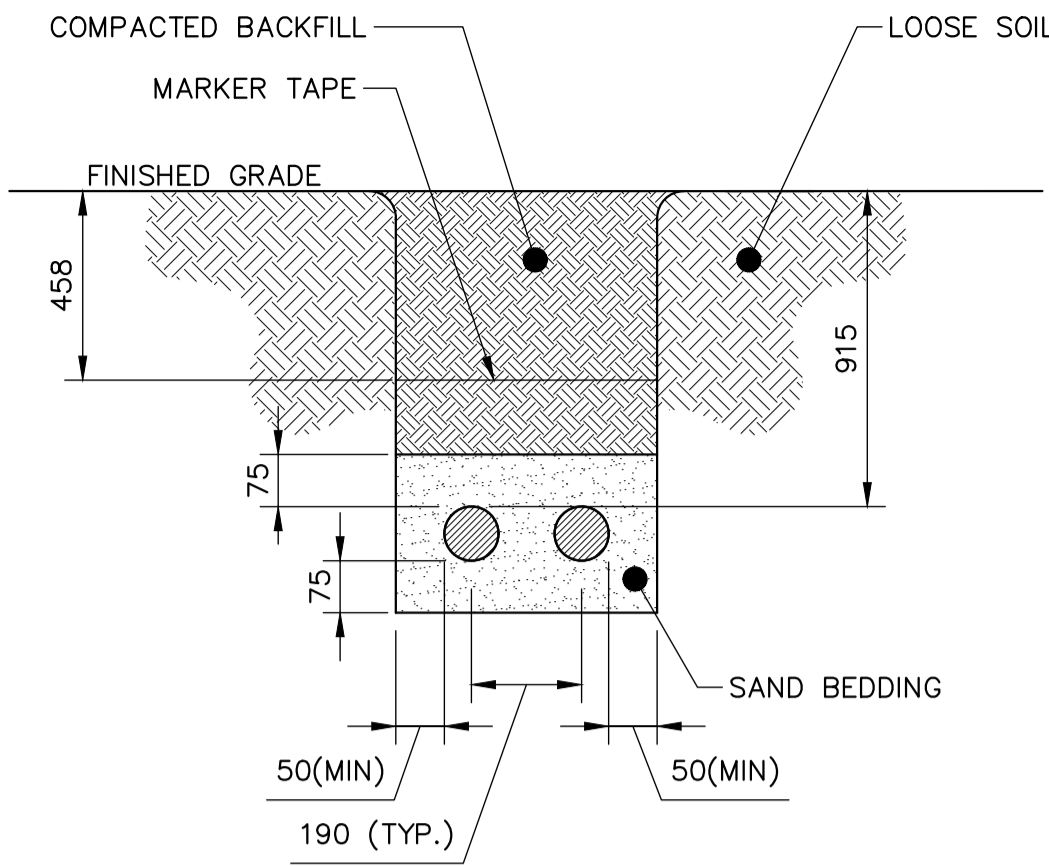

3 CABLE TRENCH DETAIL – 2 CABLES
SCALE: N.T.S.

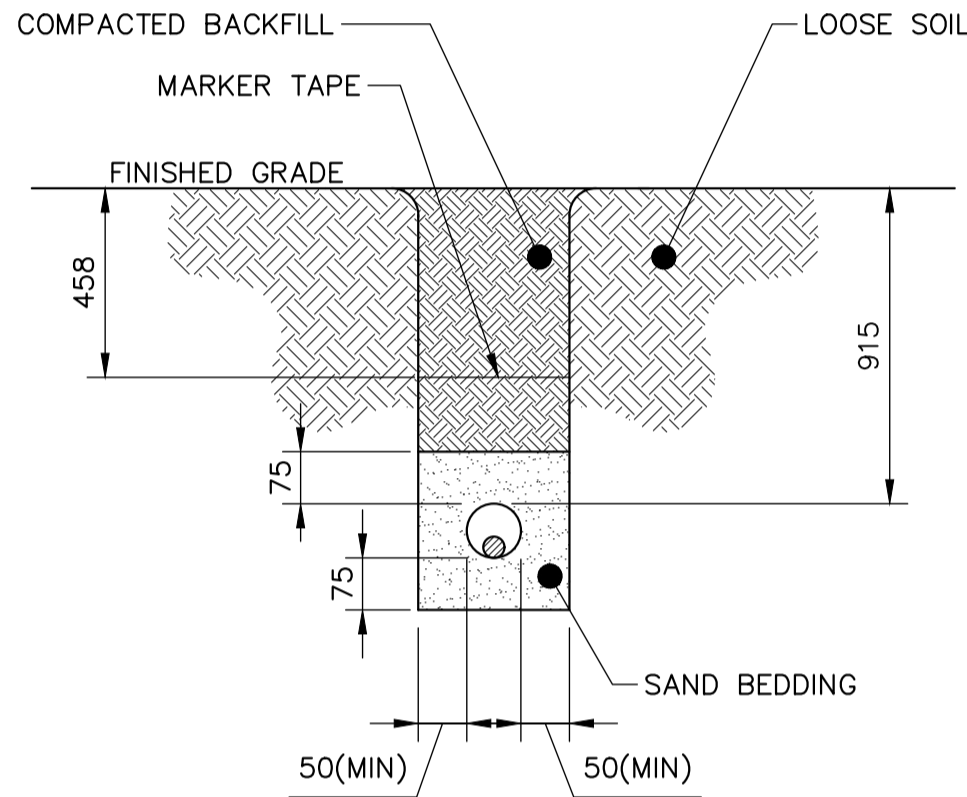

4 CABLE TRENCH DETAIL – 1 CABLE
SCALE: N.T.S.

GENERAL NOTES:
1. GROUNDING CABLES FROM DPs NOT SHOWN. ADJUST TRENCH WIDTH TO SUIT.


10	–	–
9	–	–
8	–	–
7	–	–
6	–	–
5	–	–
4	–	–
3	–	–
2	–	–
1	–	–
NO.	DRAWING NUMBER	REFERENCE DRAWING TITLE
REFERENCE DRAWINGS		



B.M. ELEV.			
CONSTRUCTION COMPLETION DATE: YYYY MM DD			
NO.	REVISIONS	DATE	BY
0	ISSUED FOR CONSTRUCTION	2025 07 08	

KGS GROUP	
DESIGNED BY	CLR
CHECKED BY	
DRAWN BY	DIS
APPROVED BY	
SCALE:	AS SHOWN
RELEASED FOR CONSTRUCTION	
DATE	2024 07 22
DATE	

ENGINEER'S SEAL
CONSULTANT DRAWING NUMBER
24-0107-04_E03

 THE CITY OF WINNIPEG TRANSIT DEPARTMENT ENGINEERING DIVISION	
WINNIPEG TRANSIT – FORT ROUGE FACILITY HYDROGEN REFUELLING STATION ELECTRICAL DETAILS	
CITY DRAWING NUMBER	465-2025-E0003
SHEET	1 OF 1