




THE CITY OF WINNIPEG
TRANSIT DEPARTMENT

WINNIPEG TRANSIT – FORT ROUGE FACILITY HYDROGEN REFUELLING STATION

BID OPPORTUNITY NO.: 465–2025

421 OSBORNE STREET
WINNIPEG, MANITOBA

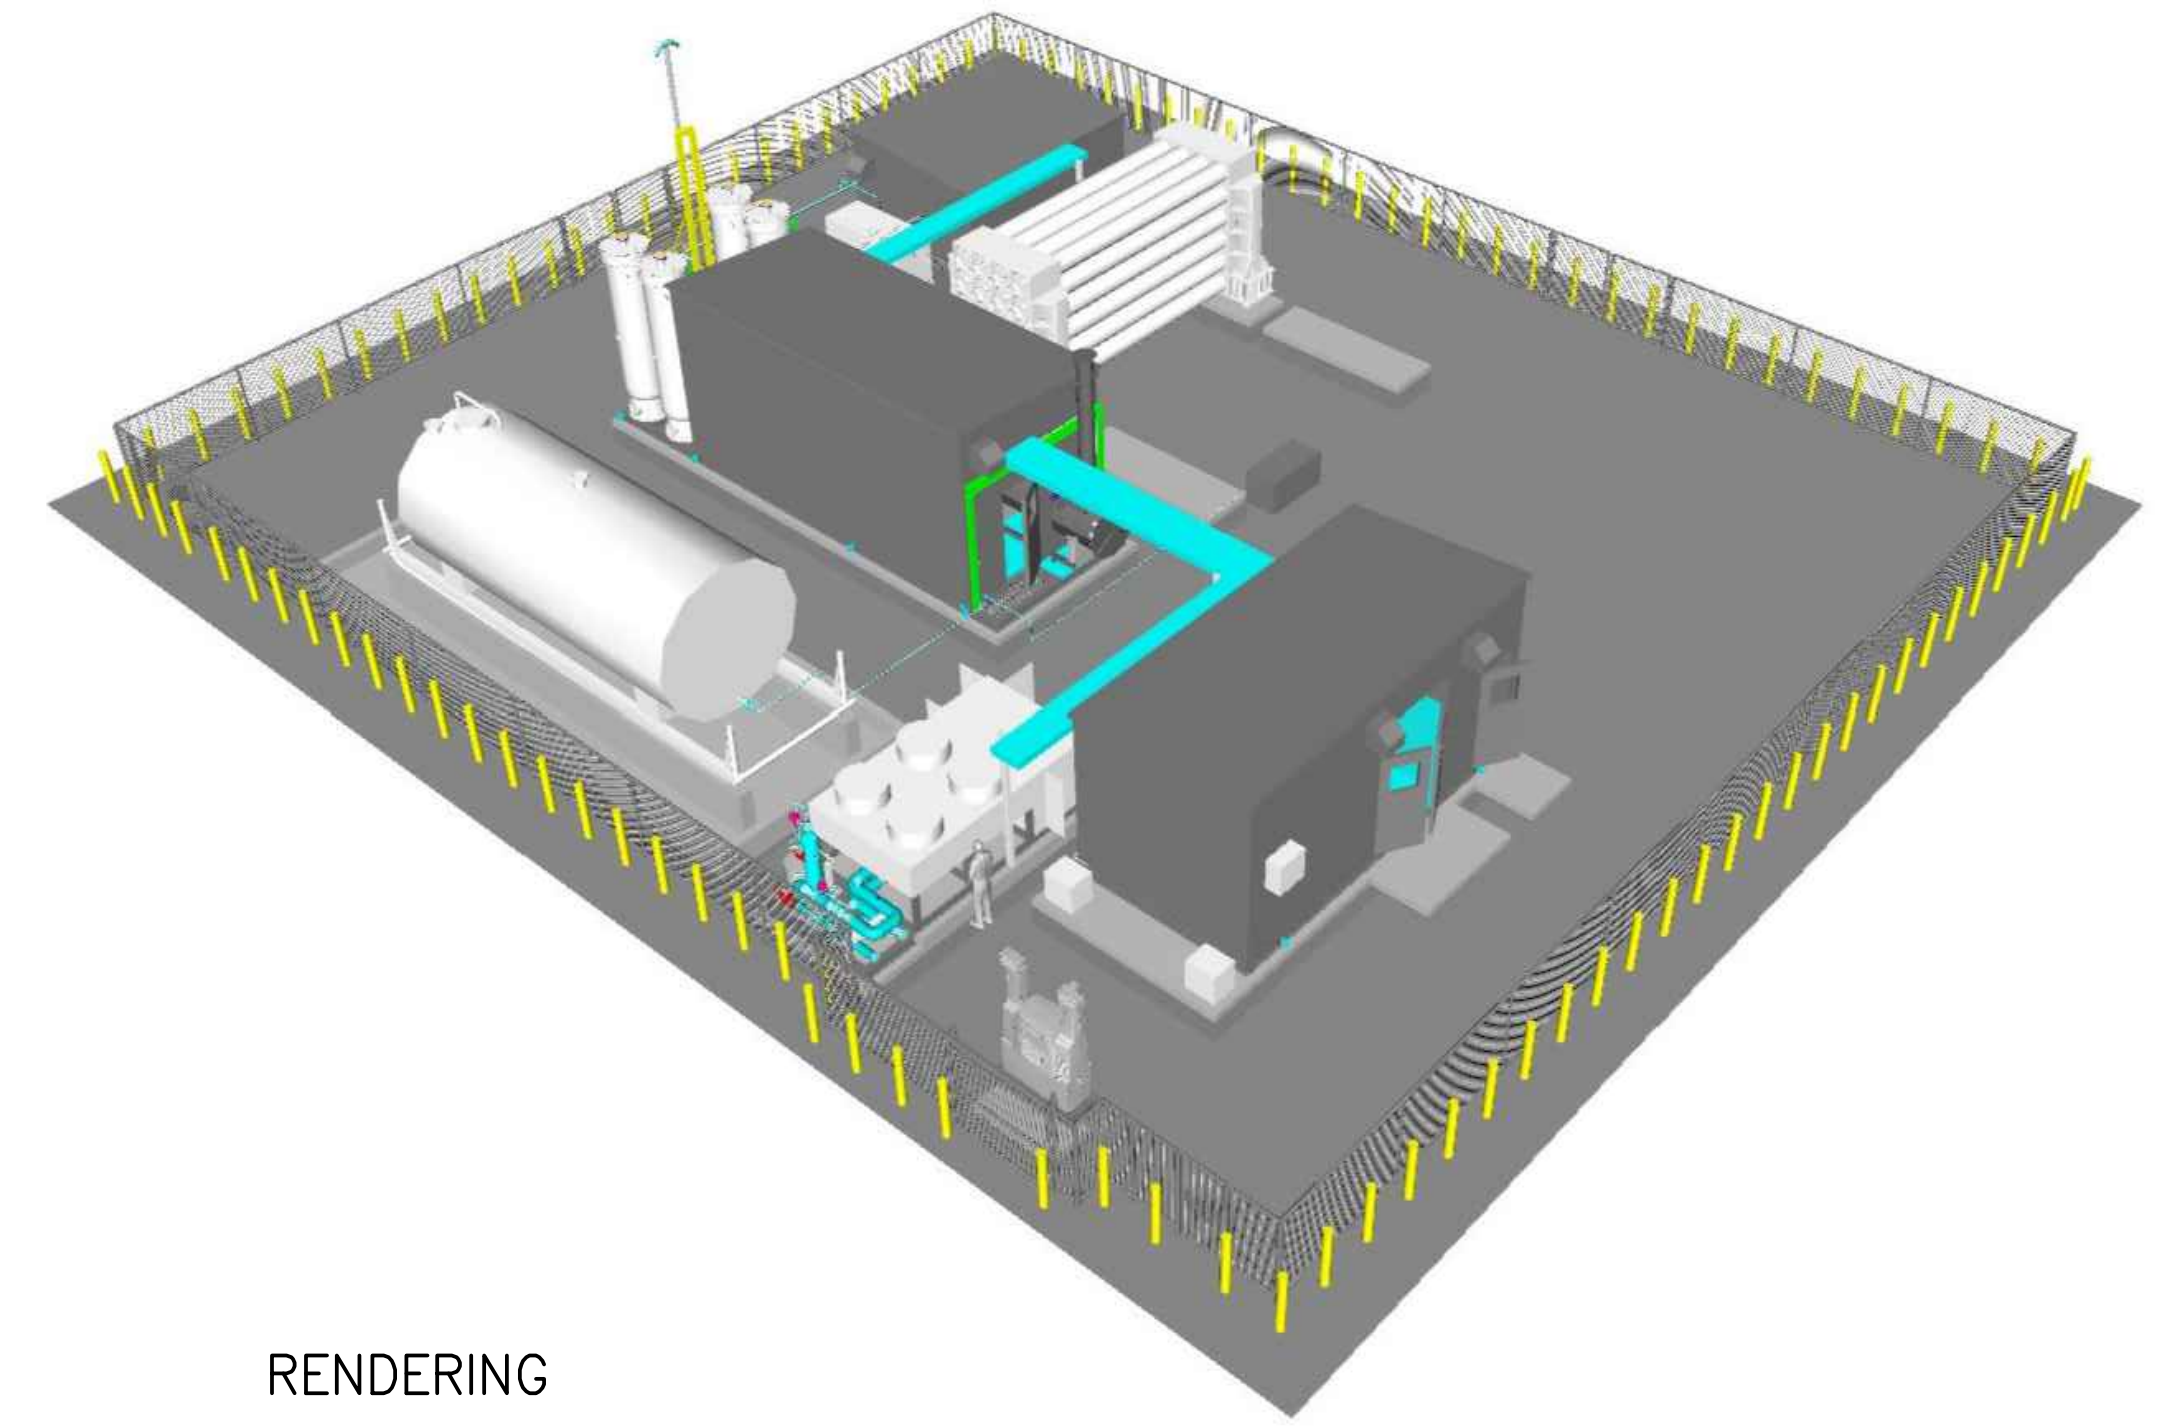

RENDERING

GENERAL	
465–2025–G00	COVER SHEET

MUNICIPAL	
465–2025–C0001	EXISTING SITE PLAN
465–2025–C0002	TOPOGRAPHIC SURVEY
465–2025–C0003	PROPOSED SITE SERVICING PLAN
465–2025–C0004	PROPOSED LOT GRADING PLAN
465–2025–C0005	DETAILS
465–2025–C0006	BUS TURNING MOVEMENTS

STRUCTURAL	
465–2025–S0000	GENERAL NOTES
465–2025–S0001	SITE PLAN
465–2025–S0002	GENERAL ARRANGEMENT PLAN
465–2025–S0003	FOUNDATION PLAN
465–2025–S0004	PLAN DETAILS
465–2025–S0005	SECTIONS & DETAILS
465–2025–S0006	FENCE & BOLLARD DETAILS

ELECTRICAL	
465–2025–E0000	LEGEND
465–2025–E0001	PARTIAL SINGLE LINE DIAGRAM
465–2025–E0002	SITE PLAN
465–2025–E0003	DETAILS
465–2025–E0004	SPECIFICATIONS – SHEET 1
465–2025–E0005	SPECIFICATIONS – SHEET 2

10	–	–
9	–	–
8	–	–
7	–	–
6	–	–
5	–	–
4	–	–
3	–	–
2	–	–
1	–	–
NO.	DRAWING NUMBER	REFERENCE DRAWING TITLE
REFERENCE DRAWINGS		



B.M. ELEV.			
CONSTRUCTION COMPLETION DATE: YYYY MM DD			
0	ISSUED FOR CONSTRUCTION	2025 07 08	
NO.	REVISIONS	DATE	BY

KGS GROUP	
DESIGNED BY	MEL
CHECKED BY	
DRAWN BY	FBV
APPROVED BY	
SCALE:	N.T.S.
RELEASED FOR CONSTRUCTION	
DATE	2025 02 27
DATE	

ENGINEER'S SEAL	
CONSULTANT DRAWING NUMBER	
24–0107–010_G00	

		THE CITY OF WINNIPEG	
		TRANSIT DEPARTMENT ENGINEERING DIVISION	
WINNIPEG TRANSIT – FORT ROUGE FACILITY HYDROGEN STATION			
COVER SHEET			
CITY DRAWING NUMBER		465–2025–G00	SHEET 1 OF 1