
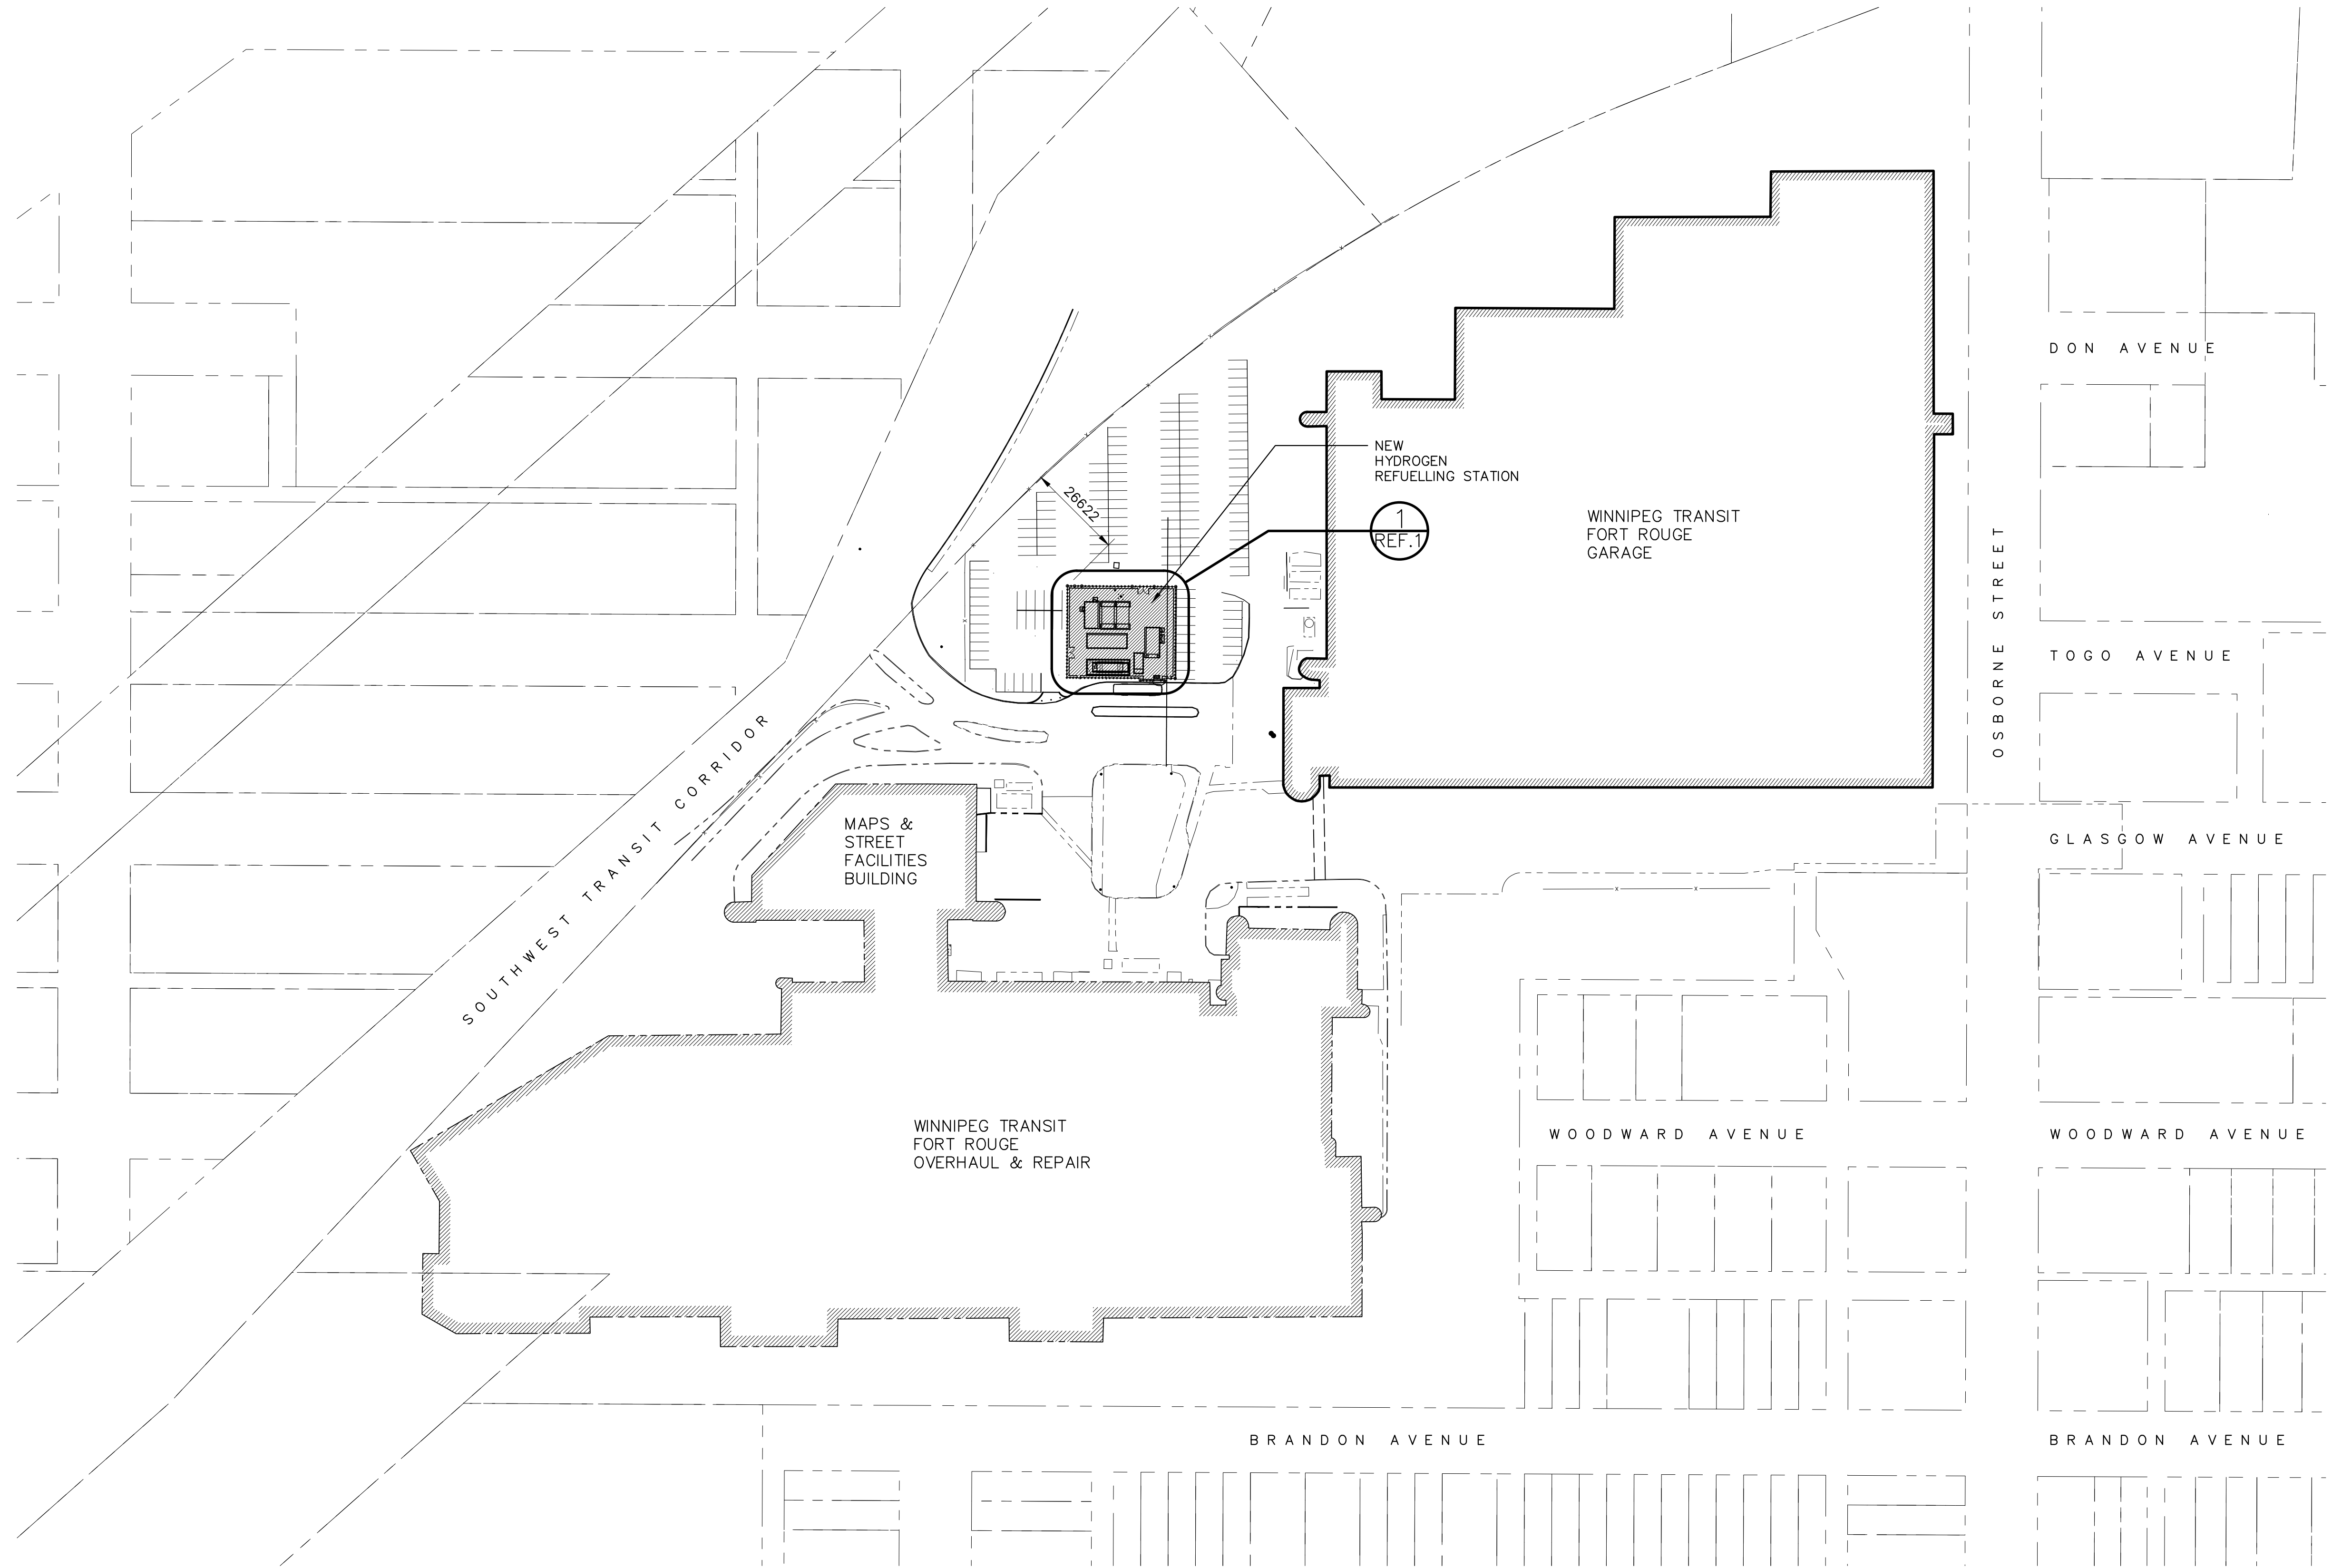


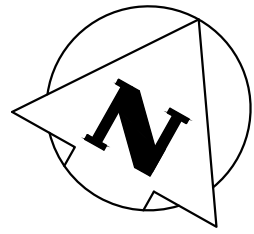

SITE PLAN  
SCALE: 1:1000

|                    |                |                          |
|--------------------|----------------|--------------------------|
| 10                 | —              | —                        |
| 9                  | —              | —                        |
| 8                  | —              | —                        |
| 7                  | —              | —                        |
| 6                  | —              | —                        |
| 5                  | —              | —                        |
| 4                  | —              | —                        |
| 3                  | —              | —                        |
| 2                  | —              | —                        |
| 1                  | 465-2025-S0002 | GENERAL ARRANGEMENT PLAN |
| NO.                | DRAWING NUMBER | REFERENCE DRAWING TITLE  |
| REFERENCE DRAWINGS |                |                          |

**ENGINEERS  
GEOSCIENTISTS  
MANITOBA**

Certificate of Authorization  
**KGS Group**  
No. 245

|                                          |                         |            |    |
|------------------------------------------|-------------------------|------------|----|
| B.M.<br>ELEV.                            |                         |            |    |
| CONSTRUCTION COMPLETION DATE: YYYY MM DD |                         |            |    |
|                                          |                         |            |    |
|                                          |                         |            |    |
|                                          |                         |            |    |
|                                          |                         |            |    |
|                                          |                         |            |    |
| 0                                        | ISSUED FOR CONSTRUCTION | 2025 07 08 |    |
| NO.                                      | REVISIONS               | DATE       | BY |

|                      |            |                           |  |
|----------------------|------------|---------------------------|--|
| <b>KGS<br/>GROUP</b> |            |                           |  |
| DESIGNED BY          | MEL        | CHECKED BY                |  |
| DRAWN BY             | MRB        | APPROVED BY               |  |
| SCALE:               | AS SHOWN   | RELEASED FOR CONSTRUCTION |  |
| DATE                 | 2025 03 28 | DATE                      |  |

|                           |  |
|---------------------------|--|
| ENGINEER'S SEAL           |  |
| CONSULTANT DRAWING NUMBER |  |
| 24-0107-004_S01           |  |

**THE CITY OF WINNIPEG**  
TRANSIT DEPARTMENT  
ENGINEERING DIVISION

WINNIPEG TRANSIT – FORT ROUGE FACILITY  
HYDROGEN REFUELLING STATION

**STRUCTURAL  
SITE PLAN**

CITY DRAWING NUMBER

465-2025-S0001

SHEET 1 OF 1