


LEGEND

- STANDARD BOLLARD
- C40 IMPACT BOLLARD
- REMOVABLE BOLLARD

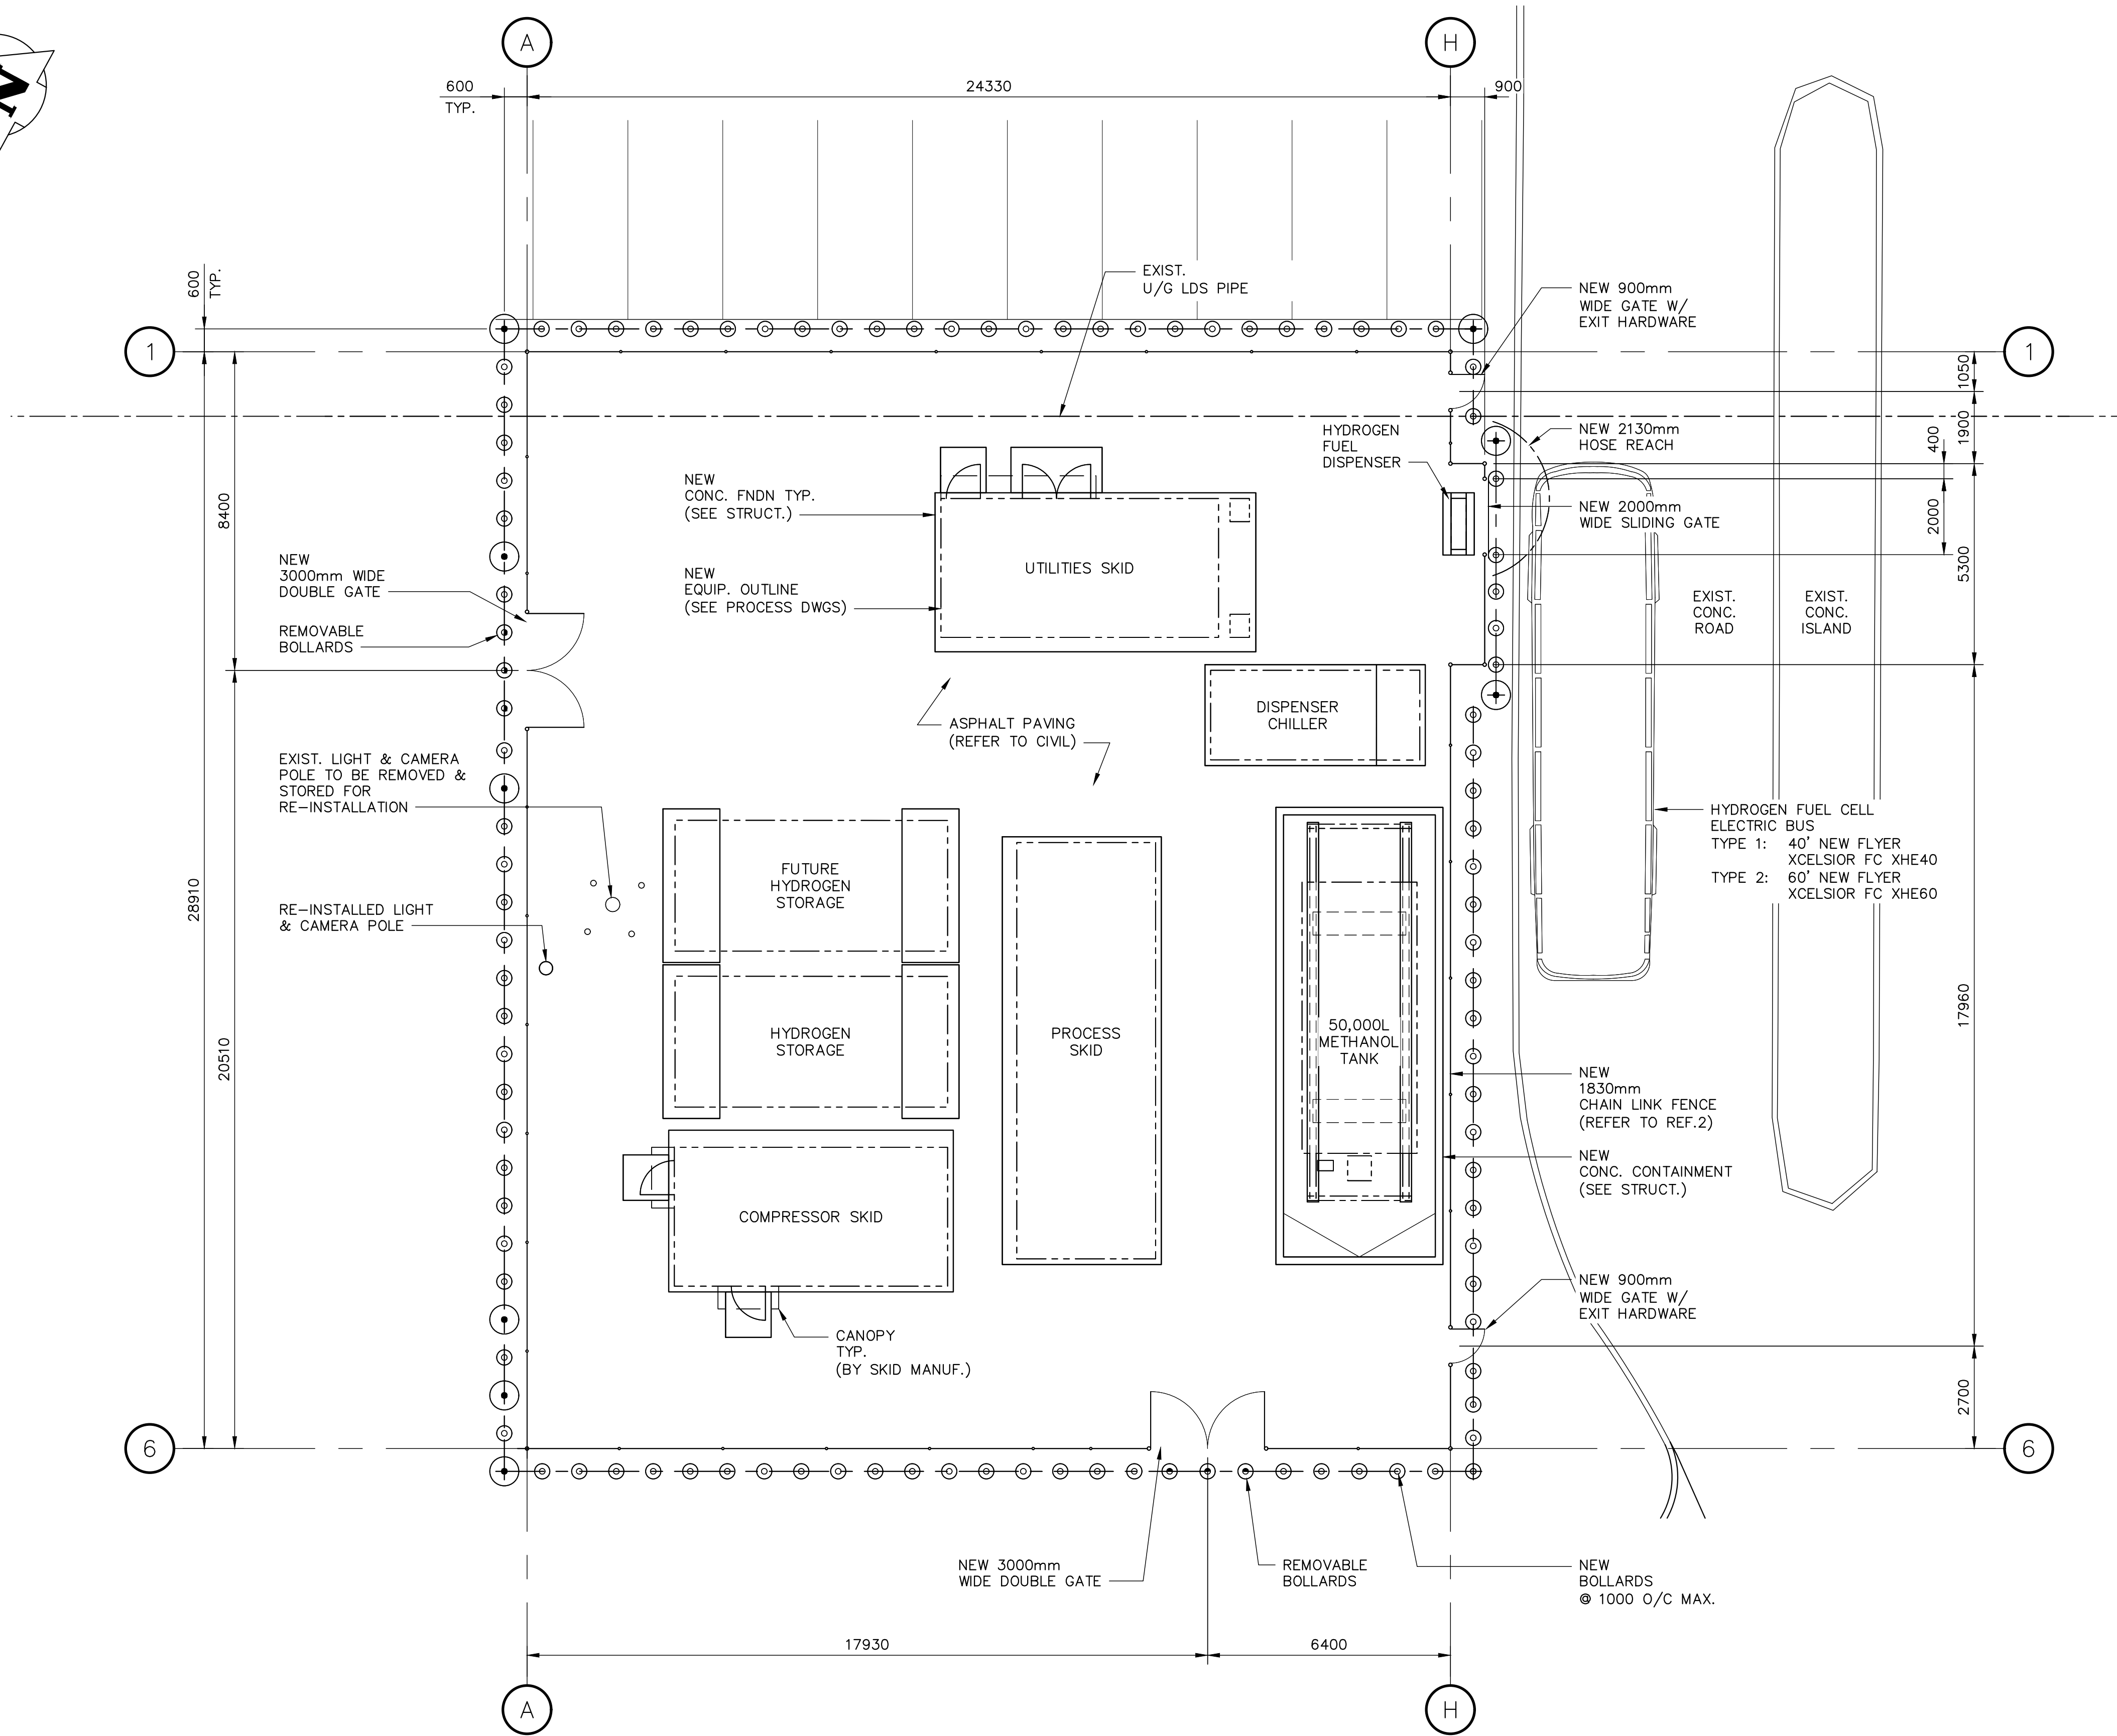

1 GENERAL ARRANGMENT PLAN
REF.1 SCALE: 1:100

10	—	—
9	—	—
8	—	—
7	—	—
6	—	—
5	—	—
4	—	—
3	—	—
2	465-2025-S0006	FENCE & BOLLARD DETAILS
1	465-2025-S0001	SITE PLAN
NO.	DRAWING NUMBER	REFERENCE DRAWING TITLE
REFERENCE DRAWINGS		



B.M. ELEV.			
CONSTRUCTION COMPLETION DATE: YYYY MM DD			
0	ISSUED FOR CONSTRUCTION	2025 07 08	
NO.	REVISIONS	DATE	BY

KGS GROUP			
DESIGNED BY	MEL	CHECKED BY	
DRAWN BY	SNH	APPROVED BY	
SCALE:	AS SHOWN	RELEASED FOR CONSTRUCTION	
DATE	2025 03 27	DATE	
PLOT DATE: 2025 07 08			

ENGINEER'S SEAL	
CONSULTANT DRAWING NUMBER	
24-0107-004_S02	

	THE CITY OF WINNIPEG	
	TRANSIT DEPARTMENT ENGINEERING DIVISION	
	WINNIPEG TRANSIT – FORT ROUGE FACILITY HYDROGEN REFUELLING STATION	
STRUCTURAL GENERAL ARRANGEMENT PLAN		
CITY DRAWING NUMBER	465–2025–S0002	SHEET 1 OF 1