




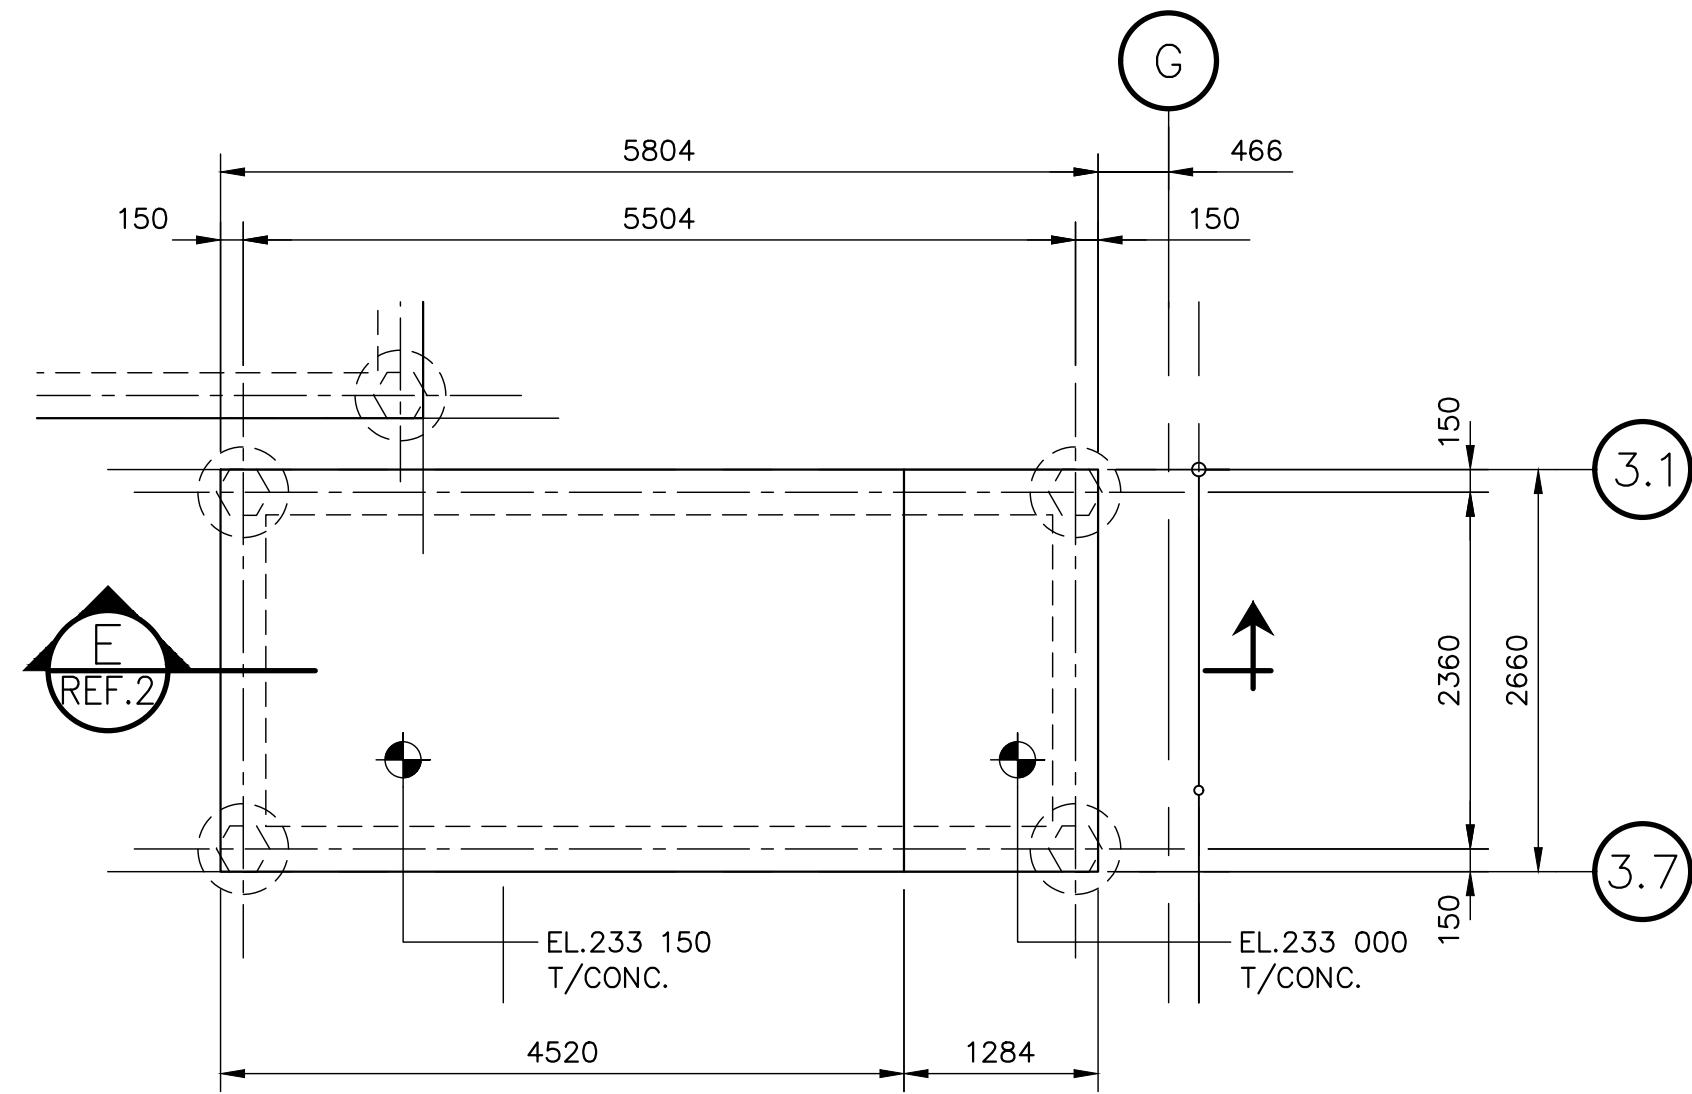

1 DETAIL
REF.1 SCALE: 1:50

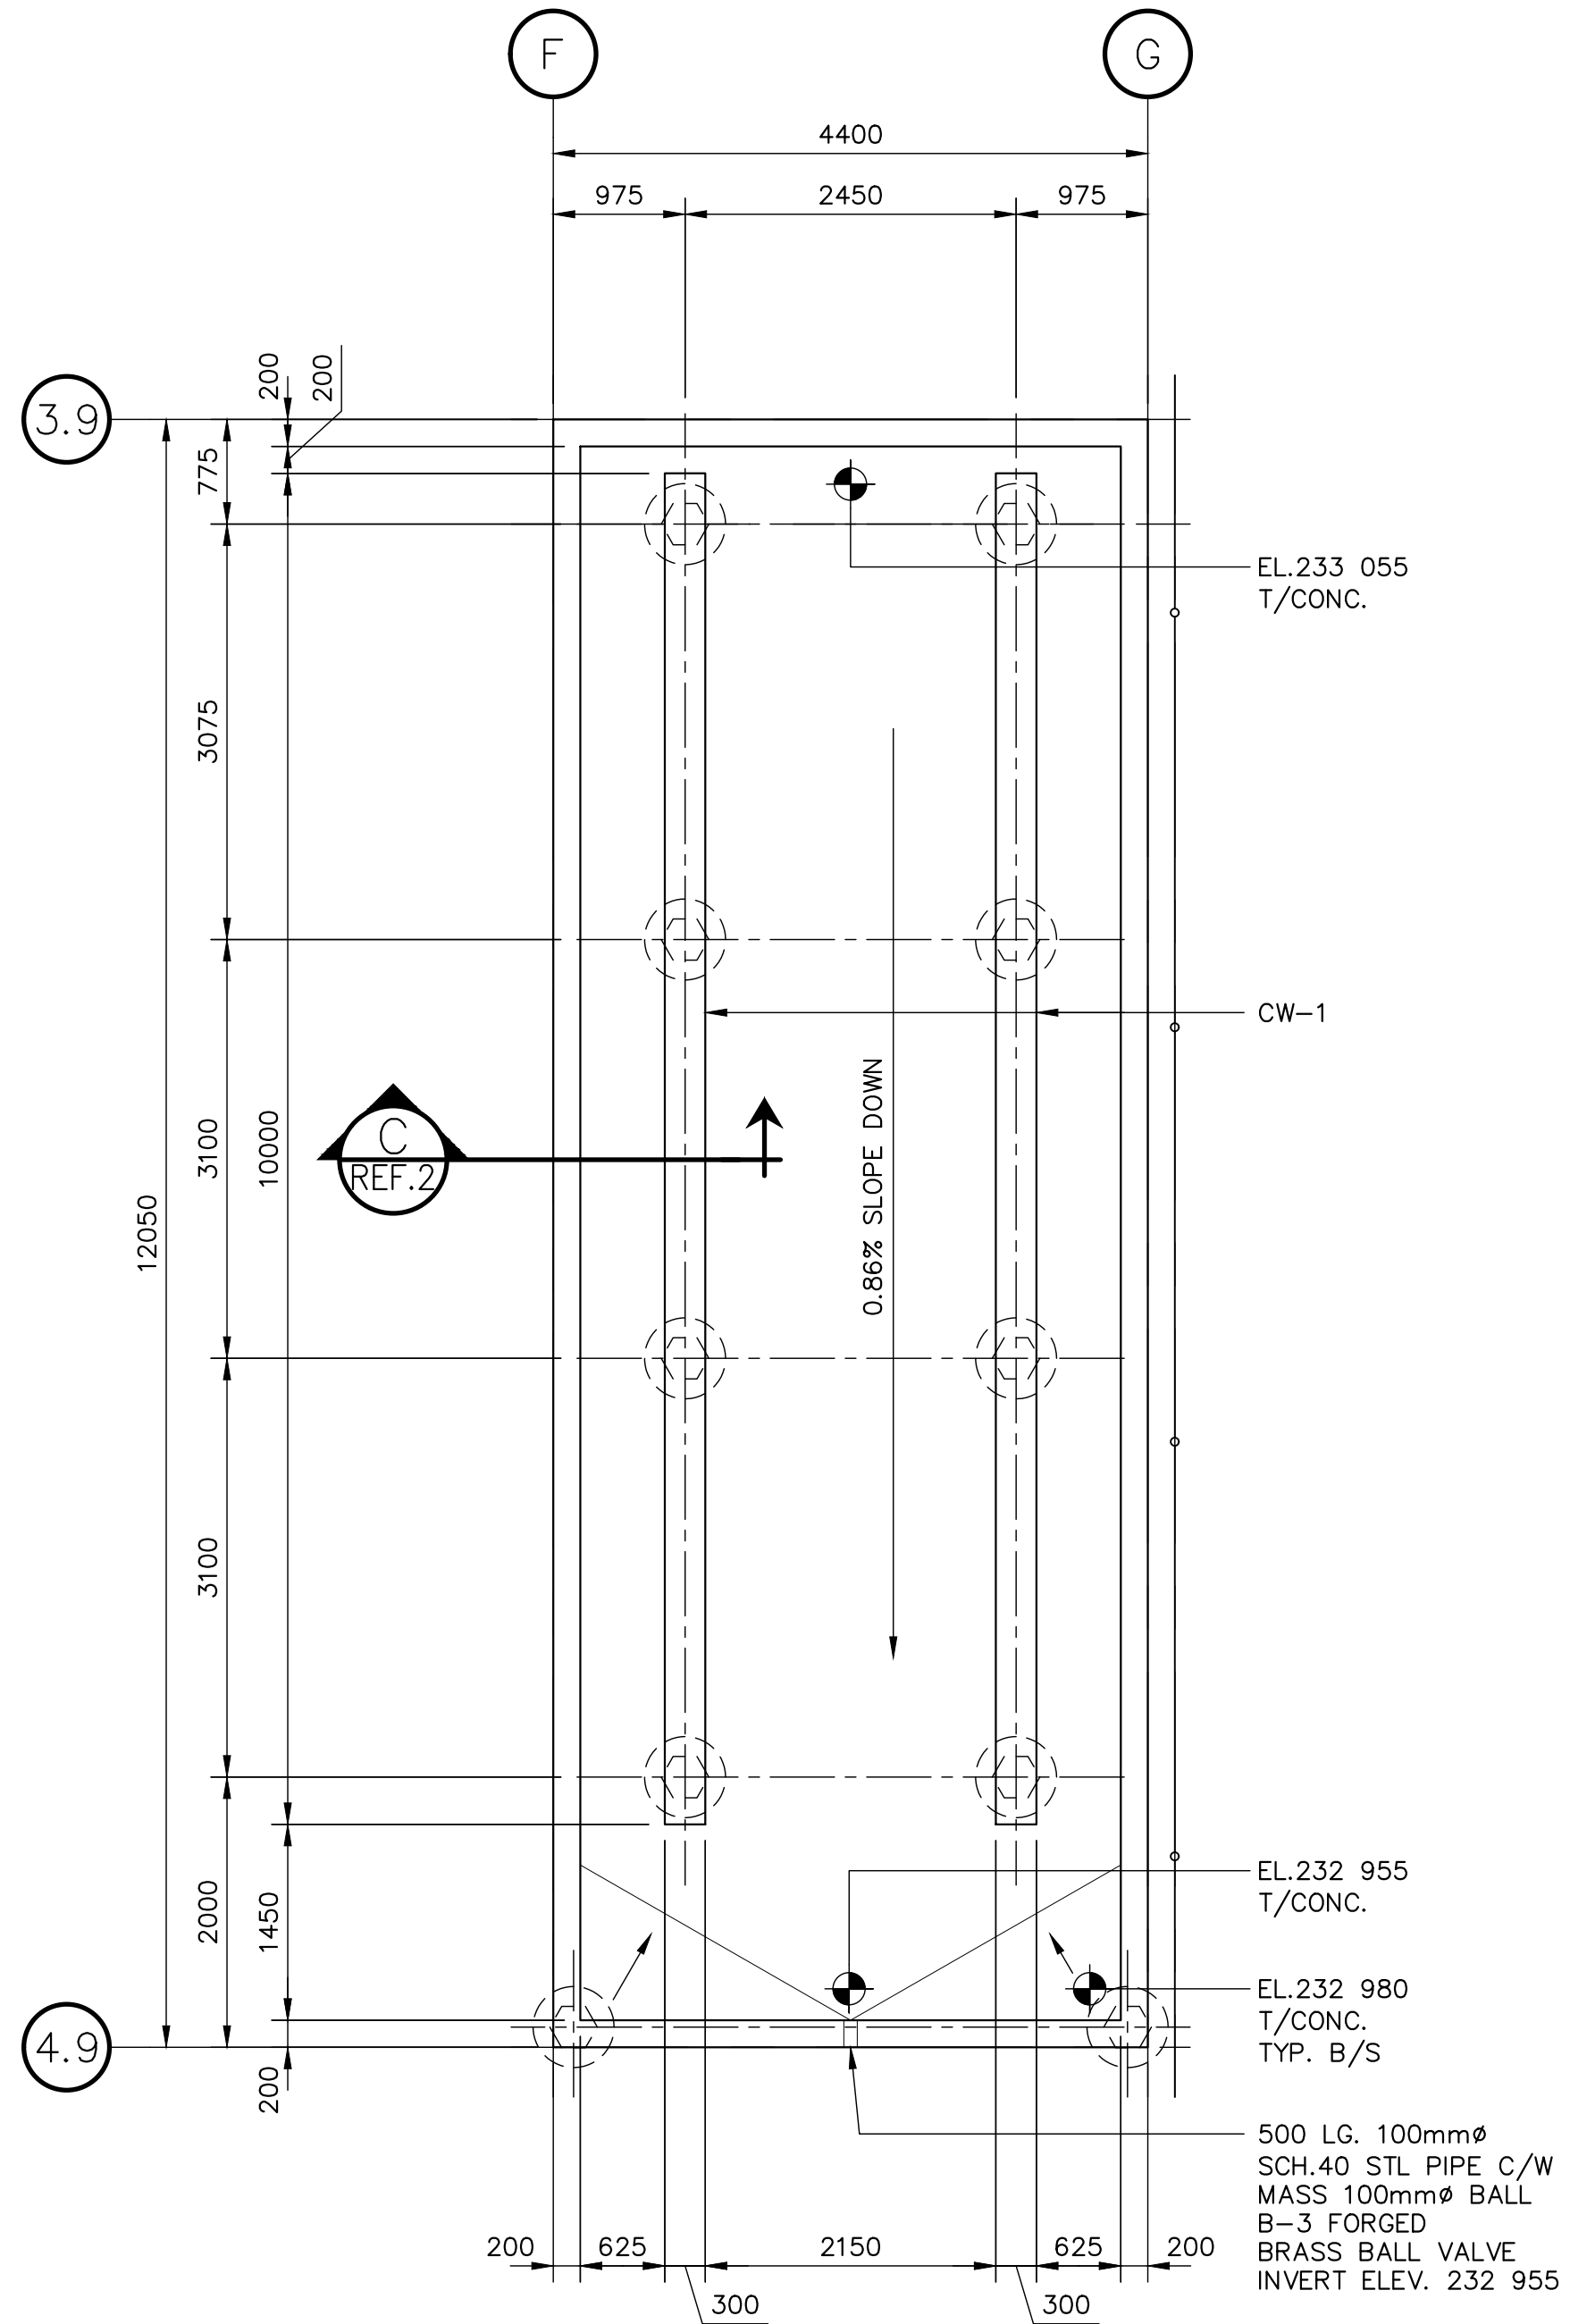

2 DETAIL
REF.1 SCALE: 1:50

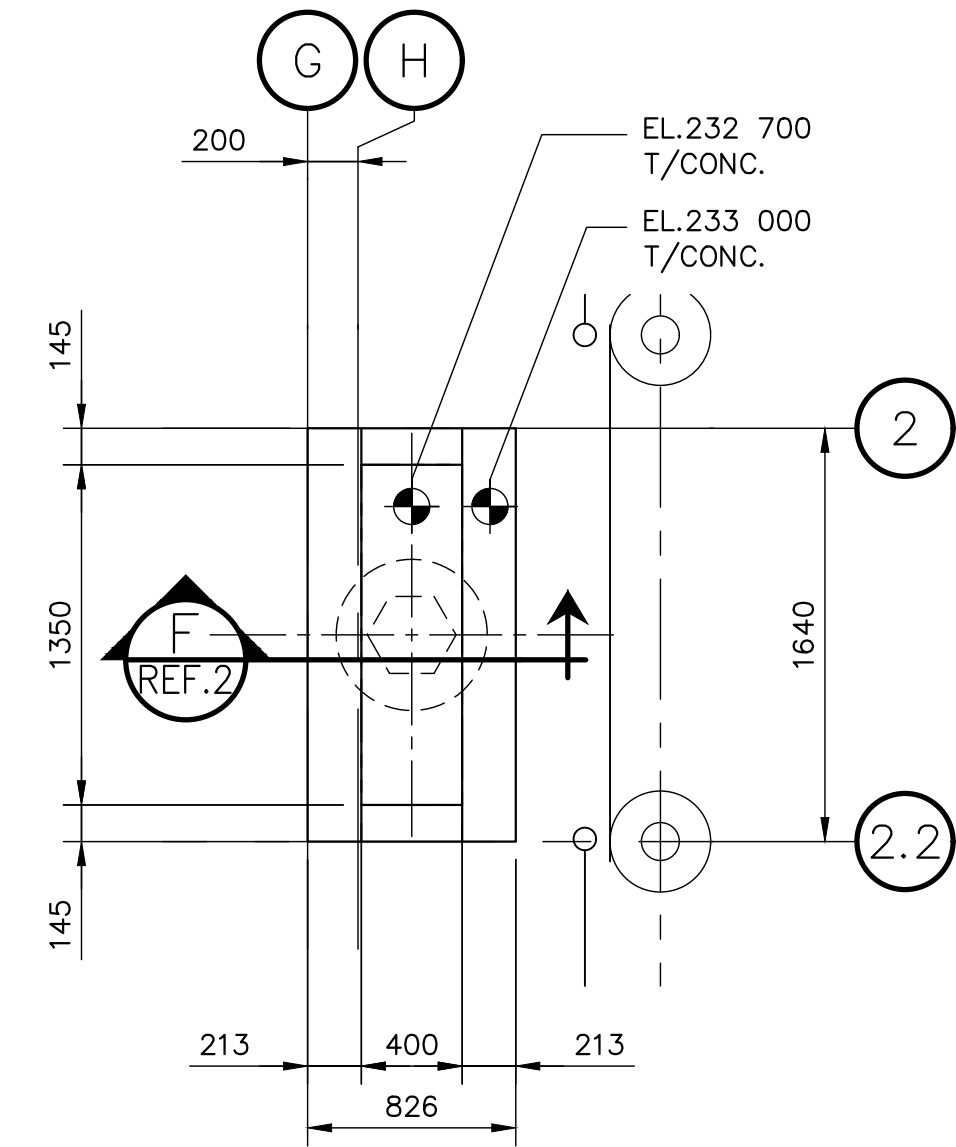

3 DETAIL
REF.1 SCALE: 1:30

10	-	-
9	-	-
8	-	-
7	-	-
6	-	-
5	-	-
4	-	-
3	-	-
2	465-2025-S0005	SECTIONS & DETAILS
1	465-2025-S0003	FOUNDATION PLAN
NO.	DRAWING NUMBER	REFERENCE DRAWING TITLE
REFERENCE DRAWINGS		



B.M. ELEV.			
CONSTRUCTION COMPLETION DATE: YYYY MM DD			
NO.	REVISIONS	DATE	BY
0	ISSUED FOR CONSTRUCTION	2025 07 08	

KGS GROUP	
DESIGNED BY	MEL
CHECKED BY	
DRAWN BY	FBV
APPROVED BY	
SCALE:	AS SHOWN
RELEASED FOR CONSTRUCTION	
DATE	2024 07 18

ENGINEER'S SEAL
CONSULTANT DRAWING NUMBER
24-0107-004_S04

THE CITY OF WINNIPEG TRANSIT DEPARTMENT ENGINEERING DIVISION	
WINNIPEG TRANSIT – FORT ROUGE FACILITY HYDROGEN REFUELLING STATION	
STRUCTURAL PLAN DETAILS	
CITY DRAWING NUMBER	465-2025-S0004
SHEET	1 OF 1