


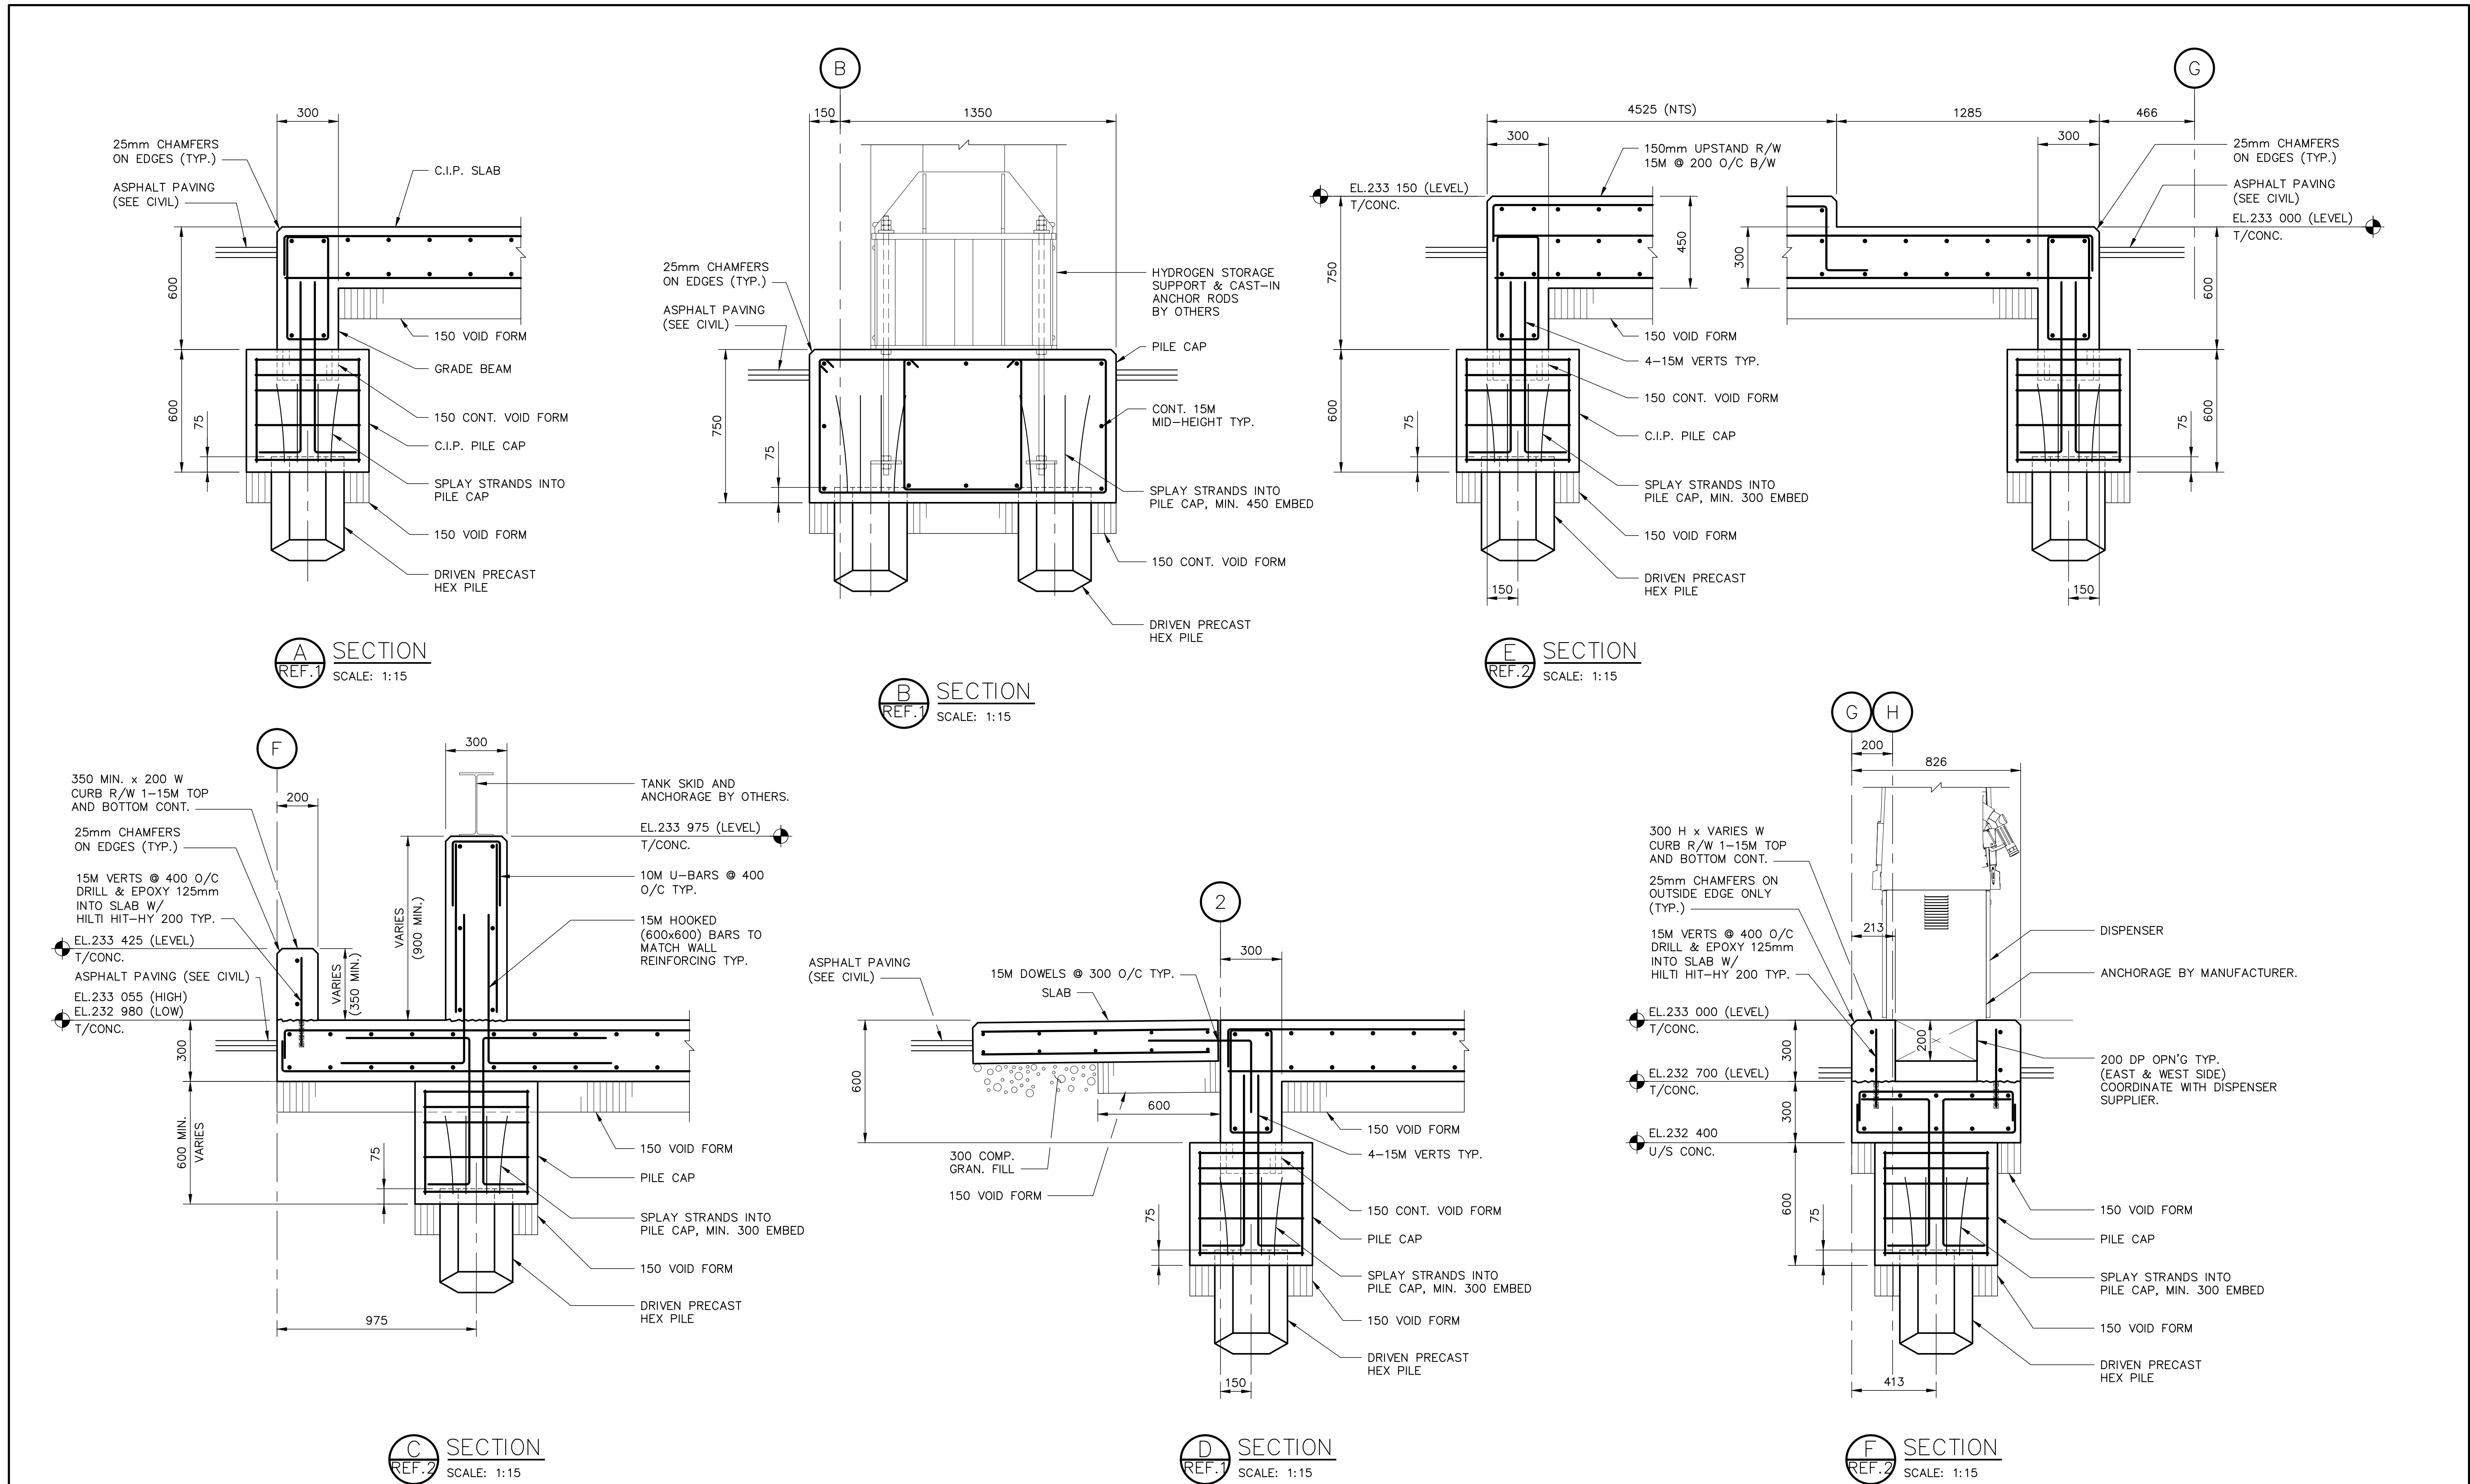

10	—	—
9	—	—
8	—	—
7	—	—
6	—	—
5	—	—
4	—	—
3	—	—
2	465-2025-S0004	PLAN DETAILS
1	465-2025-S0003	FOUNDATION PLAN
NO.	DRAWING NUMBER	REFERENCE DRAWING TITLE
REFERENCE DRAWINGS		



B.M. ELEV.	
CONSTRUCTION COMPLETION DATE: YYYY MM DD	
DESIGNED BY	MEL
CHECKED BY	
DRAWN BY	FBV
APPROVED BY	
SCALE:	AS SHOWN
RELEASED FOR CONSTRUCTION	
DATE	2024 07 18
DATE	2025 07 08
NO.	0
ISSUED FOR CONSTRUCTION	
REVISIONS	
DATE	
BY	

KGS GROUP	
DESIGNED BY	MEL
CHECKED BY	
DRAWN BY	FBV
APPROVED BY	
SCALE:	AS SHOWN
RELEASED FOR CONSTRUCTION	
DATE	2024 07 18
DATE	2025 07 08

ENGINEER'S SEAL
CONSULTANT DRAWING NUMBER
24-0107-004_S05

THE CITY OF WINNIPEG	
TRANSIT DEPARTMENT ENGINEERING DIVISION	
WINNIPEG TRANSIT – FORT ROUGE FACILITY HYDROGEN REFUELLING STATION	
STRUCTURAL SECTIONS & DETAILS	
CITY DRAWING NUMBER	465-2025-S0005
SHEET	1 OF 1

BID OPPORTUNITY: 465-2025
CONTRACT NUMBER: —
FILE PATH: \\kgs-file\y-data\Projects\2024\24-0107-004\Drawings\Struct\24-0107-004_S05.dwg
FILE NAME: 24-0107-004_S05.dwg