

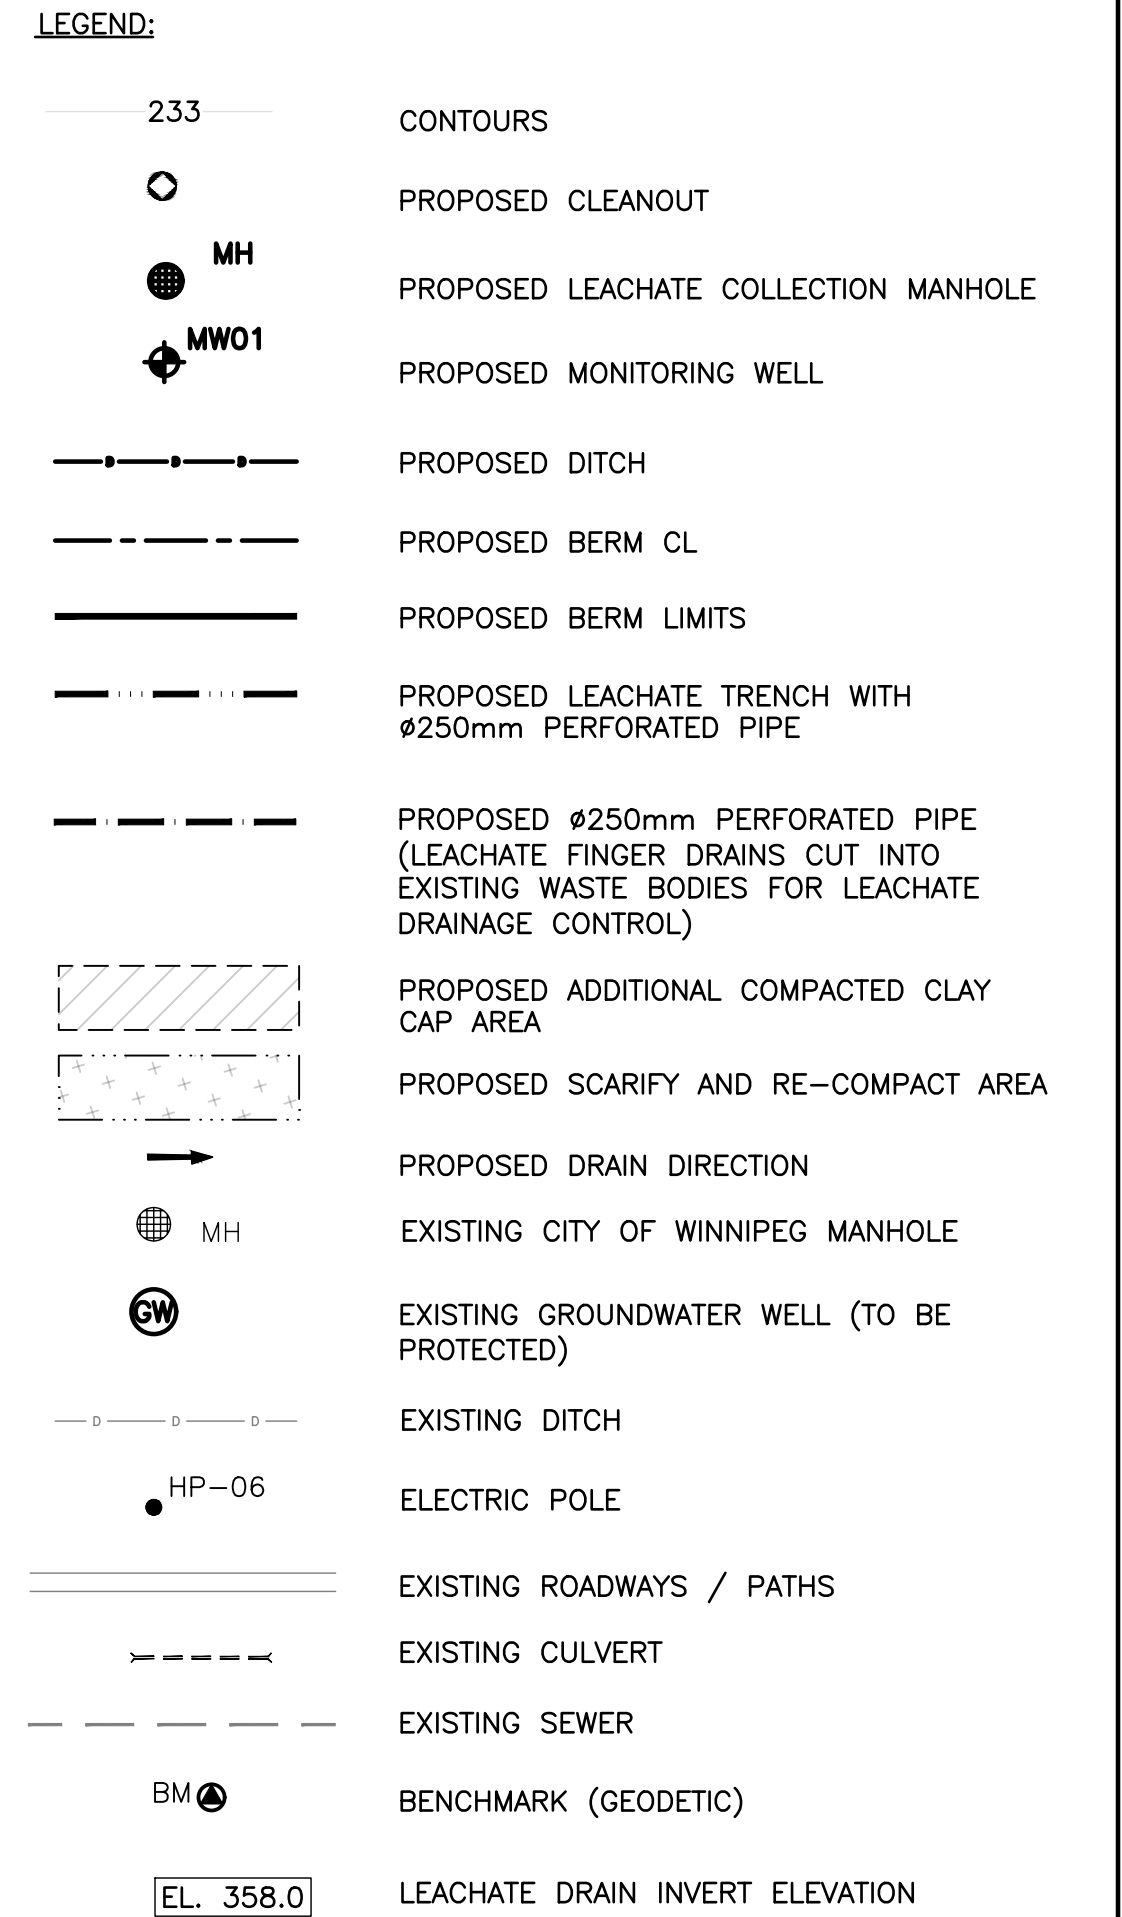
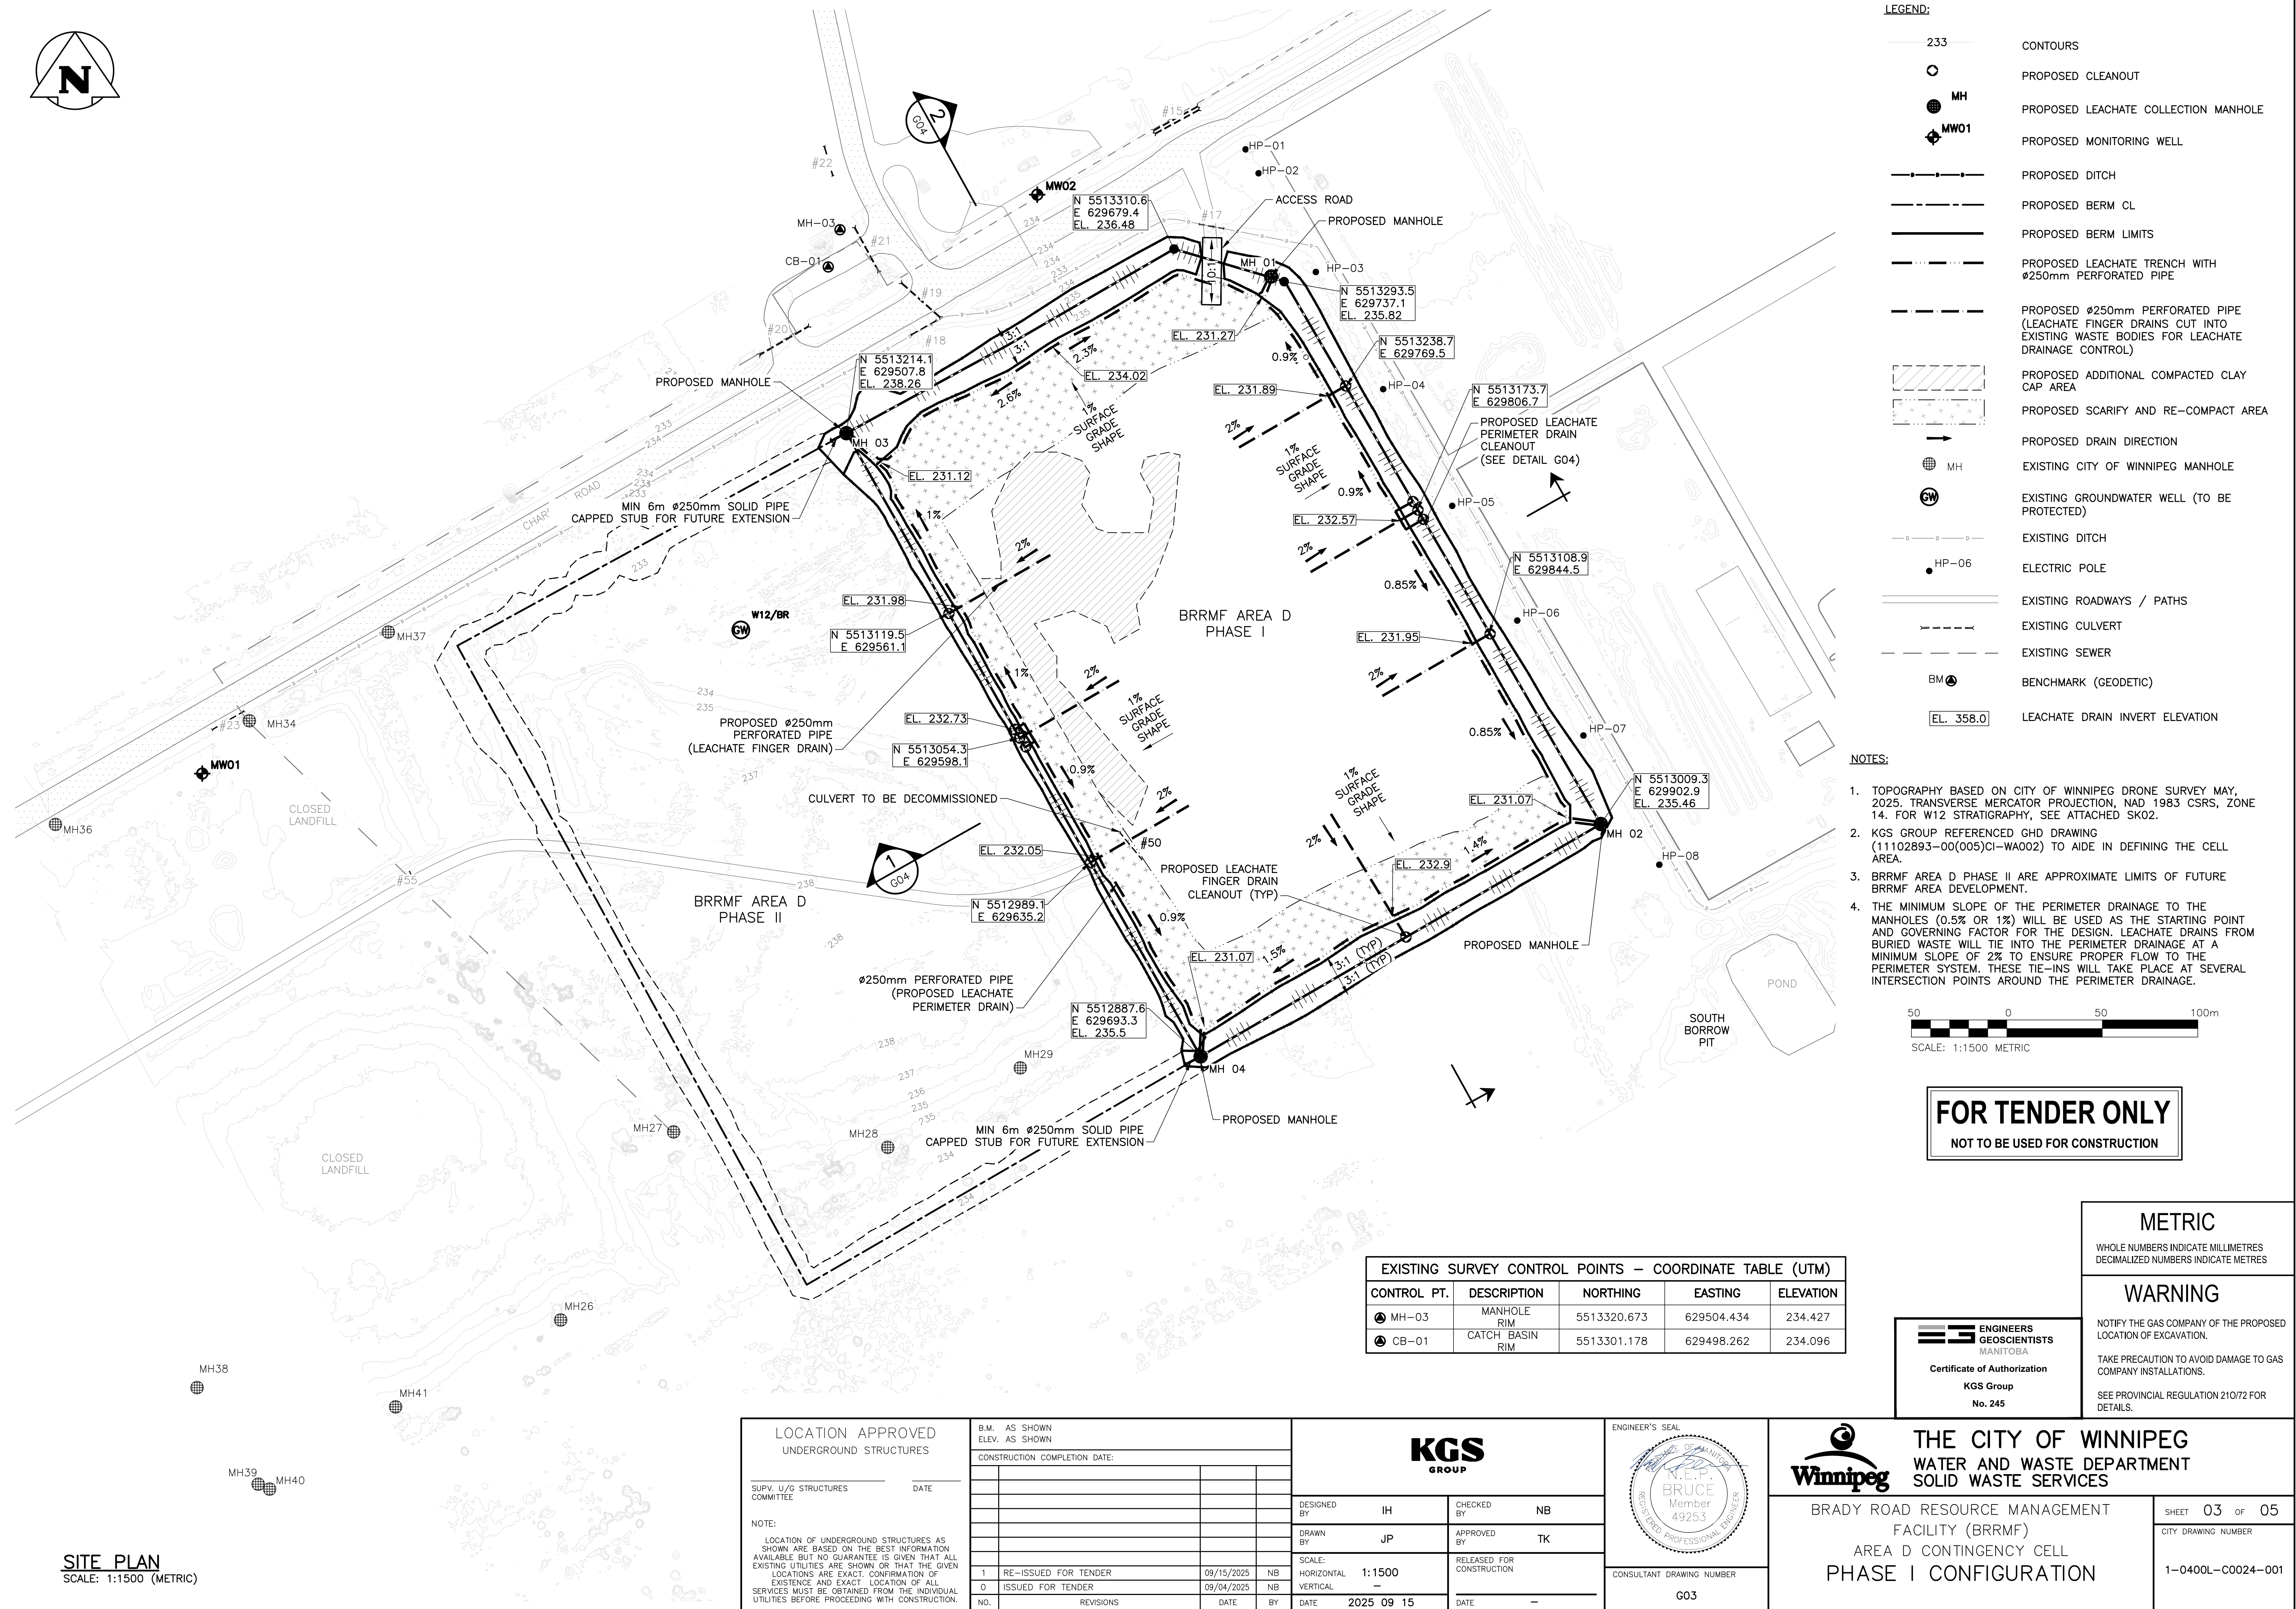


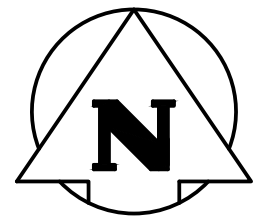

- NOTES:**
- TOPOGRAPHY BASED ON CITY OF WINNIPEG DRONE SURVEY MAY, 2025. TRANSVERSE MERCATOR PROJECTION, NAD 1983 CSRS, ZONE 14. FOR W12 STRATIGRAPHY, SEE ATTACHED SK02.
 - KGS GROUP REFERENCED GHD DRAWING (11102893-00(005)CI-WA002) TO AIDE IN DEFINING THE CELL AREA.
 - BRRMF AREA D PHASE II ARE APPROXIMATE LIMITS OF FUTURE BRRMF AREA DEVELOPMENT.
 - THE MINIMUM SLOPE OF THE PERIMETER DRAINAGE TO THE MANHOLES (0.5% OR 1%) WILL BE USED AS THE STARTING POINT AND GOVERNING FACTOR FOR THE DESIGN. LEACHATE DRAINS FROM BURIED WASTE WILL TIE INTO THE PERIMETER DRAINAGE AT A MINIMUM SLOPE OF 2% TO ENSURE PROPER FLOW TO THE PERIMETER SYSTEM. THESE TIE-INS WILL TAKE PLACE AT SEVERAL INTERSECTION POINTS AROUND THE PERIMETER DRAINAGE.

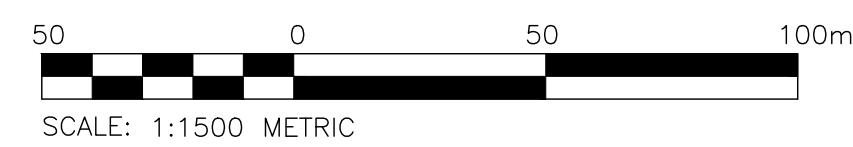

FOR TENDER ONLY
NOT TO BE USED FOR CONSTRUCTION

EXISTING SURVEY CONTROL POINTS – COORDINATE TABLE (UTM)				
CONTROL PT.	DESCRIPTION	NORTHING	EASTING	ELEVATION
MH-03	MANHOLE RIM	5513320.673	629504.434	234.427
CB-01	CATCH BASIN RIM	5513301.178	629498.262	234.096

LOCATION APPROVED
UNDERGROUND STRUCTURES

SUPV. U/G STRUCTURES COMMITTEE DATE

NOTE:
LOCATION OF UNDERGROUND STRUCTURES AS SHOWN ARE BASED ON THE BEST INFORMATION AVAILABLE BUT NO GUARANTEE IS GIVEN THAT ALL EXISTING UTILITIES ARE SHOWN OR THAT THE GIVEN LOCATIONS ARE EXACT. CONFIRMATION OF EXISTENCE AND EXACT LOCATION OF ALL SERVICES MUST BE OBTAINED FROM THE INDIVIDUAL UTILITIES BEFORE PROCEEDING WITH CONSTRUCTION.

B.M. AS SHOWN
ELEV. AS SHOWN

CONSTRUCTION COMPLETION DATE:

1	RE-ISSUED FOR TENDER	09/15/2025	NB
0	ISSUED FOR TENDER	09/04/2025	NB
NO.	REVISIONS	DATE	BY

KGS GROUP

DESIGNED BY	IH	CHECKED BY	NB
DRAWN BY	JP	APPROVED BY	TK
SCALE:	HORIZONTAL 1:1500 VERTICAL —	RELEASED FOR CONSTRUCTION	DATE 2025 09 15

PLOT DATE: 2025 09 15

ENGINEER'S SEAL

K.E.P. BRUCE
Member 49253
REGISTERED PROFESSIONAL ENGINEER

CONSULTANT DRAWING NUMBER
G03

THE CITY OF WINNIPEG
WATER AND WASTE DEPARTMENT
SOLID WASTE SERVICES

BRADY ROAD RESOURCE MANAGEMENT FACILITY (BRRMF)
AREA D CONTINGENCY CELL
PHASE I CONFIGURATION

METRIC
WHOLE NUMBERS INDICATE MILLIMETRES
DECIMALIZED NUMBERS INDICATE METRES

WARNING
NOTIFY THE GAS COMPANY OF THE PROPOSED LOCATION OF EXCAVATION.
TAKE PRECAUTION TO AVOID DAMAGE TO GAS COMPANY INSTALLATIONS.
SEE PROVINCIAL REGULATION 210/72 FOR DETAILS.

SHEET **03** OF **05**

CITY DRAWING NUMBER
1-0400L-C0024-001

SITE PLAN
SCALE: 1:1500 (METRIC)