



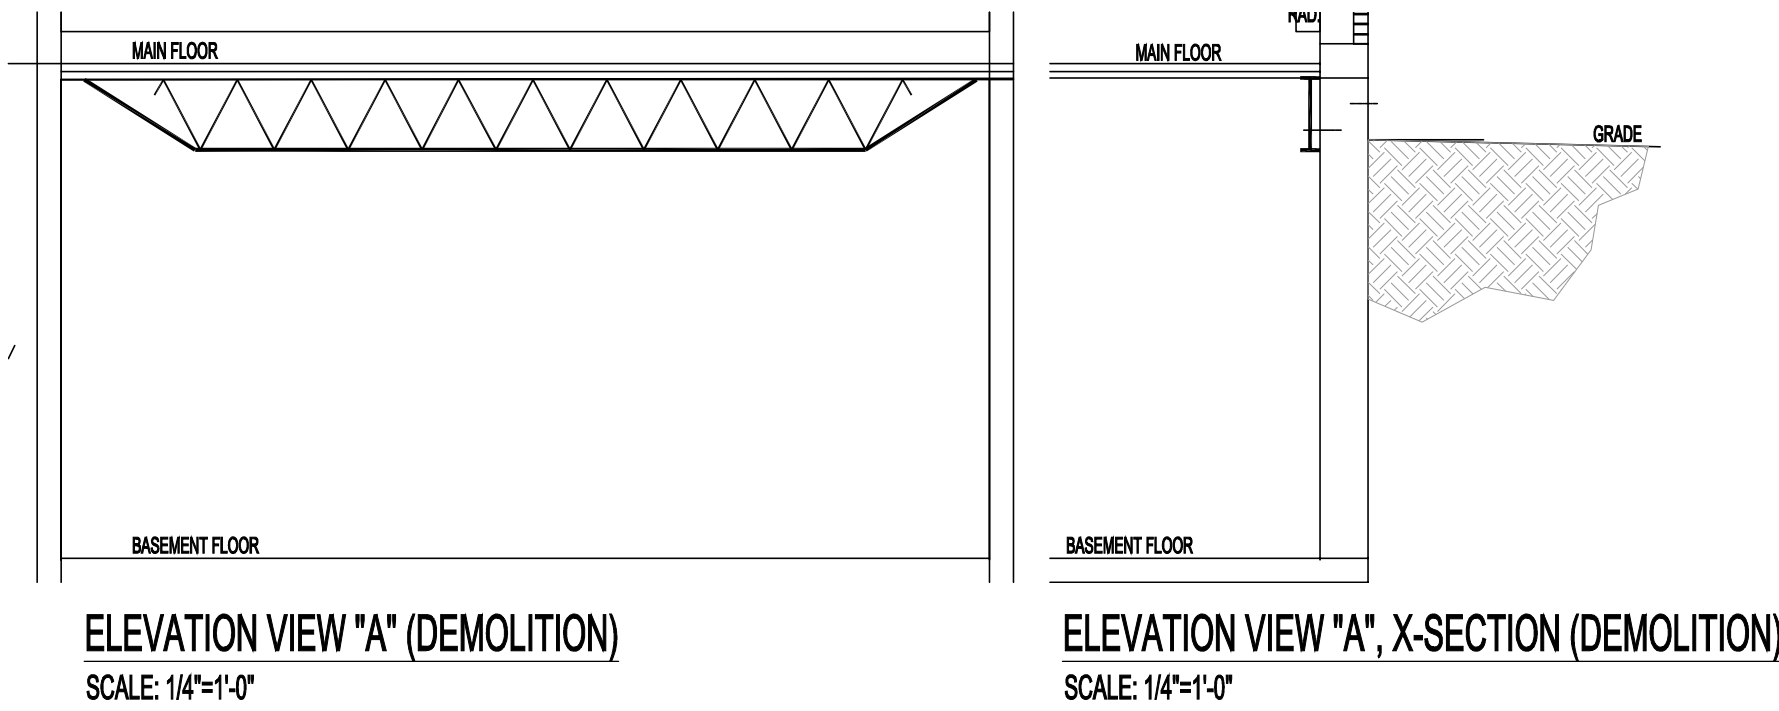

- ELECTRICAL DEMOLITION NOTES:** "X"
- ALSO SEE GENERAL NOTES & SPECIFICATIONS.
ALL EXISTING/REWORK ELECTRICAL COMPONENTS & SYSTEMS SHALL COMPLY TO THE 2021 CANADIAN ELECTRICAL CODE, PART I, 25TH EDITION (NOTED AS "CODE") ADOPTED BY THE WINNIPEG ELECTRICAL BY-LAW NO. 72/2022. THIS INCLUDES ABANDONED WIRES, CABLES, CONDUITS & ITS SUPPORTS SHALL BE REMOVED.
DO NOT DISTURB OR DISCONNECT ANY WIRING & CABLING IN AREA OF WORK REQUIRED FOR OTHER AREAS.
1. REPLACE ELECTRIC SERVICE LINE-SIDE AS PER SLD & RENOVATION DRAWINGS.
 2. REPLACE ALL ELECTRICAL PANELS & CIRCUIT BREAKERS AS SHOWN, EXCEPT PANEL "SUB-J" SHALL BE REMOVED & RE-CIRC AS PER SLD DRAWING.
 3. REPLACE REVERSE- FED TRANSFORMER , SEE RENO DRAWING.
 4. REPLACE LUMINAIRES, LIGHT SWITCH & FACEPLATE, SEE RENO DRAWING.

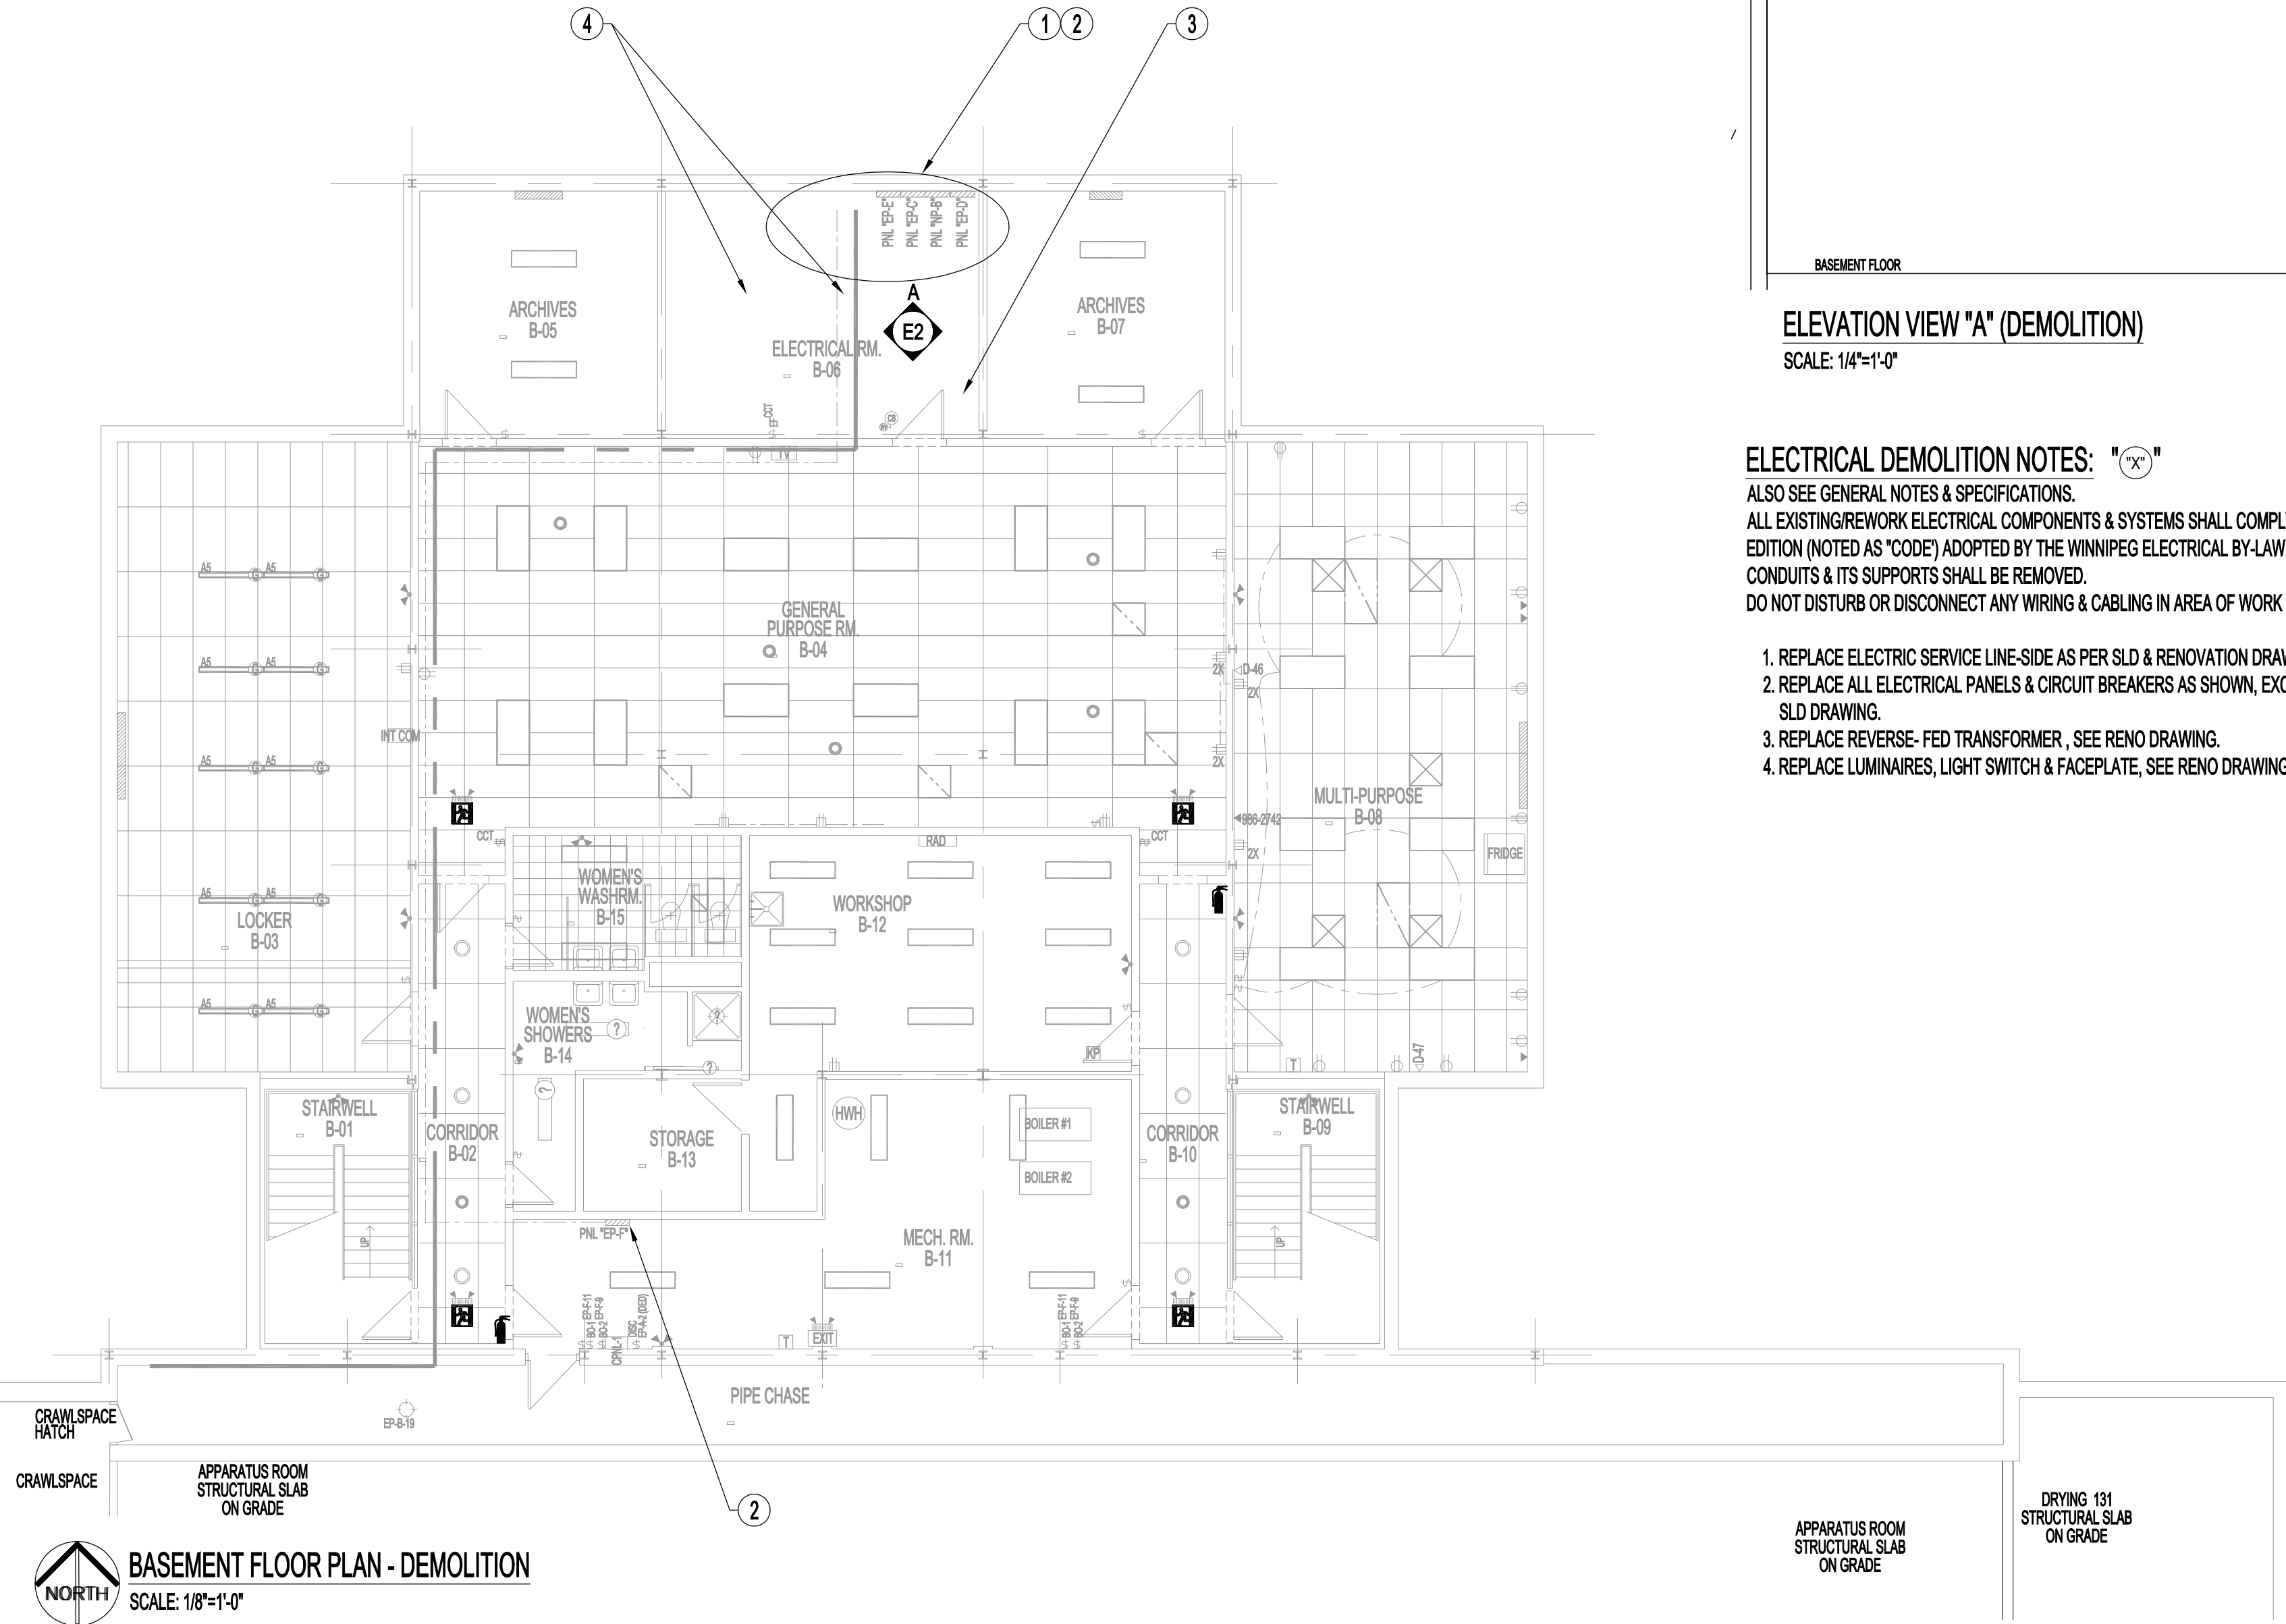

0	ISSUED FOR CONSTRUCTION	DTA	08.11 2025
A	ISSUED FOR REVIEW	DTA	08.15 2025
No.	REVISION/DESCRIPTION	BY	DATE

SEAL



DATE	DESIGN	DRAWN	CHECKED	APPROVED
2025.08.08	BY: DTA	BY: DTA	BY:	BY:



PROJECT
WINNIPEG FIRE PARAMEDIC SERVICES
FIRE STATION 1
ELECTRICAL DISTRIBUTION UPGRADE AND GENSET
65 ELLEN STREET TENDER No:802-2025

SHEET TITLE
BASEMENT FLOOR PLAN
ELECTRICAL - DEMOLITION
POWER AND SYSTEMS

SCALE	PROJECT No:	SHEET No:
AS SHOWN	2024-070	E2