

ELECTRICAL RENOVATION NOTES "X"

ALSO SEE GENERAL NOTES & SPECIFICATIONS.

ALL EXISTING/REWORK ELECTRICAL COMPONENTS & SYSTEMS SHALL MADE COMPLIANCE TO THE 2021 CANADIAN ELECTRICAL CODE, PART I, 25TH EDITION (NOTED AS "CODE") ADOPTED BY THE WINNIPEG ELECTRICAL BY-LAW NO. 72/2022. THIS INCLUDES ABANDONED WIRES,CABLES, CONDUITS & ITS SUPPORTS SHALL BE REMOVED.

DO NOT DISTURB OR DISCONNECT ANY WIRING & CABLING IN AREA OF WORK REQUIRED FOR OTHER AREAS.

1. PROVIDE WALL MOUNT DIGITAL GENSET CONTROLLER AT WATCH DESK 109, 60" AFF OF EXISTING 5-GANG LIGHT SWITCH, WITH 3/4" EMT (INSIDE BUILDING/ABOVE GRADE) & PVC CONDUITS (BELOW GRADE) TO GENERATOR. ALSO REFER TO DRAWING E3 RENOVATION NOTE 2. GENERATOR.
2. REWORK PANEL "NP-A" FEEDER PATHWAY TO "MD-1" TO MEET CODE.
3. PROVIDE GFCI DUPLEX RECEPTACLE 42" AFF.
4. REMOVE MOBILE GENSET CEILING-HUNG RECEPTACLE & COMPONENTS BACK TO PANEL.
5. ALL CEILING RECEPTACLES SHALL BE CONNECTED TO EMERGENCY POWER PANELS. RE-CIRCUIT MAYBE REQUIRED.
6. RE-CIRCUIT EQUIPMENT.

0	ISSUED FOR CONSTRUCTION	DTA	08.11.2025
A	ISSUED FOR REVIEW	DTA	08.15.2025
No.	REVISION/DESCRIPTION	BY	DATE




DATE	DESIGN	DRAWN	CHECKED	APPROVED
2025.08.08	BY: DTA	BY: DTA	BY:	BY:



PROJECT
WINNIPEG FIRE PARAMEDIC SERVICES
FIRE STATION 1
ELECTRICAL DISTRIBUTION UPGRADE AND GENSET
65 ELLEN STREET TENDER No: 802-2025

SHEET TITLE
MAIN FLOOR PLAN
ELECTRICAL
POWER AND SYSTEMS

SCALE	PROJECT No:	SHEET No:
AS SHOWN	2024-070	E4

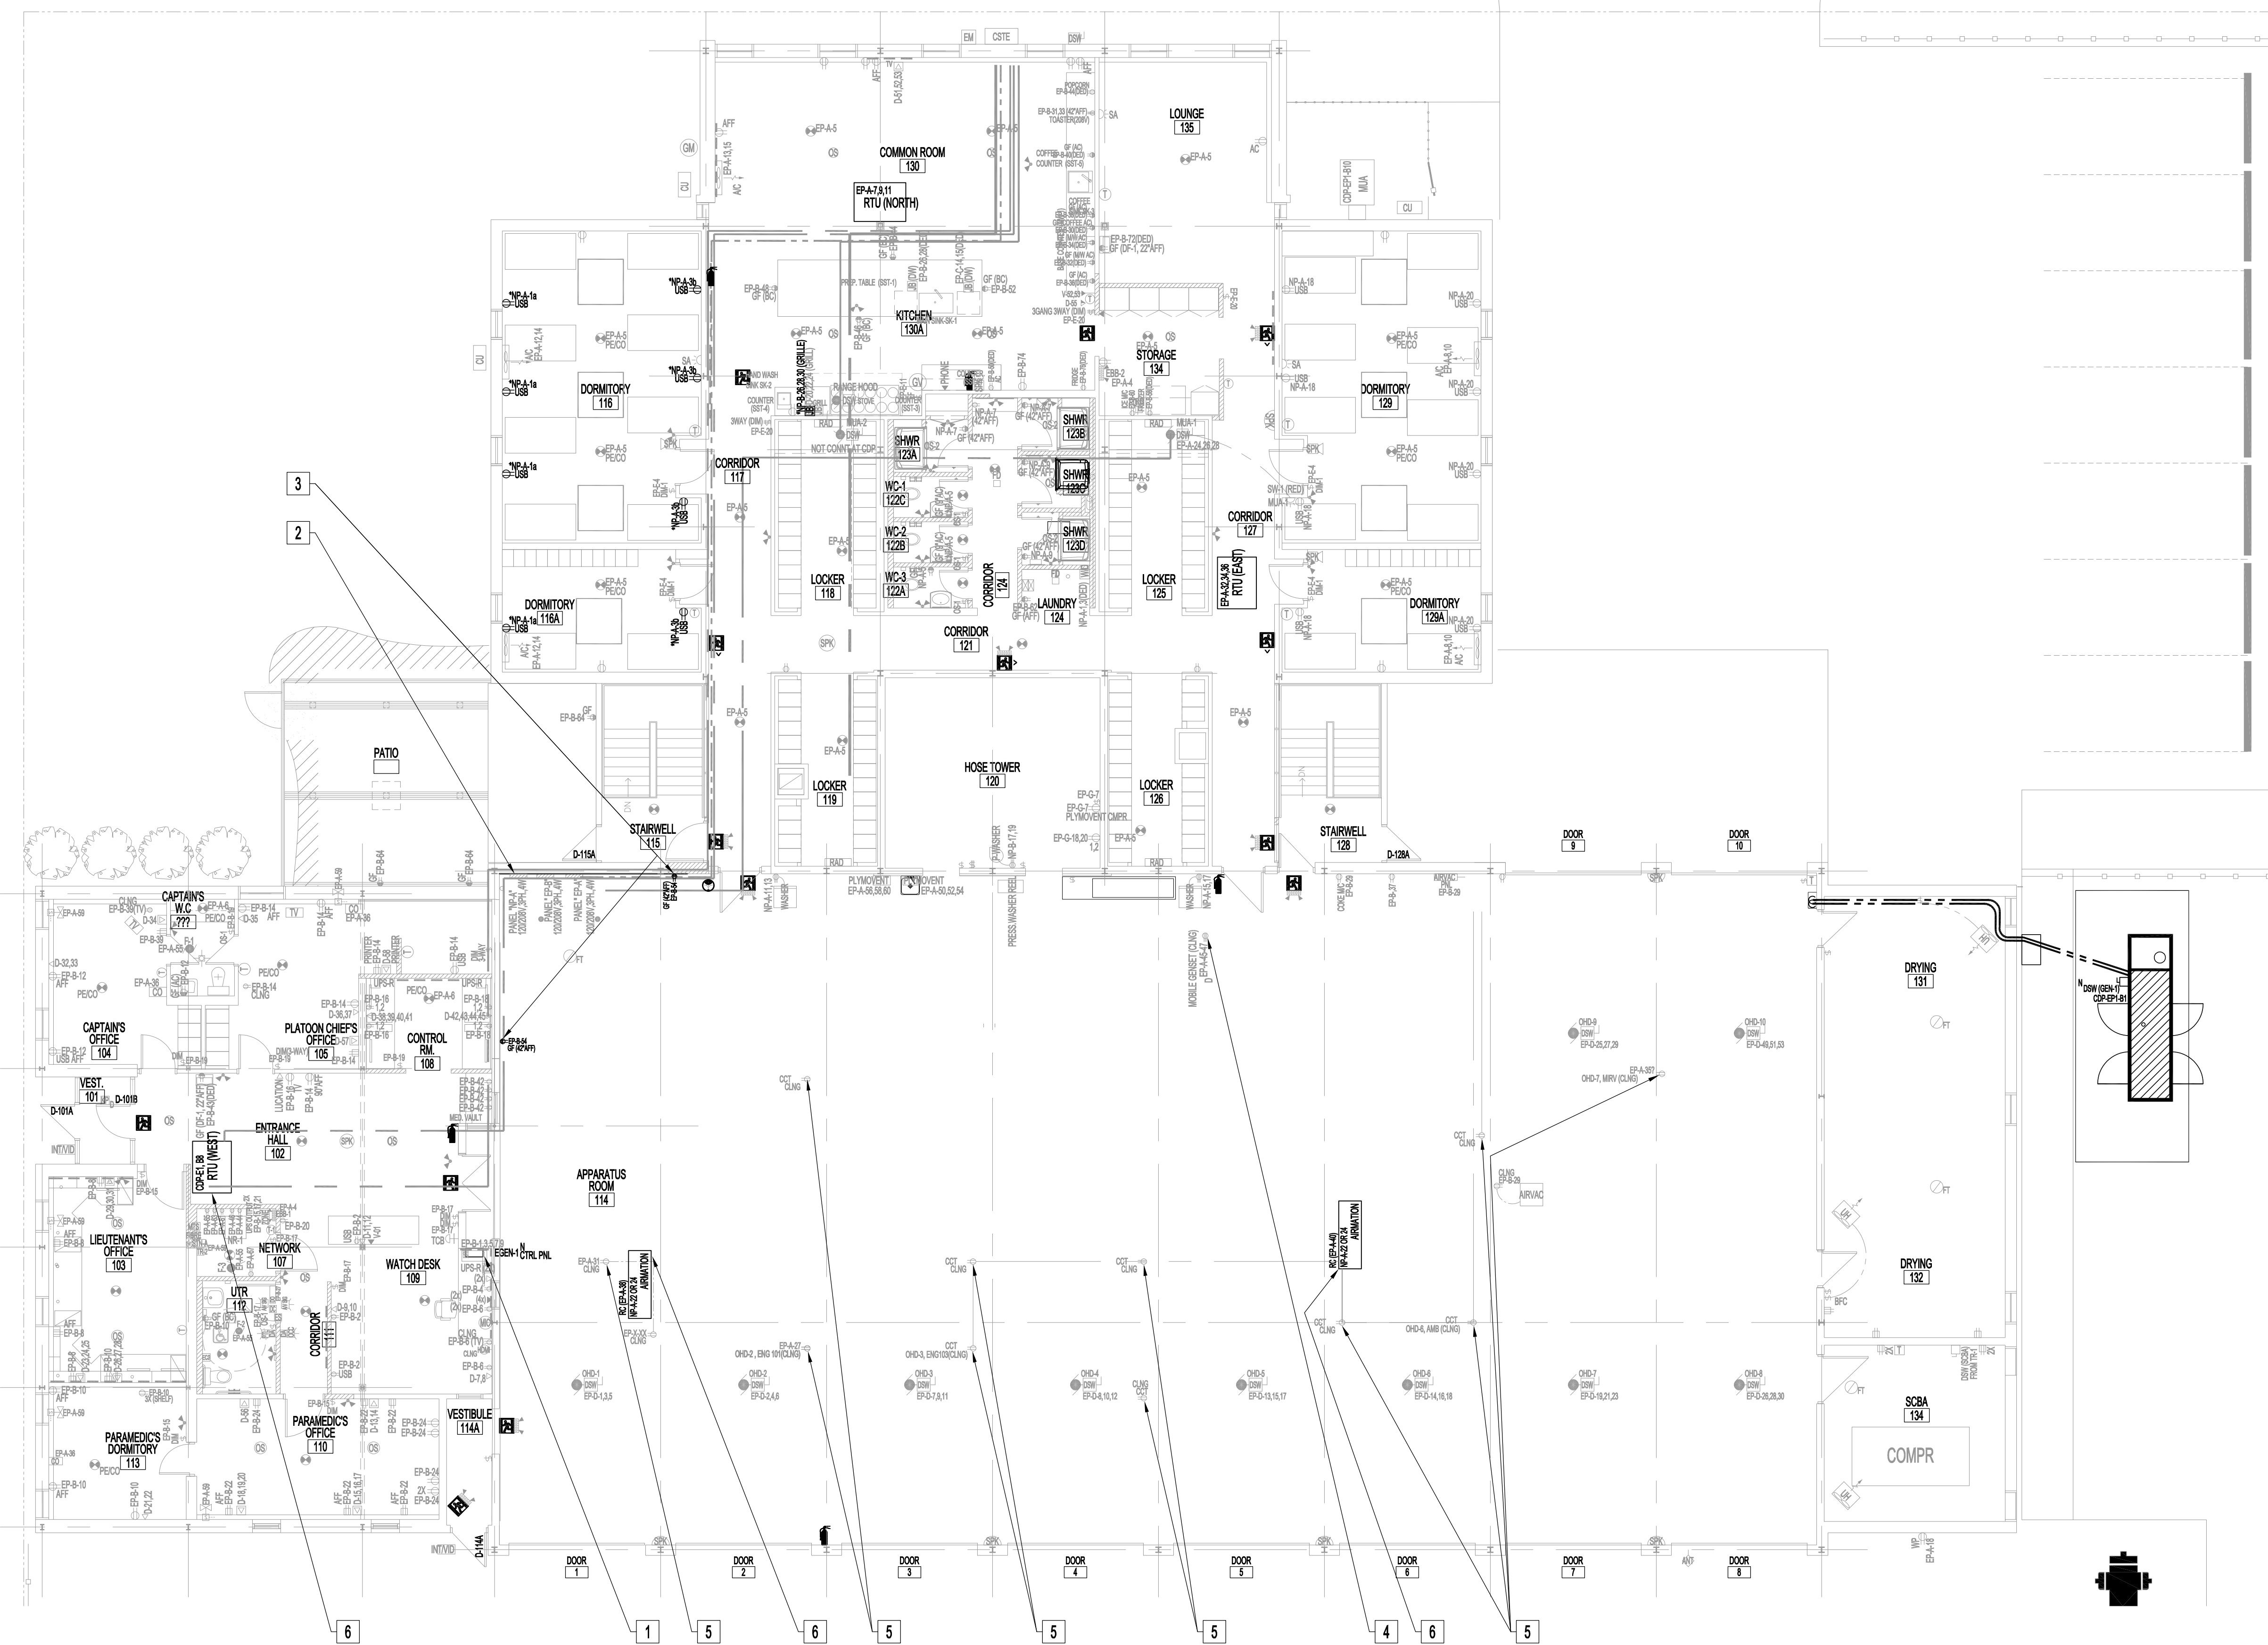

MAIN FLOOR AND PARTIAL SITE PLAN - RENOVATION
SCALE: 1/8"=1'-0"