


APPENDIX 'A' – HISTORICAL DOCUMENTS

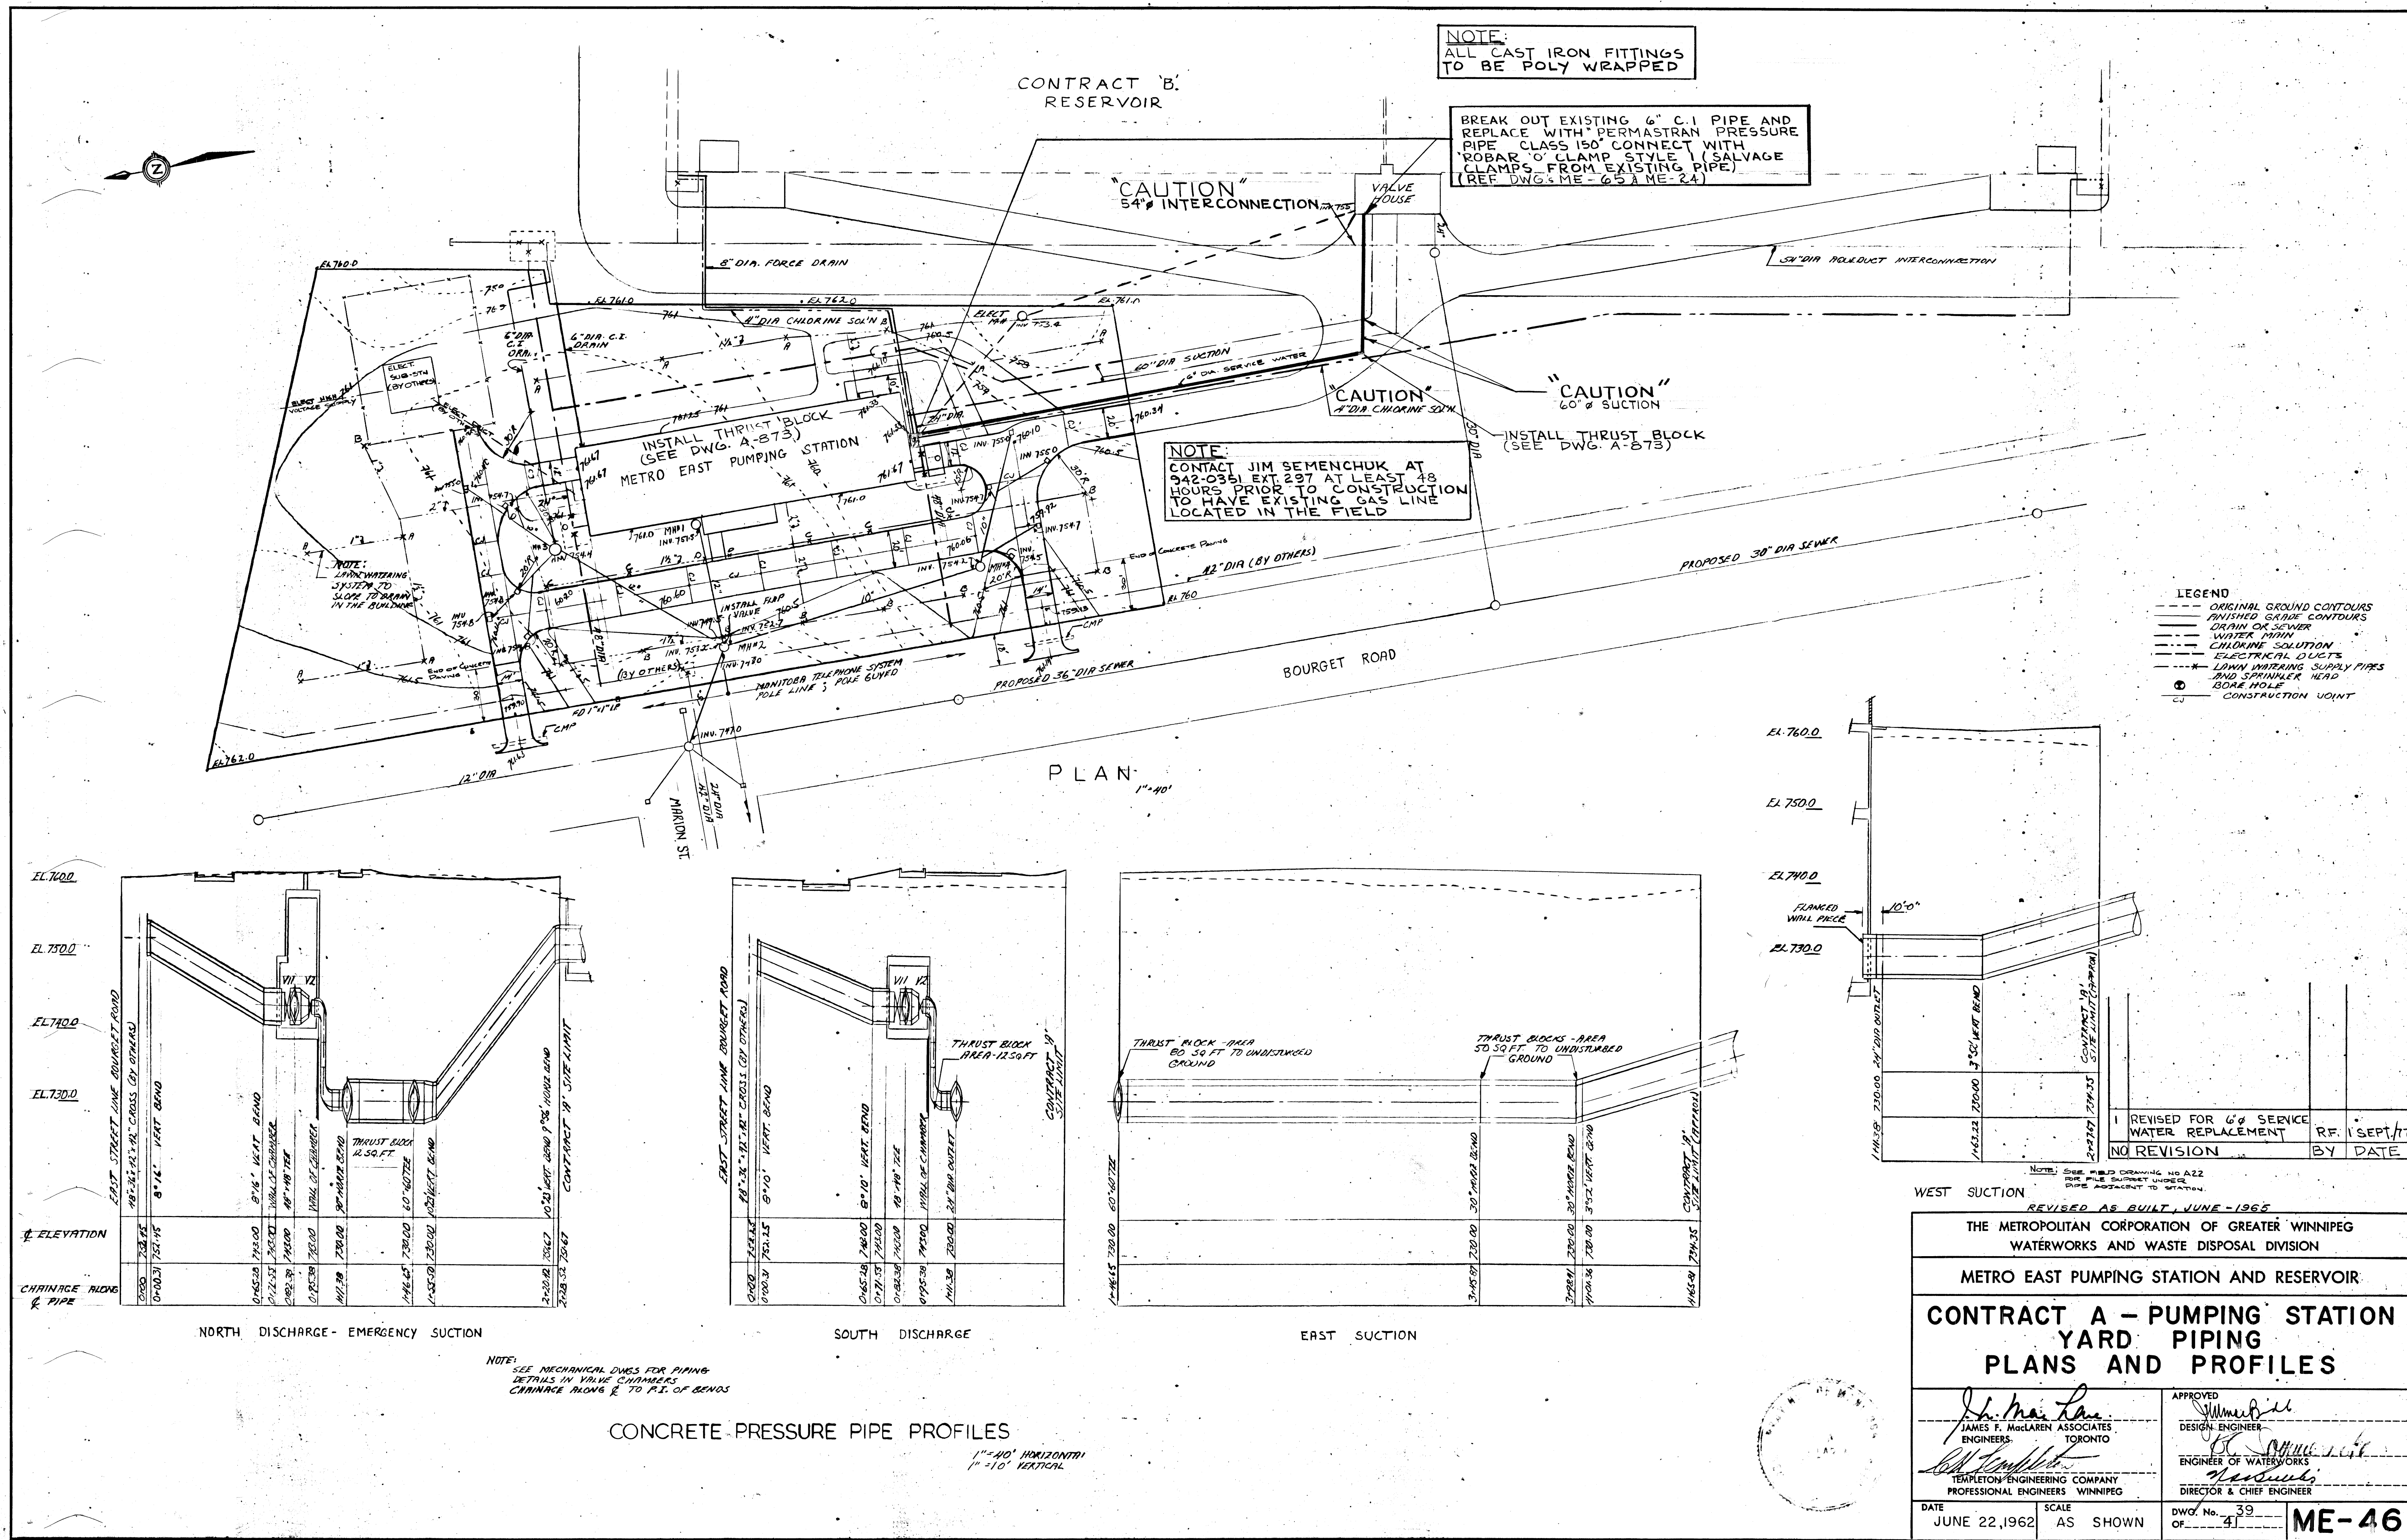

1

REVISED FOR 6\"/>

NO REVISION

RE. 1 SEPT/77

BY DATE

WEST SECTION

REVISED AS BUILT, JUNE-1965

THE METROPOLITAN CORPORATION OF GREATER WINNIPEG

WATERWORKS AND WASTE DISPOSAL DIVISION

METRO EAST PUMPING STATION AND RESERVOIR

CONTRACT A - PUMPING STATION

YARD PIPING

PLANS AND PROFILES

APPROVED

James F. MacLaren

JAMES F. MACLAREN ASSOCIATES

ENGINEERS

TORONTO

APPROVED

James F. MacLaren

ENGINEER OF WATERWORKS

TEMPLETON ENGINEERING COMPANY

PROFESSIONAL ENGINEERS - WINNIPEG

DATE

JUNE 22, 1962

SCALE

AS SHOWN


DWG. No.





39

OF

41

ME-46

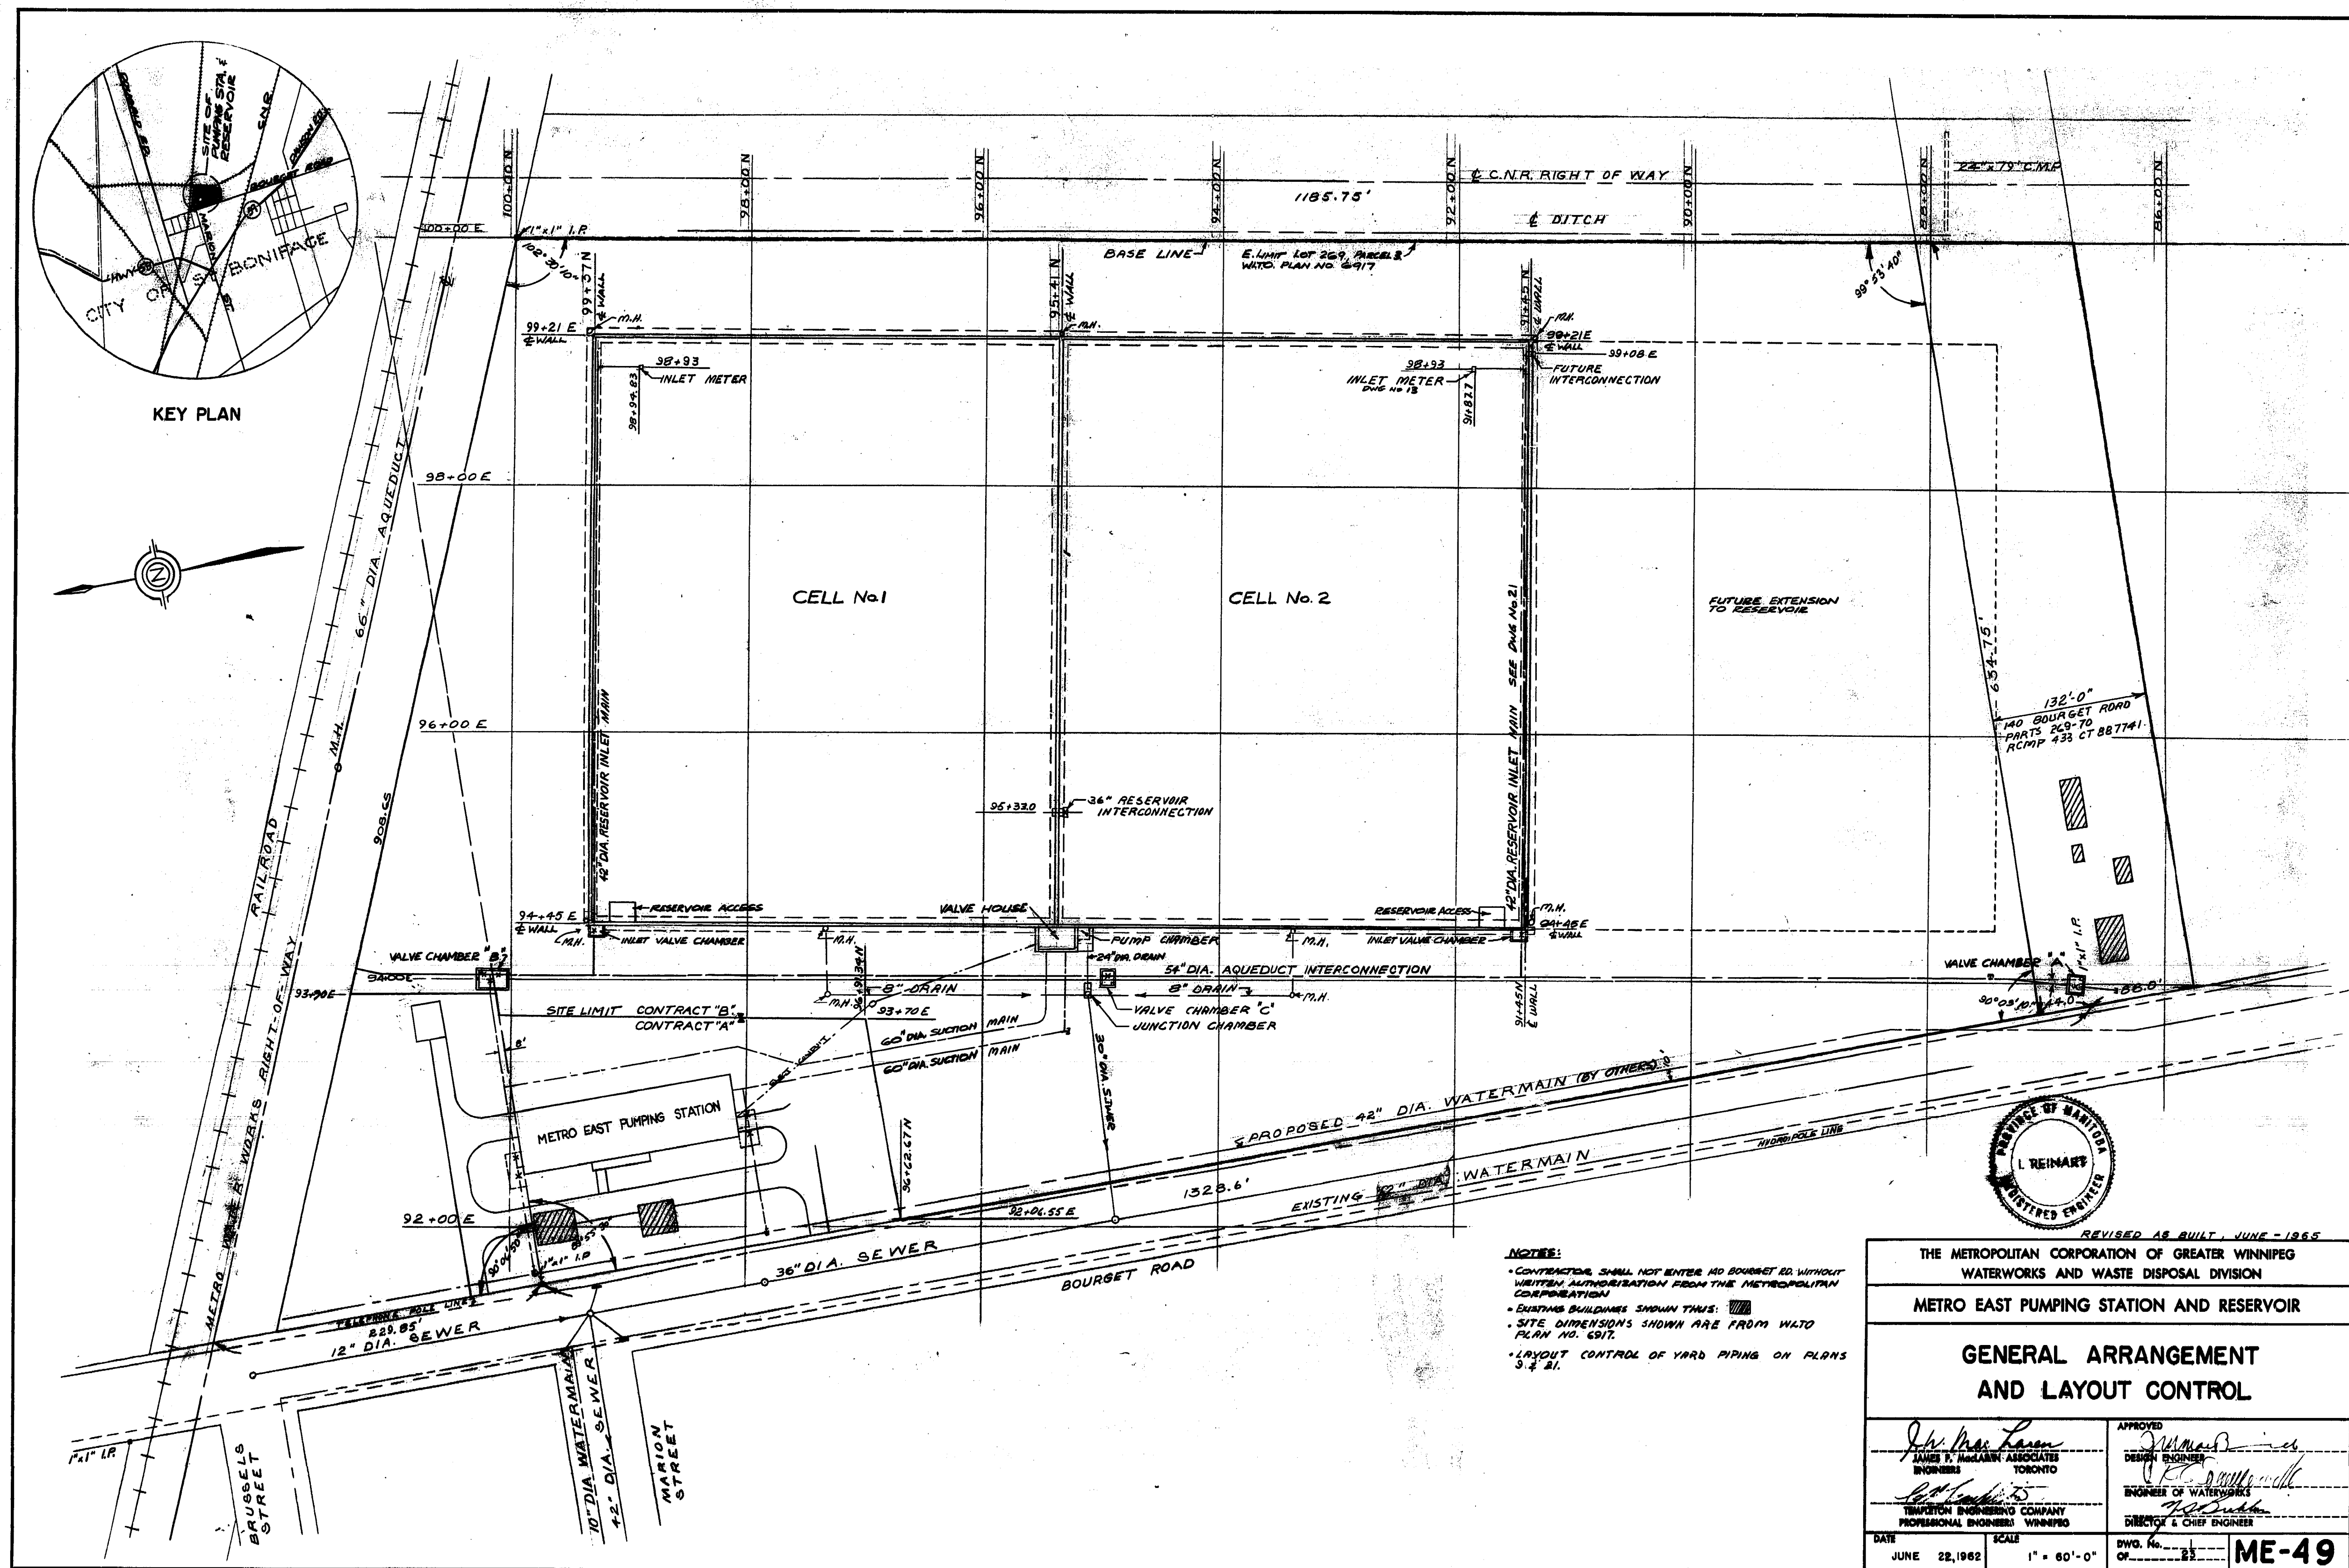

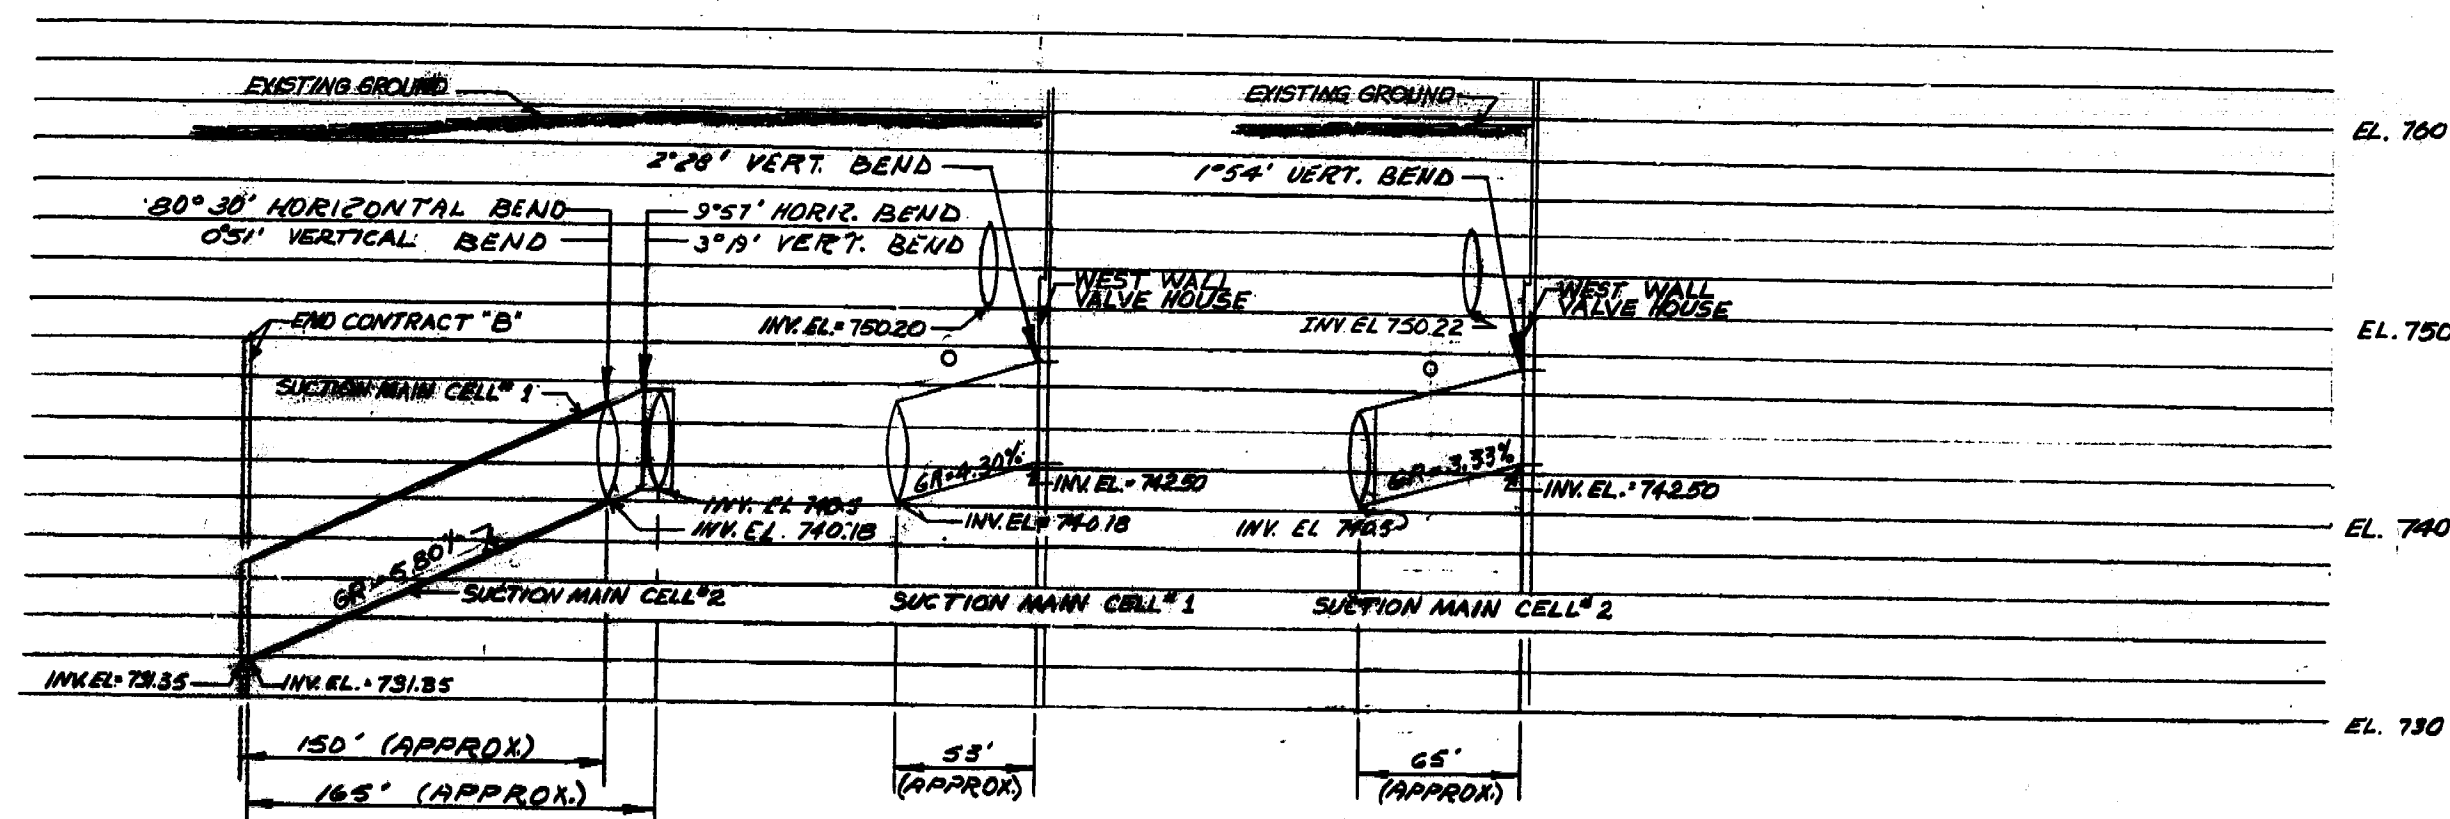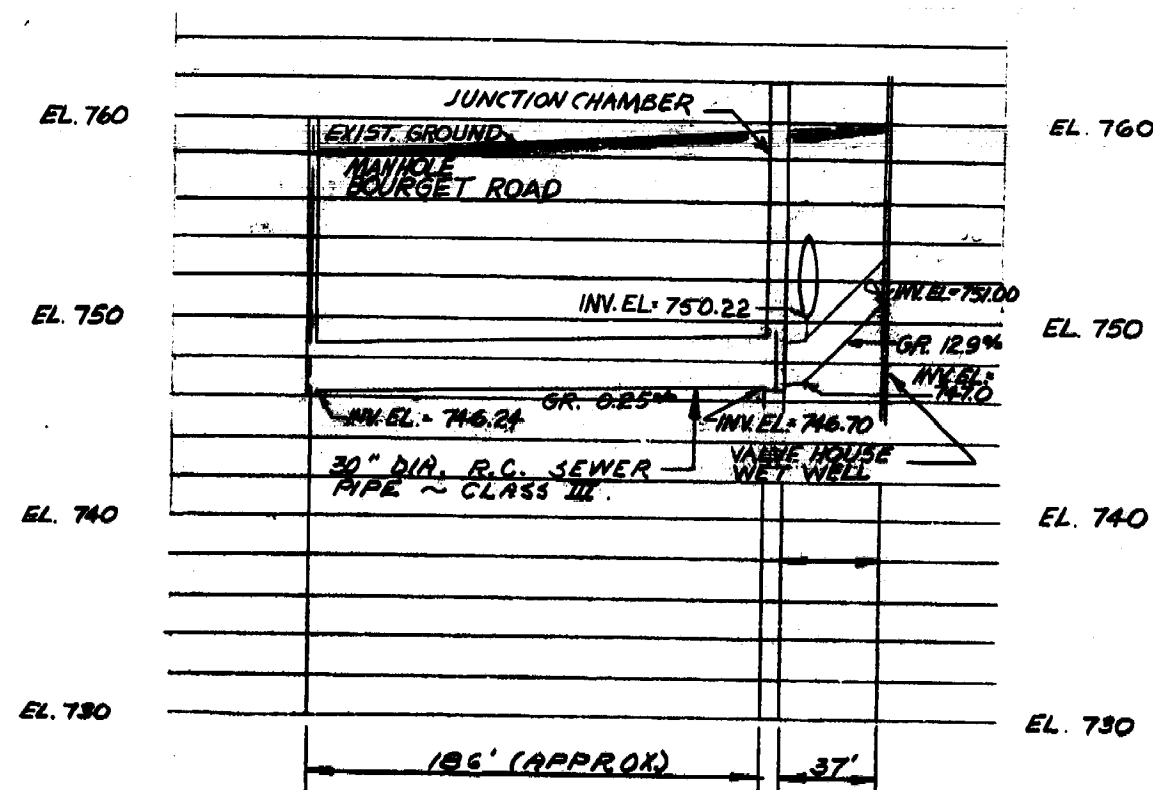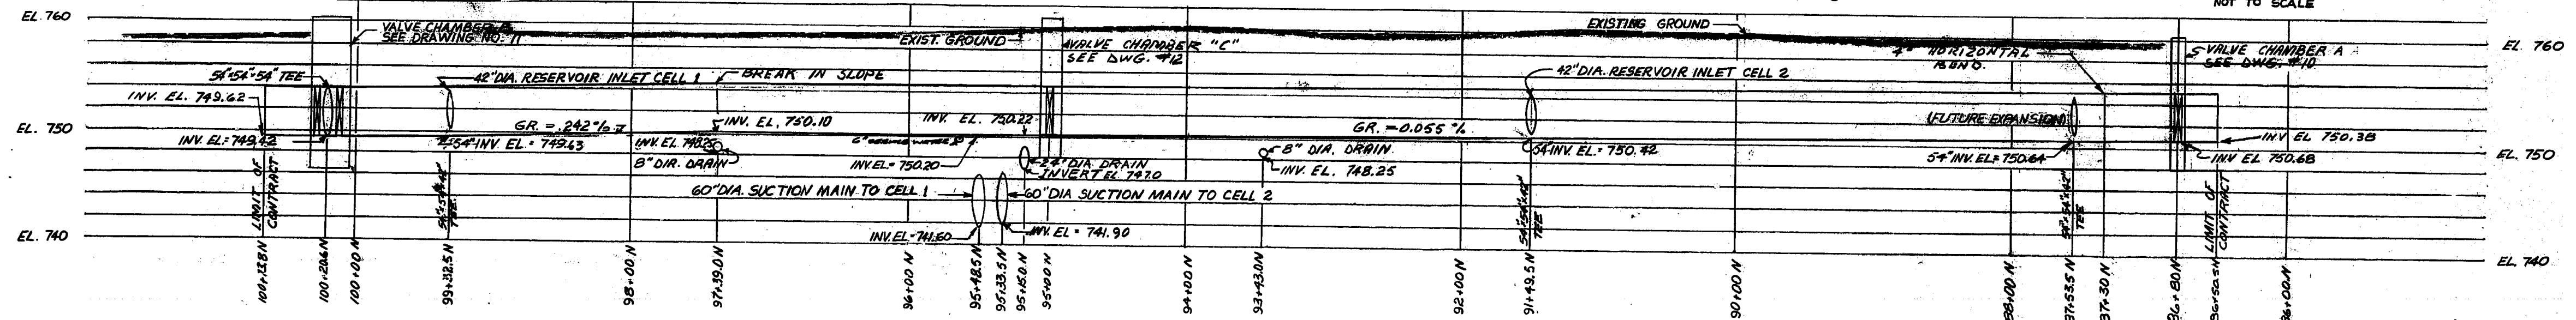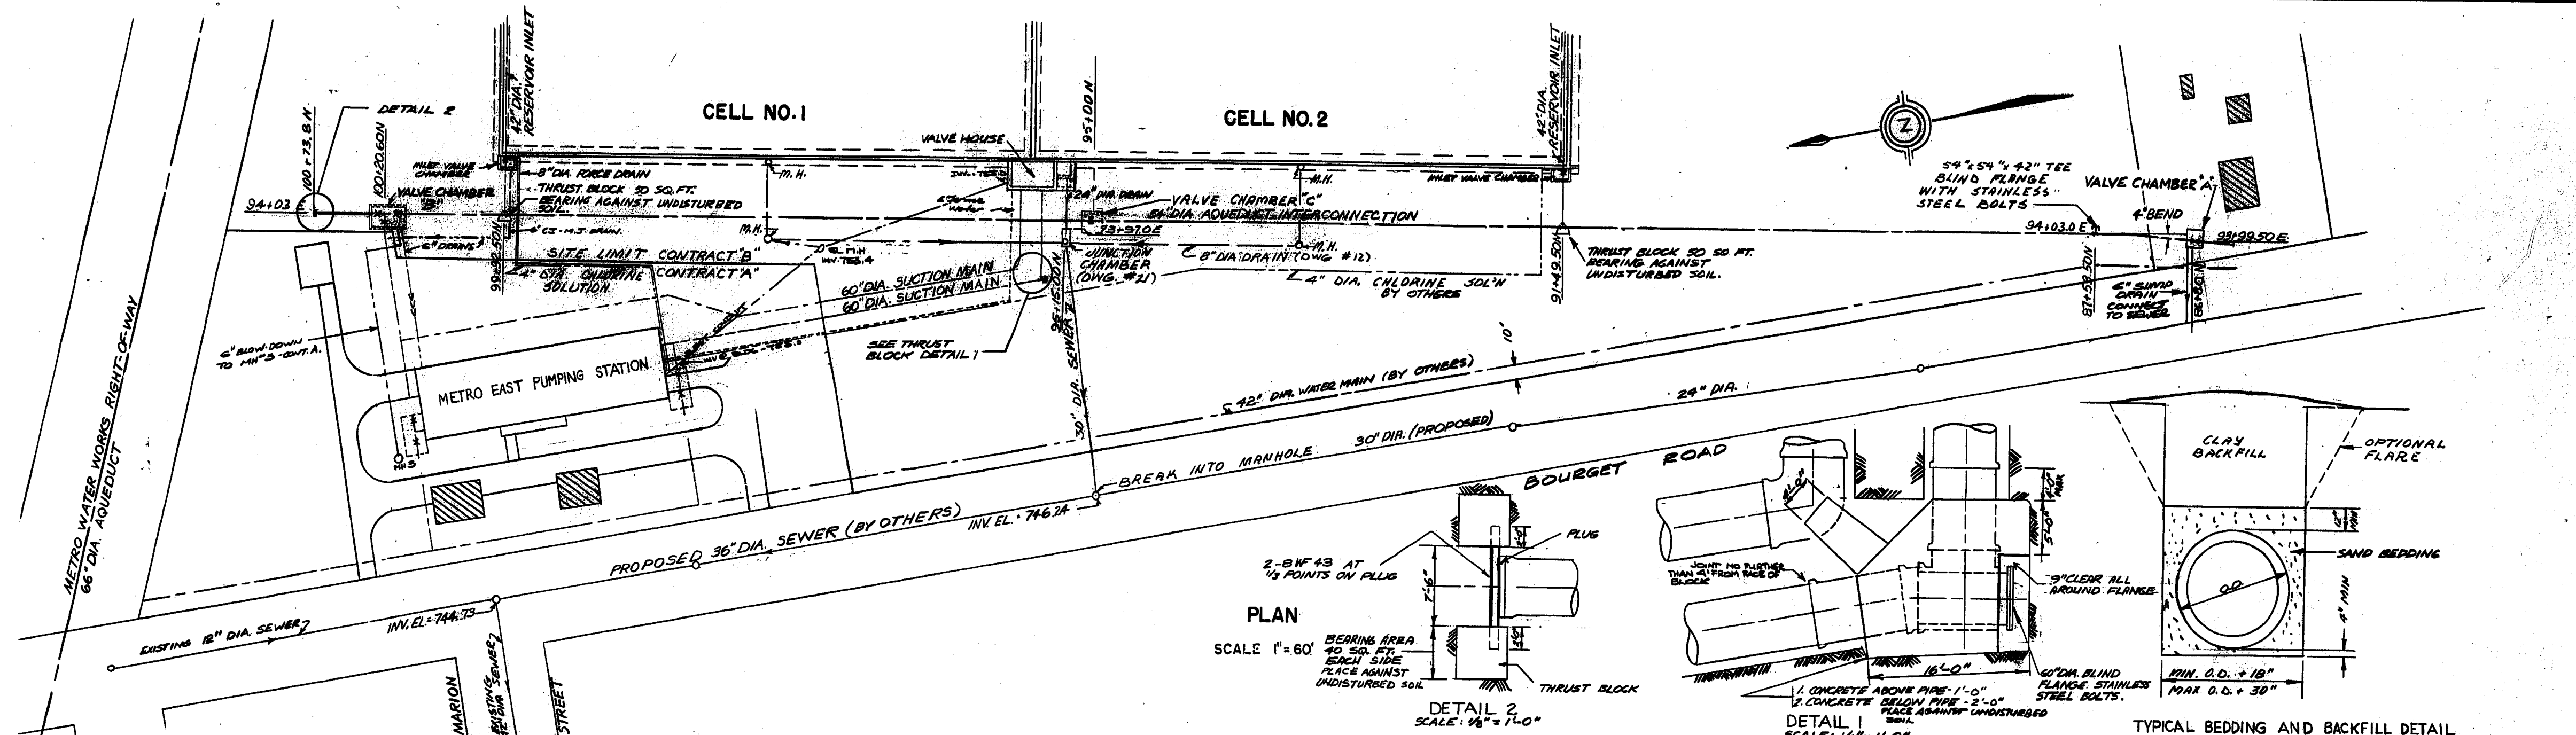

NOTES:
 1. SEE SPECIFICATIONS FOR LIST OF PIPE AND FITTINGS TO BE SUPPLIED BY THE METROPOLITAN CORPORATION.

REVISED AS BUILT, JUNE - 1965
 THE METROPOLITAN CORPORATION OF GREATER WINNIPEG
 WATERWORKS AND WASTE DISPOSAL DIVISION
 METRO EAST PUMPING STATION AND RESERVOIR

**YARD PIPING
 PLAN AND PROFILES**

J. H. MacLaren JAMES P. MACLAREN ASSOCIATES ENGINEER TORONTO		APPROVED J. H. MacLaren DESIGN ENGINEER	
E. J. Smith TOWNSHIP ENGINEERING COMPANY PROFESSIONAL ENGINEER WINNIPEG		E. J. Smith ENGINEER OF WATERWORKS DIRECTOR'S CHIEF ENGINEER	
DATE	JUNE 22, 1962	SCALE	AS SHOWN
DWG. NO.	ME-57	OF	1

