


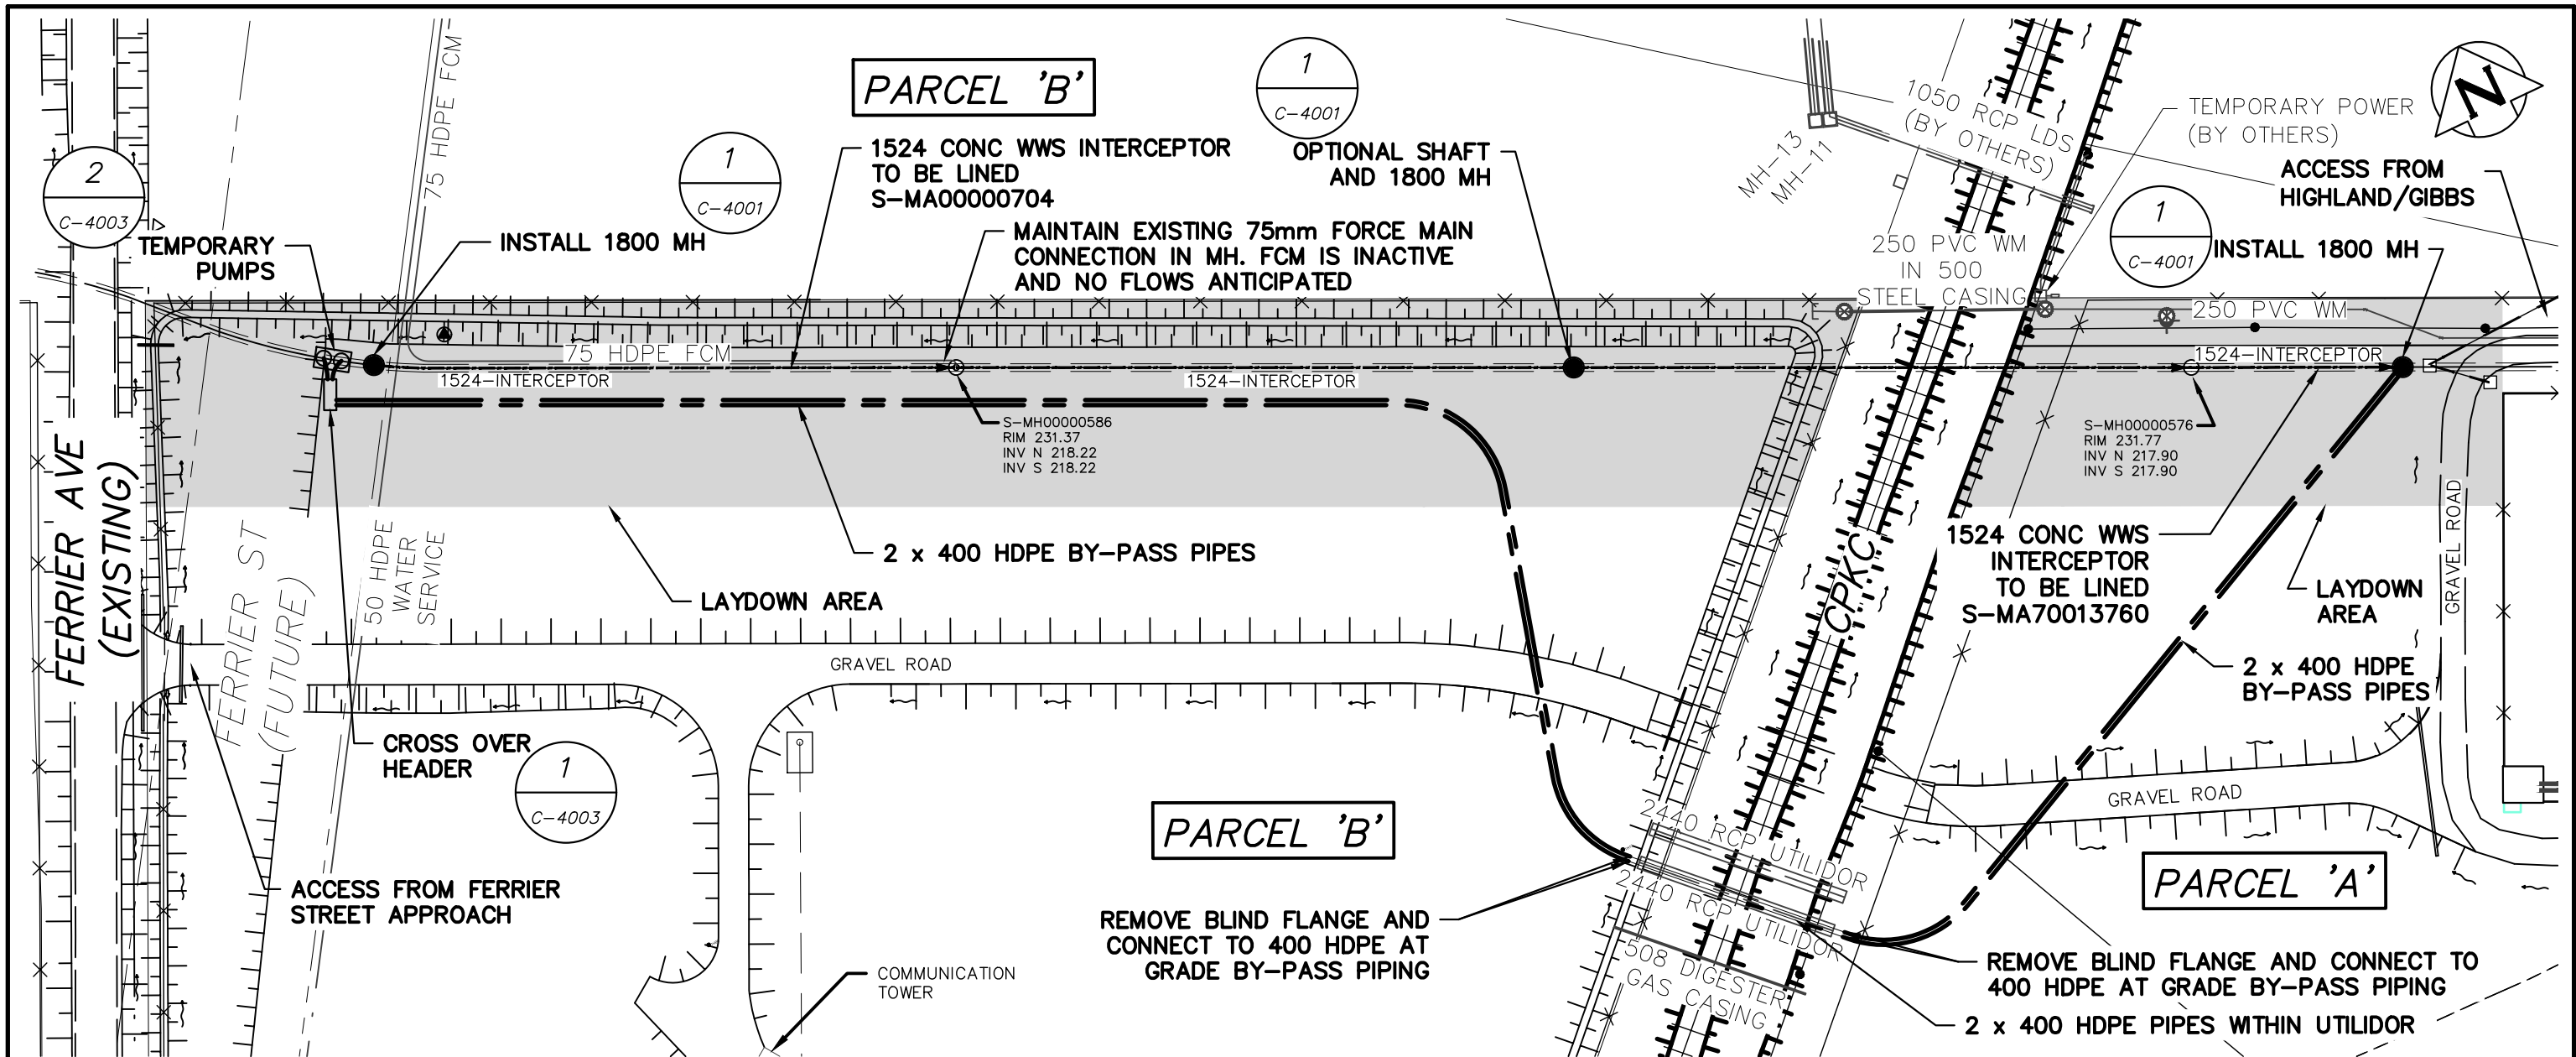

WARNING

IF POWER EQUIPMENT OR EXPLOSIVES ARE TO BE USED FOR EXCAVATION ON THIS PROJECT THE CONTRACTOR MUST:

- 1) NOTIFY THE GAS COMPANY OF THE PROPOSED LOCATION OF EXCAVATION.
- 2) TAKE PRECAUTION TO AVOID DAMAGE TO GAS COMPANY INSTALLATIONS.

SEE PROVINCIAL REGULATION 210/72 FOR DETAILS



**ENGINEERS
GEOSCIENTISTS
MANITOBA**

Certificate of Authorization

AECOM Canada ULC

No. 4671

FOR INDEX SEE
G-0001

METRIC

WHOLE NUMBERS INDICATE MILLIMETRES
DECIMALIZED NUMBERS INDICATE METRES

0.0 25.0 50 75.0 m

LOCATION APPROVED UNDERGROUND STRUCTURES		B.M. ELEV.		AECOM		ENGINEER'S SEAL		 THE CITY OF WINNIPEG WATER AND WASTE DEPARTMENT ENGINEERING DIVISION			
SUPV. U/G STRUCTURES COMMITTEE		DATE									
NOTE:				DESIGNED BY MPG		CHECKED BY MGM		2025 NORTHWEST INTERCEPTOR RENEWAL BY CIPP LINING OVERALL SITE PLAN GENERAL ARRANGEMENT AND BY-PASS PUMPING PLAN		SHEET 3 OF 8	
LOCATION OF UNDERGROUND STRUCTURES AS SHOWN ARE BASED ON THE BEST INFORMATION AVAILABLE BUT NO GUARANTEE IS GIVEN THAT ALL EXISTING UTILITIES ARE SHOWN OR THAT THE GIVEN LOCATIONS ARE EXACT. CONFIRMATION OF EXISTENCE AND EXACT LOCATION OF ALL SERVICES MUST BE OBTAINED FROM THE INDIVIDUAL UTILITIES BEFORE PROCEEDING WITH CONSTRUCTION.				DRAWN BY JP /ES		APPROVED BY CCM				CITY DRAWING NUMBER	
				SCALE: HORIZONTAL 1:1250 VERTICAL		RELEASED FOR CONSTRUCTION Stacy Cournoyer		CONSULTANT DRAWING NUMBER C-0001		3	
				DATE 2025/10/29		DATE 2025/10/29					
		0 ISSUED FOR TENDER 2025/10/31 ADL									
		NO. REVISIONS DATE BY		DATE 2025/10/29							