



LAST SAVE: 2025/04/29 - 1:16pm
PATH: C:\Users\jicko\pdfs\1-0650M-S0033-001-00.dwg

A1 SIZE - 594mm x 841mm

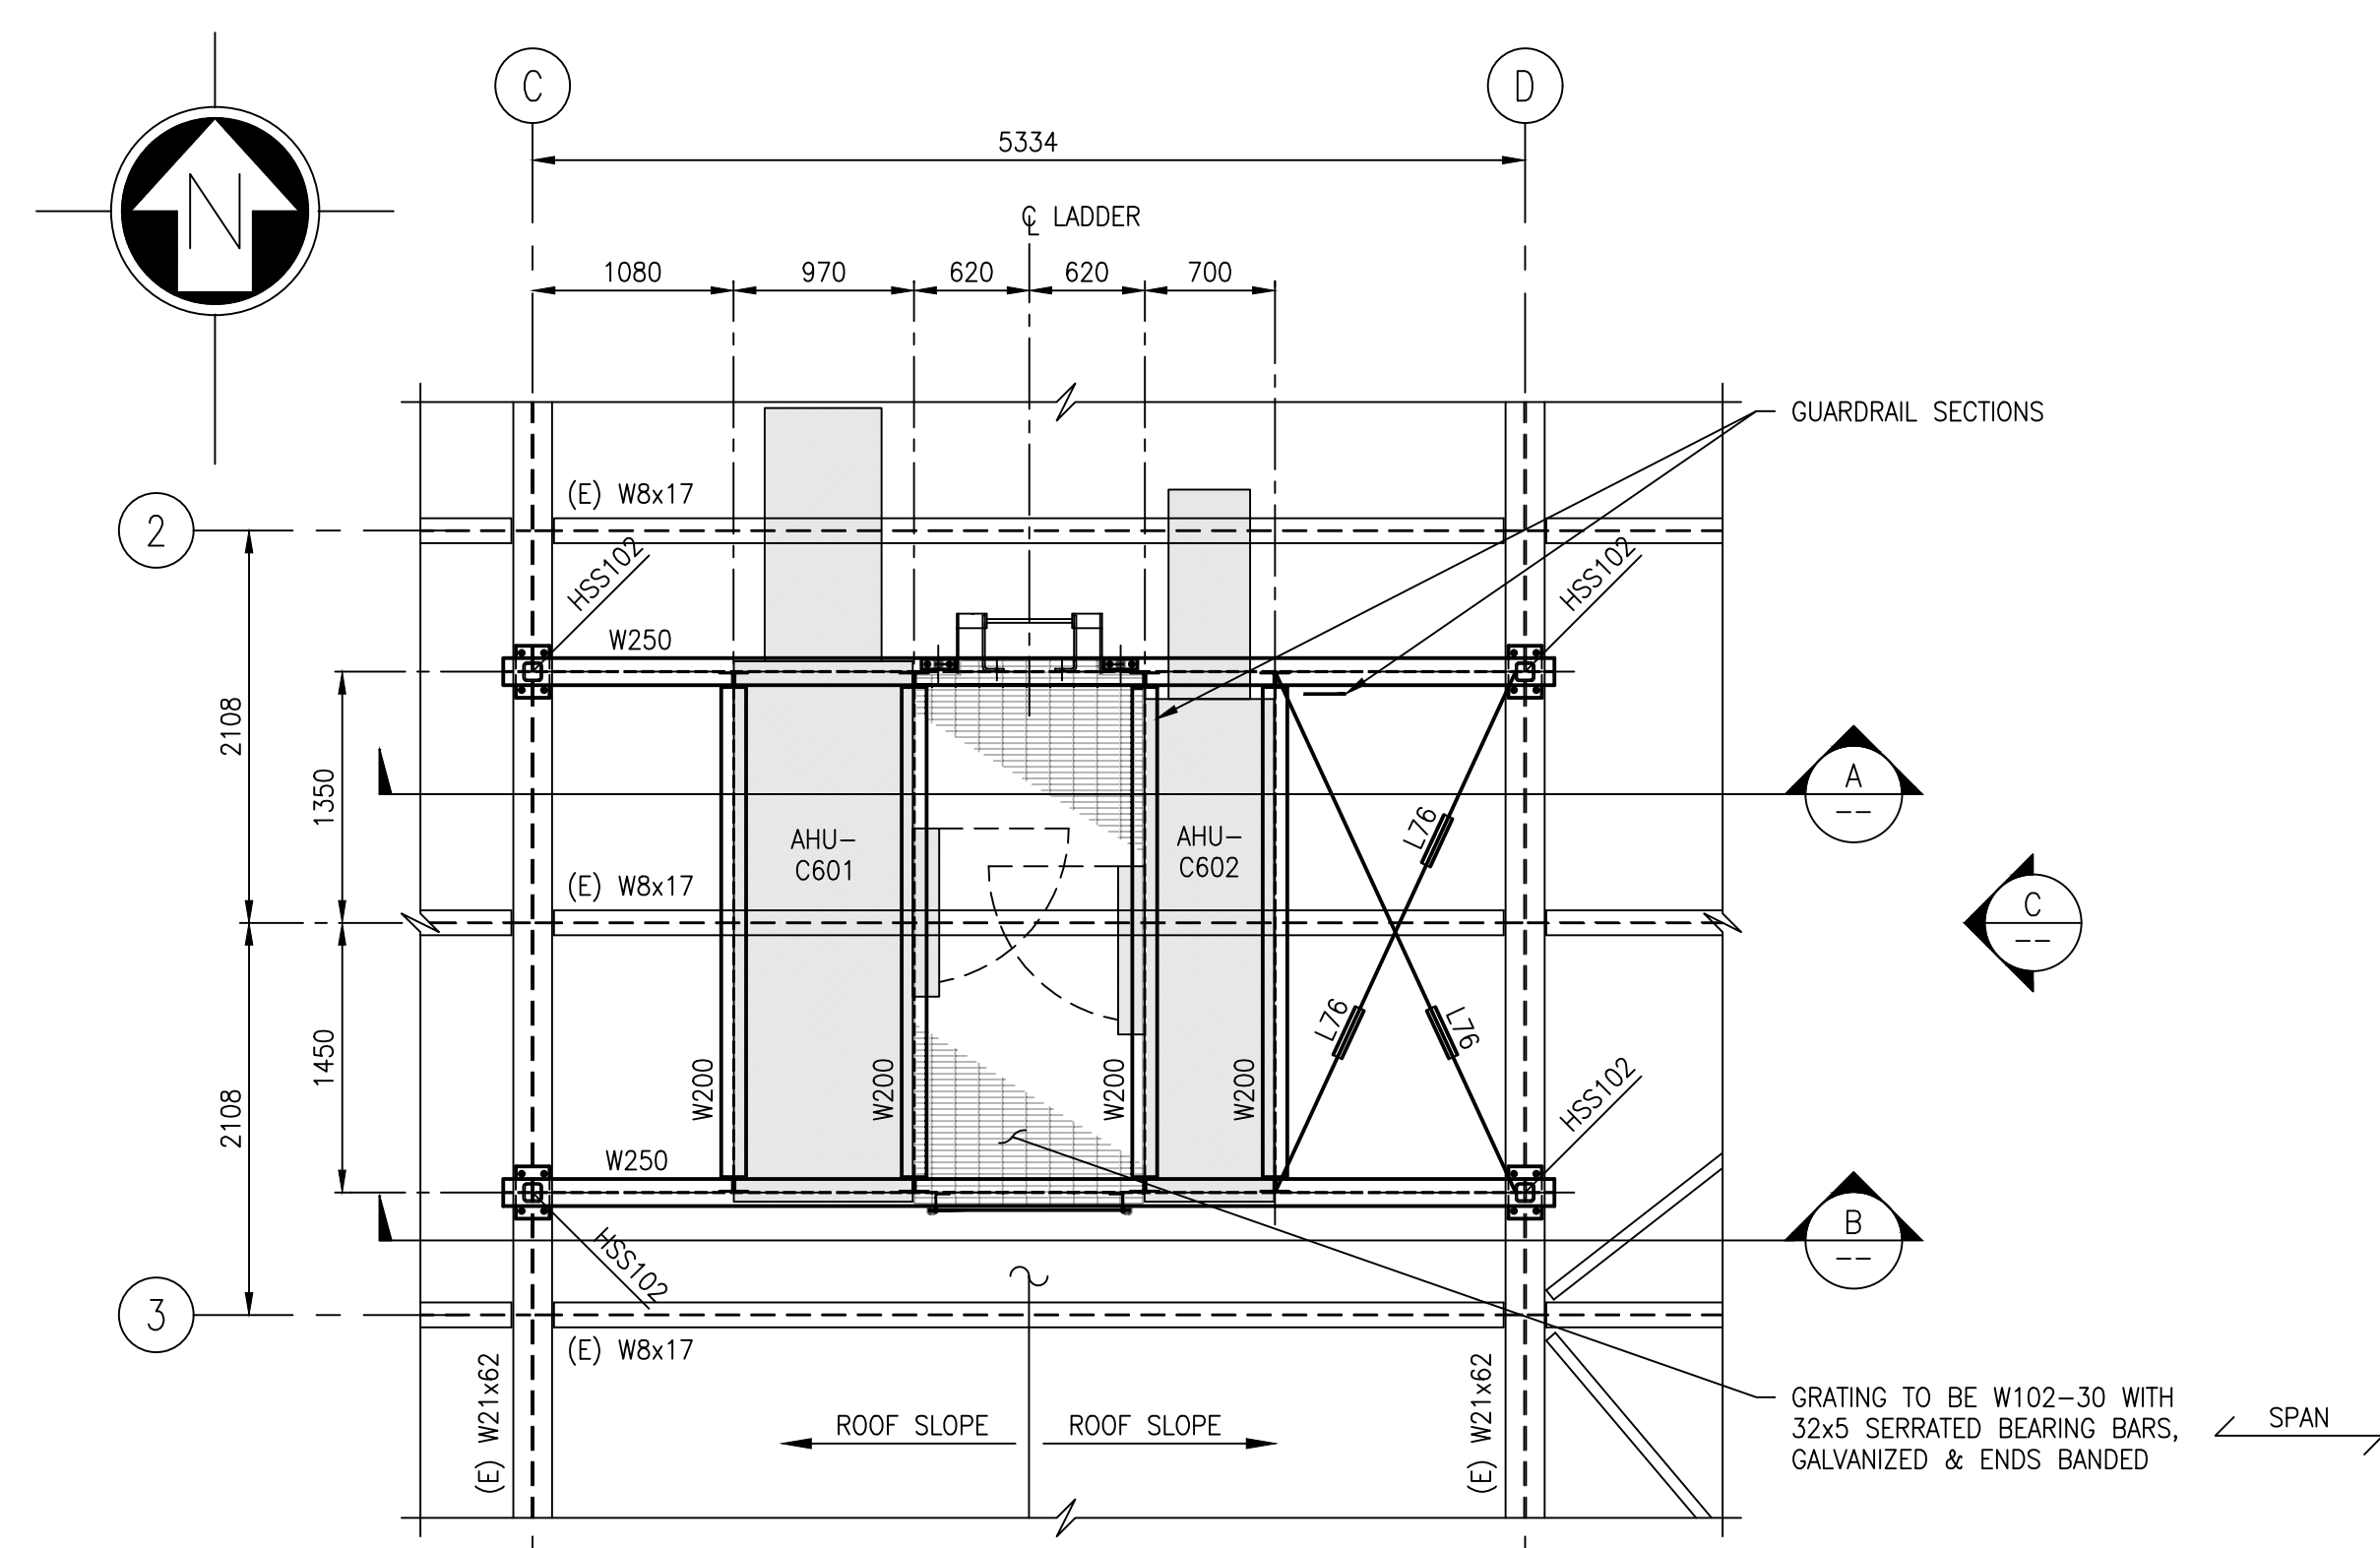


PLAN - PARTIAL ROOF
SCALE: 1 : 40

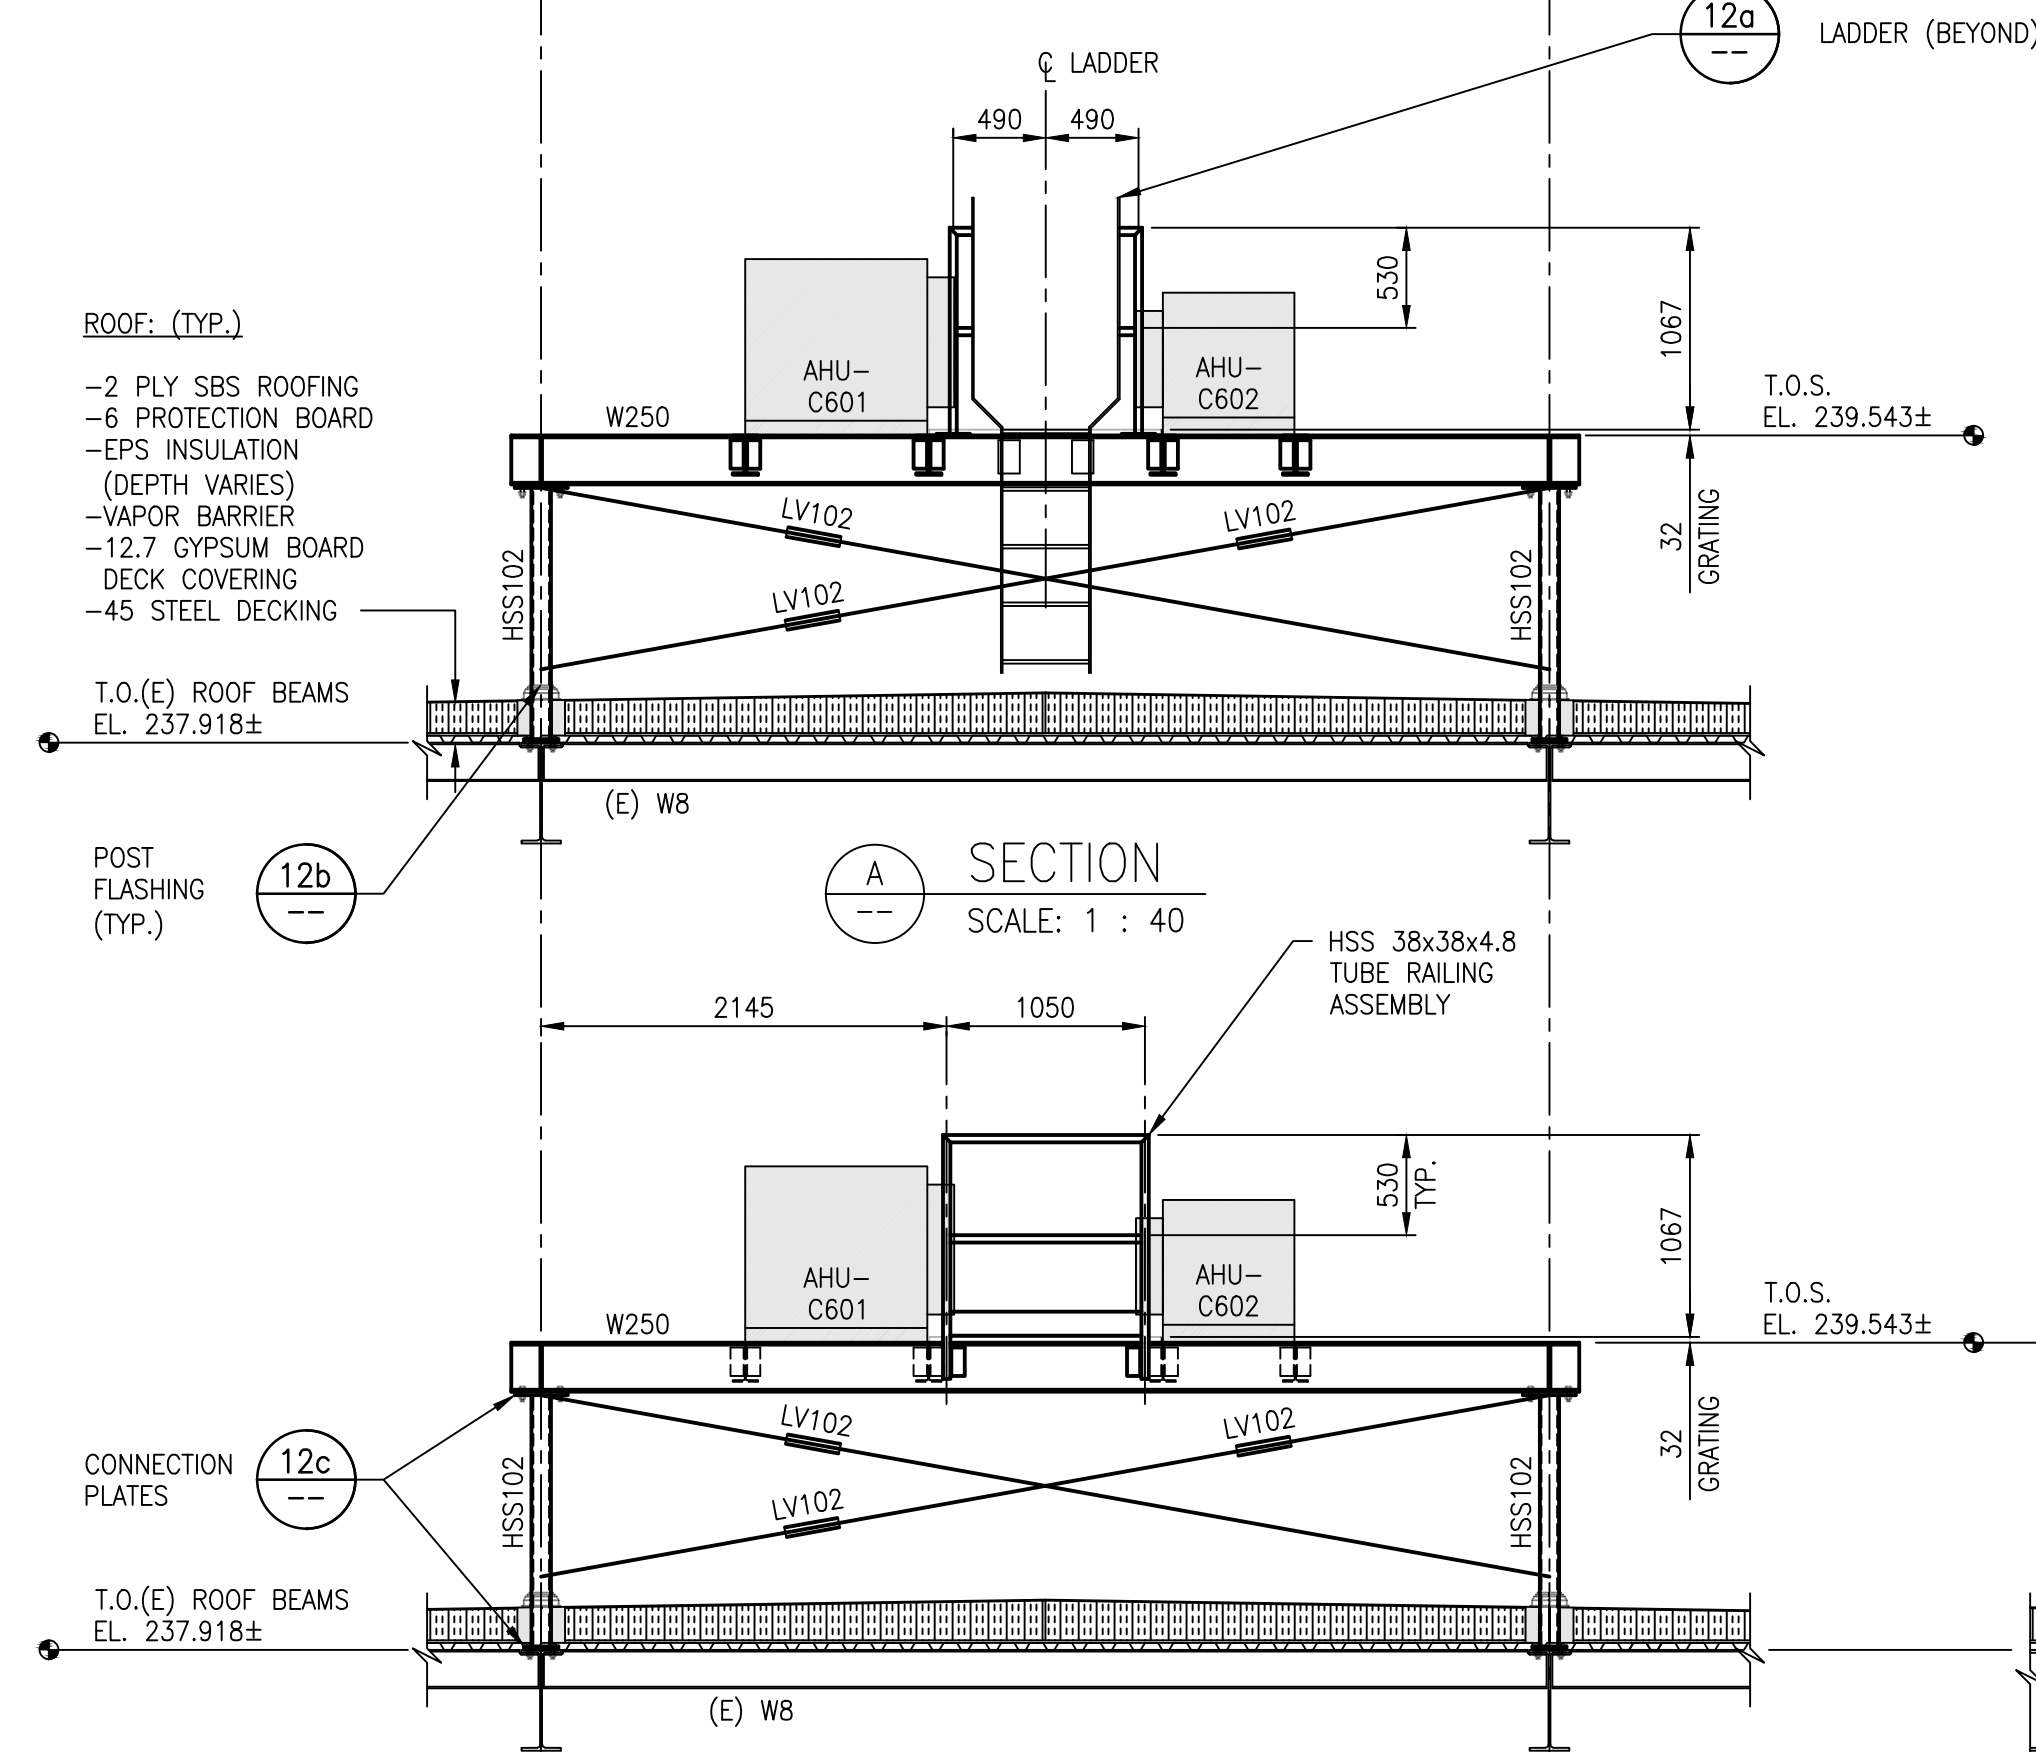

SECTION A-A
SCALE: 1 : 40




SECTION B-B
SCALE: 1 : 40

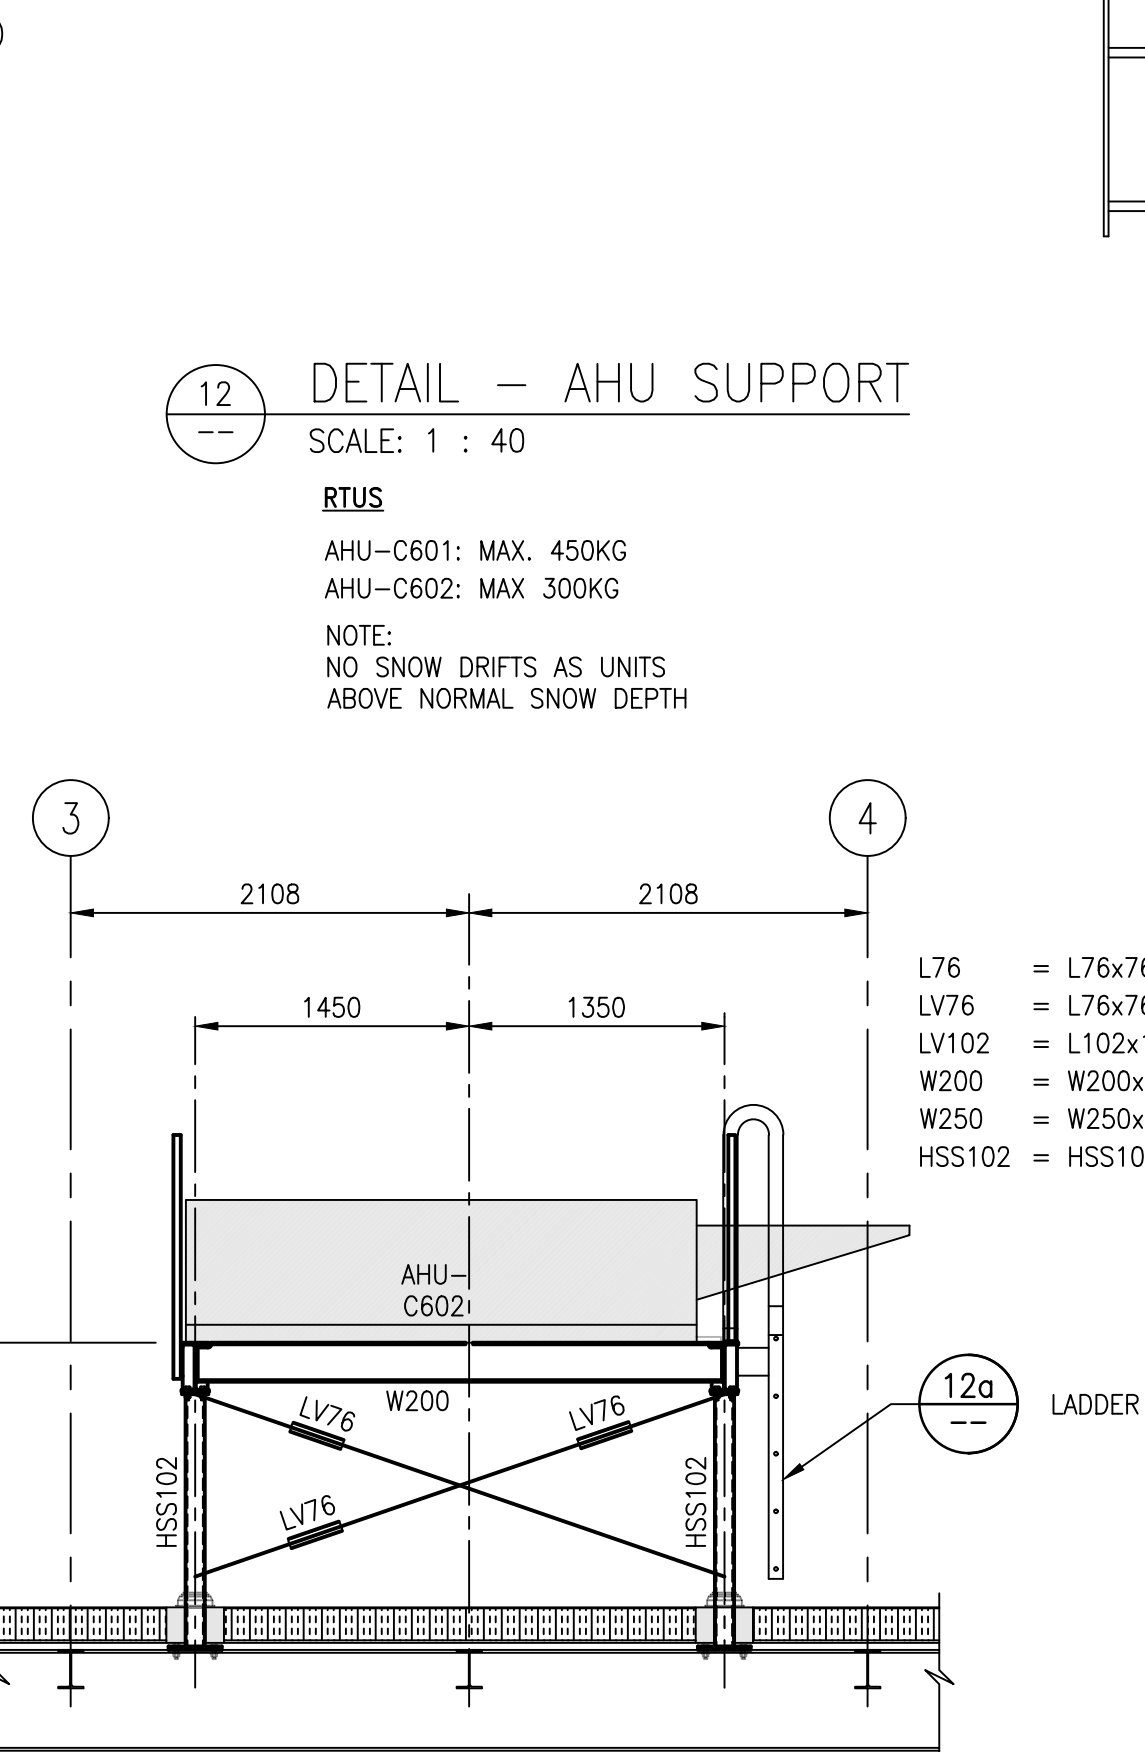


ELEVATION C-C
SCALE: 1 : 40


(LV76 CROSS BRACING TYP. @ BOTH COLUMN BAYS)

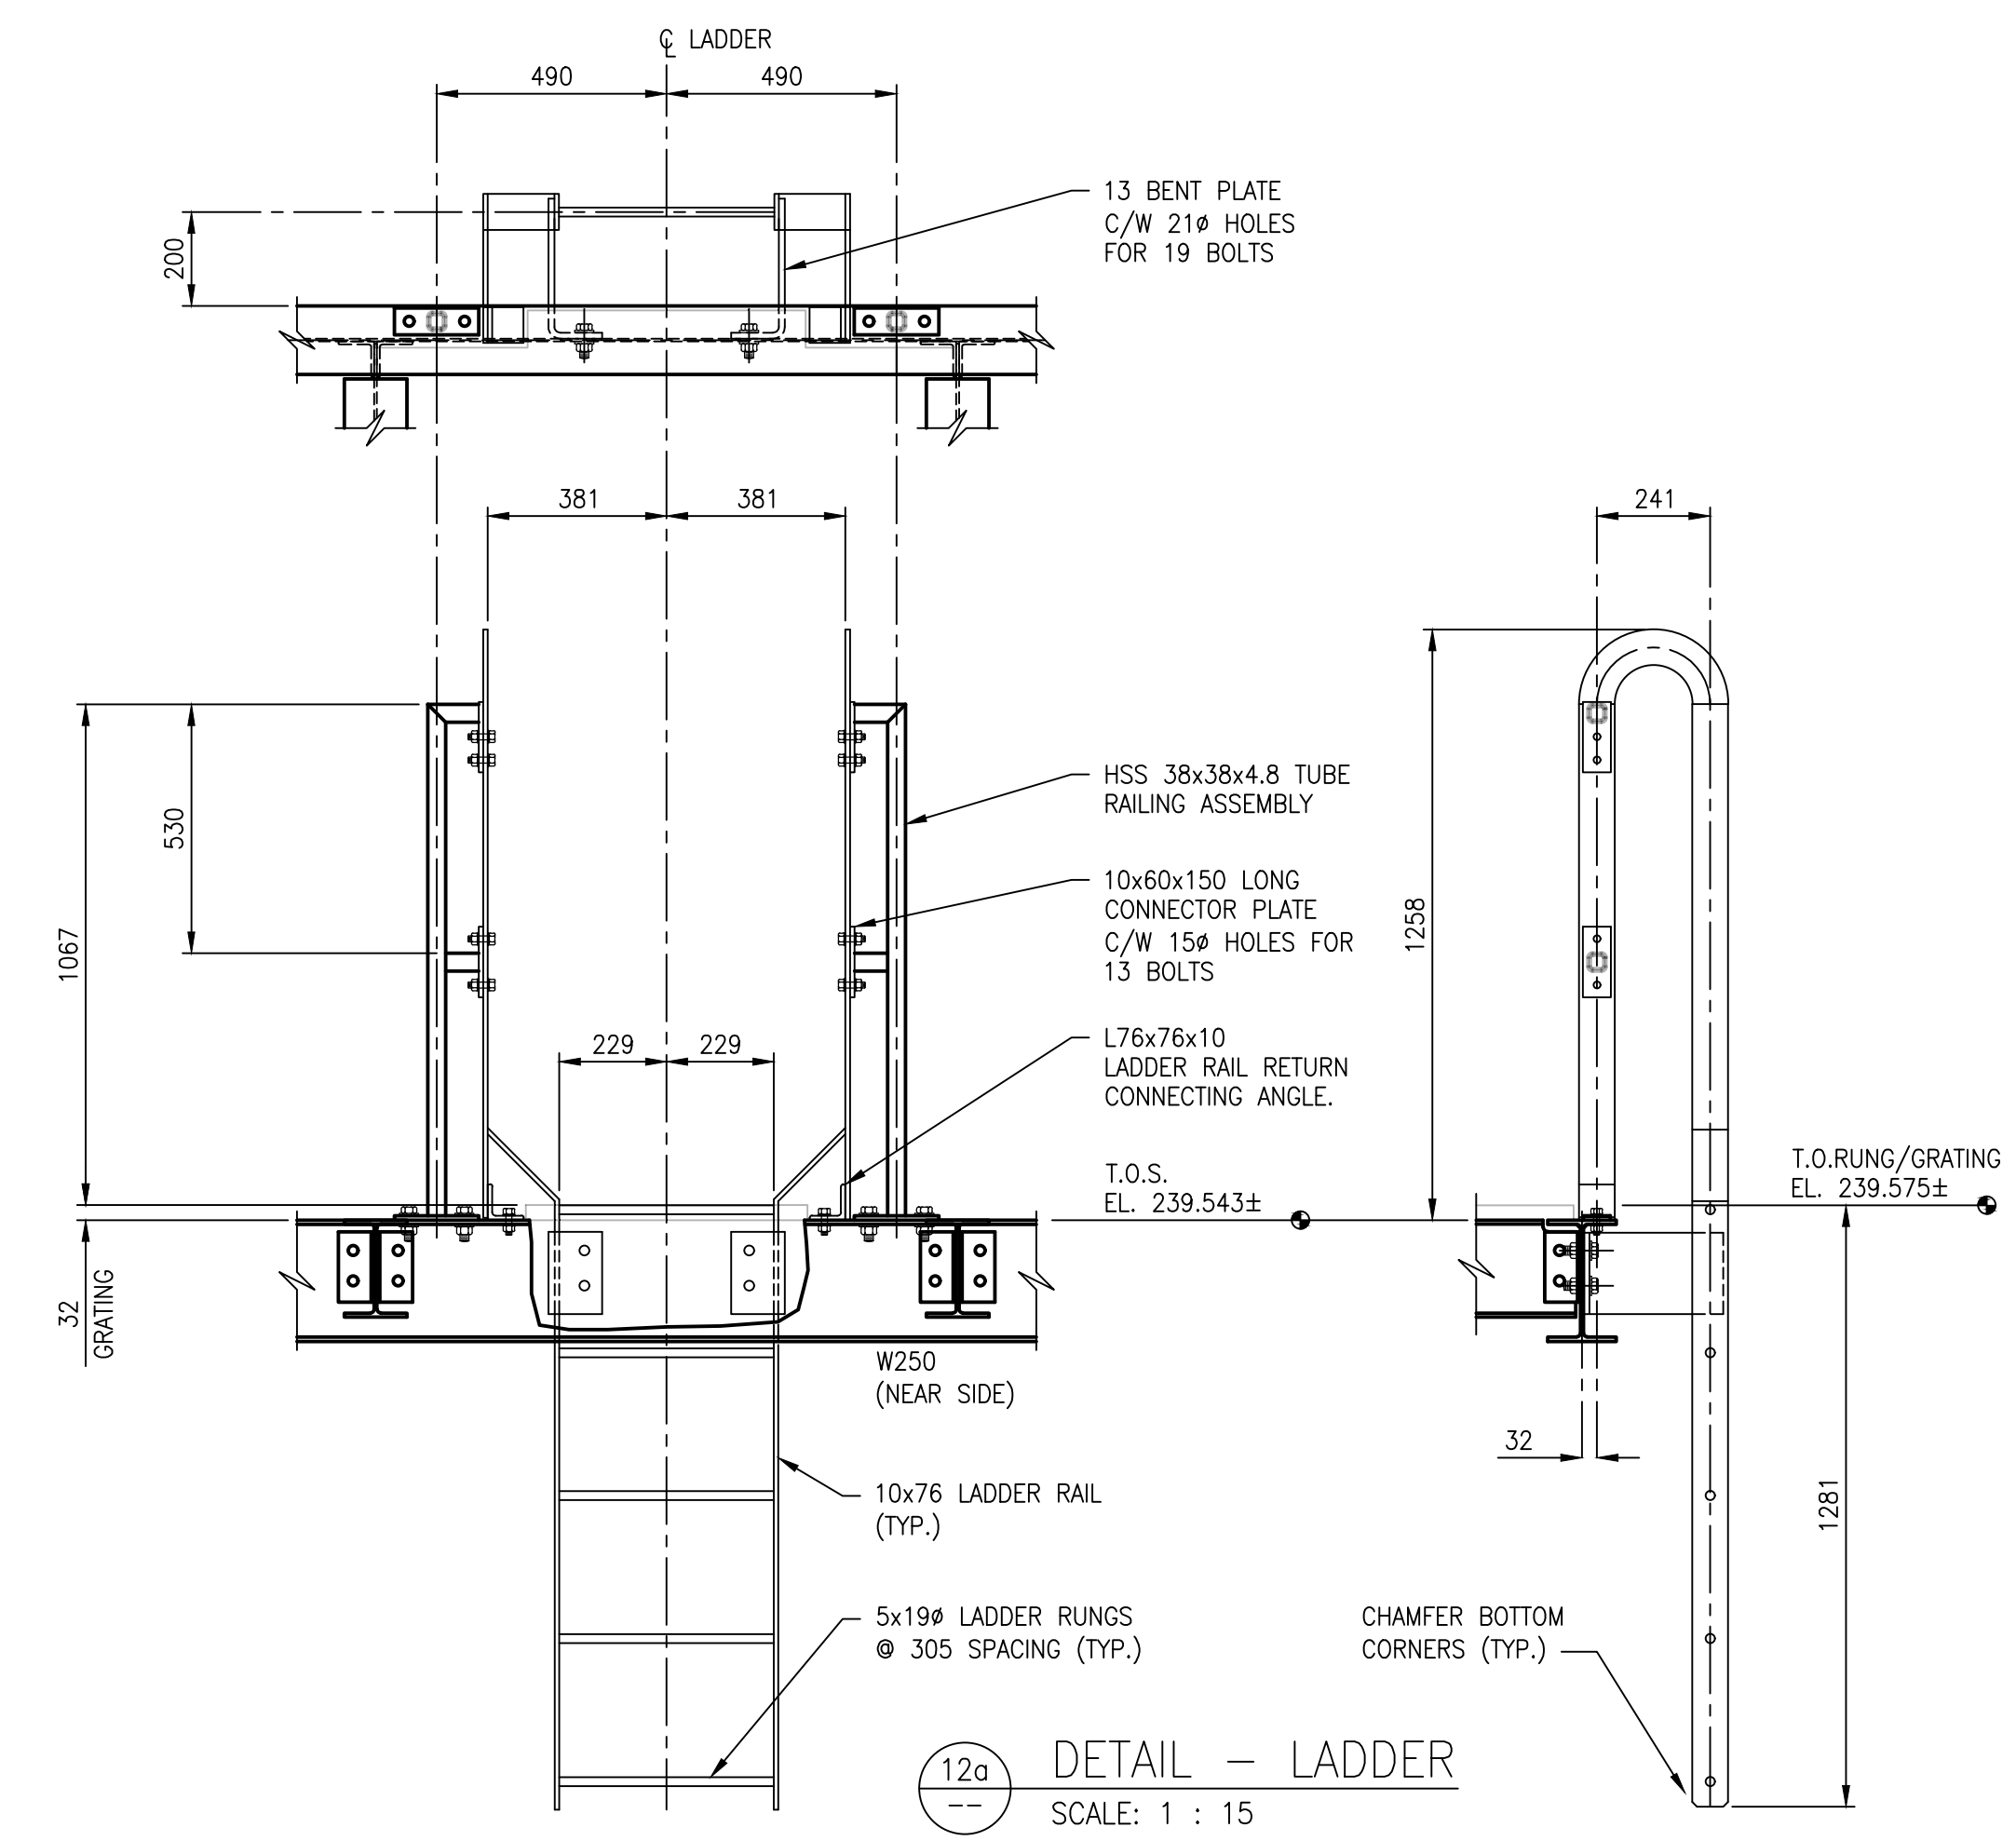


DETAIL - LADDER
SCALE: 1 : 15

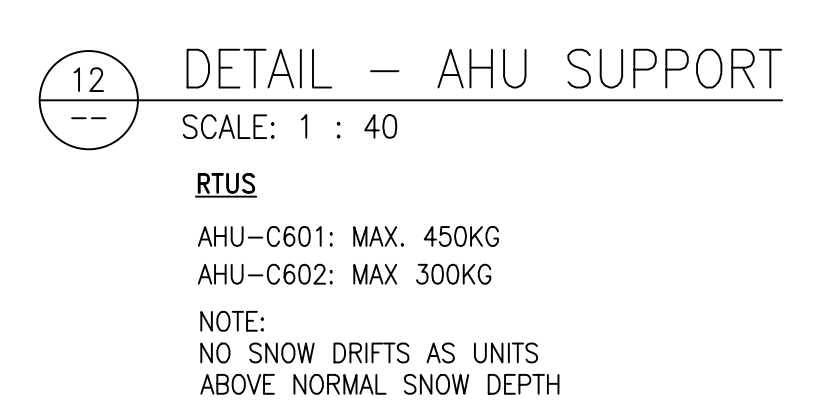

DETAIL - AHU SUPPORT
SCALE: 1 : 40

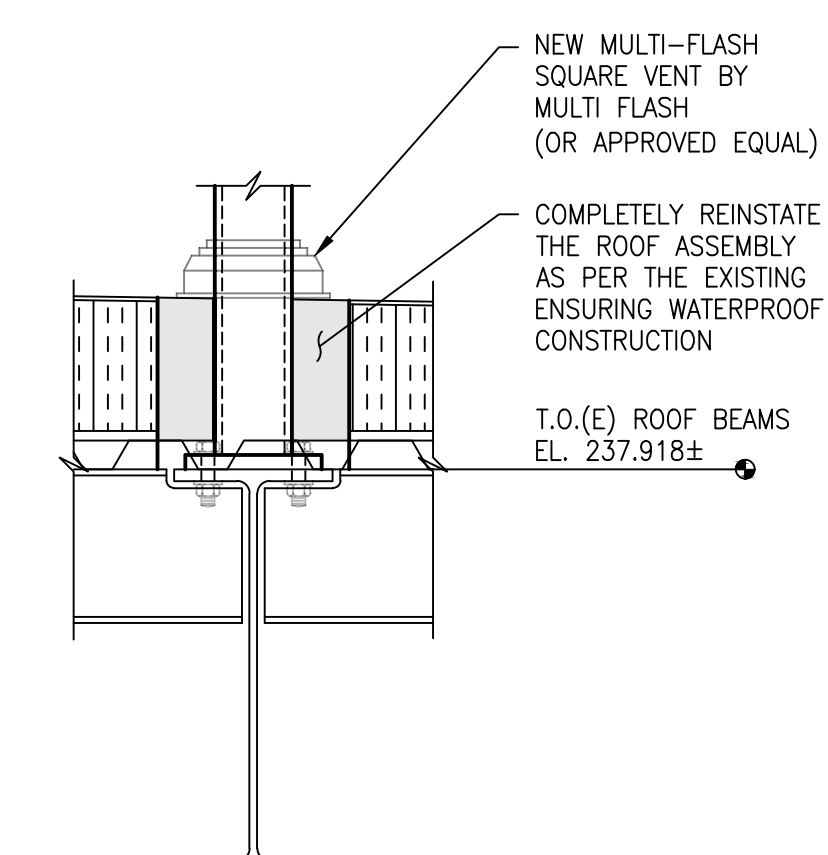


DETAIL - COLUMN FLASHING
SCALE: 1 : 10

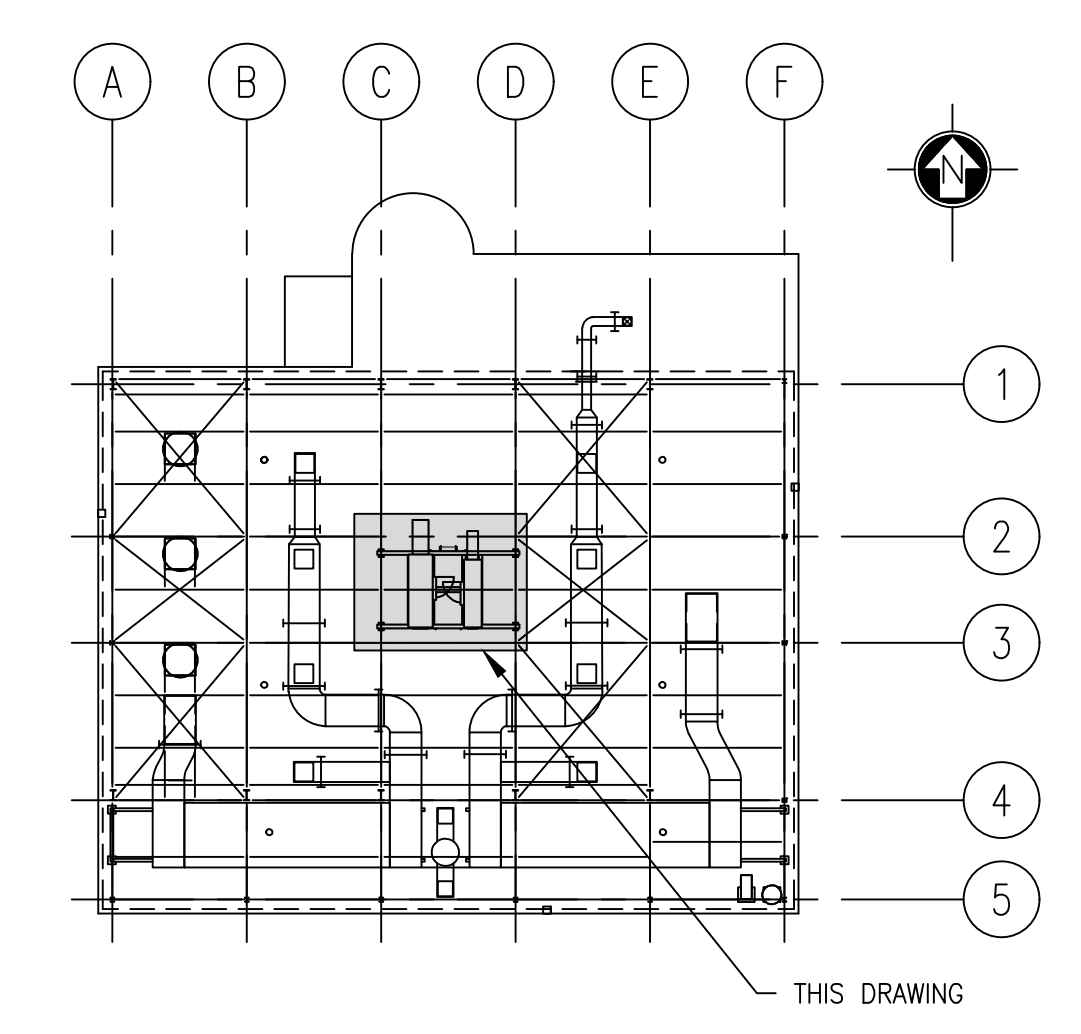

KEY PLAN - ROOF
SCALE: 1 : 300


NOTES:
1. SEE DRAWING 1-0650M-S0023-001 & 1-0650M-S0023-002 FOR GENERAL NOTES.

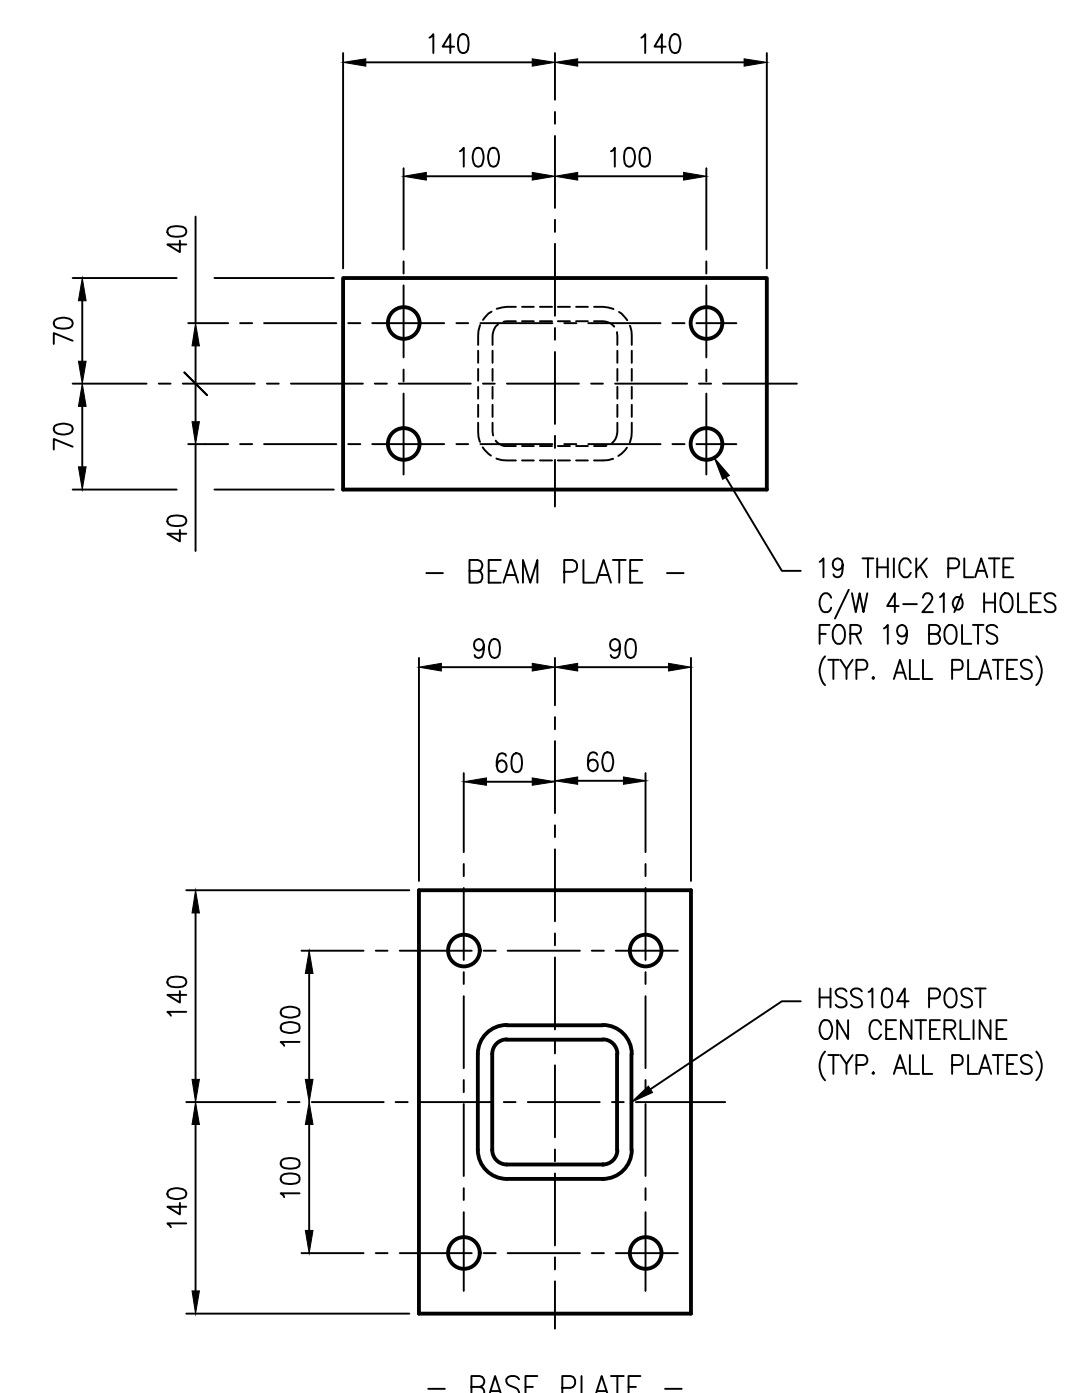

DETAIL - COLUMN PLATES
SCALE: 1 : 5

5 9.151 SHEET 11

WILKES AVE. PUMPING STATION - ROOF FRAMING PLAN
REFERENCE DRAWINGS

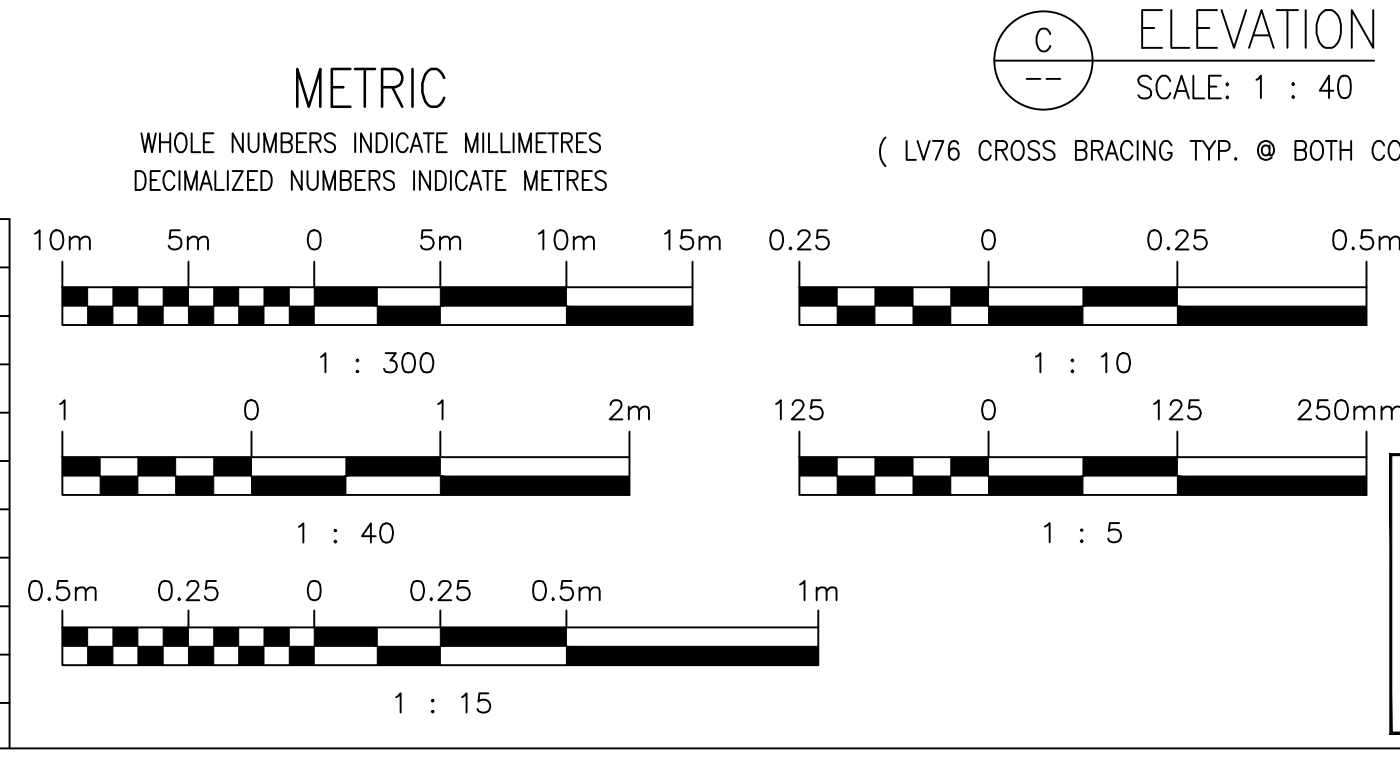

**ENGINEERS
GEOSCIENTISTS
MANITOBA**
Certificate of Authorization
AtkinsRéalis Canada Inc.
No. 4489

DESIGNED BY: K. KOTYK	CHECKED BY: F. MARSHALL
DRAWN BY: B. DICKSON	APPROVED BY: V. ELIMBAN
SCALE: AS NOTED	ISSUED FOR CONSTRUCTION BY: M. SKINNER
DATE: 2023-03-06	DATE: 2025/04/30
ISSUED FOR TENDER AND CONSTRUCTION	CONSULTANT NO.: 694715
NO. REVISIONS	DATE DESIGN CHECK

ENGINEER'S SEAL	THE CITY OF WINNIPEG WATER AND WASTE DEPARTMENT
HURST PUMPING STATION CHLORINE SYSTEM UPGRADE STRUCTURAL NEW WORK - AHU SUPPORT FRAME PLAN, ELEVATIONS & DETAILS	CITY DRAWING NUMBER 1-0650M-S0033
SHEET 001	REV. 00
SIZE A1	

1-0650M-S0033-001-00.dwg