


A1 SIZE - 594mm x 841mm

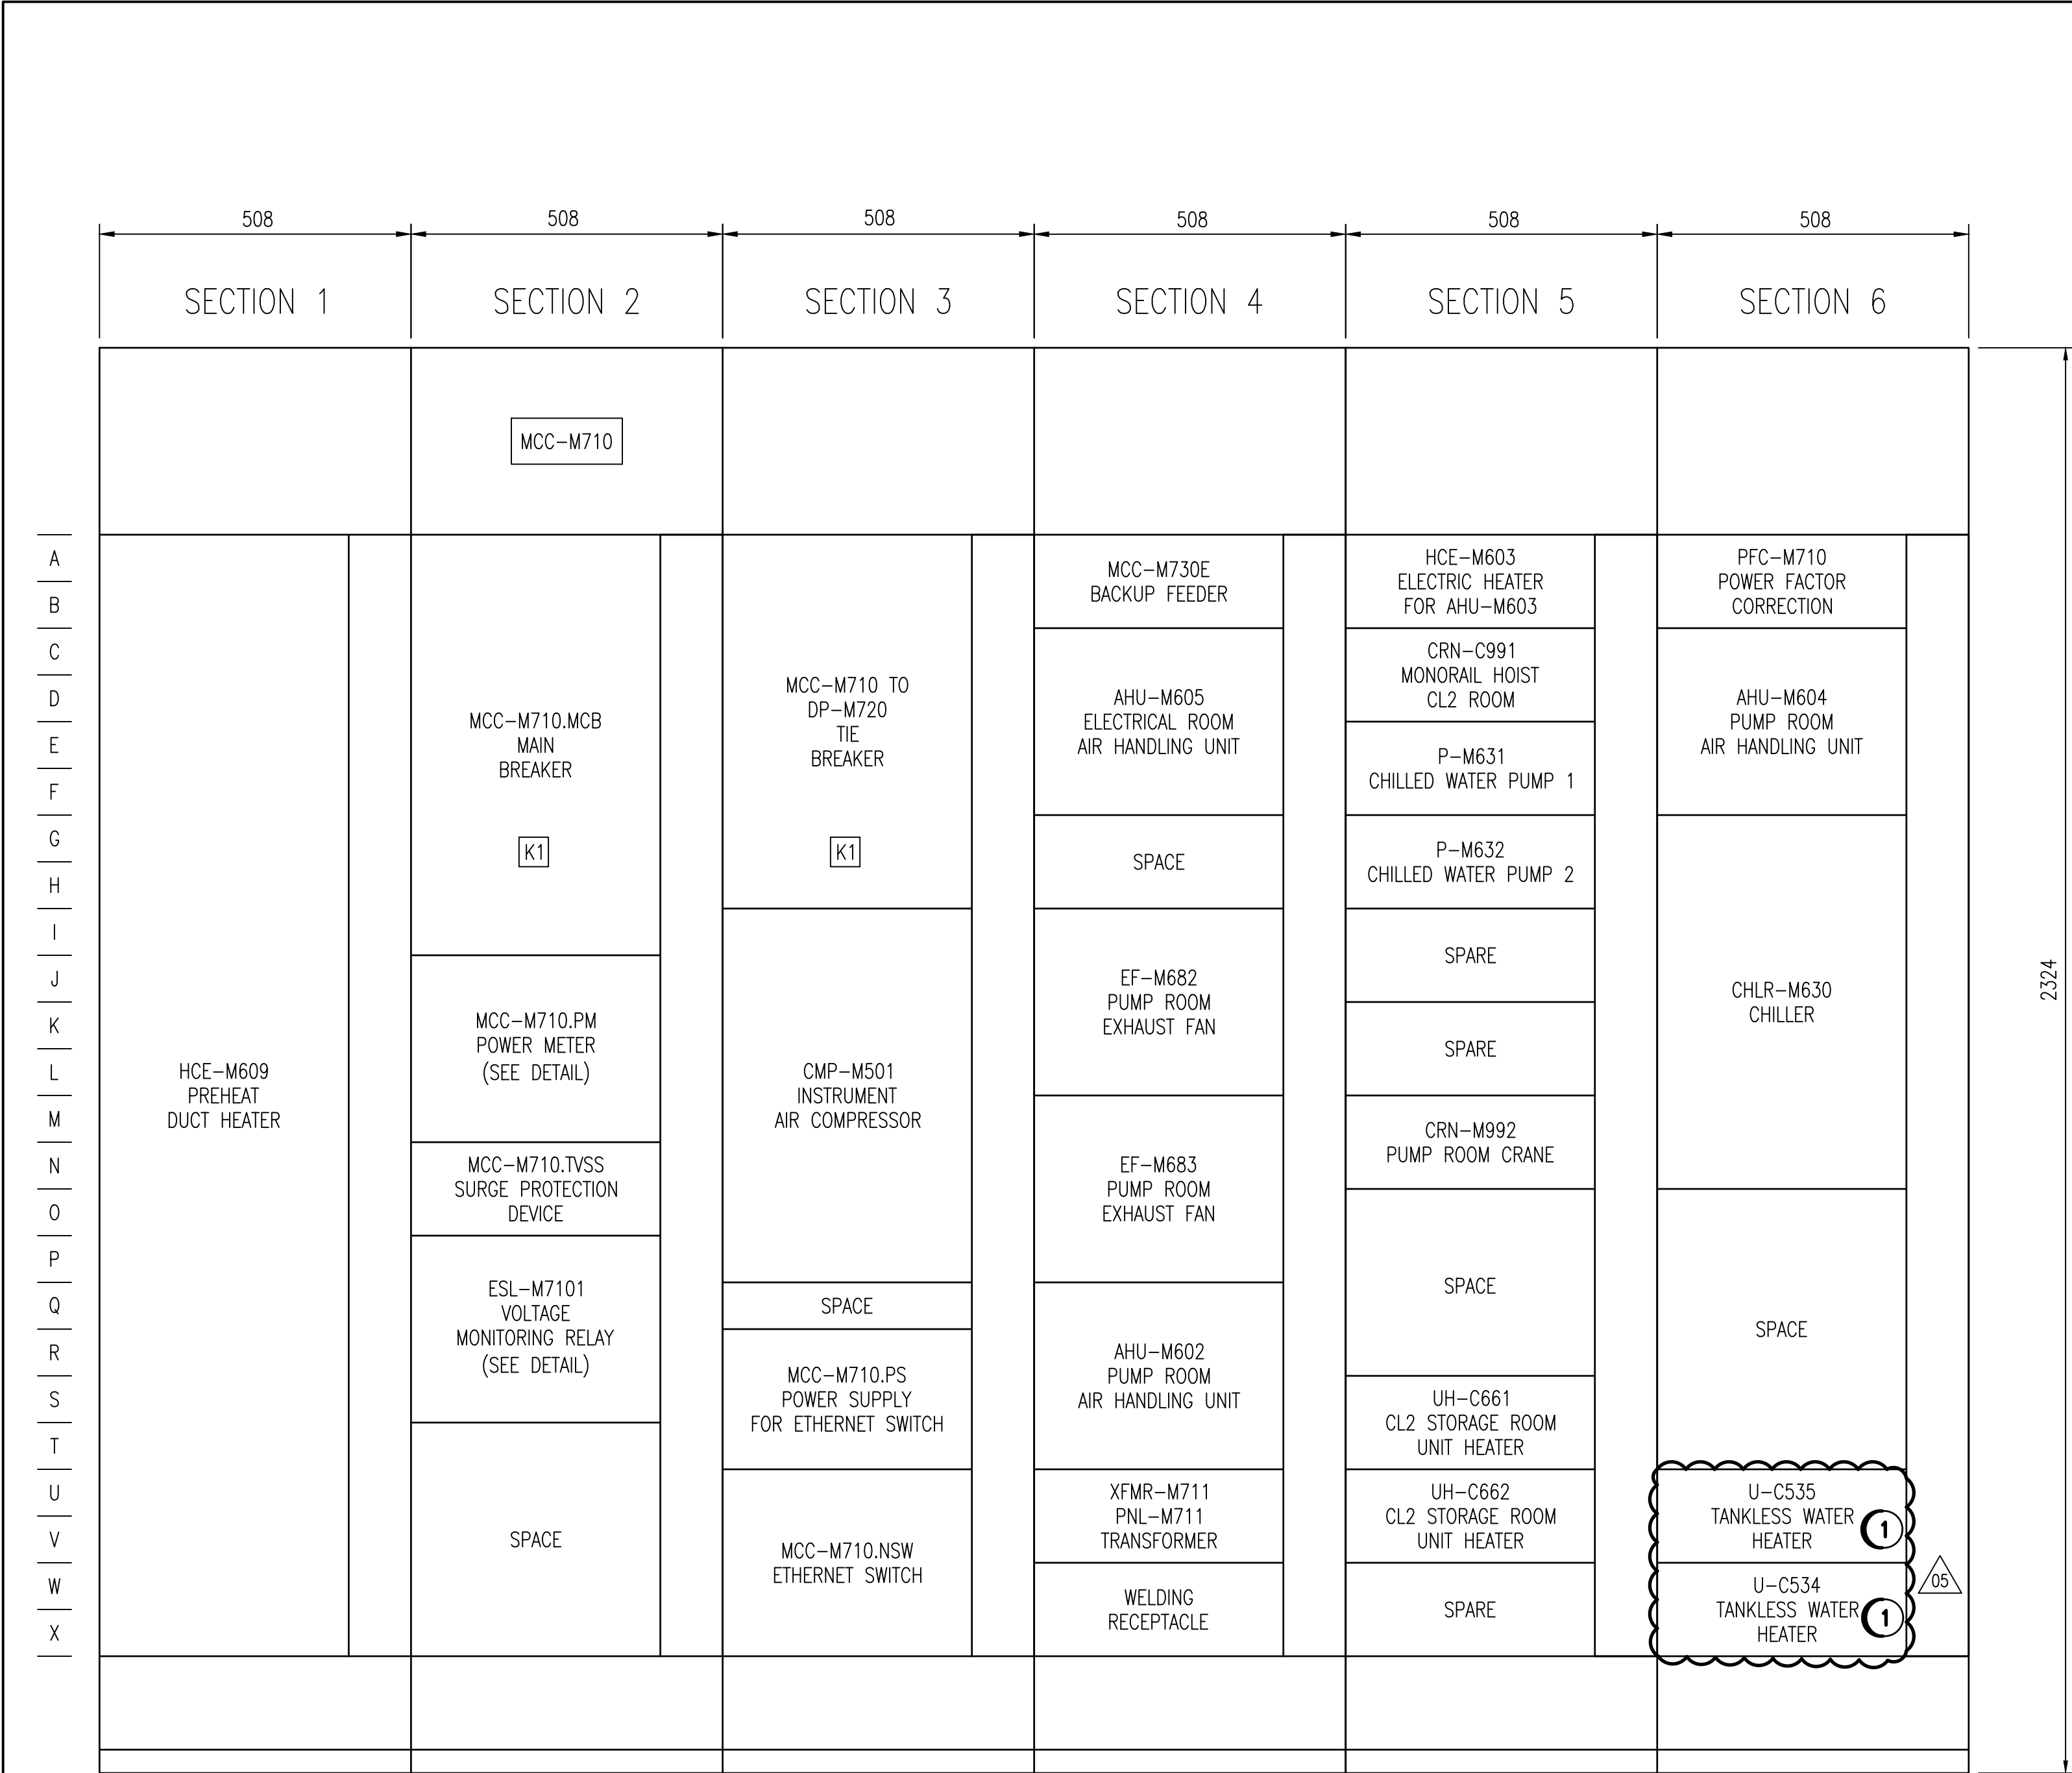

MCC-M710 ELEVATION - 'NON-ESSENTIAL'
SCALE: NTS

SPECIFIC NOTES

1 PROVIDE NEW MCC BUCKET C/W WITH 125A CIRCUIT BREAKER TO FEED NEW CHLORINE TANKLESS HEATERS. PROVIDE NEW LAMACIODS



1-0630M-E0066	JB-M732U-1 LAYOUT AND SCHEMATIC
1-0630M-E0028	MCC SCHEDULES
1-0630M-E0023	MCC-M710 SINGLE LINE DIAGRAM
DRAWING NUMBER	REFERENCE DRAWINGS



					 AtkinsRéalis 148 Nature Park Way, Winnipeg, Manitoba Canada R3P 0X7 204-786-8080		ENGINEER'S SEAL THE CITY OF WINNIPEG WATER AND WASTE DEPARTMENT MACLEAN WATER PUMPING STATION MCC ELEVATION AND DETAILS MCC-M710 CITY DRAWING NUMBER 1-0630M-E0026 SHEET 001 REV. 05 SIZE A1		
05	ISSUED FOR TENDER AND CONSTRUCTION	2025/04/30	VE	VE	DESIGNED BY: B. CLEVEN	CHECKED BY: C. REIMER			
04	REVISED PER CHILLER REPLACEMENT	2021/02/04	JDB	BJC	DRAWN BY: M.J. PERSSON	APPROVED BY: C. REIMER			
03	AS-BUILT	2013/07/24	-	BJC	SCALE: NTS	ISSUED FOR CONSTRUCTION BY: R. CARROLL			
02	ISSUED FOR CONSTRUCTION	2012/11/29	BJC	CJR	DATE: 2011/12/19	DATE: 2012/11/29			
01	ADDENDUM 1, BID OPP. 490-2012	2012/08/14	BJC	CJR					
00	ISSUED FOR TENDER, BID OPP. 490-2012	2012/07/23	BJC	CJR	CONSULTANT NO.: 508955-0000-47DD-0026				
NO.	REVISIONS	DATE	DESIGN	CHECK					