


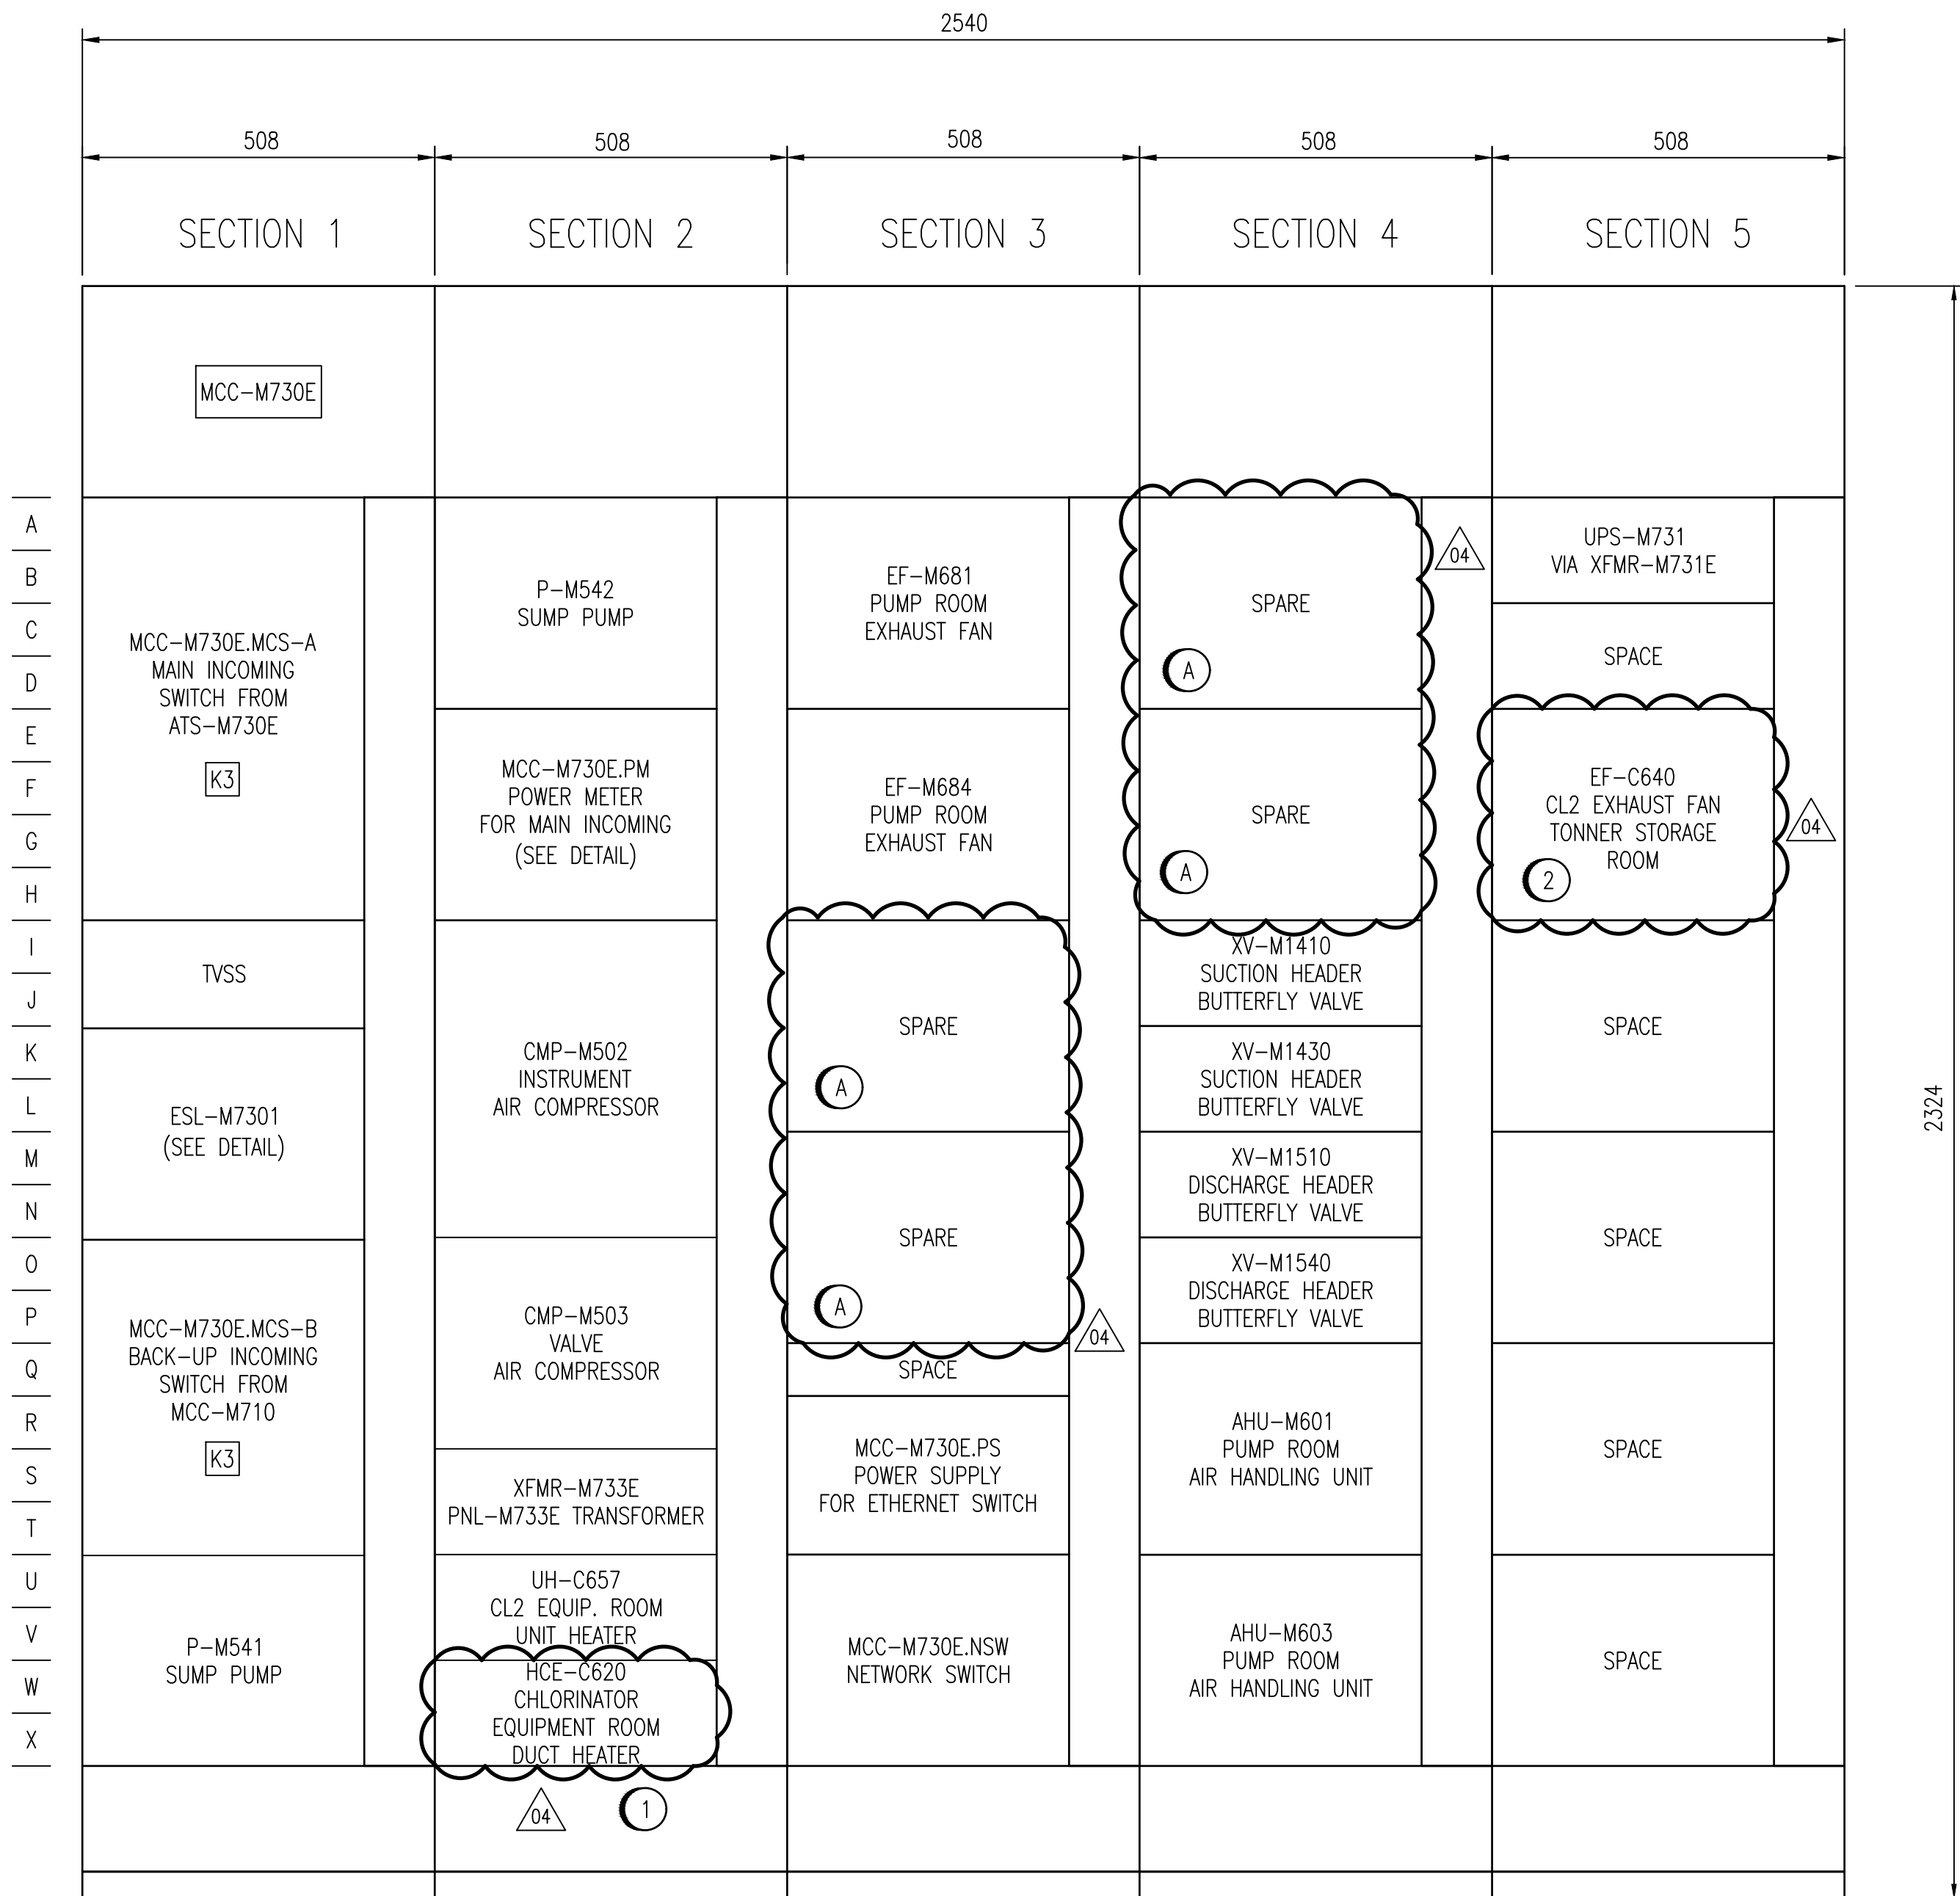

MCC-M730E - FRONT ELEVATION
SCALE: NTS

DEMOLITION NOTES:


- 01 REMOVE CABLING/CONDUIT TO MCC-C730E EXHAUST FANS EF-C690, C692, C686, AND C689. PROVIDE NEW LAMACOID INDICATING 'SPARE'.

SPECIFIC NOTES:

- 01 PROVIDE NEW MCC BUCKET C/W WITH 30A CIRCUIT BREAKER TO FEED NEW CHLORINE EQUIPMENT ROOM DUCT HEATER. REFER TO SCHEMATIC DRAWING 1-0630M-E0078 FOR MORE DETAILS. MODIFY MCC ACCORDINGLY IF MCC BUCKET PROVIDED BY VENDOR IS A DIFFERENT SIZE. PROVIDE NEW LAMACOID
- 02 PROVIDE NEW MCC BUCKET C/W WITH 15A CIRCUIT BREAKER TO FEED NEW CHLORINE EQUIPMENT EXHAUST FAN. REFER TO MOTOR SCHEMATIC DRAWING 1-0630M-E0079 FOR MORE DETAILS. MODIFY MCC ACCORDINGLY IF MCC BUCKET PROVIDED BY VENDOR IS A DIFFERENT SIZE. PROVIDE NEW LAMACOID

1-0630M-E0066	JB-M732U-1 LAYOUT AND SCHEMATIC
1-0630M-E0025	MCC-M730E SINGLE LINE DIAGRAM
1-0630M-E0028	MCC SCHEDULES

DRAWING NUMBER REFERENCE DRAWINGS

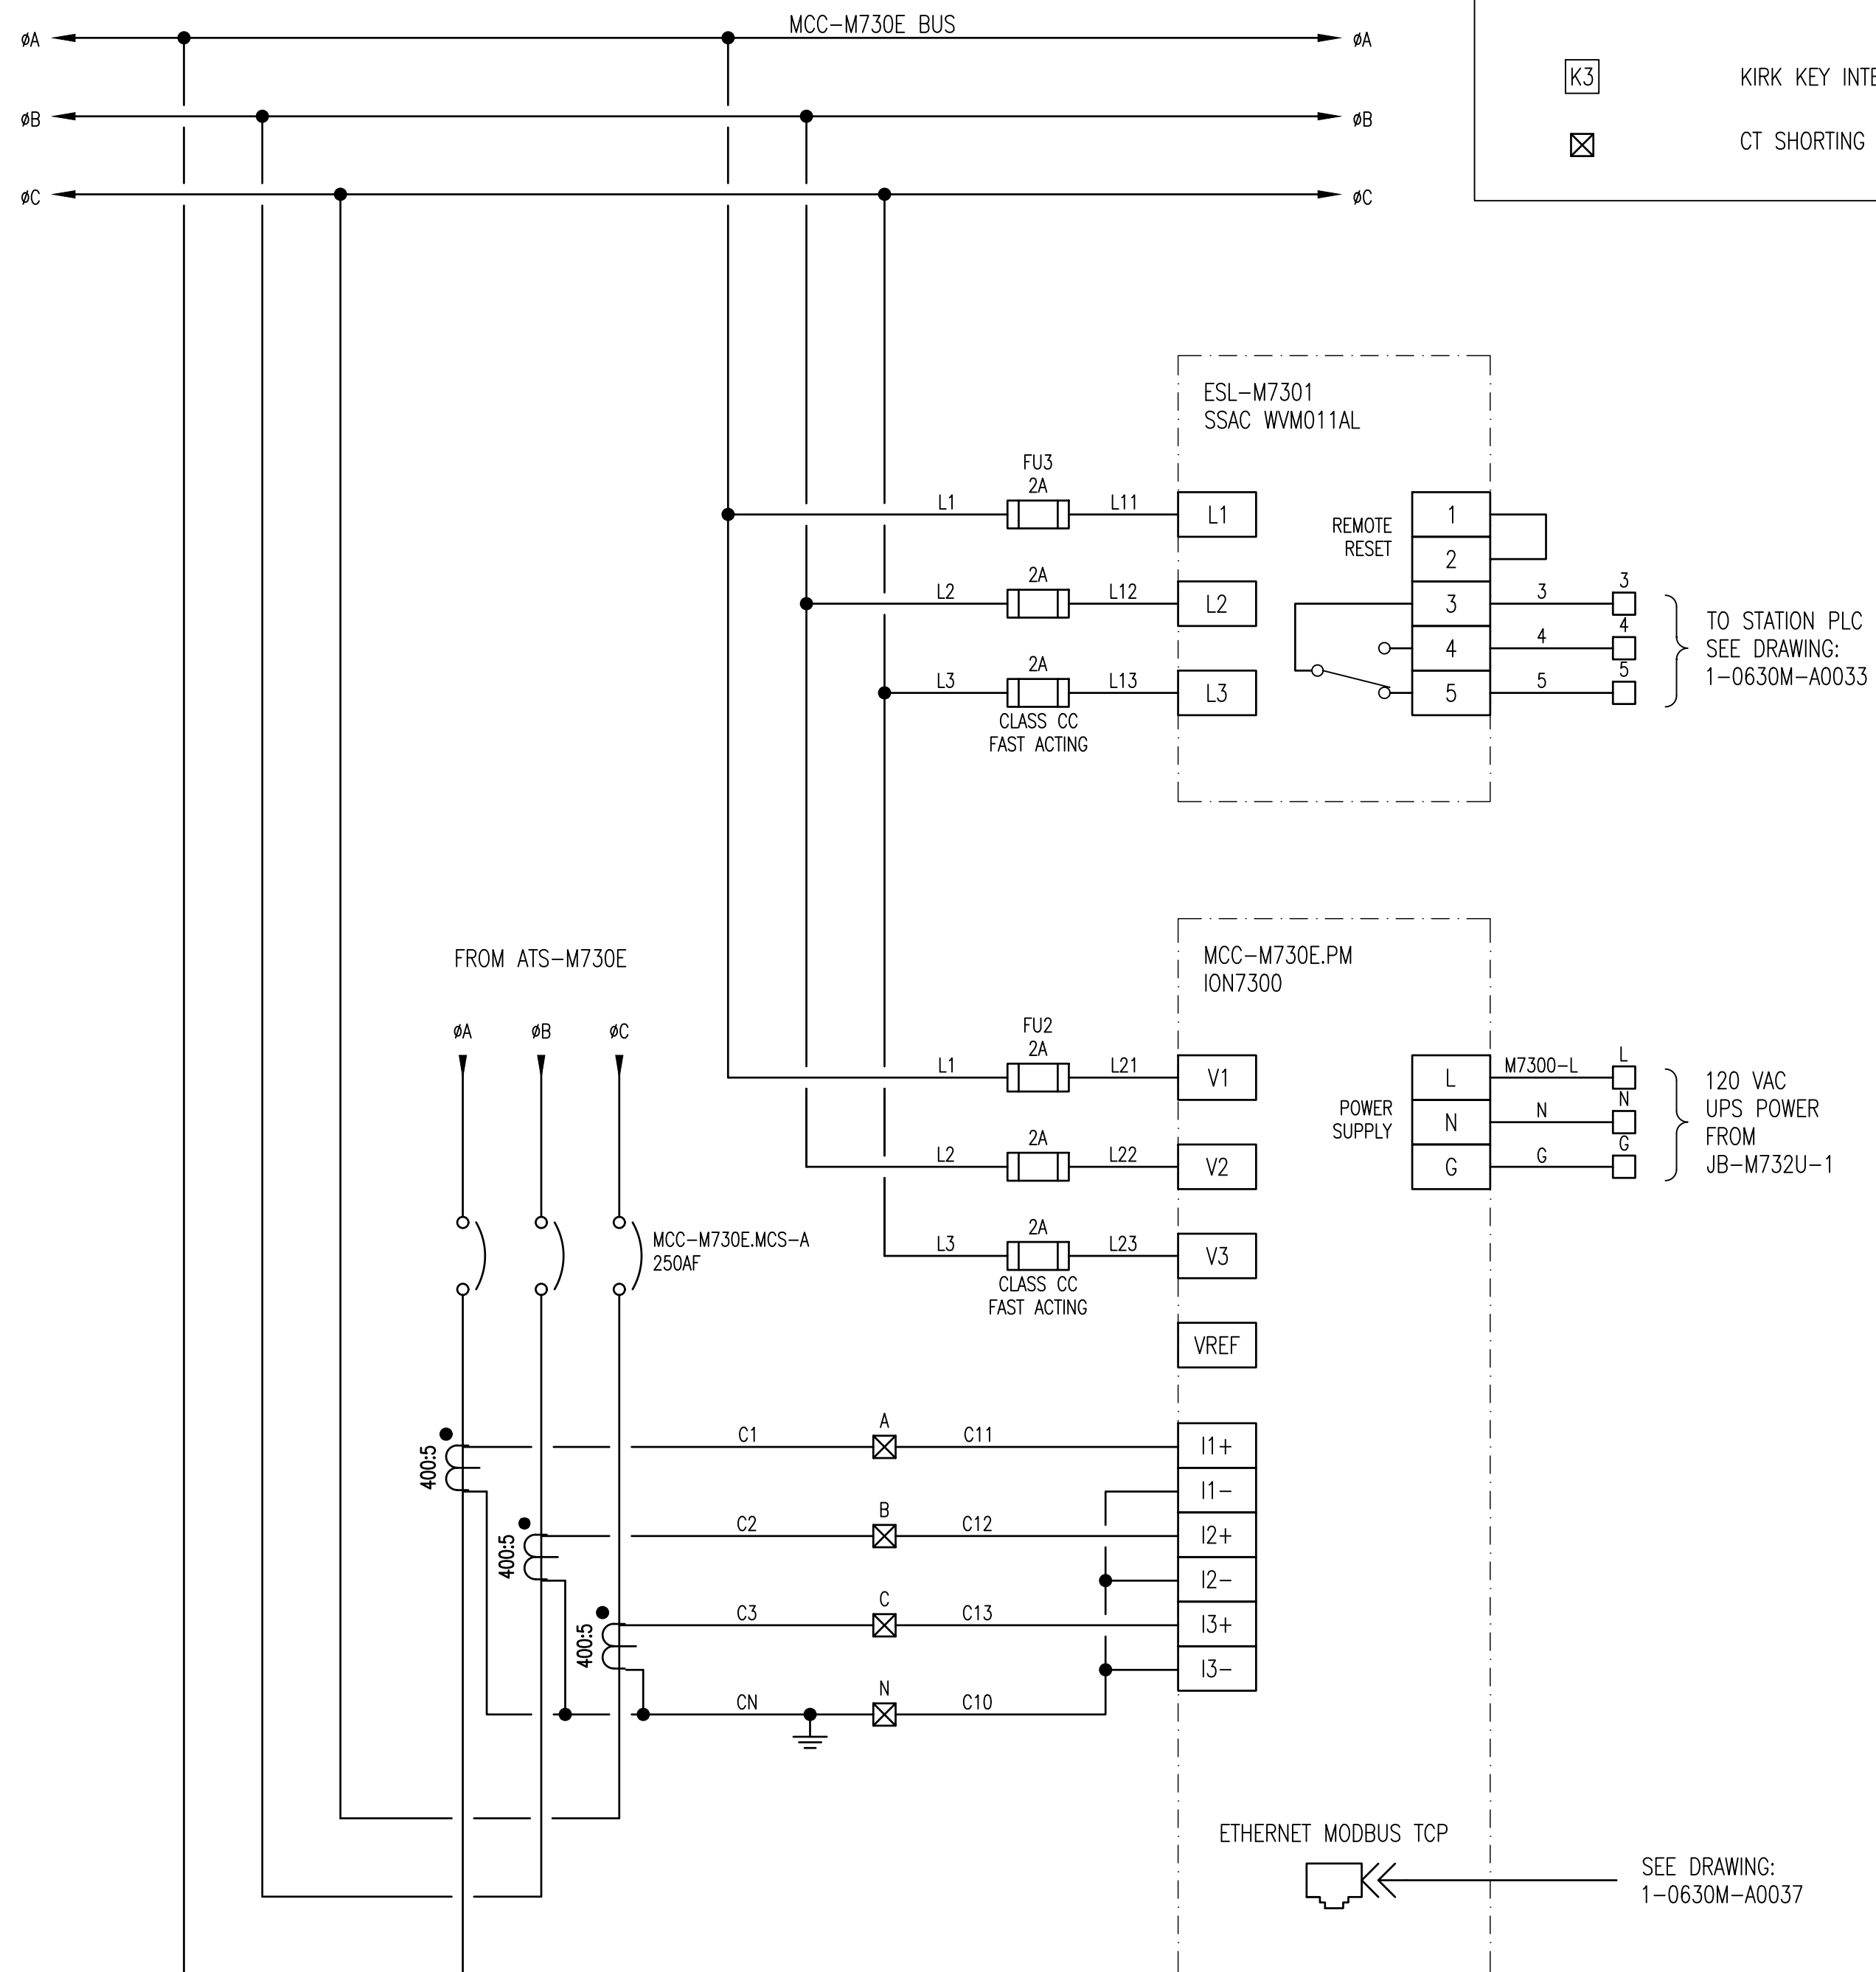

DETAIL: MCC-M730E POWER METER AND VOLTAGE MONITOR
SCALE: NTS

						 148 Nature Park Way, Winnipeg, Manitoba Canada R3P 0X7 204-786-8080	
						DESIGNED BY: B. CLEVEN	CHECKED BY: C. REIMER
04	ISSUED FOR TENDER AND CONSTRUCTION	2025/04/30	VE	VE		DRAWN BY: MJ. PERSSON	APPROVED BY: C. REIMER
03	AS-BUILT	2013/07/24	—	BJC		SCALE: NTS	ISSUED FOR CONSTRUCTION BY: R. CARROLL
02	ISSUED FOR CONSTRUCTION	2012/11/29		BJC	CJR		
01	ADDENDUM 1, BID OPP. 490-2012	2012/08/14		BJC	CJR	DATE: 2011/12/23	DATE: 2012/11/29
00	ISSUED FOR TENDER, BID OPP. 490-2012	2012/07/23		BJC	CJR	CONSULTANT NO.: 508955-0000-47DD-0027	
NO.	REVISIONS	DATE	DESIGN	CHECK			