


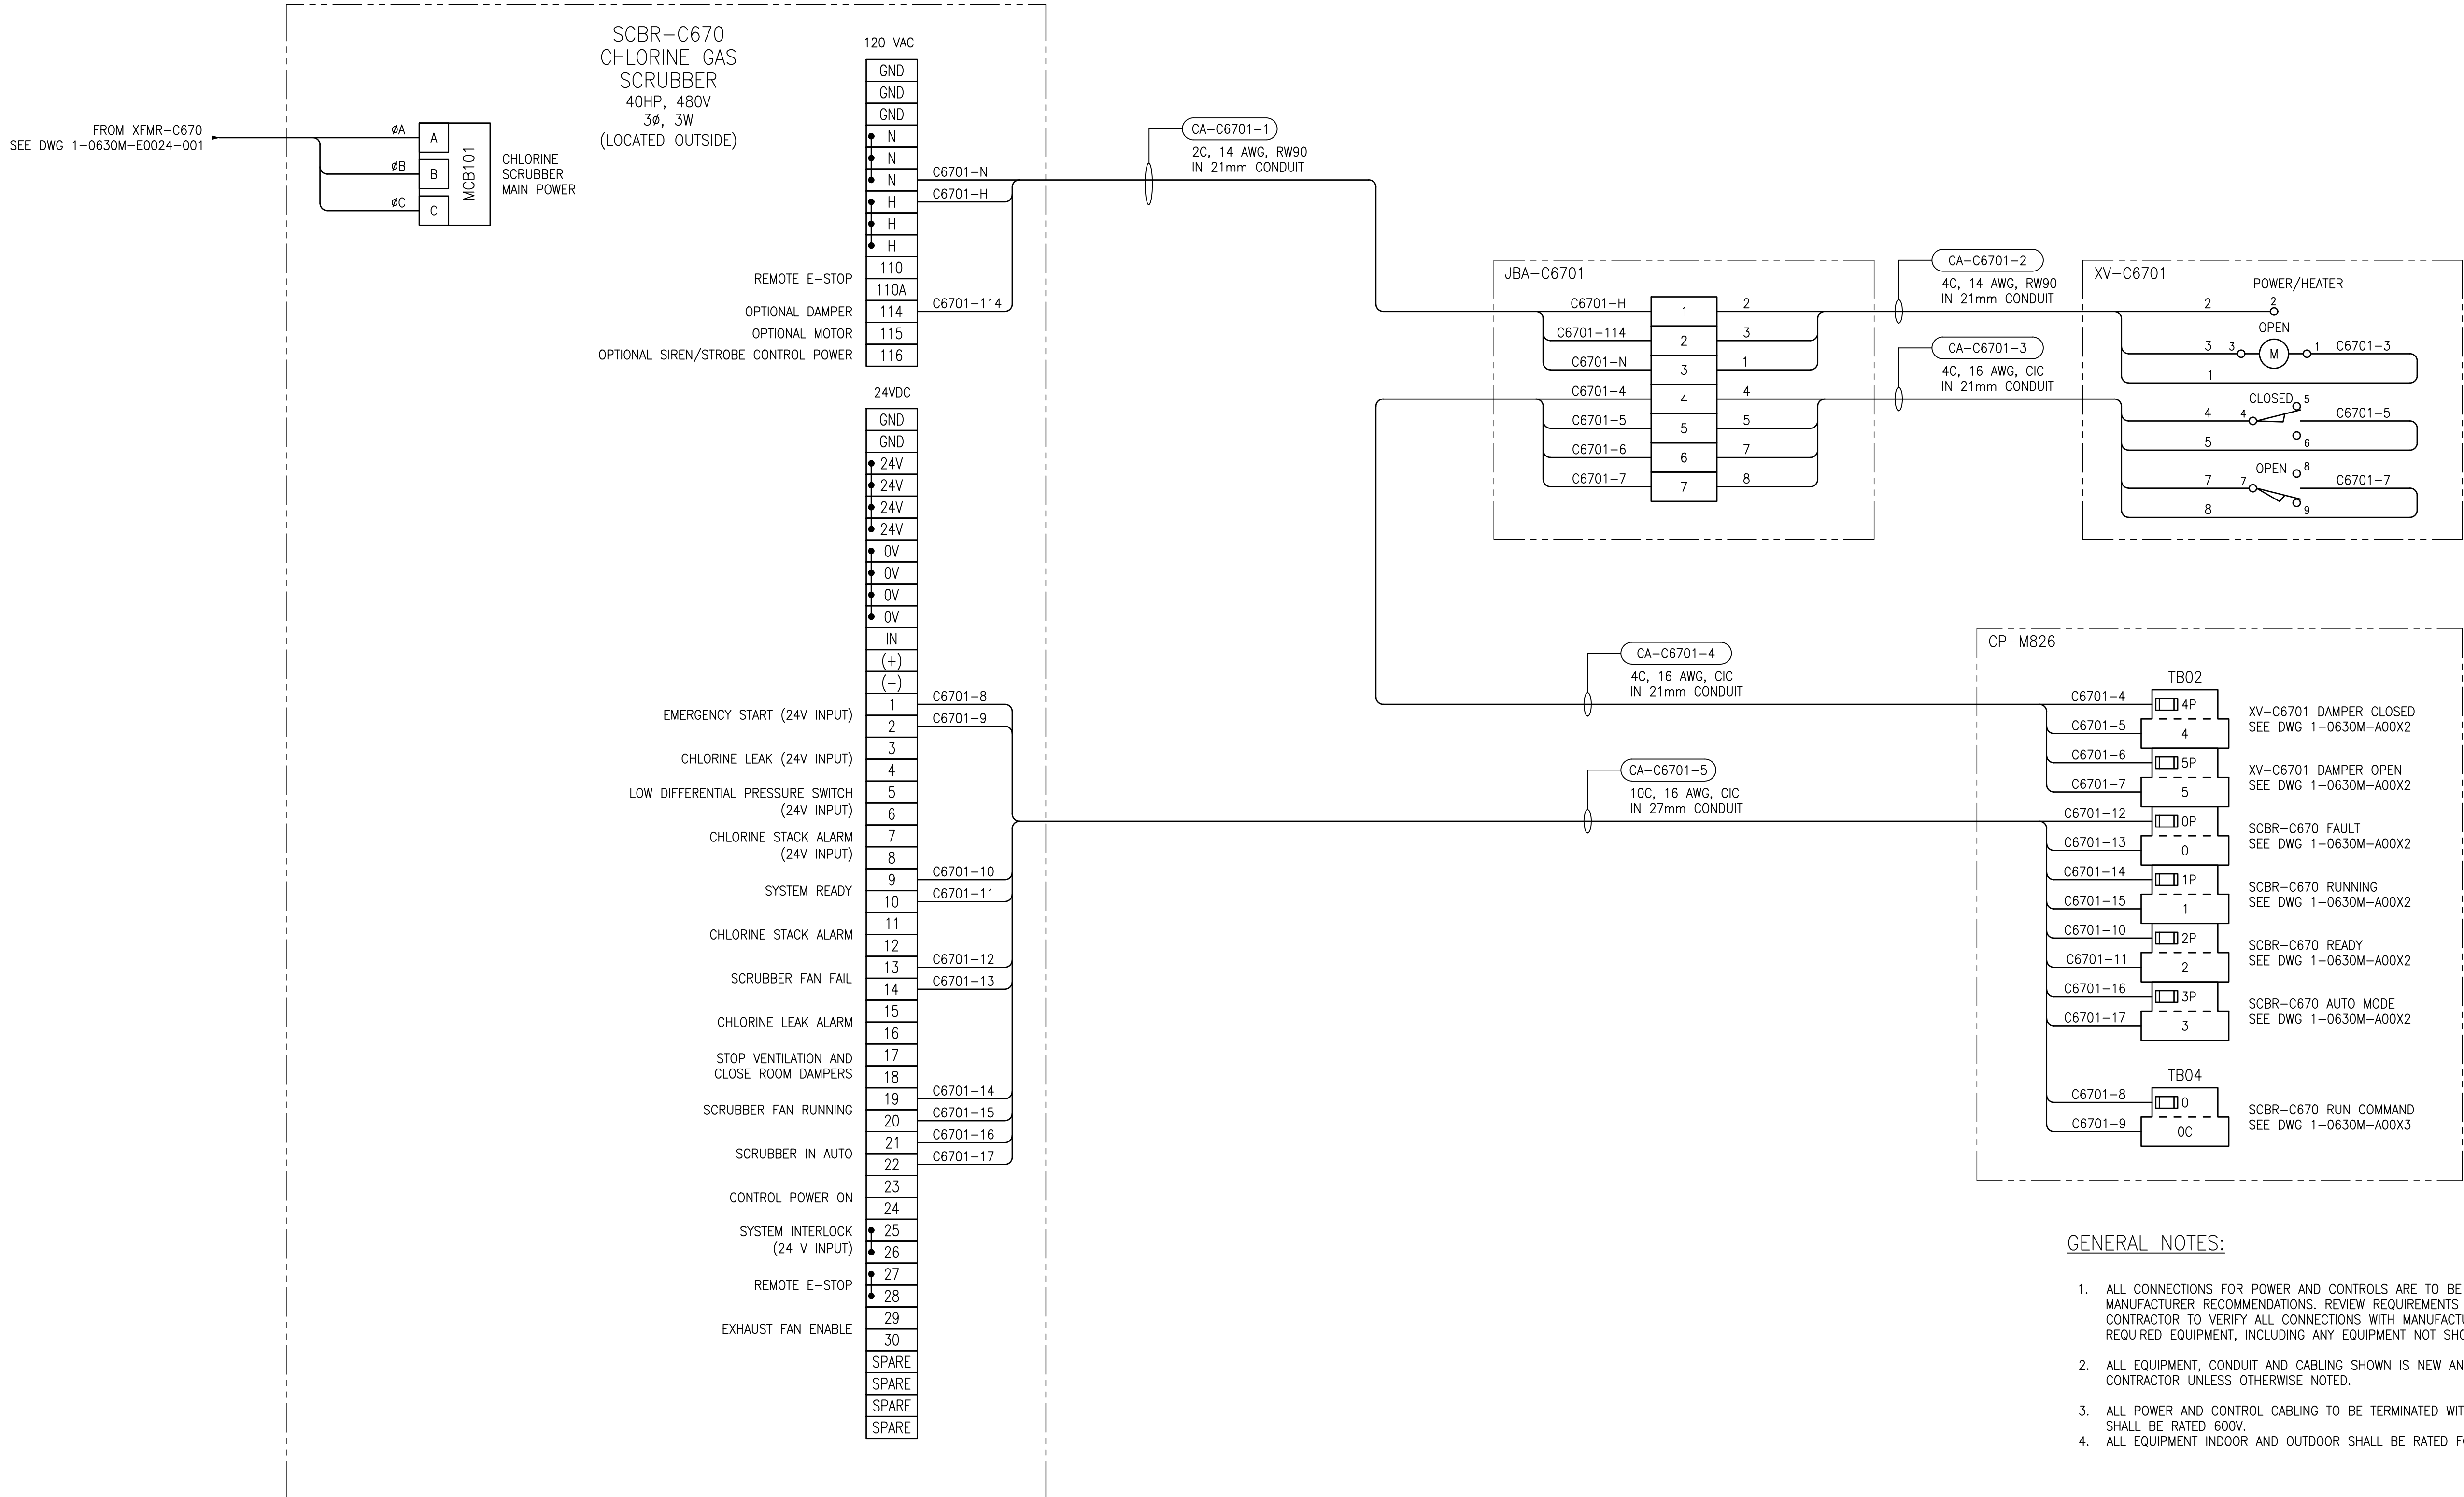

1-0630M-A0072	PANEL LAYOUT, DAMPER ACTUATOR JUNCTION BOXES
1-0630M-A0057	HVAC CONTROL PANEL CP-M826, DISCRETE OUTPUTS RACK 0, MODULE 4
1-0630M-A0055	HVAC CONTROL PANEL CP-M826, DISCRETE INPUTS RACK 0, MODULE 2
1-0630M-A0053	PANEL LAYOUT, HVAC CONTROL PANEL CP-M826
1-0630M-E0024	ELECTRICAL SINGLE LINE DIAGRAM, DP-M720
DRAWING NUMBER	REFERENCE DRAWINGS



					 148 Nature Park Way, Winnipeg, Manitoba Canada R3P 0X7 204-786-8080		ENGINEER'S SEAL		 THE CITY OF WINNIPEG WATER AND WASTE DEPARTMENT							
					DESIGNED BY: B. WILKS				CHECKED BY: V. ELIMBAN		MACLEAN PUMPING STATION CHLORINE SYSTEM UPGRADE CONNECTION DIAGRAM CHLORINE GAS SCRUBBER SCBR-C670					
					DRAWN BY: B. WILKS				APPROVED BY: V. ELIMBAN							
					SCALE: NTS				ISSUED FOR CONSTRUCTION BY: M. SKINNER							
					DATE: 2023/06/20				DATE: 2025/04/30							
00 ISSUED FOR TENDER AND CONSTRUCTION					2025/04/30		VE		VE		CITY DRAWING NUMBER					
NO. REVISIONS					DATE		DESIGN		CHECK		1-0630M-E0083					
											SHEET		REV.		SIZE	
											001		00		A1	