



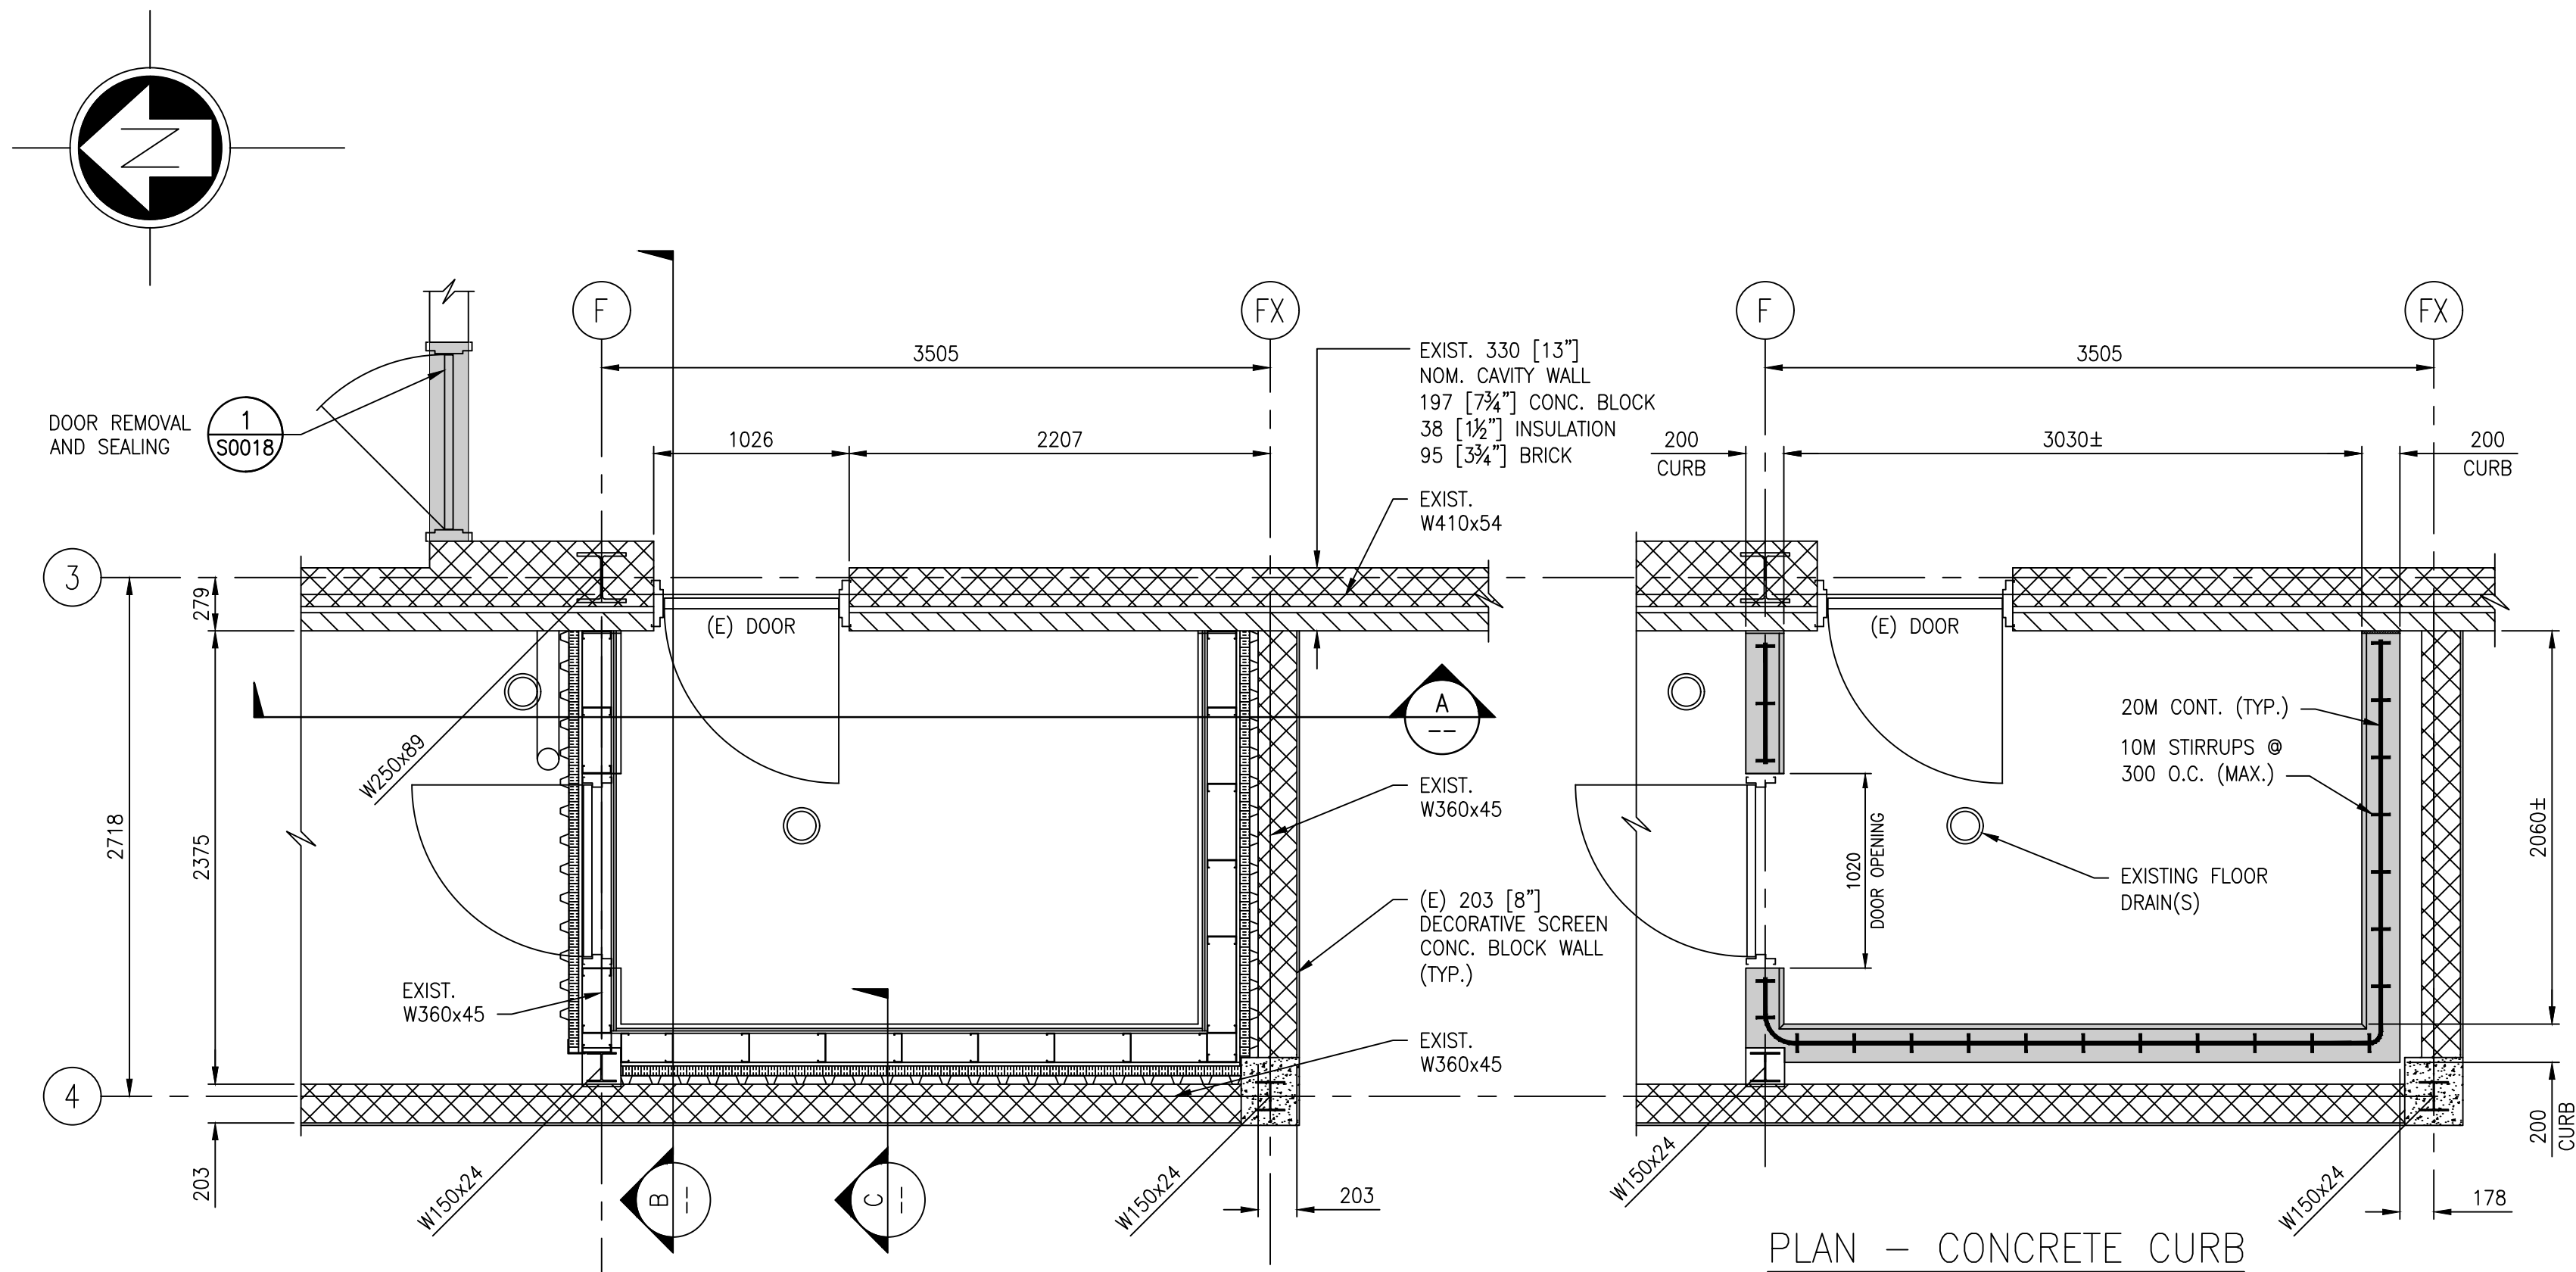


PLAN - SERVICE AREA 314
SCALE: 1 : 30

PLAN - CONCRETE CURB
SCALE: 1 : 30

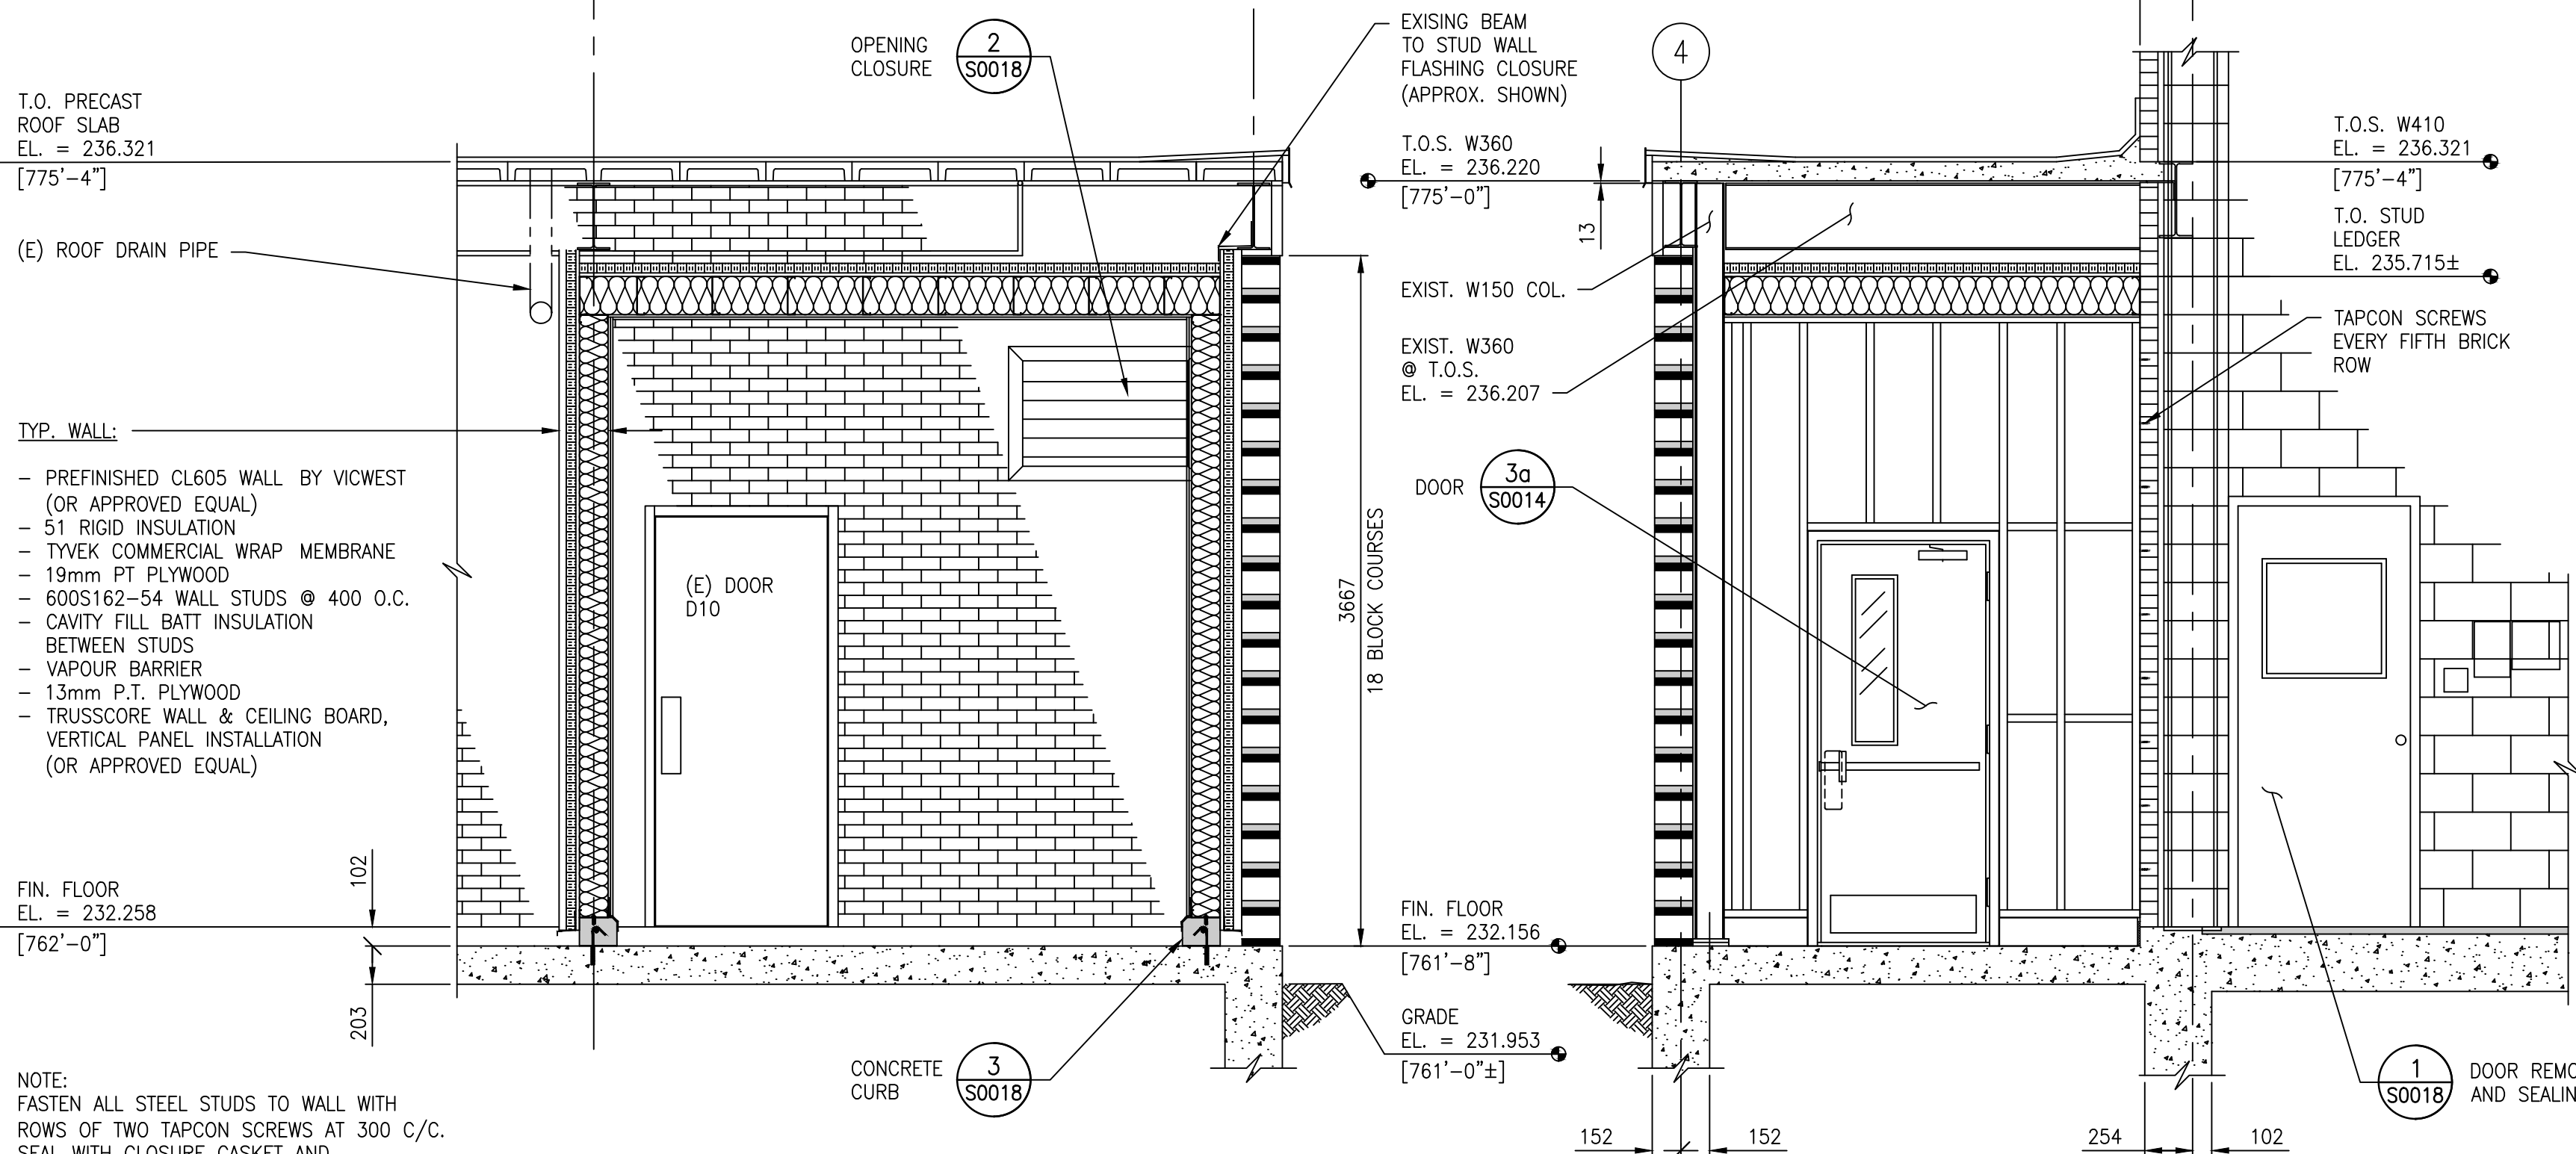


SECTION A
SCALE: 1 : 30


SECTION B
SCALE: 1 : 30

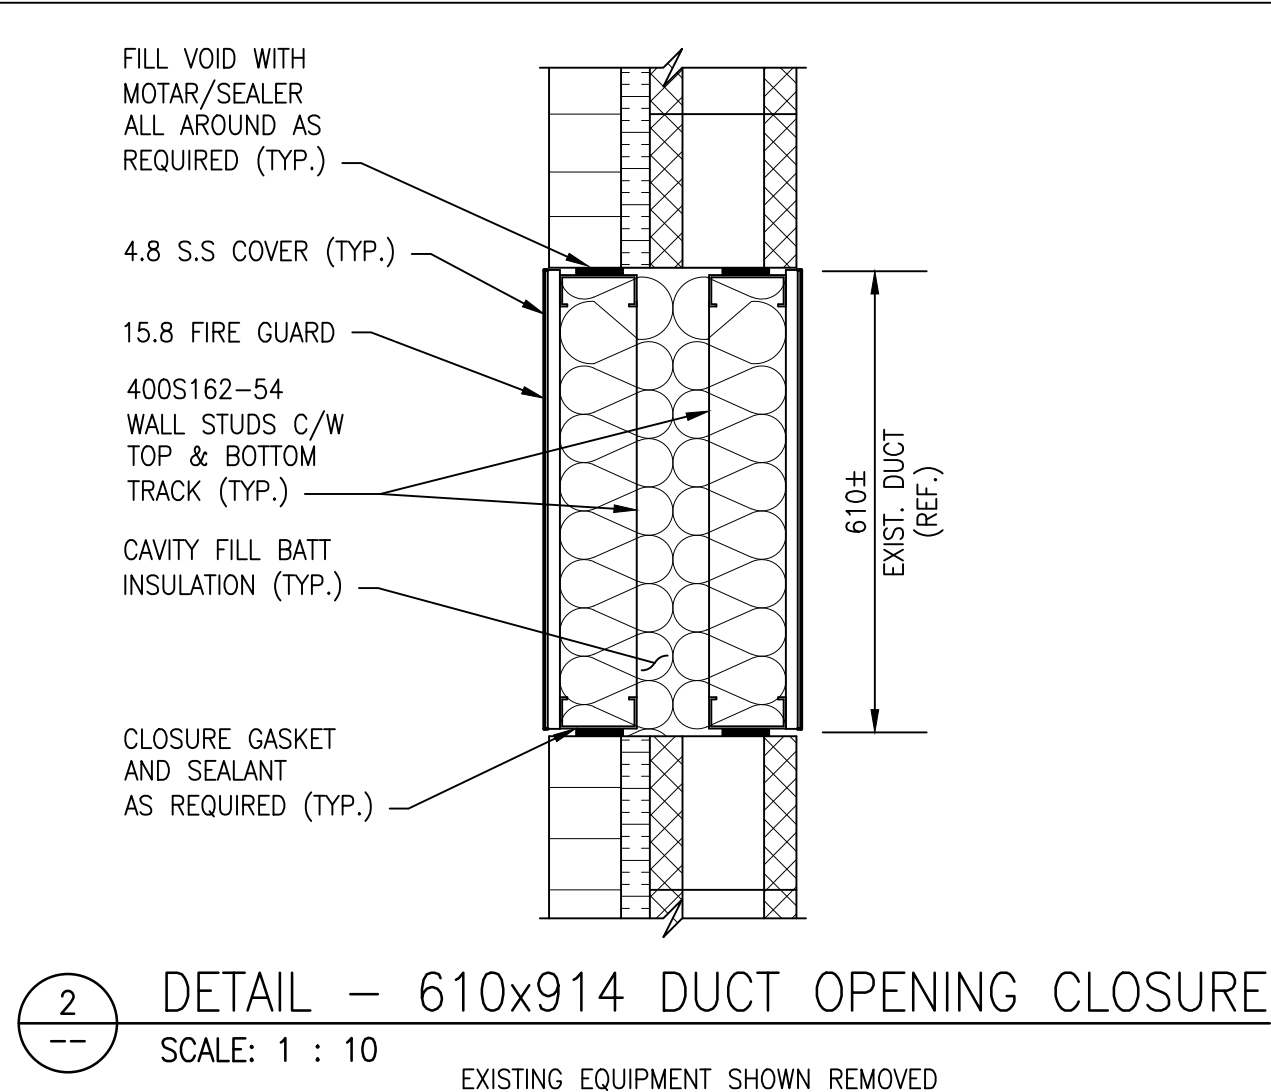

DETAIL - 610x914 DUCT OPENING CLOSURE
SCALE: 1 : 10

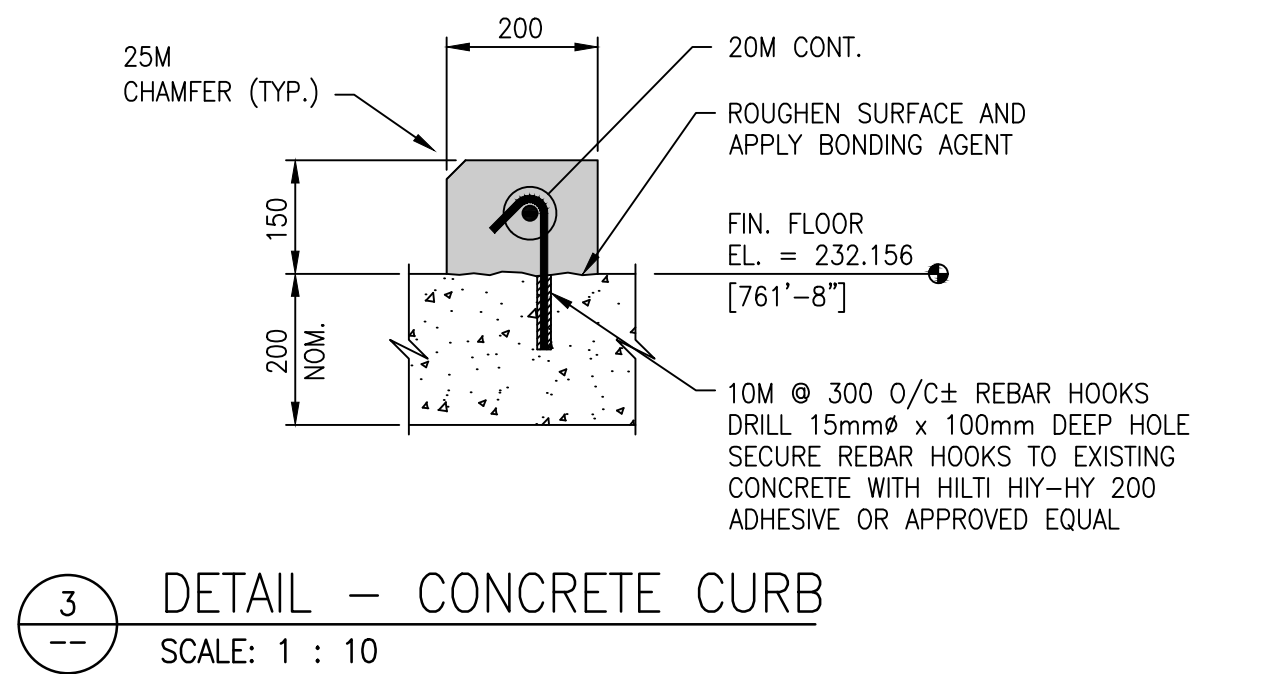


DETAIL - CONCRETE CURB
SCALE: 1 : 10

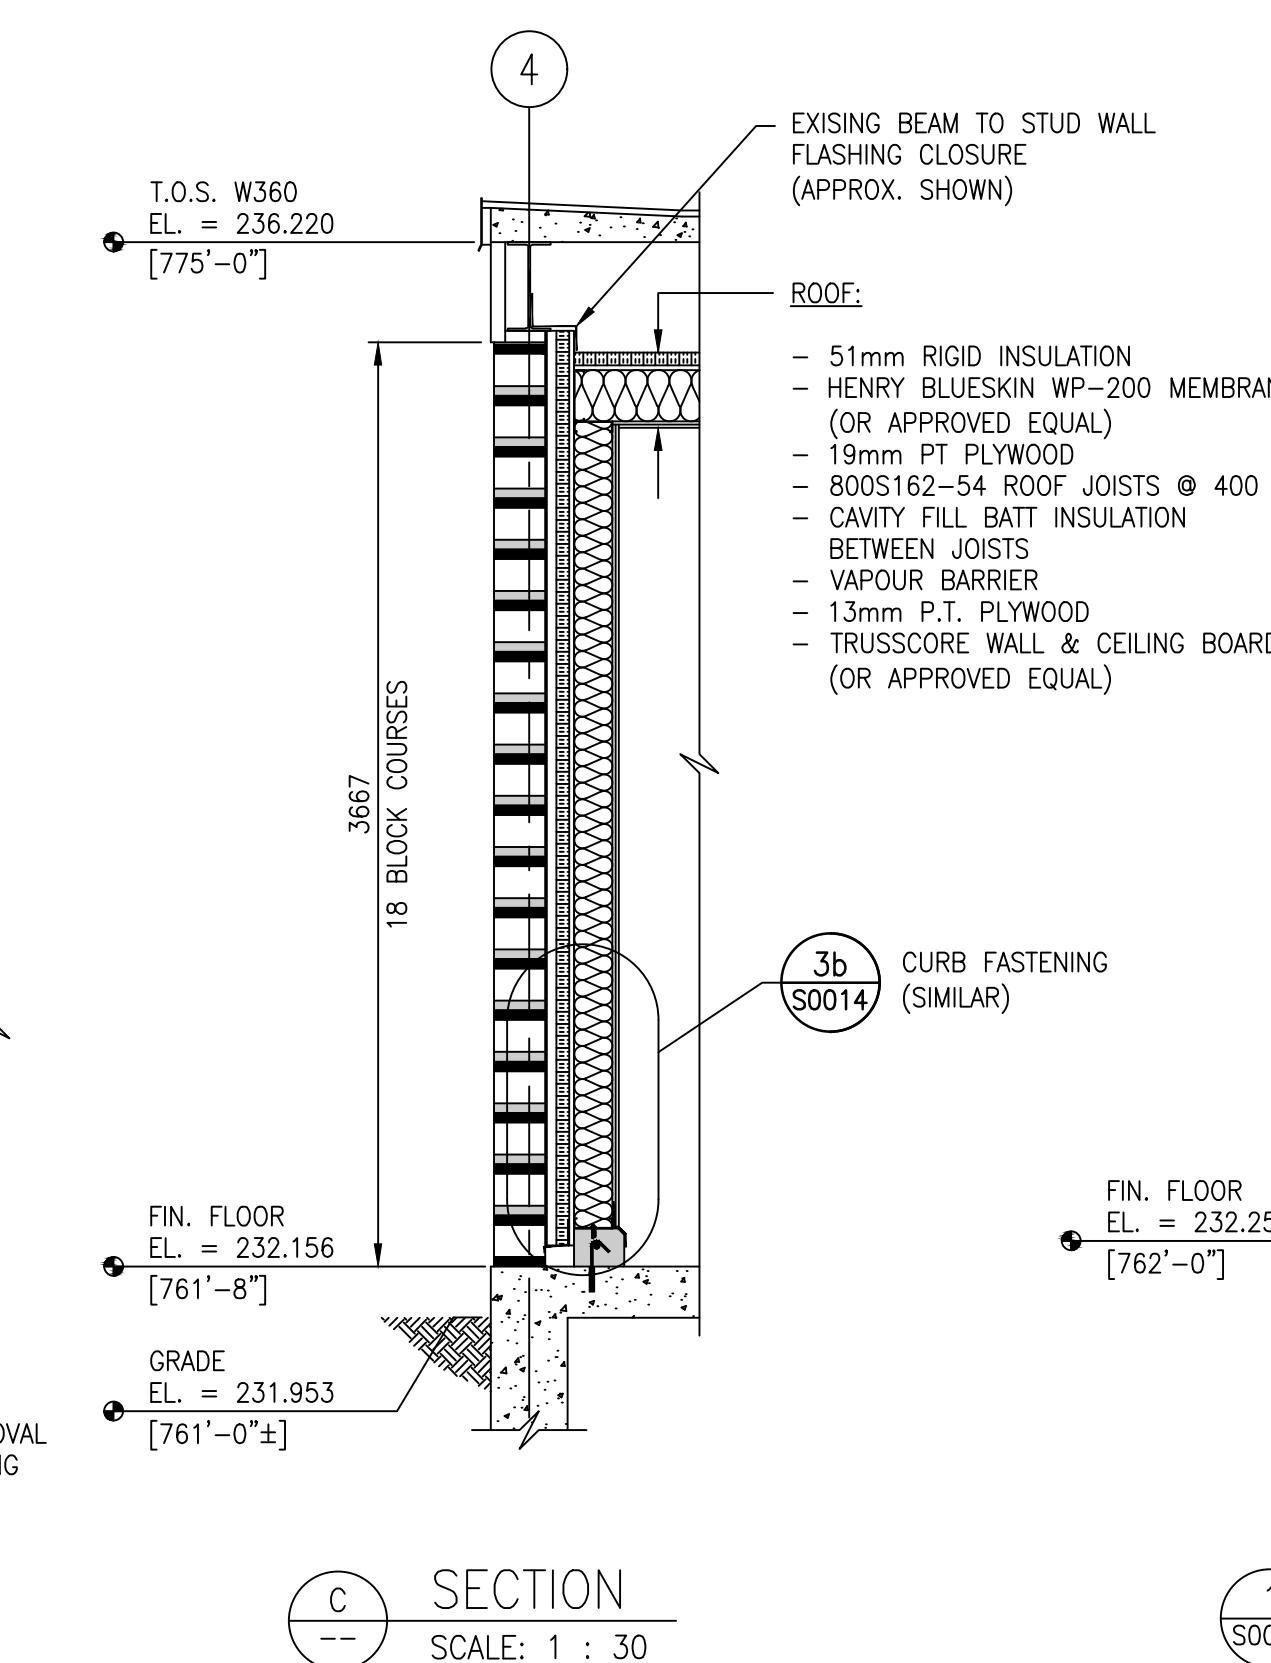

SECTION C
SCALE: 1 : 30


DETAIL - DOOR OPENING CLOSURE
SCALE: 1 : 30

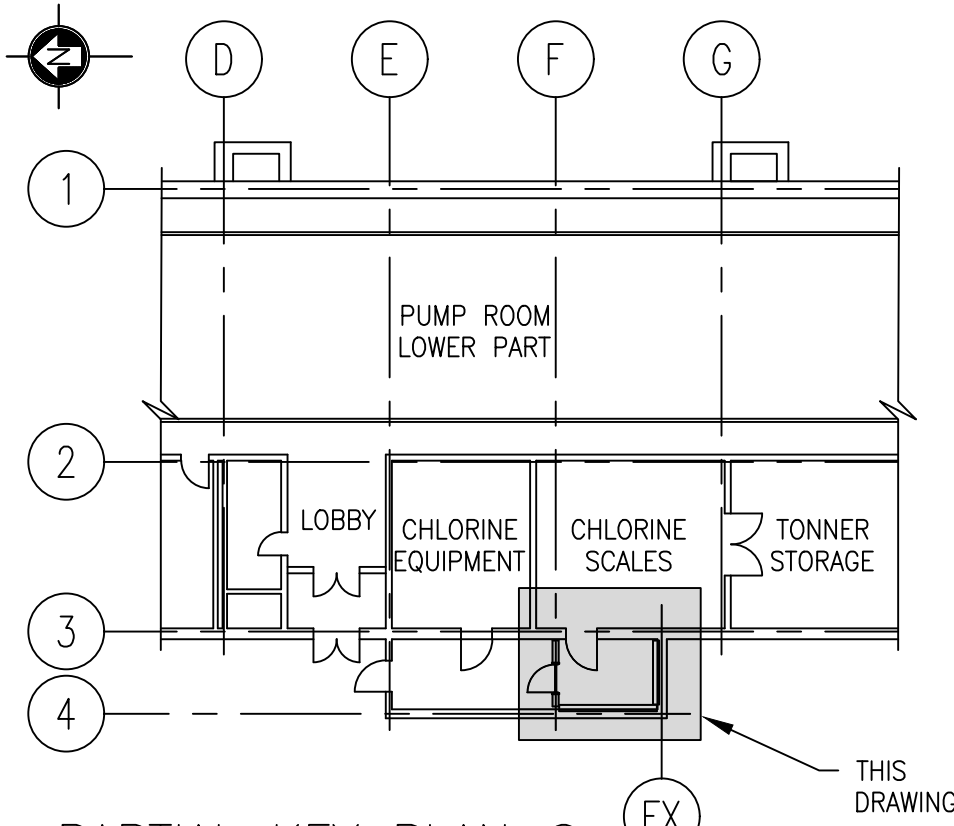

PARTIAL KEY PLAN @
ABOVE ELEVATION 232.528M [762.0']
SCALE: 1 : 250

REF. DRAWING ME-13, ME-14 & ME-20


NOTES:
1. SEE DRAWING 1-0630M-S0010-001 & 1-0630M-S0010-002 FOR GENERAL NOTES.

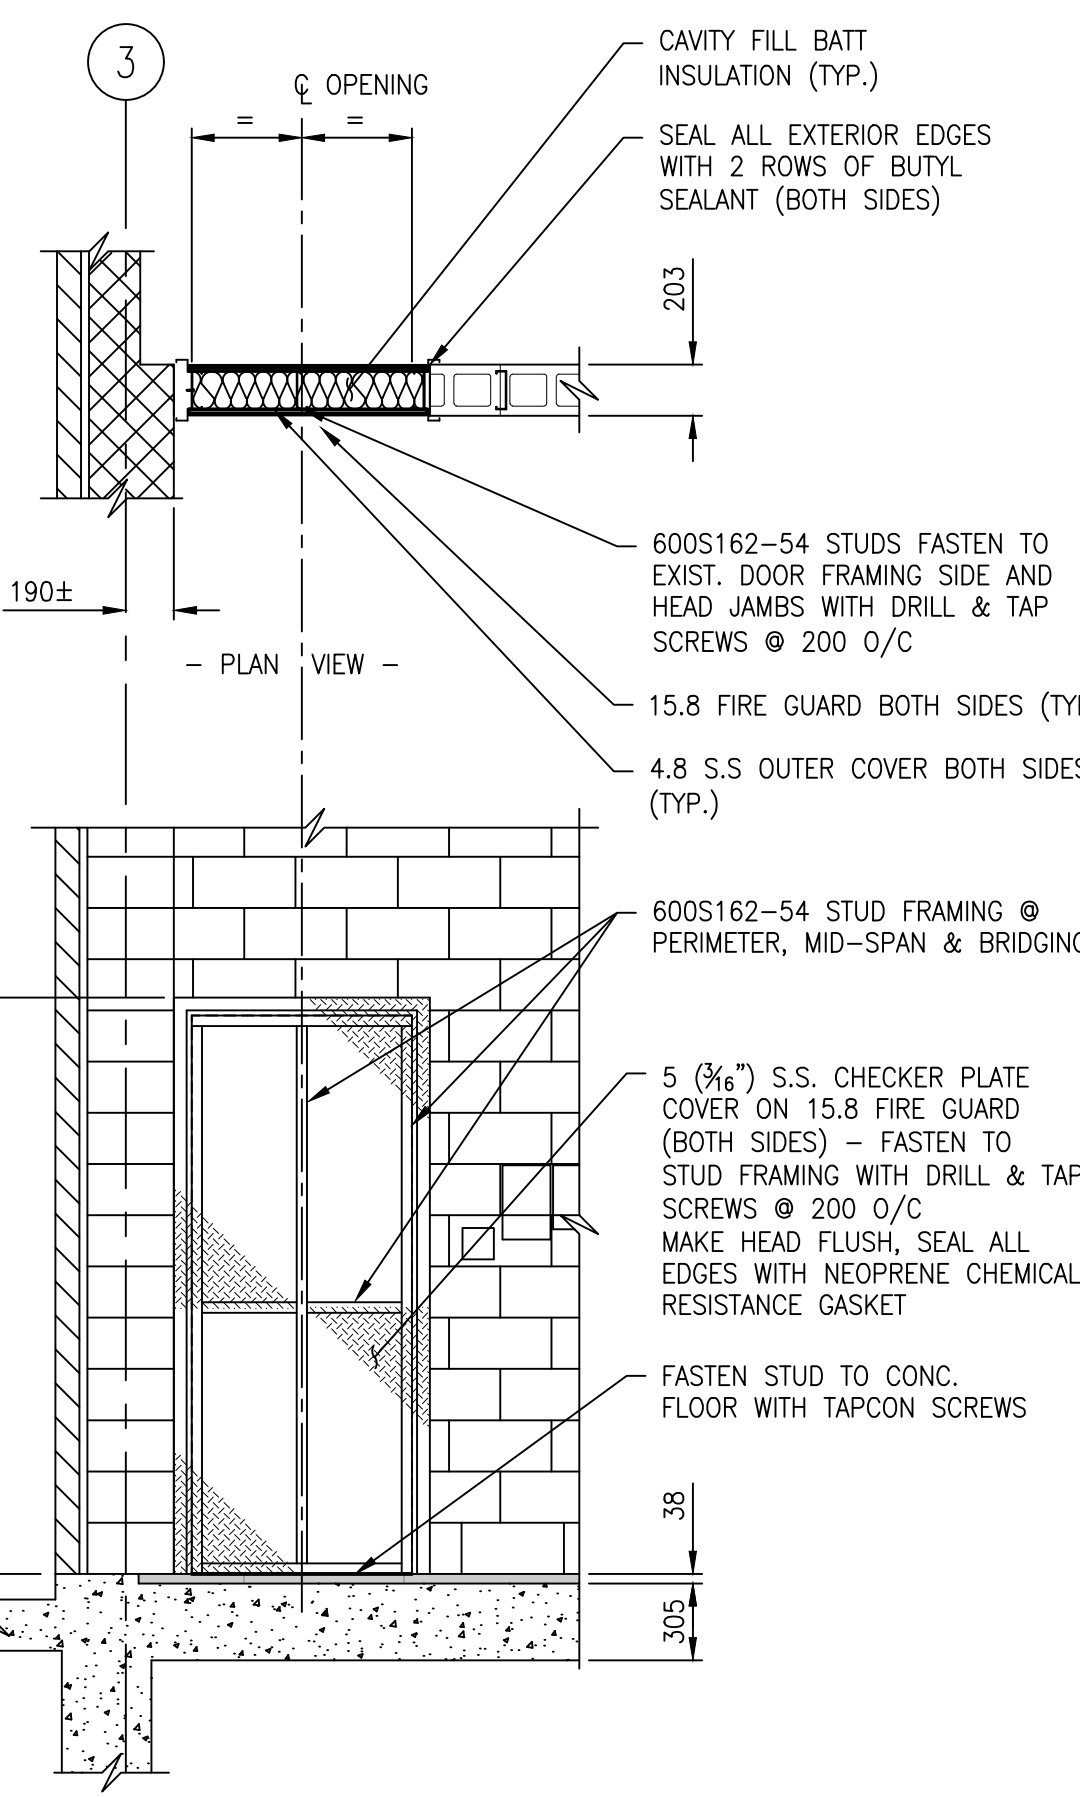

DETAIL - DOOR OPENING CLOSURE
SCALE: 1 : 30

PARTIAL ELEVATION LOOKING NORTH
(ELECTRICAL SERVICES ABOVE DOOR NOT SHOWN FOR CLARITY)

DRAWING NUMBER	REFERENCE DRAWINGS
ME-22	PUMPING STATION - SECTIONS AND DETAILS
ME-20	PUMPING STATION - PLAN ABOVE ELEVATION 762.00 AND ROOF PLAN
ME-17	PUMPING STATION - STRUCTURAL STEEL
ME-14	PUMPING STATION - STRUCTURAL PLAN ABOVE ELEVATION 762.00 SHEET 2
ME-13	PUMPING STATION - STRUCTURAL PLAN ABOVE ELEVATION 762.00 SHEET 1

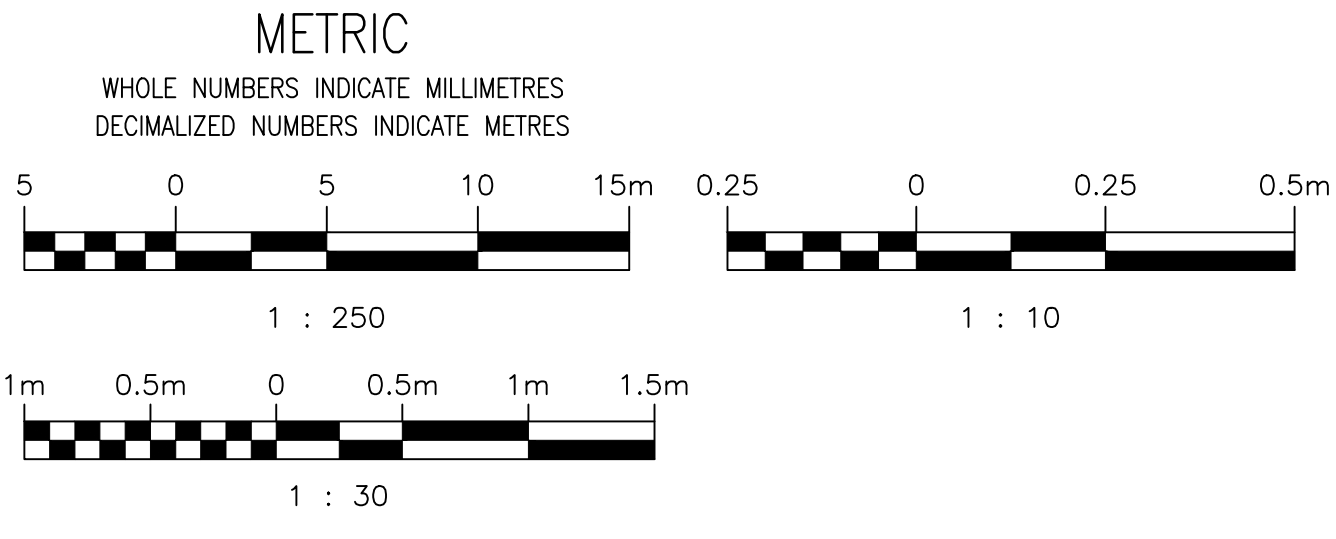

**ENGINEERS
GEOSCIENTISTS
MANITOBA**

Certificate of Authorization

AtkinsRéalis Canada Inc.

No. 4489

NO.	REVISIONS	DATE	DESIGN	CHECK
00	ISSUED FOR TENDER AND CONSTRUCTION	2025/04/30	KK	FM

DESIGNED BY: K. KOTYK
CHECKED BY: F. MARSHALL
DRAWN BY: B. DICKSON
APPROVED BY: V. ELIMBAN
SCALE: AS NOTED
ISSUED FOR CONSTRUCTION BY: M. SKINNER
DATE: 2023-04-24
DATE: 2025/04/30
CONSULTANT NO.: 694715

ENGINEER'S SEAL

THE CITY OF WINNIPEG
WATER AND WASTE DEPARTMENT

MACLEAN PUMPING STATION
CHLORINE SYSTEM UPGRADE
SERVICE AREA 1 - ADDITIONAL ROOM ENCLOSURE
REMOVALS AND NEW WORK
PLAN AND ELEVATIONS

CITY DRAWING NUMBER
1-0630M-S0018

SHEET
001

REV.
00

SIZE
A1