


A1 SIZE - 594mm x 841mm

LAST SAVE: 2025/04/29 - 12:31pm
PATH: C:\Users\jclab\pdfs\1-0640C-C0001-001-00.dwg

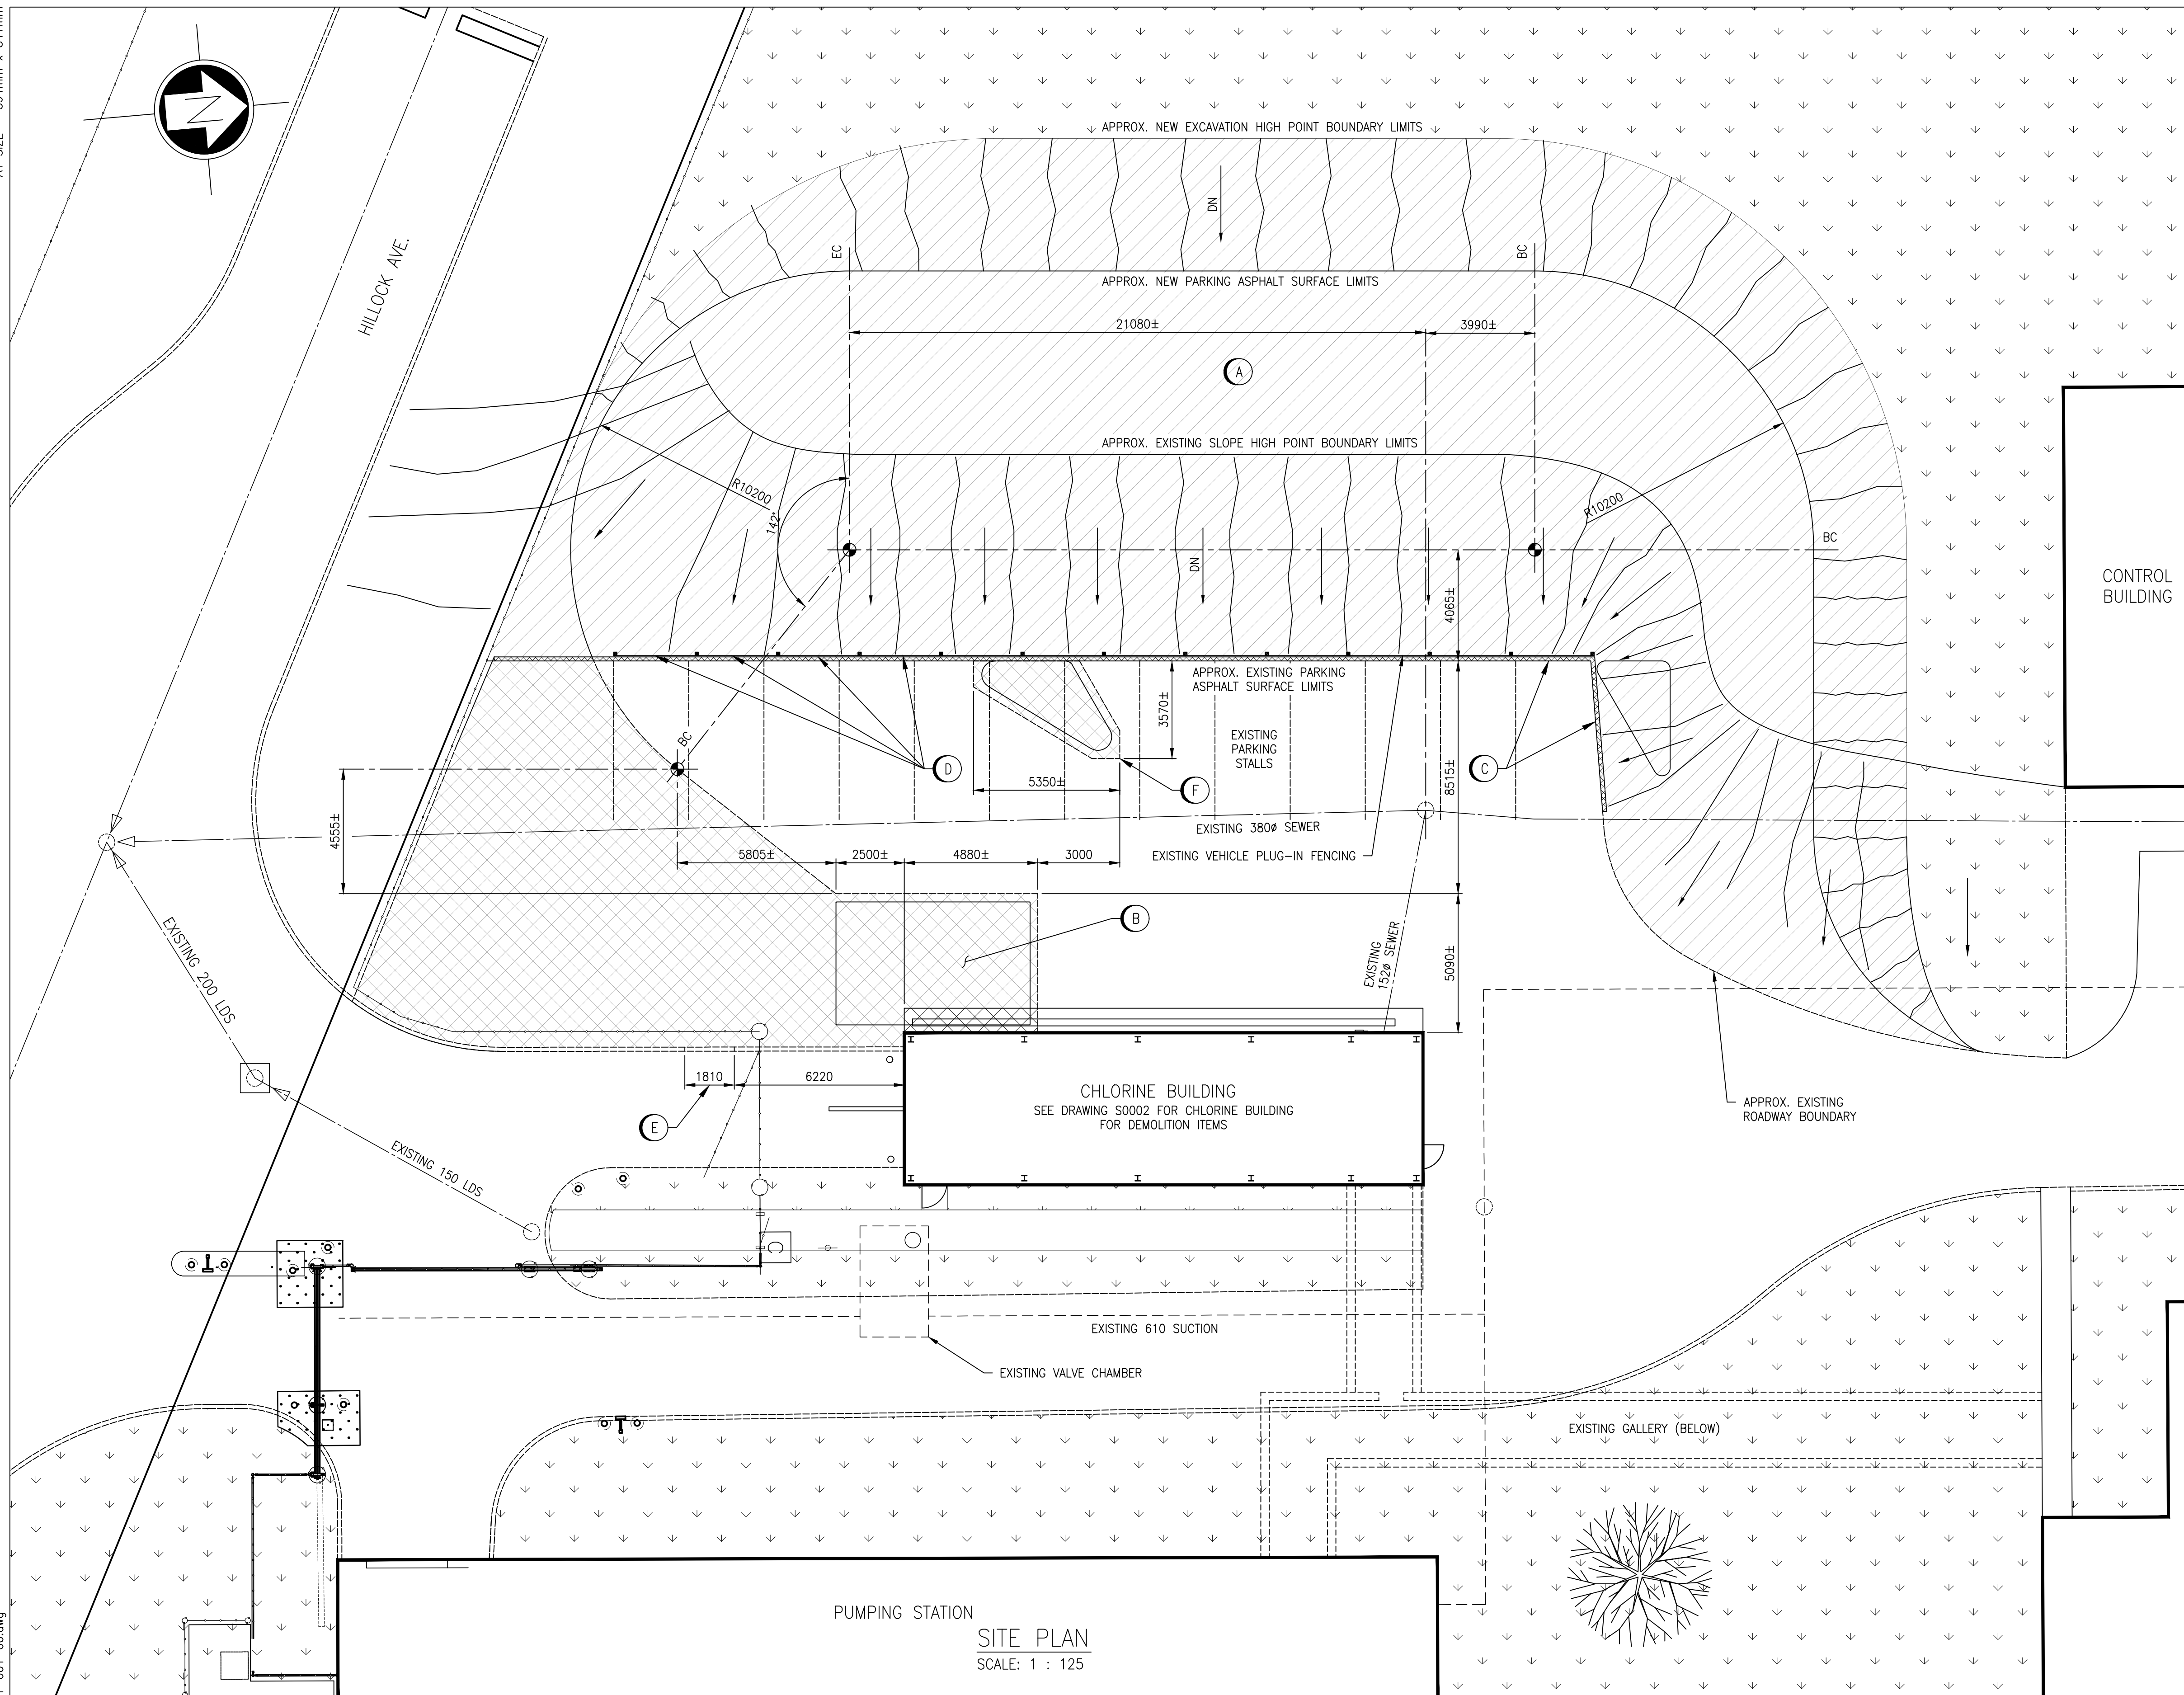

D-6279	McPHILLIPS PUMPING STATION - SITE PLAN
McP-73	McPHILLIPS STREET PUMPING STATION - SITE AND LOCATION PLAN & GENERAL NOTES
McP-32	McPHILLIPS STREET PUMPING STATION - YARD PIPING PROFILES
McP-31	McPHILLIPS STREET PUMPING STATION - YARD PIPING PLAN
DRAWING NUMBER	REFERENCE DRAWINGS

METRIC

WHOLE NUMBERS INDICATE MILLIMETRES
DECIMALIZED NUMBERS INDICATE METRES

20 0 20 40 60m

1 : 1000

2 0 2 4 6 8m

1 : 125

**ENGINEERS
GEOSCIENTISTS
MANITOBA**

Certificate of Authorization

AtkinsRéalis Canada Inc.

No. 4489


00	ISSUED FOR TENDER AND CONSTRUCTION	2025/04/30	KK	FM	CONSULTANT NO: 694715
NO.	REVISIONS	DATE	DESIGN	CHECK	

AtkinsRéalis

148 Nature Park Way, Winnipeg, Manitoba
Canada R3P 0X7 204-786-8080

DESIGNED BY: K. KOTYK
DRAWN BY: B. DICKSON
SCALE: AS SHOWN
DATE: 2023-10-05

CHECKED BY: F. MARSHALL
APPROVED BY: V. ELIMBAN
ISSUED FOR CONSTRUCTION BY: M. SKINNER
DATE: 2025/04/30

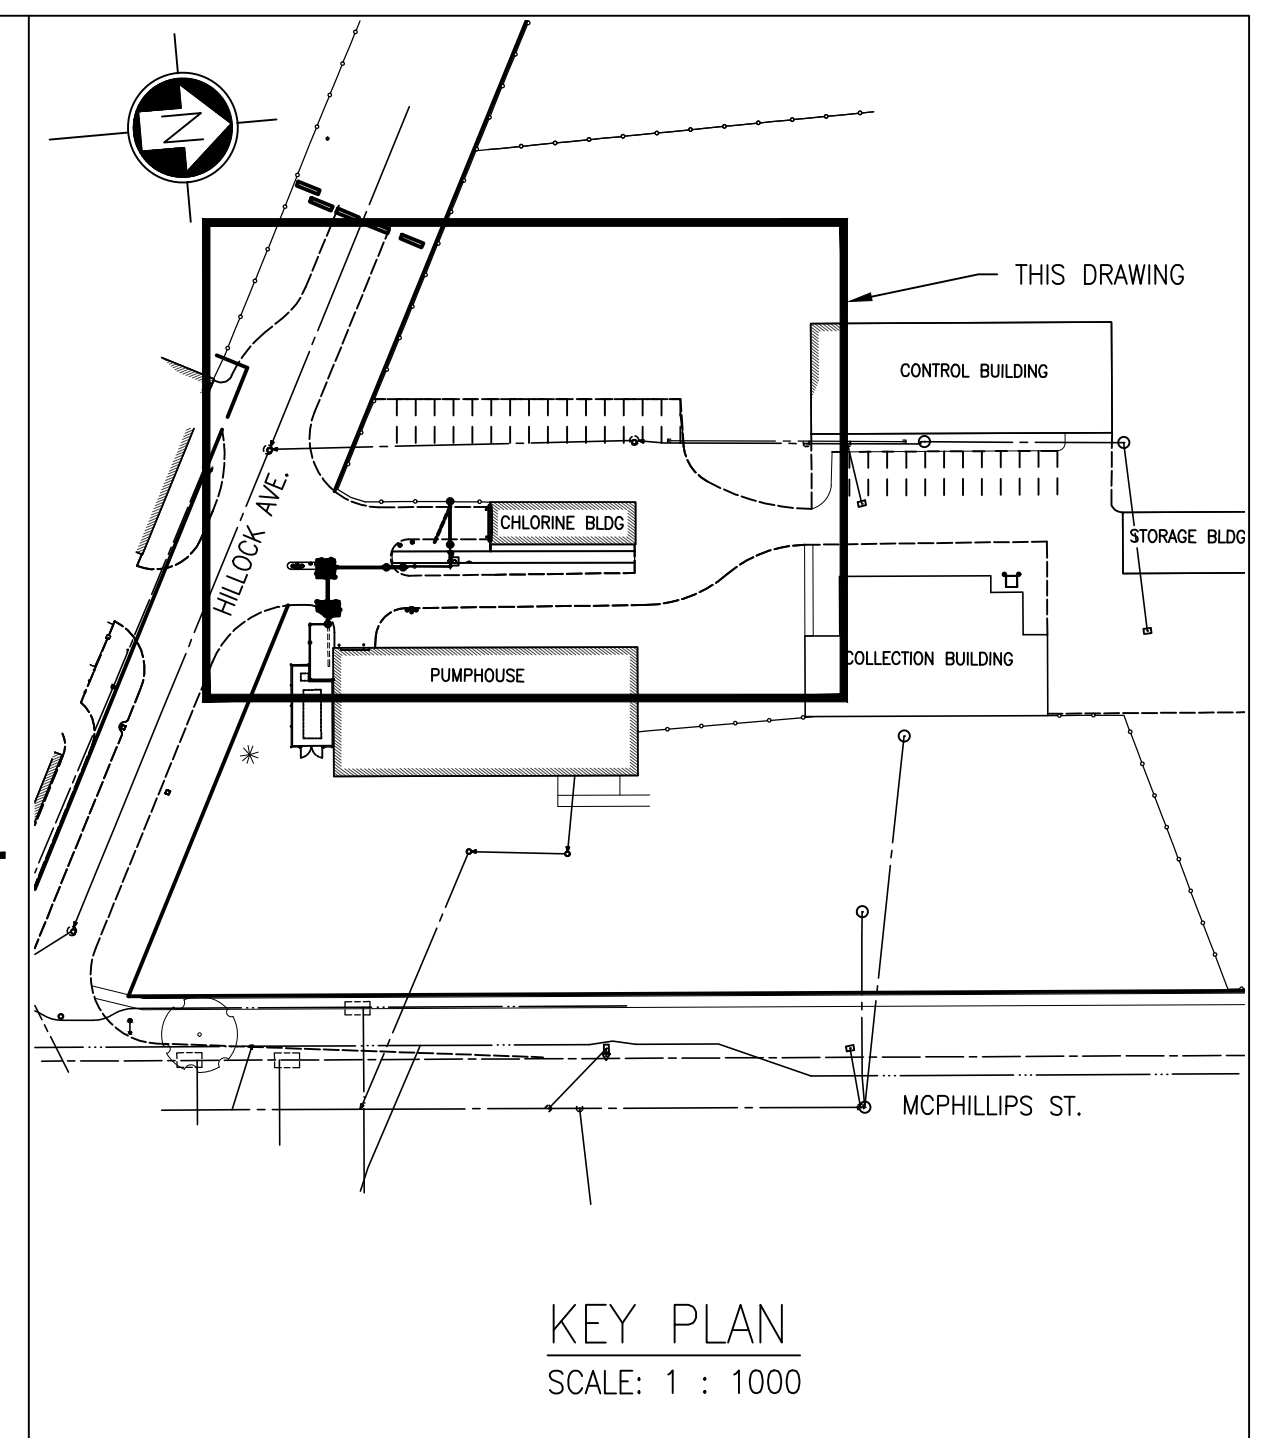

- NOTES:**
- SEE DRAWING 1-0640C-S0001-001 & 1-0640C-S0001-002 FOR GENERAL NOTES.
- SPECIFIC NOTES:**
- THE DRAWING IS BASED ON EXISTING CITY OF WINNIPEG DRAWINGS, SATELITE INFO AND NEW DRAWINGS. LOCATIONS & ELEVATIONS SHOWN ARE NOT GUARANTEED TO BE ACCURATE. SITE CONFIRM VIA SURVEY ALL LOCATIONS PRIOR TO COMPLETING ANY WORK.
 - REPORT ALL DISCREPANCIES TO THE CONTRACT ADMINISTRATOR.
 - ALL REMOVALS TO BE IN ACCORDANCE WITH CITY OF WINNIPEG MANAGEMENT DETAILS & STANDARDS DIVISION 4 - SURFACE WORKS SPECIFICATIONS - LATEST REVISIONS.
 - ALL EARTHWORKS REMOVALS TO BE IN ACCORDANCE WITH CITY OF WINNIPEG STANDARDS CW 3010 & CW 3170.
 - ALL PAVEMENT REMOVALS TO BE IN ACCORDANCE WITH CITY OF WINNIPEG STANDARDS CW 3110, CW 3235 AND CW 3240.

REMOVAL NOTES

- A** DEMOLISH AND REMOVE EXISTING EARTH/SOD HILL FOR ADDITIONAL PARKING STALLS
- B** DEMOLISH AND REMOVE EXISTING PARKING LOT ASPHALT SURFACE FOR ADDITIONAL LANDSCAPING & SCRUBBER PAD - DEPTH VARIES
- C** DEMOLISH AND REMOVE EXISTING PARKING LOT CONCRETE CURBING
- D** DEMOLISH AND REMOVE PARKING FENCE/ELECTRICAL BAYS, RE-USE IF SALVAGABLE
- E** DEMOLISH AND REMOVE SECTION OF ROAD CURBING FOR LOT DRAINAGE.
- F** DEMOLISH AND REMOVE SECTION OF ASPHALT FOR MEDIAN CURBING AND GROUNDWORKS

LEGEND:

- EXISTING GROUND\GRASS
- EARTH - GRASS HILL REMOVAL
- ASPHALT/CONCRETE REMOVAL

ENGINEER'S SEAL

THE CITY OF WINNIPEG
WATER AND WASTE DEPARTMENT

MCPHILLIPS PUMPING STATION
CHLORINE SYSTEM UPGRADES
CIVIL
DEMOLITION DRAWING - EARTHWORKS
PLANS

CITY DRAWING NUMBER	SHEET	REV.	SIZE
1-0640C-C0001	001	00	A1