



ELEMENTARY DIAGRAM:

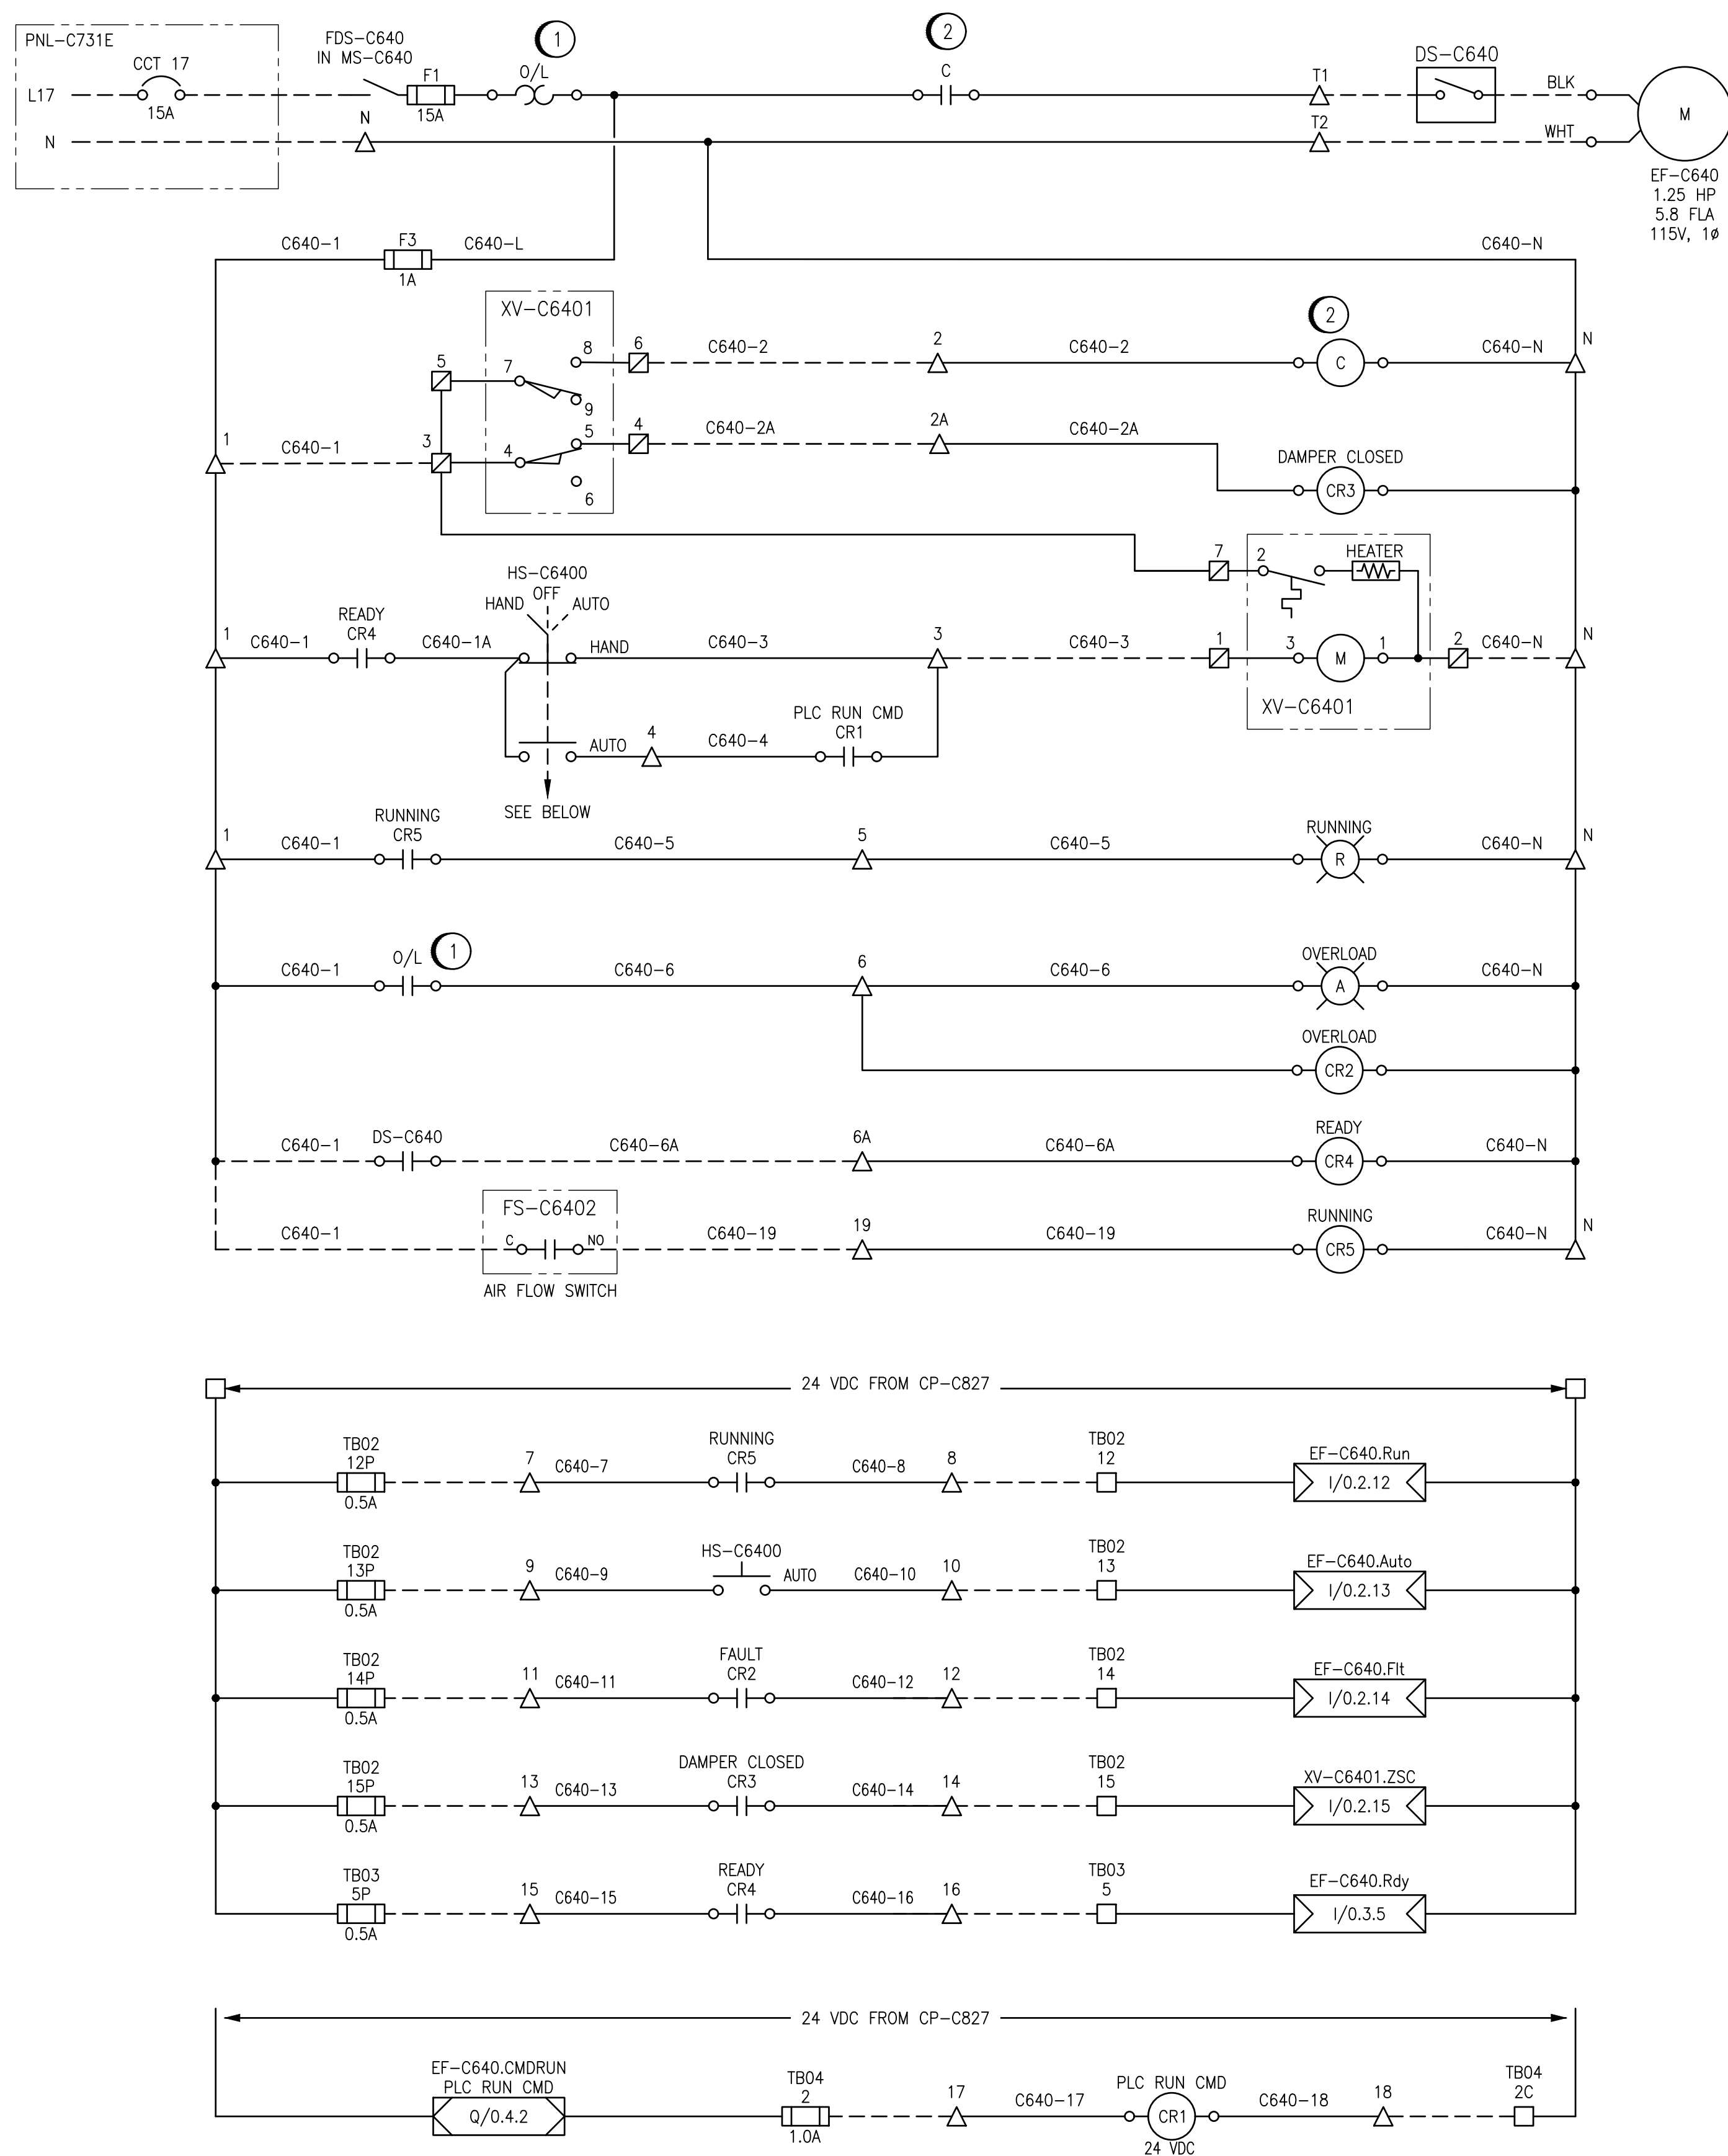

FIELD CONNECTION DIAGRAM:

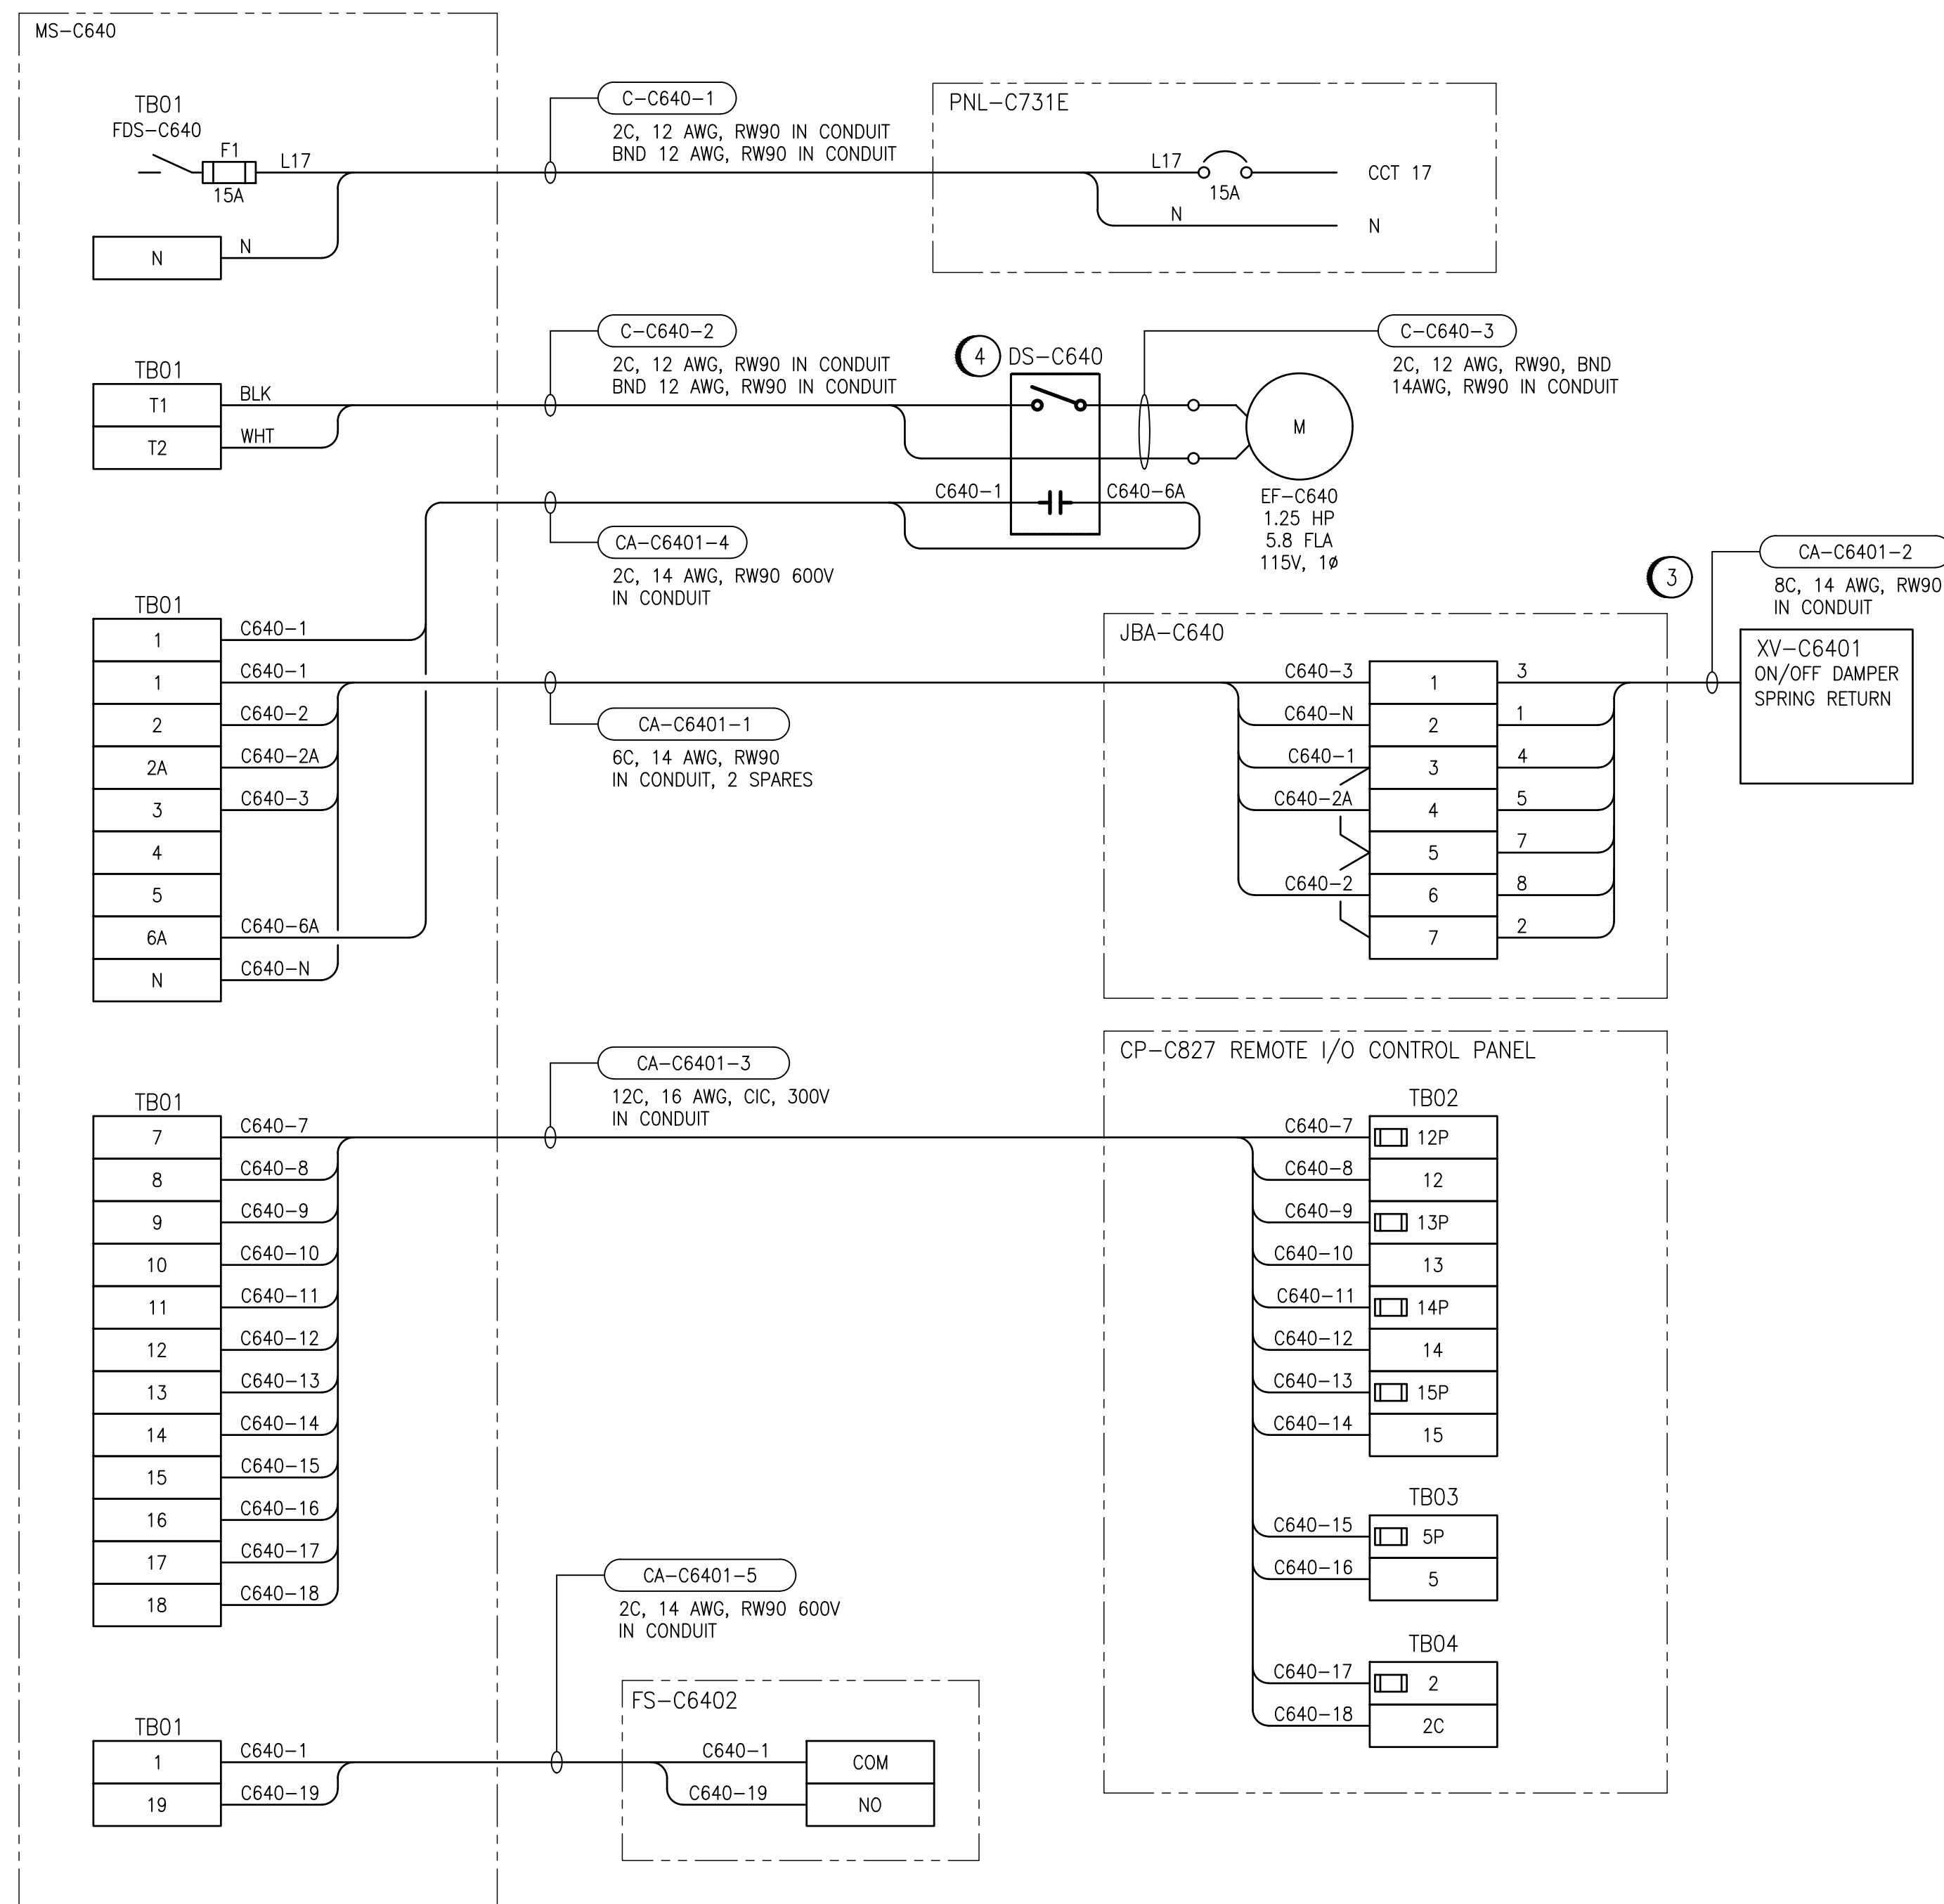


GENERAL NOTES:

- ALL CONNECTIONS FOR POWER AND CONTROLS ARE TO BE IN ACCORDANCE WITH MANUFACTURER RECOMMENDATIONS. REVIEW REQUIREMENTS ON SHOP DRAWINGS. CONTRACTOR TO VERIFY ALL CONNECTIONS WITH MANUFACTURER AND PROVIDE ALL REQUIRED EQUIPMENT, INCLUDING ANY EQUIPMENT NOT SHOWN ON DRAWING.
- ALL EQUIPMENT, CONDUIT AND CABLING SHOWN IS NEW AND SHALL BE PROVIDED BY THE CONTRACTOR UNLESS OTHERWISE NOTED.
- MS-C640 TO BE LOCATED IN CHLORINE TONNER STORAGE ROOM. CONTRACTOR TO PROVIDE CONTROL PANEL LAYOUT BASED ON SCHEMATIC. CONTRACT ADMINISTRATOR TO REVIEW AND APPROVE SHOP DRAWING OF CONTROL PANEL PRIOR TO CONSTRUCTION AND SHIPMENT TO SITE.

CONSTRUCTION NOTES:

- PROVIDE OVERLOAD RELAY BASED ON MOTOR FLA AND NAMEPLATE DATA. OVERLOAD SHALL BE RESET WITH A MANUAL PUSH BUTTON MOUNTED ON THE FRONT OF THE CONTROL PANEL.
- PROVIDE CONTACTOR RATED FOR CONTINUOUS OPERATION AND THE CONTACTOR RATED MINIMUM 1.25X THE FLA OF THE MOTOR.
- JUNCTION BOX TO BE LOCATED WITHIN 10 FEET OF DAMPER ACTUATOR
- CONTRACTOR TO PROVIDE DISCONNECT COMPLETE WITH AUXILIARY CONTACT FOR READY SIGNAL.

LEGEND:

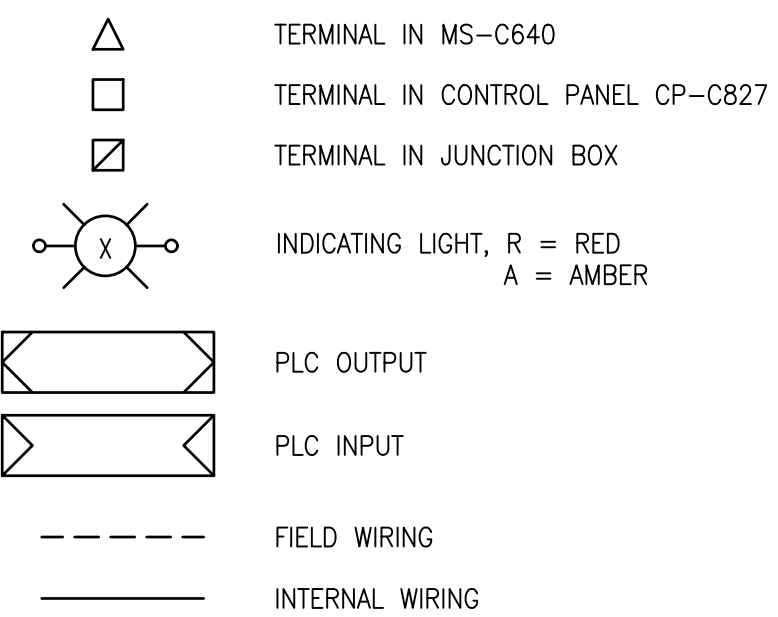

1-0640C-A0024-001	PANEL LAYOUT, DAMPER ACTUATOR, JUNCTION BOXES
1-0640C-A0007-001	PANEL CP-C827, DISCRETE OUTPUTS RACK 0, MODULE 4
1-0640C-A0006-001	PANEL CP-C827, DISCRETE INPUTS RACK 0, MODULE 3
1-0640C-A0005-001	PANEL CP-C827, DISCRETE INPUTS RACK 0, MODULE 2
1-0640C-A0004-001	REMOTE I/O PANEL, CONTROL PANEL CP-C827
1-0640C-A0003-001	REMOTE I/O PANEL LAYOUT, CONTROL PANEL CP-827
1-0640C-E0003-001	SINGLE LINE DIAGRAM, MCC-C710/MCC-C720E

DRAWING NUMBER	REFERENCE DRAWINGS
----------------	--------------------

ENGINEERS
GEOSCIENTISTS
MANITOBA
Certificate of Authorization
AtkinsRéalis Canada Inc.
No. 4489

NO.	REVISIONS	DATE	DESIGN	CHECK
00	ISSUED FOR TENDER AND CONSTRUCTION	2025/04/30	VE	VE

AtkinsRéalis 148 Nature Park Way, Winnipeg, Manitoba Canada R3P 0X7 204-786-8080	
DESIGNED BY: B. WILKS	CHECKED BY: V. ELIMBAN
DRAWN BY: B. WILKS	APPROVED BY: V. ELIMBAN
SCALE: NTS	ISSUED FOR CONSTRUCTION BY: M. SKINNER
DATE: 2023/08/15	DATE: 2025/04/30
CONSULTANT NO.:	

ENGINEER'S SEAL

THE CITY OF WINNIPEG WATER AND WASTE DEPARTMENT			
MCPHILLIPS PUMPING STATION CHLORINE SYSTEM UPGRADES MOTOR STARTER SCHEMATIC / FIELD WIRING DIAGRAM EXHAUST FAN EF-C640 TONNER STORAGE ROOM			
CITY DRAWING NUMBER 1-0640C-E0020	SHEET 001	REV. 00	SIZE A1