


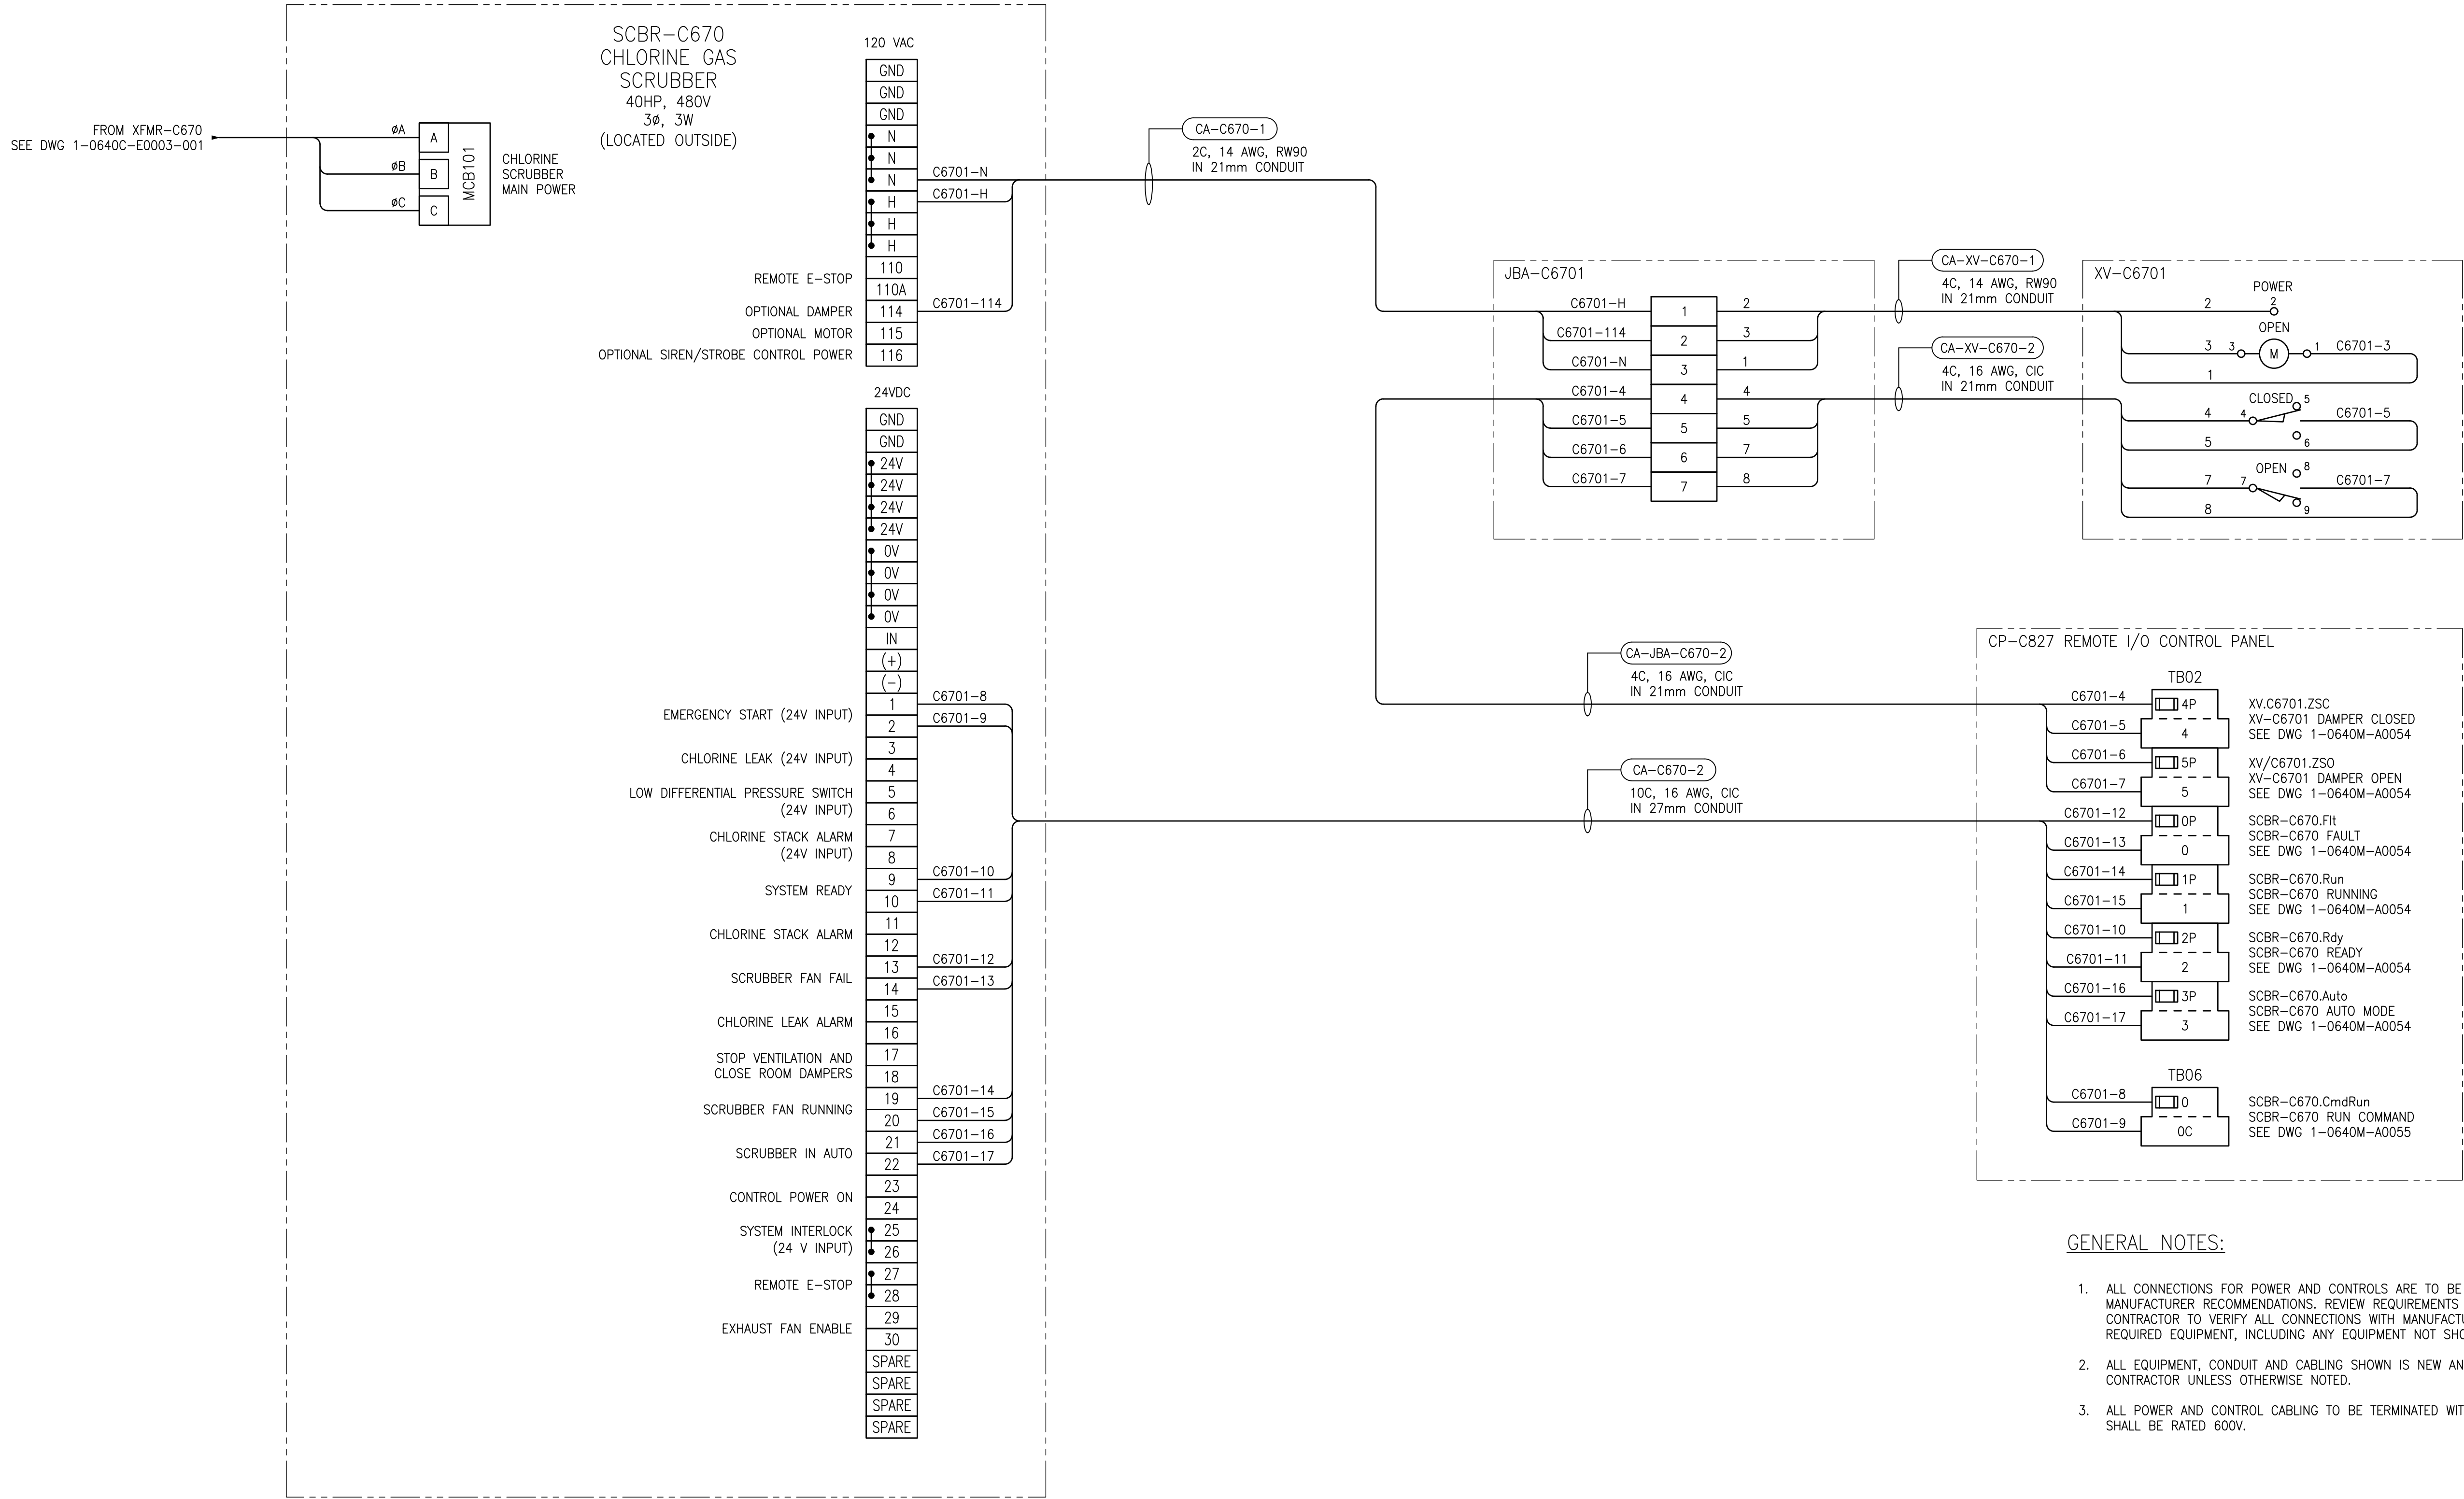

1-0640C-A0024-001	PANEL LAYOUT, DAMPER ACTUATOR, JUNCTION BOXES
1-0640C-A0009-001	PANEL CP-C827, ANALOG INPUTS RACK 0, MODULES 6
1-0640C-A0005-001	PANEL CP-C827, DISCRETE OUTPUTS RACK 0, MODULE 2
1-0640C-A0004-001	REMOTE I/O PANEL, CONTROL PANEL CP-C827
1-0640C-A0003-001	REMOTE I/O PANEL LAYOUT, CONTROL PANEL CP-827
1-0640C-E0003-001	SINGLE LINE DIAGRAM, MCC-C710/MCC-C720E
DRAWING NUMBER	REFERENCE DRAWINGS



					 148 Nature Park Way, Winnipeg, Manitoba Canada R3P 0X7 204-786-8080		ENGINEER'S SEAL		 THE CITY OF WINNIPEG WATER AND WASTE DEPARTMENT									
					DESIGNED BY: B. WILKS				CHECKED BY: V. ELIMBAN		MCPHILLIPS PUMPING STATION CONNECTION DIAGRAM CHLORINE GAS SCRUBBER SCBR-C670							
					DRAWN BY: B. WILKS				APPROVED BY: V. ELIMBAN									
					SCALE: NTS				ISSUED FOR CONSTRUCTION BY: M. SKINNER									
					DATE: 2023/07/22				DATE: 2025/04/30									
					CONSULTANT NO.:													
00		ISSUED FOR TENDER AND CONSTRUCTION			2025/04/30		VE		VE		CITY DRAWING NUMBER 1-0640C-E0025		SHEET 001		REV. 00		SIZE A1	
NO.		REVISIONS			DATE		DESIGN		CHECK									