
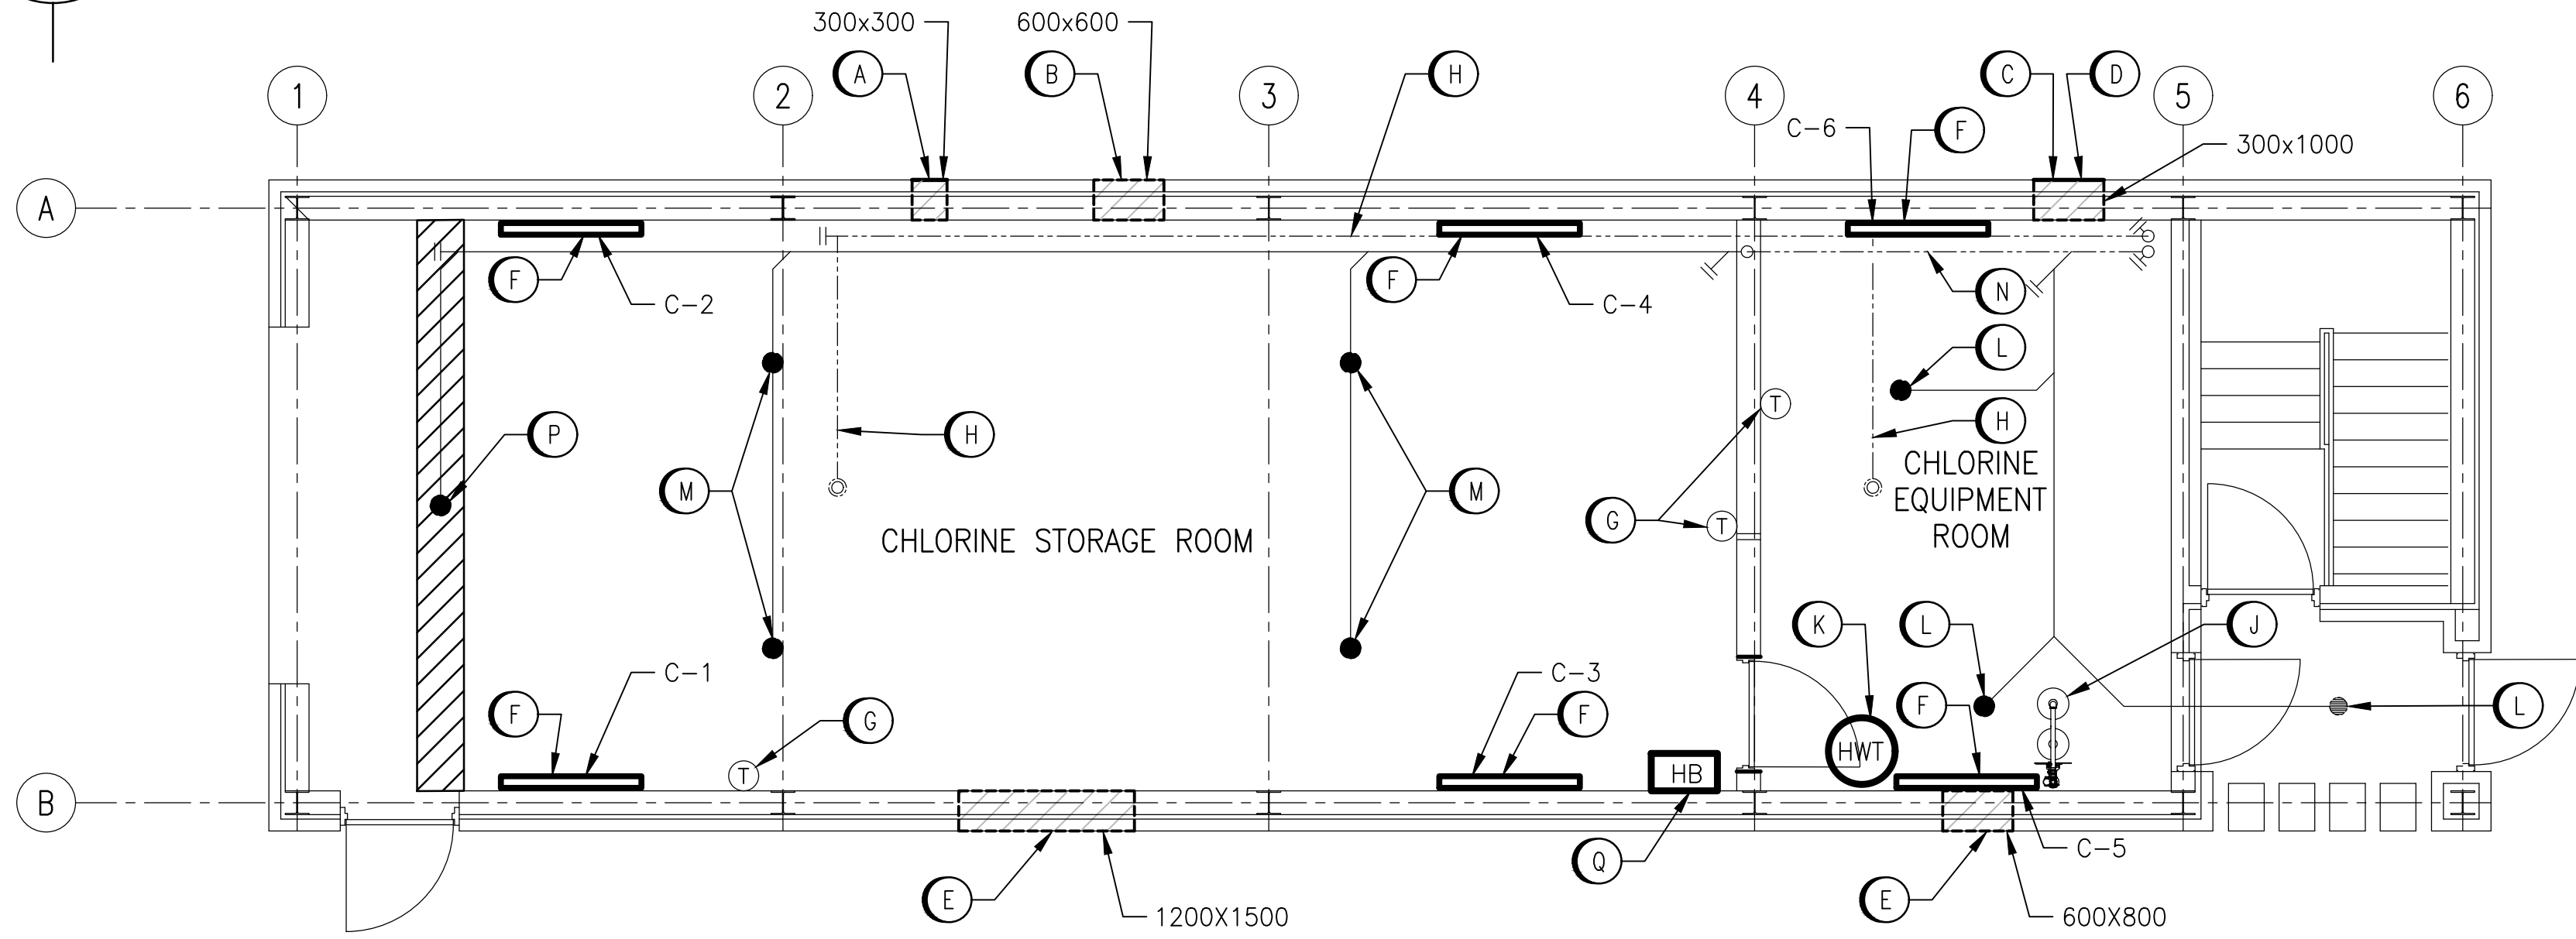


LAST SAVE: 2025/04/23 - 10:49am  
PATH: M:\694715\ENG\45MEC\DD - General DWG\McPHILLIPS\1-0640M-MXXX-001-PD.dwg

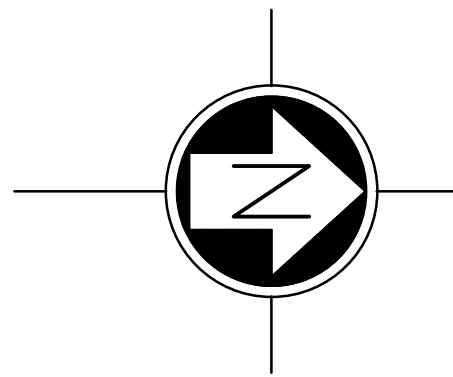

MAIN FLOOR PLAN  
SCALE: 1 : 50

#### DEMOLITION NOTES

- (A) REMOVE EXISTING EXHAUST FAN (FN-3), LOUVRE AND DAMPER.
- (B) REMOVE EXISTING EXHAUST FAN (FN-4), LOUVRE AND DAMPER.
- (C) REMOVE EXISTING EXHAUST FAN (FN-1), LOUVRE AND DAMPER.
- (D) REMOVE EXISTING EXHAUST FAN (FN-2), LOUVRE AND DAMPER.
- (E) REMOVE EXISTING MOTORIZED DAMPER AND LOUVRE.
- (F) EXISTING 5kW ELECTRICAL WALL HEATER TO REMAIN.
- (G) EXISTING THERMOSTAT AND WIRING TO REMAIN.
- (H) EXISTING RWL AT HIGH LEVEL TO REMAIN.
- (J) EXISTING EYEWASH STATION TO REMAIN. REMOVE DCW PIPING AND DHW PIPING TO SAFETY SHOWER/EYEWASH. REMOVE EXISTING MIXING VALVE.
- (K) EXISTING HOT WATER TANK TO BE REMOVED.
- (L) EXISTING FLOOR DRAIN TO REMAIN.
- (M) FLOOR DRAIN TO BE FILLED AND ABANDONED.


#### DEMOLITION NOTES



- (N) EXISTING DRAIN PIPE/VENT TO REMAIN.
- (P) EXISTING CONCRETE FLOOR TO BE REMOVED AS SHOWN. EXISTING FLOOR DRAIN AND PIPE TO BE REMOVED. PREPARE SITE FOR NEW DRAIN PIPE.
- (Q) EXISTING HOSE BIB TO BE REMOVED AND EXISTING DCW SUPPLY TO BE MODIFIED TO SUIT NEW PLUMBING REQUIREMENTS.

#### GENERAL NOTES

1. DRAWING INFORMATION BASED ON HISTORICAL DRAWING AND SITE INVESTIGATIONS.
2. INSULATION ON ALL EXISTING DOMESTIC WATER, FRESH AIR INTAKE, RAIN WATER LEADER, CONDENSATE AND DRAIN PIPE FITTINGS MAY CONTAIN ASBESTOS MATERIALS. REFER TO EXISTING ASBESTOS REPORTS TO CONFIRM.
3. MASONRY BLOCK WALLS, CEILING OR WALL HARD PLASTERS AND CERAMIC FLOOR TILES MAY CONTAIN ASBESTOS.

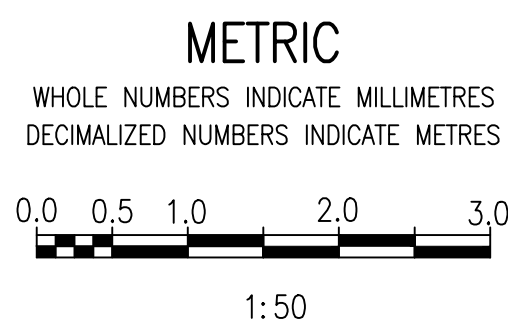DRAWING NUMBER	REFERENCE DRAWINGS



					 <b>AtkinsRéalis</b> 148 Nature Park Way, Winnipeg, Manitoba Canada R3P 0X7 204-786-8080		ENGINEER'S SEAL		 <b>THE CITY OF WINNIPEG</b> WATER AND WASTE DEPARTMENT									
					DESIGNED BY: T. SHAW		CHECKED BY: S. NORSWORTHY		MCPHILLIPS PUMPING STATION CHLORINE SYSTEM UPGRADE MECHANICAL REMOVALS									
					DRAWN BY: M. GAUDINO		APPROVED BY: S. NORSWORTHY											
					SCALE: AS NOTED		ISSUED FOR CONSTRUCTION BY: M. SKINNER											
					DATE: 2023-03-06		DATE: 2025/04/30											
					CONSULTANT NO.: 694715-3000-45DD-1001				CITY DRAWING NUMBER									
00		ISSUED FOR TENDER AND CONSTRUCTION			2025/04/30		TS		SN		1-0640C-M0001		SHEET 001		REV. 00		SIZE A1	
NO.		REVISIONS			DATE		DESIGN		CHECK									