


SHELTER BASE PLAN


NOTE: CONFIRM FINAL CROSS SLOPE WITH CONTRACT ADMINISTRATOR PRIOR TO LAYOUT CONTRACTOR TO REPORT ANY DISCREPANCIES TO CONTRACT ADMINISTRATOR PRIOR TO LAYOUT.

CONTRACTOR TO VERIFY EXACT DIMENSIONS OF SHELTER PRIOR TO LAYOUT WITH SHELTER MANUFACTURER. CONTRACT ADMINISTRATOR TO SUPPLY CONTACT INFORMATION.

1 C.I.P. SHELTER BASE FOR HEATED SHELTERS
N.T.S.

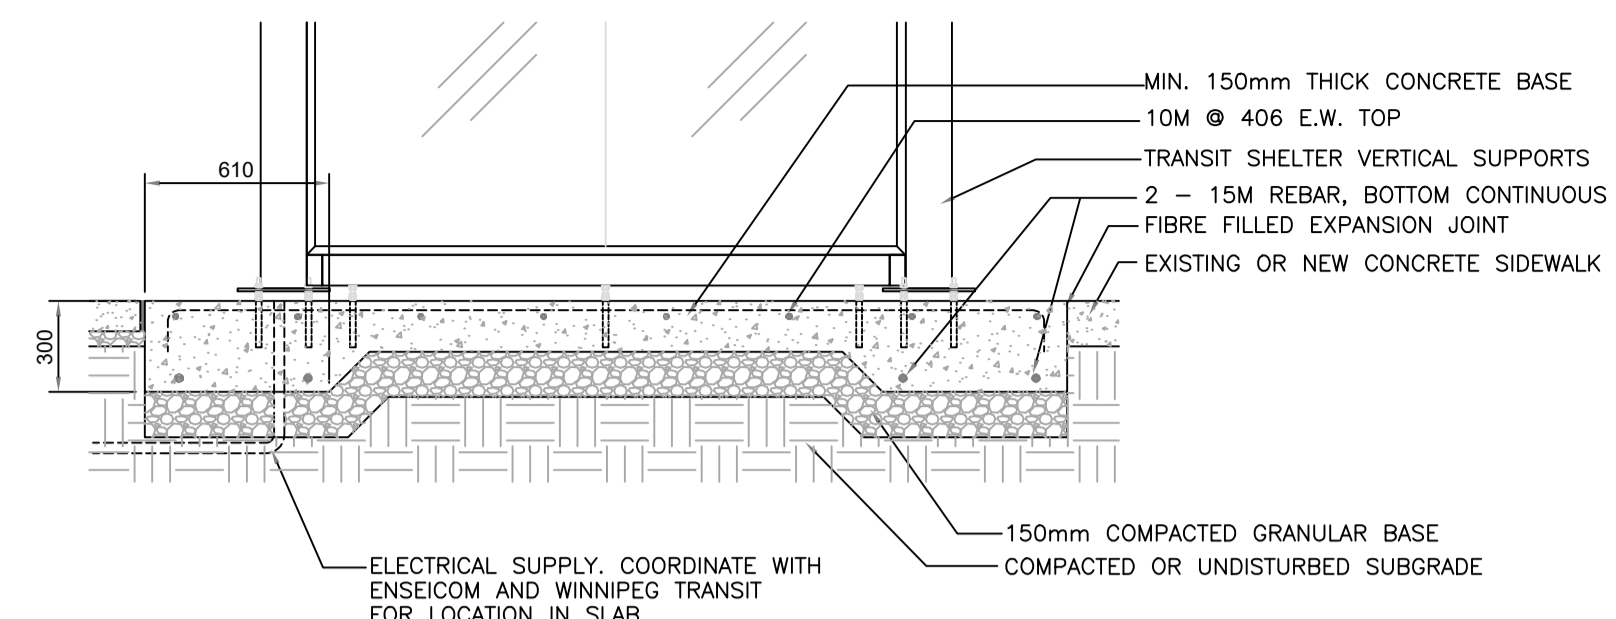


SHELTER BASE SECTION

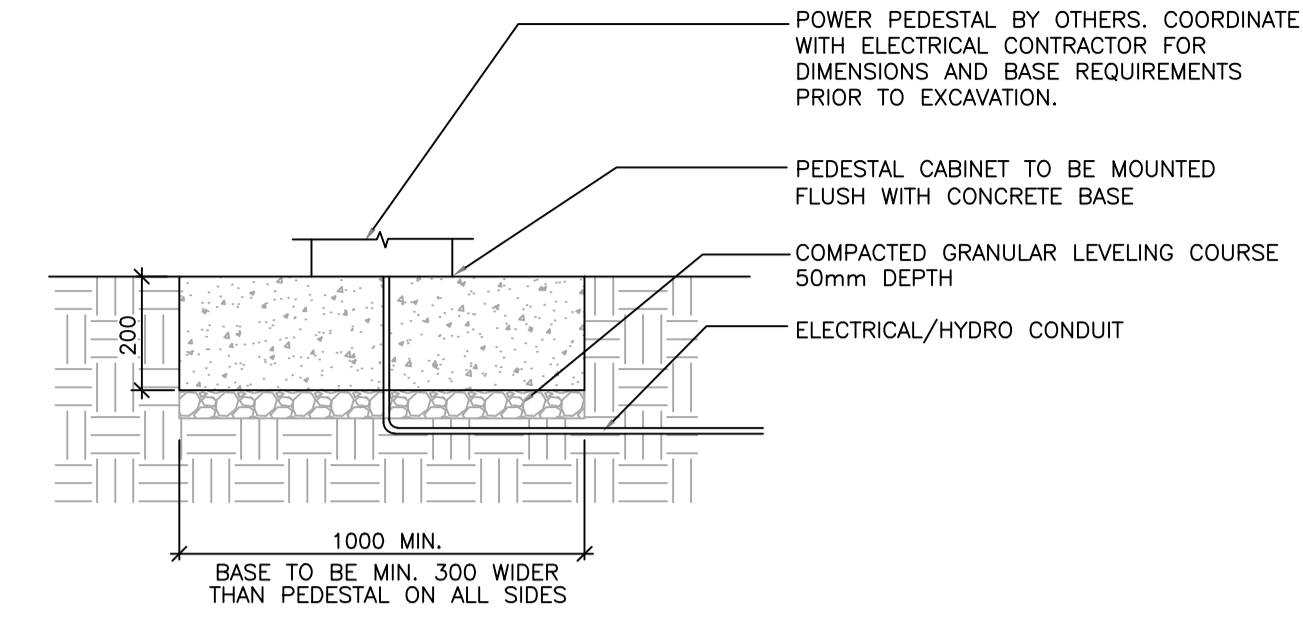


NOTE: EXACT LOCATION OF PEDESTAL TO BE CONFIRMED ON SITE BY WINNIPEG TRANSIT AND CONTRACT ADMINISTRATOR CONTRACTOR TO COORDINATE WITH LAND OWNERS & WINNIPEG TRANSIT RE: CONDUIT LOCATIONS GROUND ROD TO BE INSTALLED BY CONTRACTOR SIZE AND LOCATION TO BE CONFIRMED BY PEDESTAL MANUFACTURER WHERE POWER PEDESTAL WILL BE WITHIN AREA OF NEW CONCRETE SIDEWALK THE BASE IS TO BE POURED INTEGRAL WITH SIDEWALK


2 POWER PEDESTAL BASE
N.T.S.

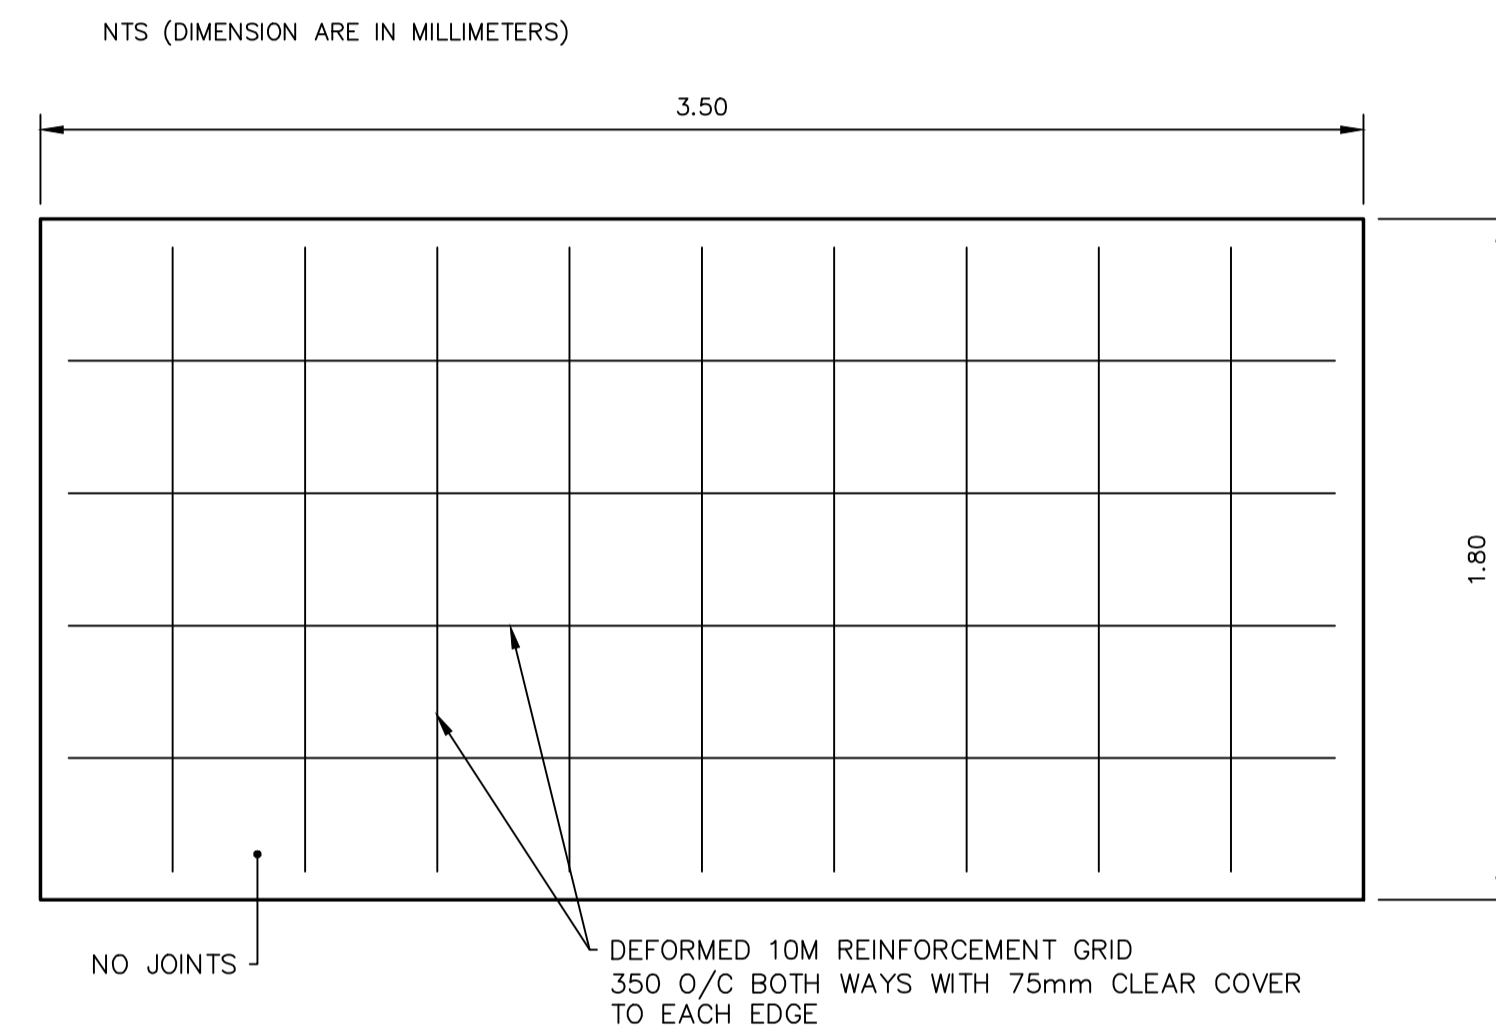

3 NON-HEATED SHELTER DETAIL
N.T.S.

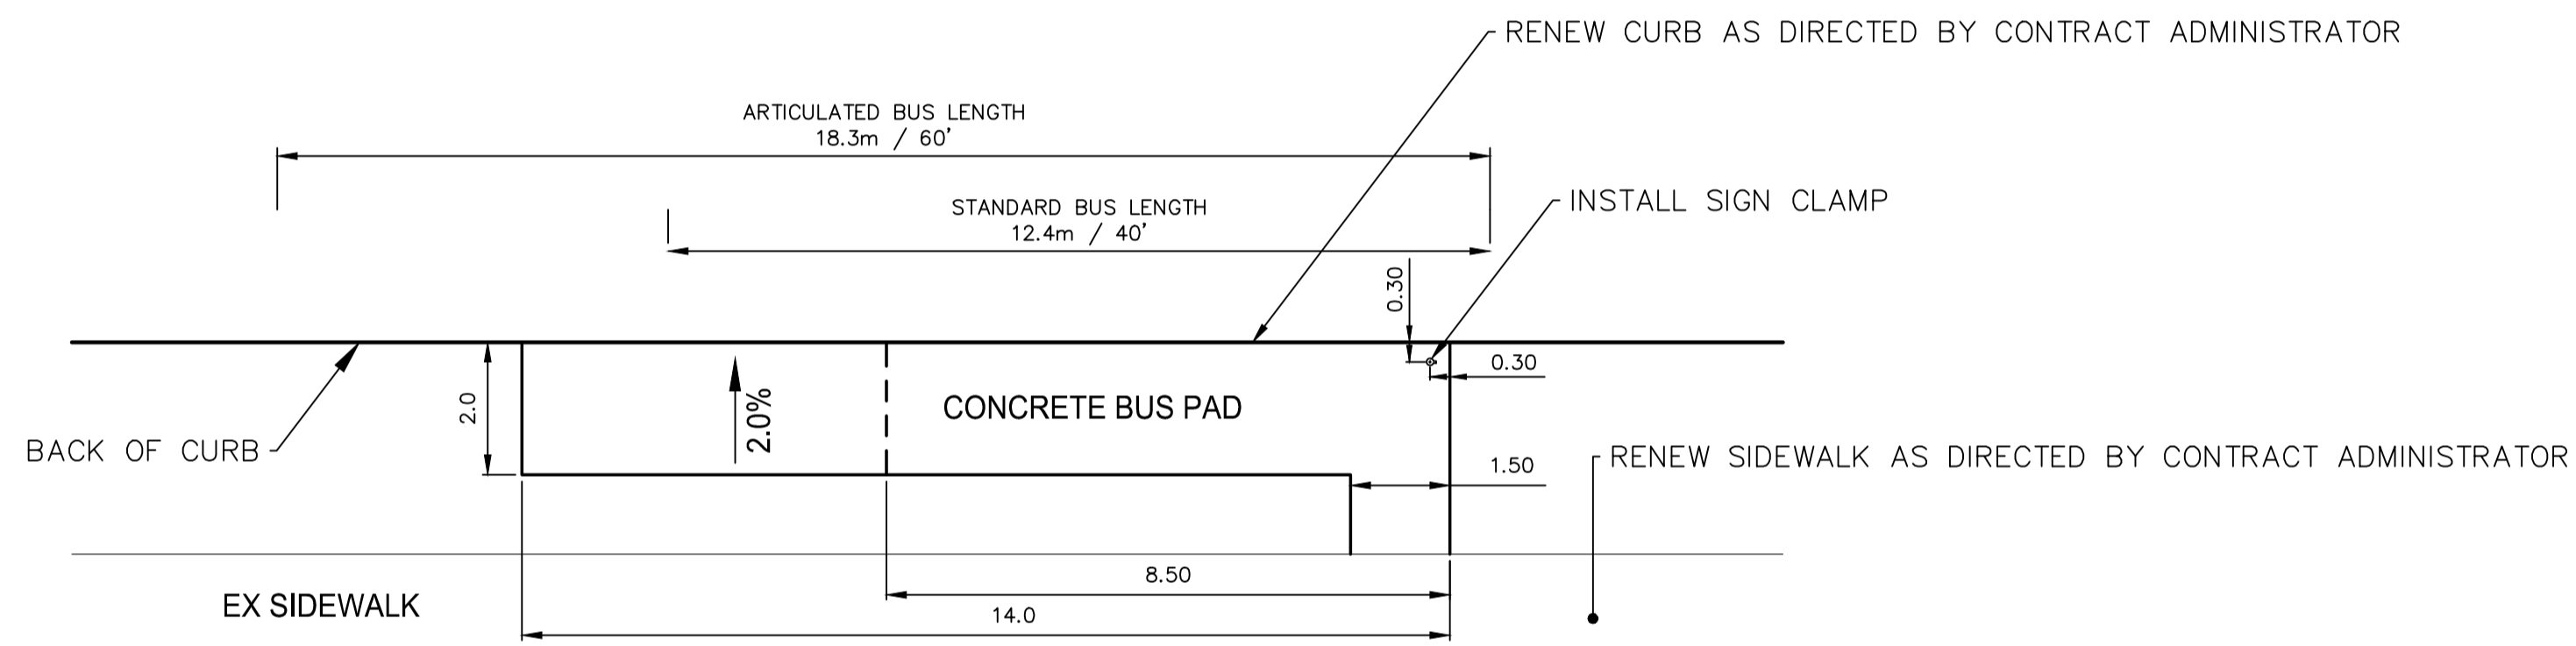

4 TYPICAL TRANSIT STOP
N.T.S.

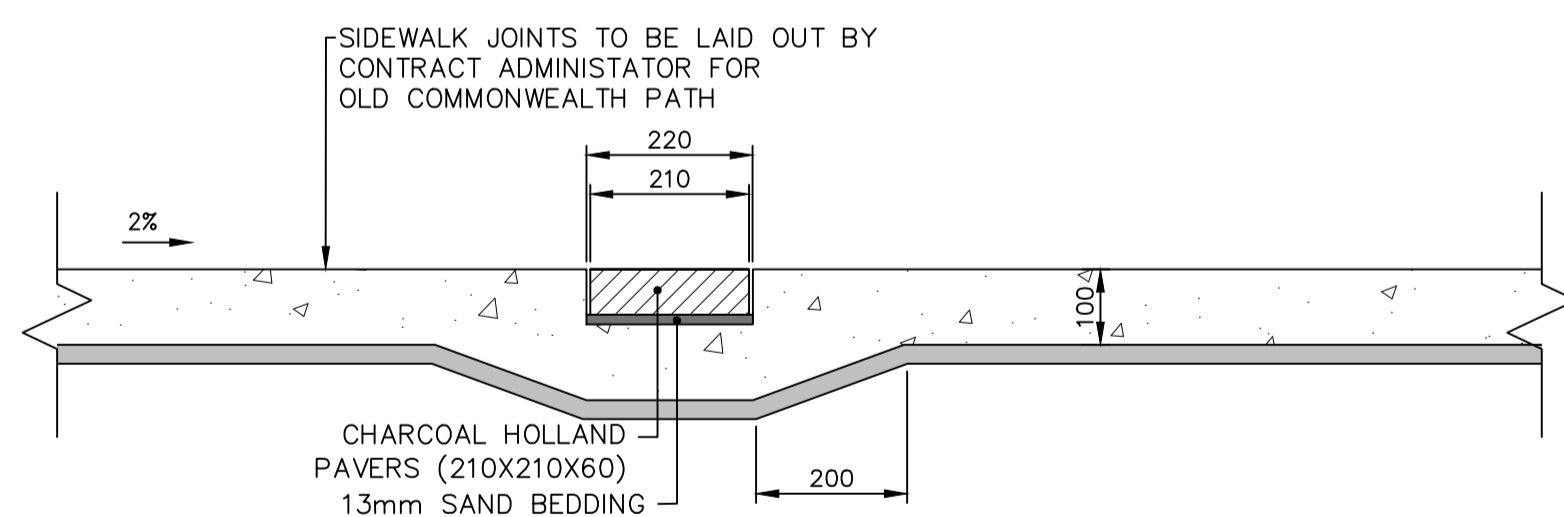

5 SIDEWALK WITH BLOCKOUT FOR PAVING STONE DETAIL
N.T.S.

METRIC
WHOLE NUMBERS INDICATE MILLIMETRES
DECIMALIZED NUMBERS INDICATE METRES

ENGINEERS GEOSCIENTISTS MANITOBA
Certificate of Authorization
WSP Canada Inc.
No. 5750

FOR TENDER PURPOSES ONLY
NOT FOR CONSTRUCTION

May 12, 2025 - 7:58am
P:\2023\CA0017599.2194 - 2024 Local Street Renewals_751-2023\2025 Transit Stops\02 Drawings\03_Work_Dwg\CA0017599.2194-Construction_Details.dwg - Job: 33-2025_Drawing_CA0017599.2194-28-R2

NO.	REVISIONS	DATE	BY
8			
7			
6			
5			
4			
3	ISSUED FOR CONSTRUCTION	2025/05/07	R.H.
2	ISSUED FOR TENDER	2025/02/01	S.R.S.
1	ISSUED FOR 75% REVIEW	2025/01/20	S.R.S.

DESIGNED BY	S.R.S.	CHECKED BY	R.H.
DRAWN BY	E.M.	APPROVED BY	S.R.S.
HOR. SCALE	N.T.S.	RELEASED FOR CONSTRUCTION	R.MUNRO
VERTICAL	1:10	DATE	2025/01/20
DATE	2025/01/20	DATE	2025/05/12

WSP Canada Inc.
1600 Buffalo Place
Winnipeg, MB R3T 6B8
t. 204.477.6650
f. 204.474.2864
www.wsp.com


ENGINEER'S SEAL
V.M. MAROTI
Member 30809
2025-05-12
CONSULTANT ACAD DWG. NO.
CA0017599.2194-28

THE CITY OF WINNIPEG
PUBLIC WORKS DEPARTMENT
ENGINEERING SERVICES DIVISION

2025 TRANSIT INFRASTRUCTURE IMPROVEMENTS

VARIOUS LOCATIONS
CONSTRUCTION DETAILS


CITY DRAWING NUMBER
SHEET 07 OF 12
TENDER NO.
33-2025

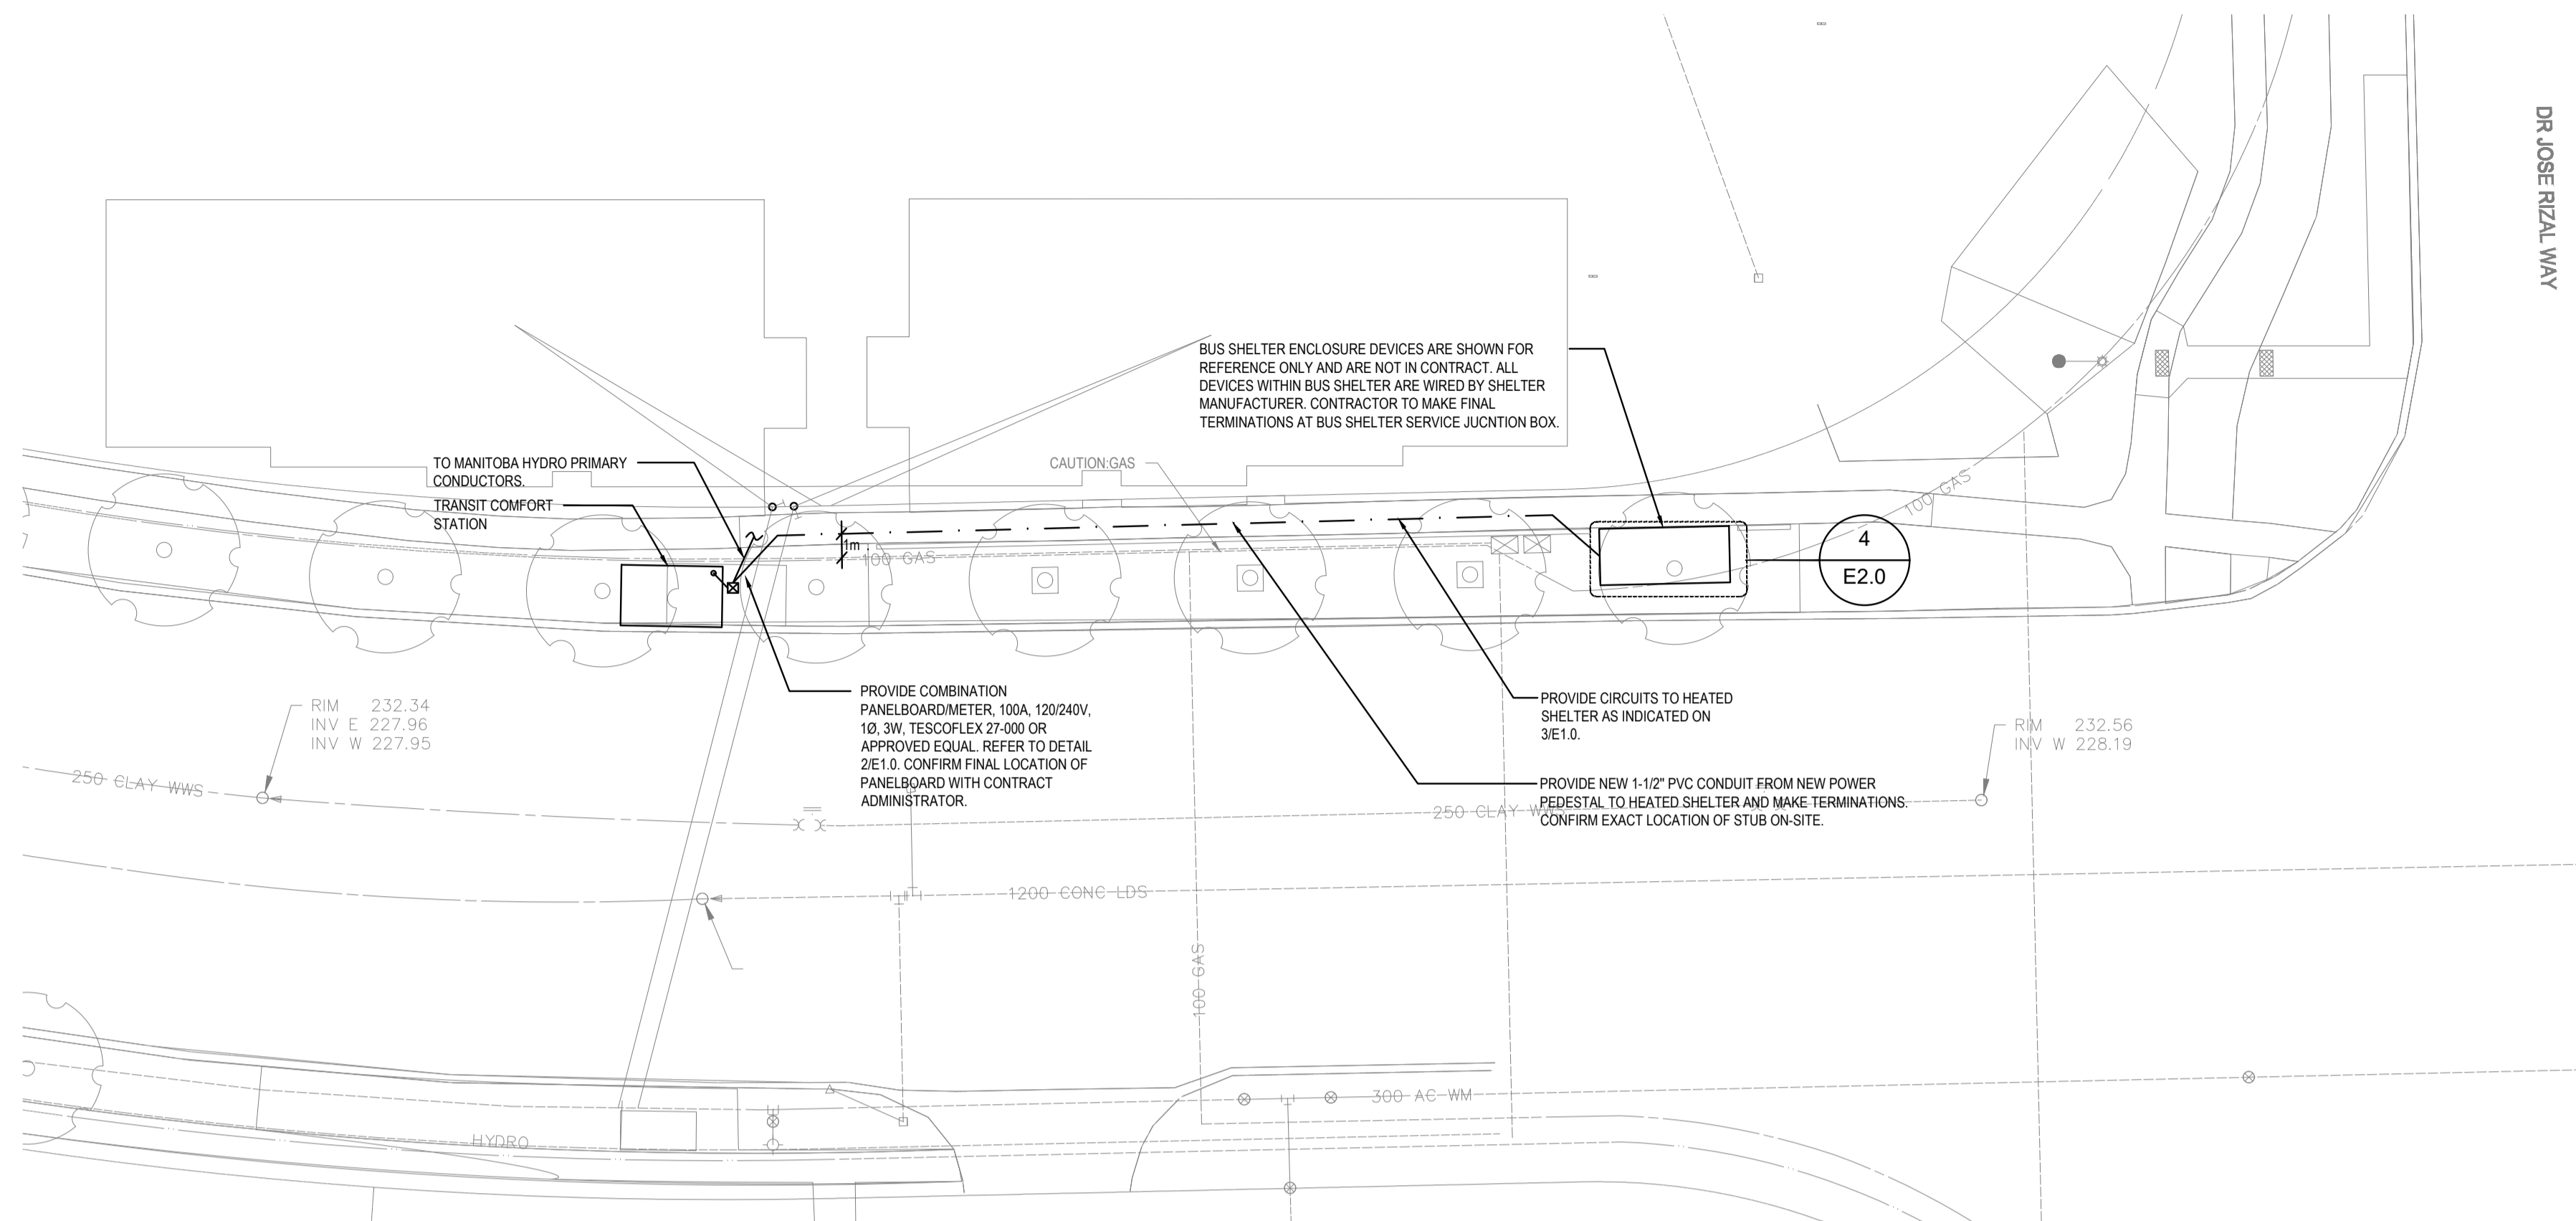

DR. JOSE RIZAL WAY

- GENERAL NOTES:
1. VERIFY LOCATIONS OF UTILITIES AND PROTECT ALL ELECTRICAL EQUIPMENT AGAINST DAMAGE DURING CONSTRUCTION.
 2. COORDINATE POLE BASE AND POWER LOCATIONS WITH CIVIL AND LANDSCAPE DRAWINGS.
 3. TRENCHLINE IS SHOWN FOR APPROXIMATE ROUTING. CONTRACTOR SHALL CONFIRM AND COORDINATE ROUTING OF CONDUIT WITH SITE CONDITIONS.
 4. ELECTRICAL TRENCH INSTALL ATLEAST 1m AWAY FROM GAS LINE AS SHOWN.

1 OLD COMMONWEALTH - ELECTRICAL SITE PLAN
Scale: 1:250

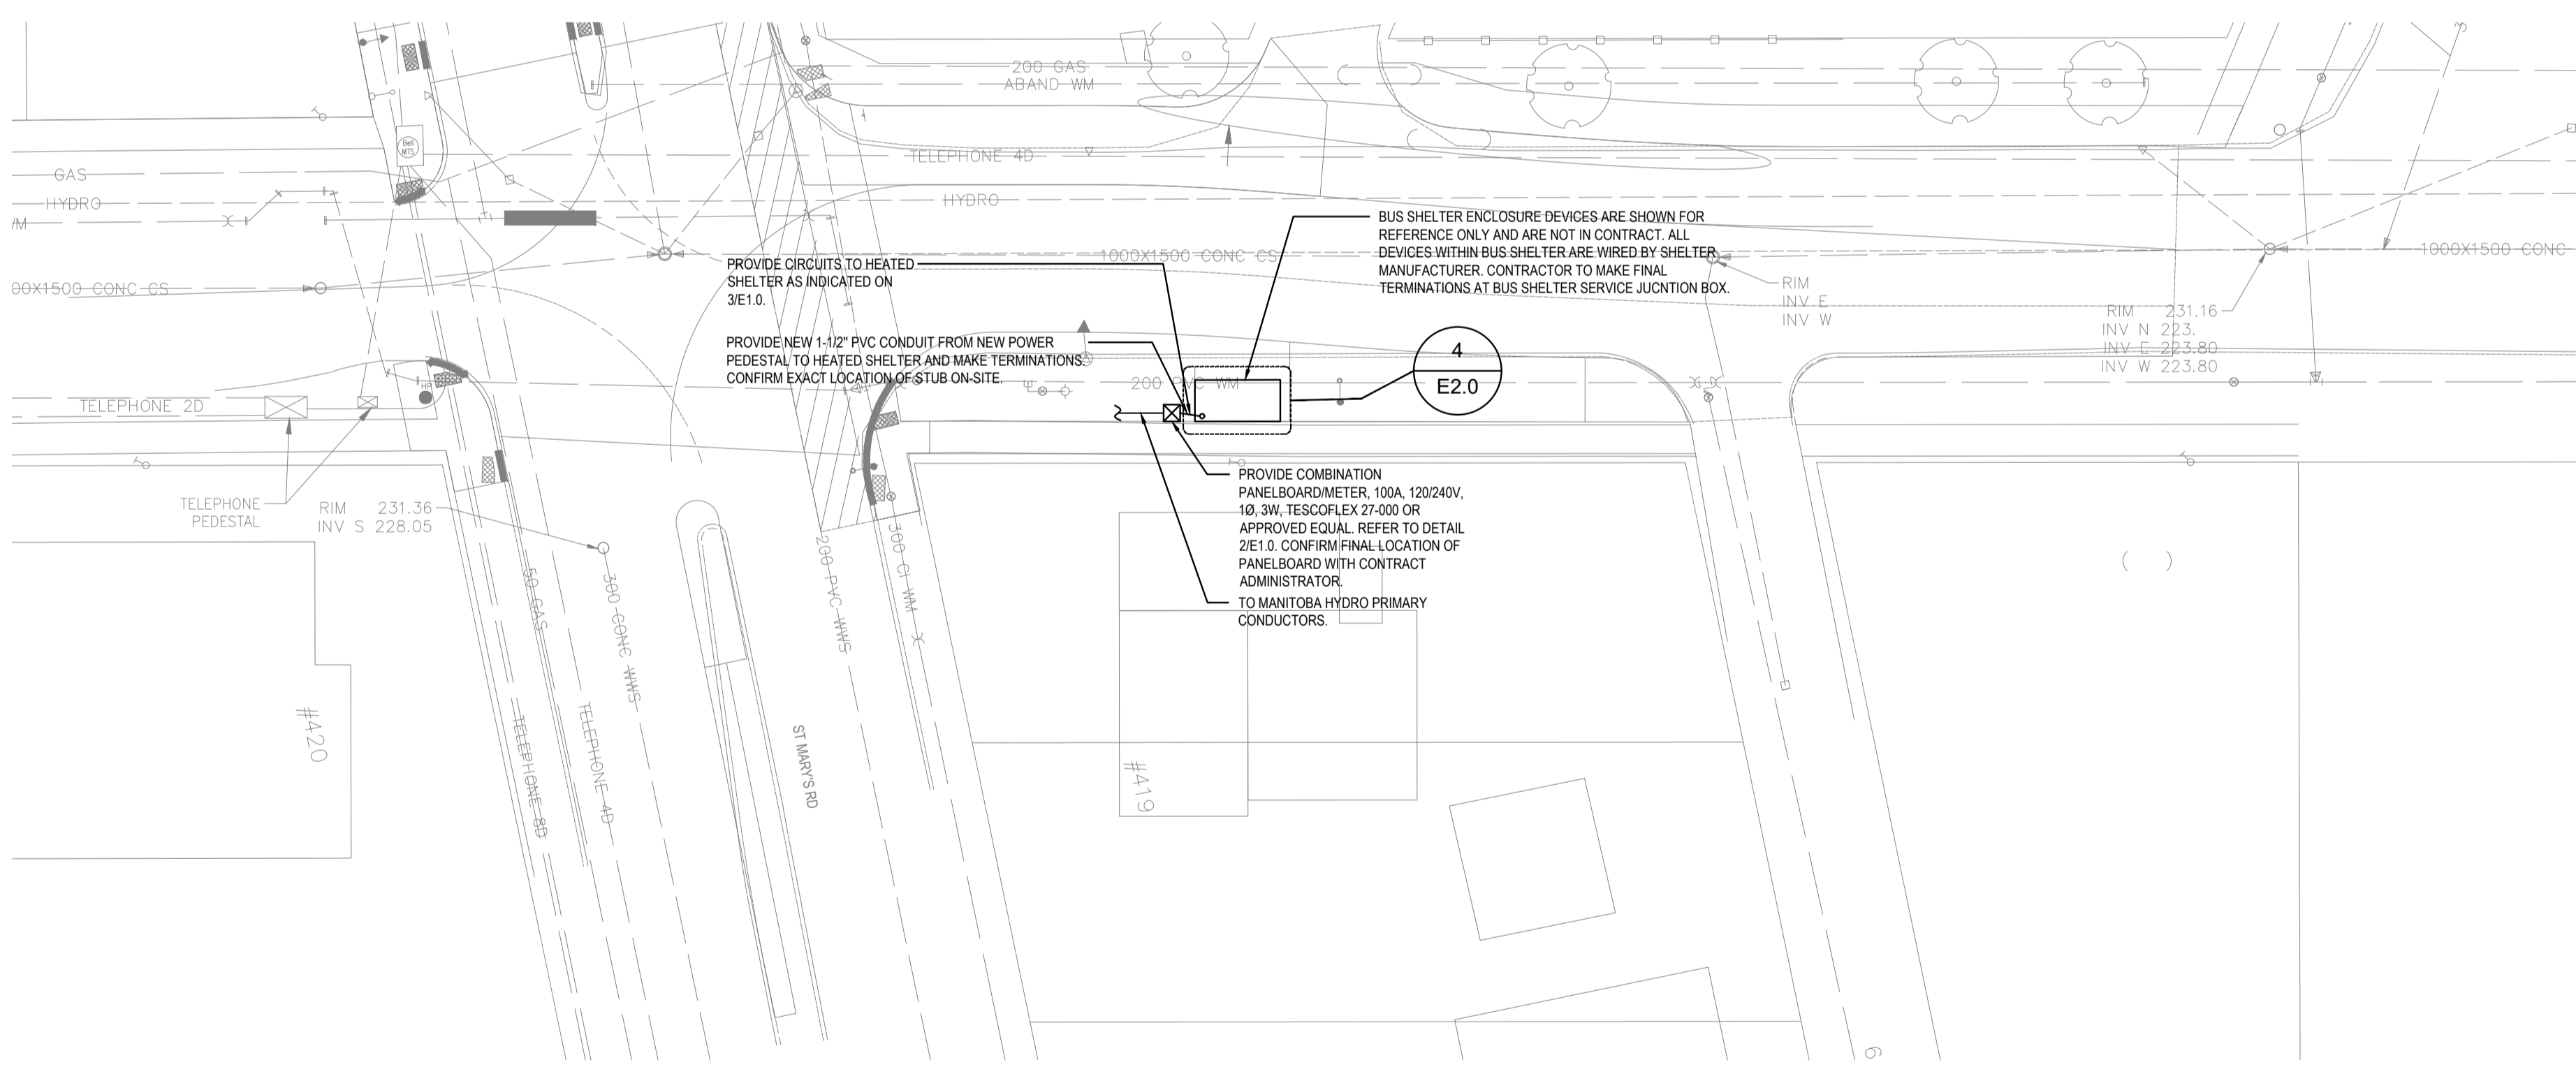

2 CARRIERE AVE - ELECTRICAL SITE PLAN
Scale: 1:250

ISSUED FOR CONSTRUCTION



MCW Consultants Ltd.
Vancouver Calgary
Edmonton Dauphin
Winnipeg Toronto
Thunder Bay
Ottawa Moncton
Saint John Truro
Halifax

210-1821 Wellington Avenue
Winnipeg, Manitoba
R3H 0G4
Tel: 204-779-7900
Fax: 204-779-1119
www.mcw.com

LOCATIONS APPROVED UNDERGROUND STRUCTURES


SIGNED BY: _____ DATE: _____

SUPV UG STRUCTURES _____ DATE _____

LOCATION OF UNDERGROUND STRUCTURES AS SHOWN ARE BASED ON THE BEST INFORMATION AVAILABLE BUT NO GUARANTEE IS GIVEN THAT ALL EXISTING UTILITIES ARE SHOWN OR THAT THE GIVEN LOCATIONS ARE EXACT CONFIRMATION OF EXISTANCE AND EXACT LOCATION OF ALL SERVICES MUST BE OBTAINED FROM THE INDIVIDUAL UTILITIES BEFORE PROCEEDING

NO.	ISSUED FOR CONSTRUCTION	DATE	BY
0	ISSUED FOR CONSTRUCTION	2025-05-02	MJB

DESIGNED BY	JDV	CHECKED BY	MJB
DRAWN BY	JDV	APPROVED BY	MJB
RELEASED FOR CONSTRUCTION			R.MUNRO
DATE	2025/05/12		

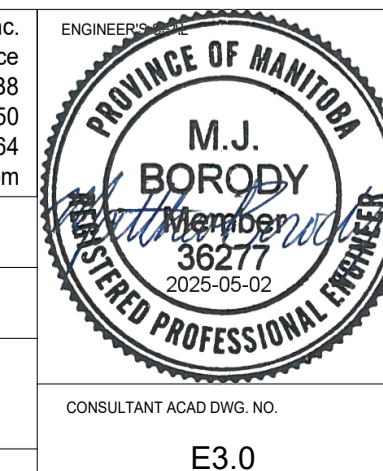

THE CITY OF WINNIPEG
PUBLIC WORKS DEPARTMENT
ENGINEERING SERVICES DIVISION

2025 TRANSIT INFRASTRUCTURE IMPROVEMENTS
VARIOUS LOCATIONS - ELECTRICAL

TRANSIT INFRASTRUCTURE IMPROVEMENTS

16156

10 OF 10 SHEETS

TENDER NO. 33-2025