
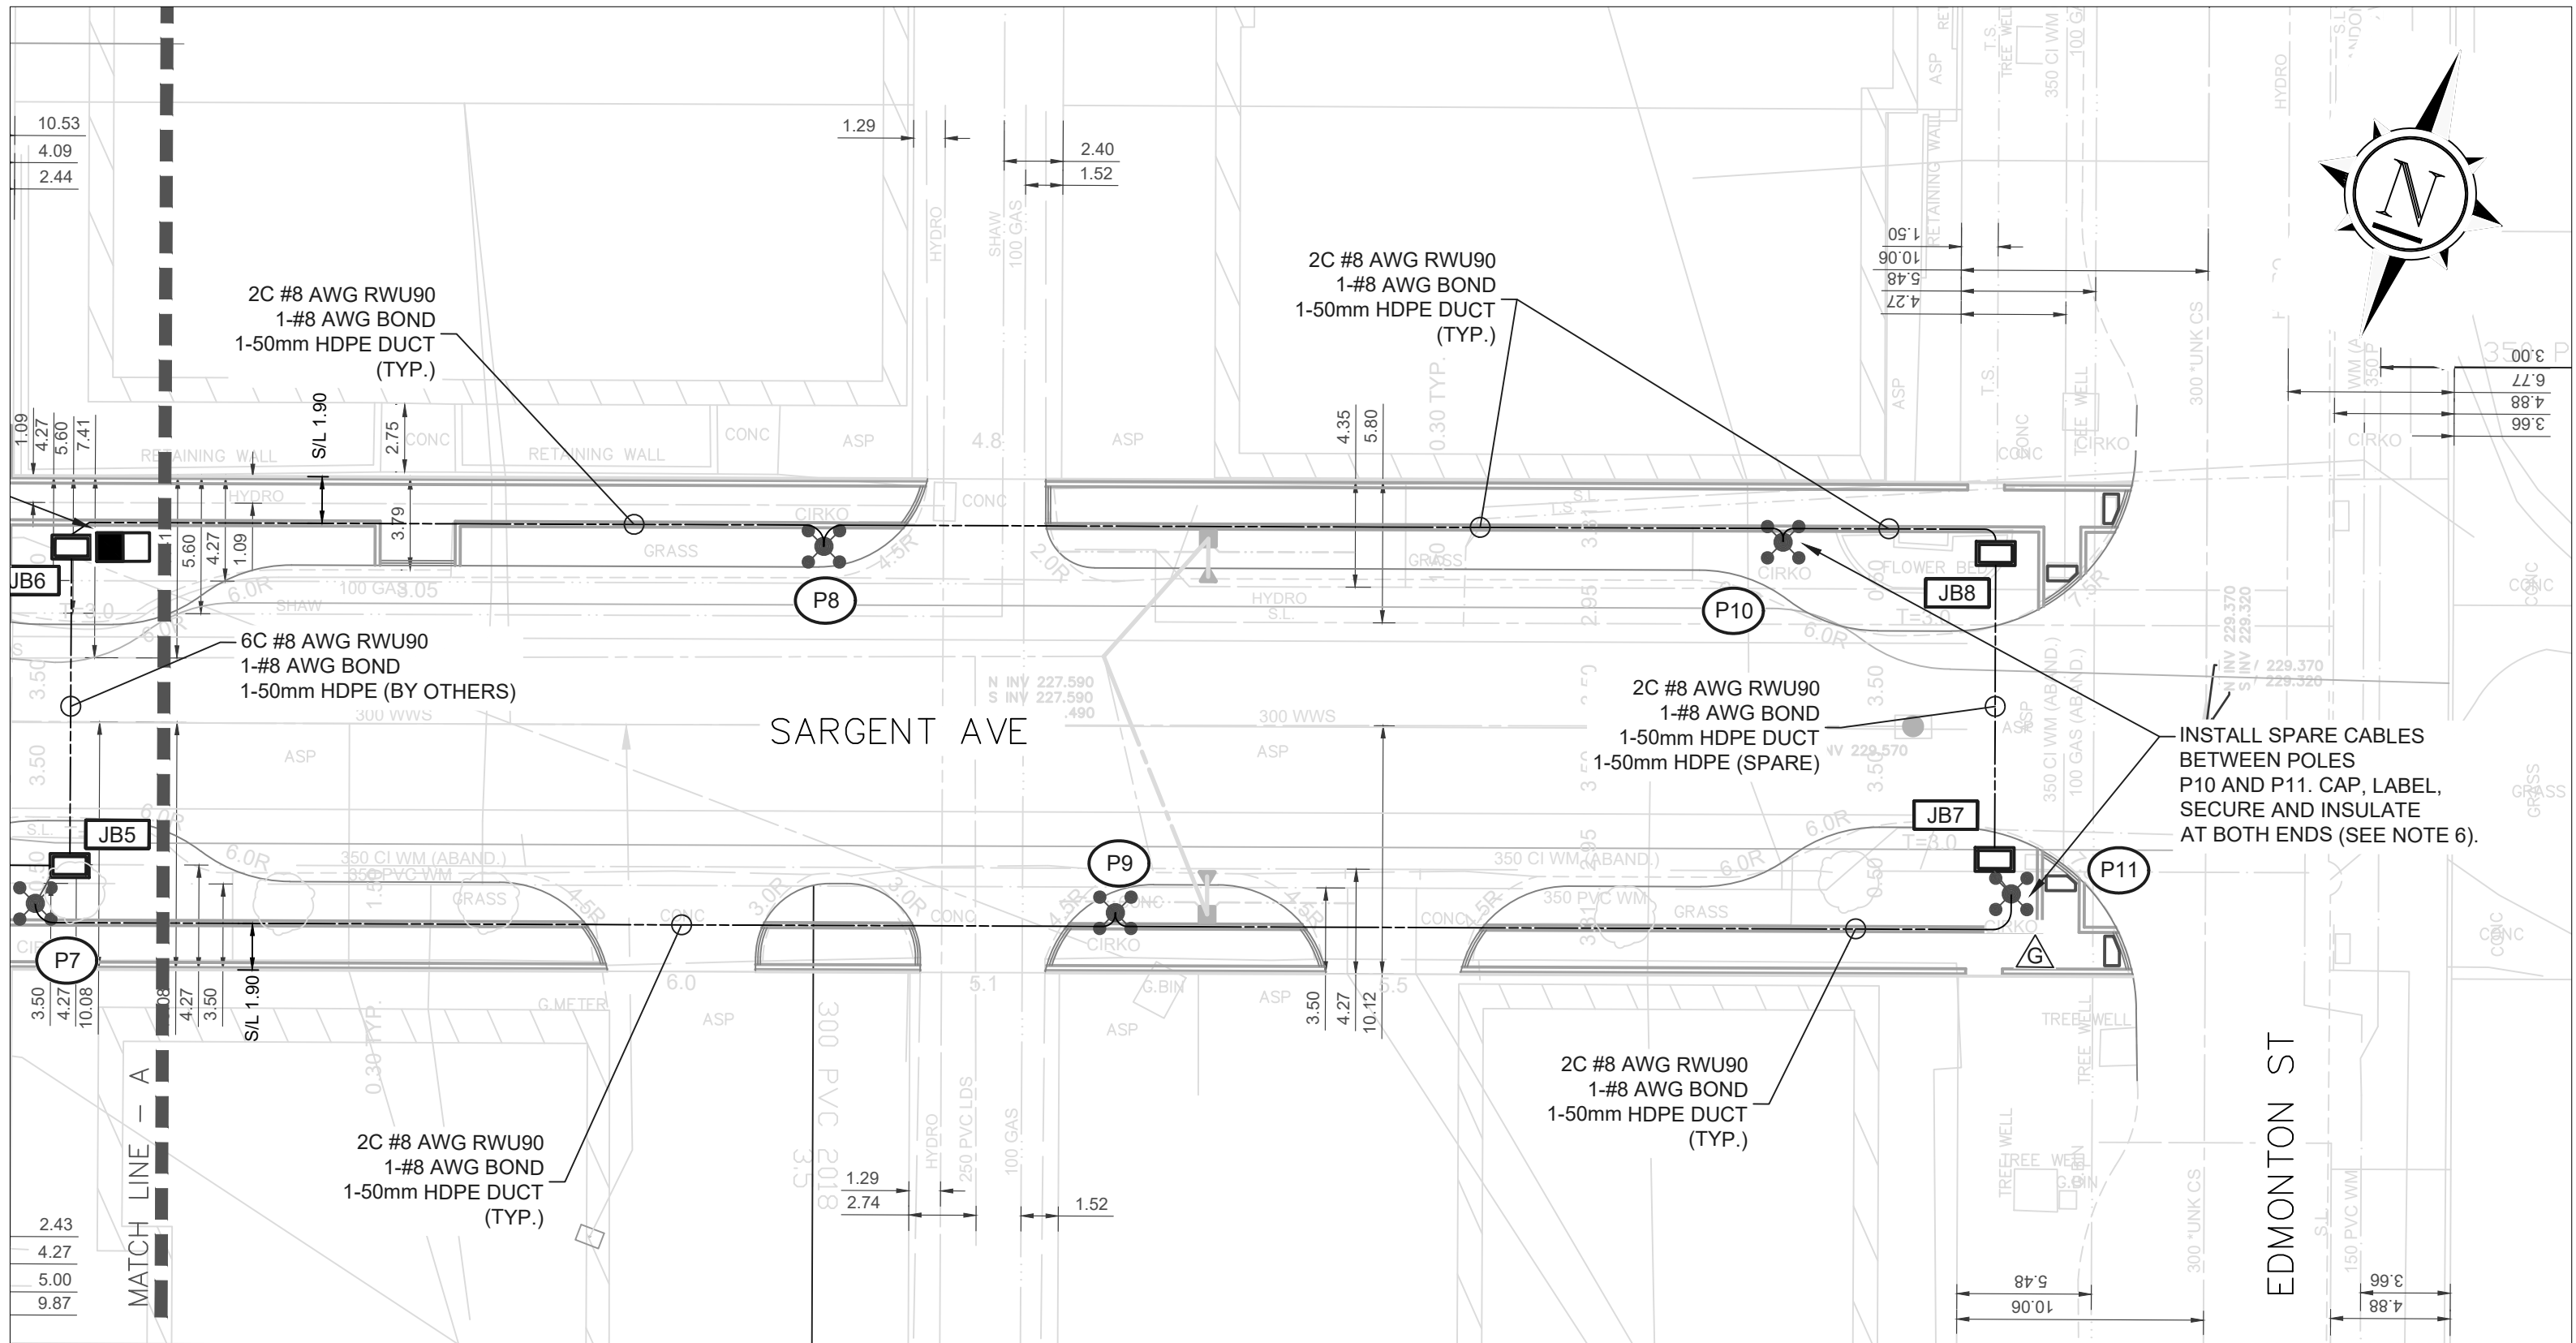


PLAN
1:250

KEY MAP

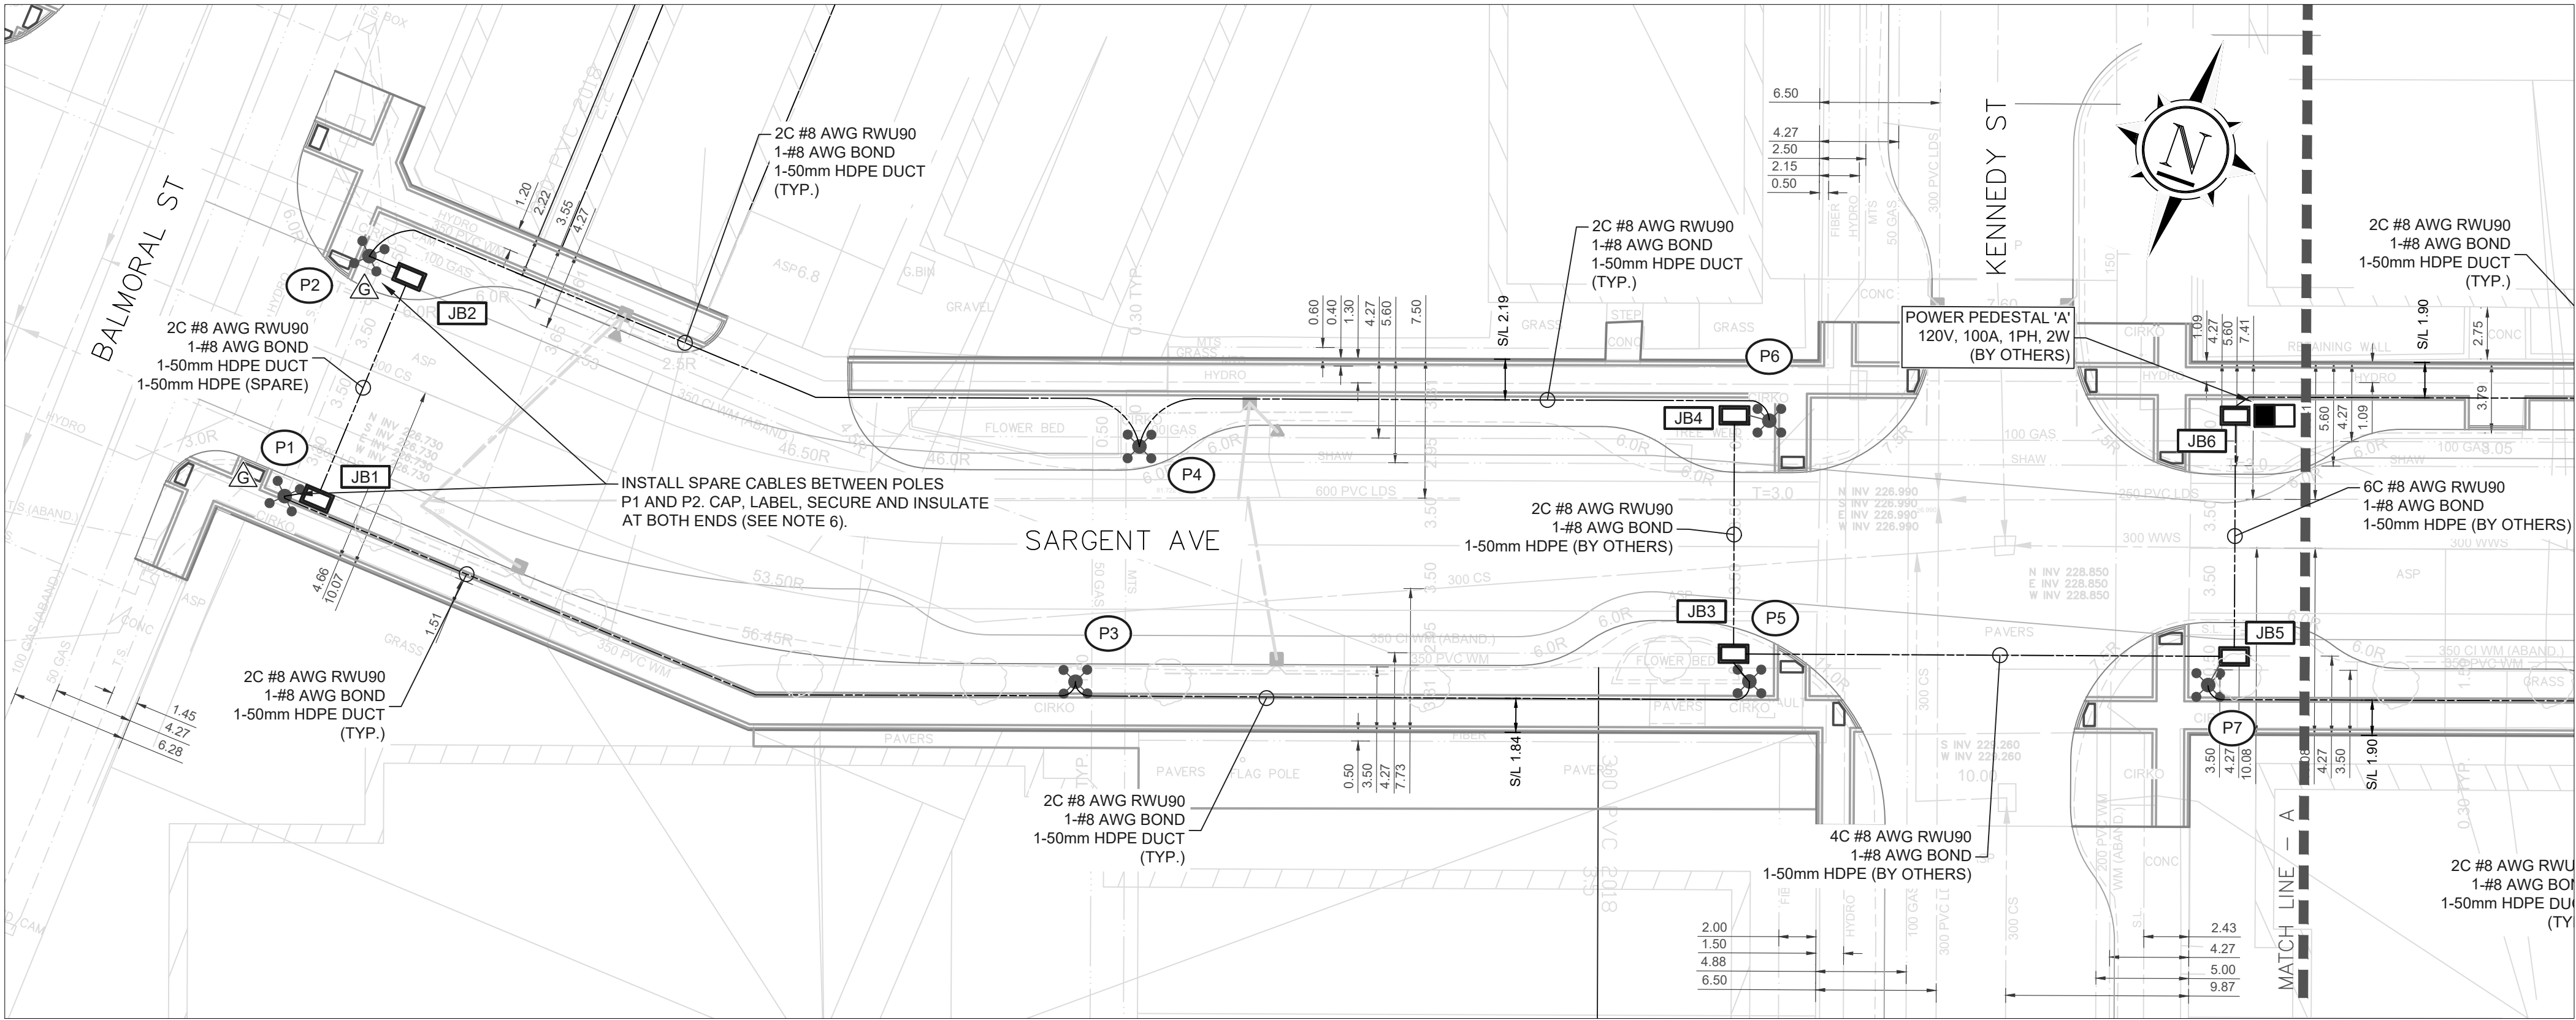

AREA: SARGENT AVE
WINNIPEG, MB

LEGEND — STREETLIGHTING:

- STREETLIGHT POWER DISTRIBUTION PANEL
- SIGNALS AND S/L POWER PEDESTAL (BY OTHERS)
- STREETLIGHT JUNCTION BOX/PULL BOX
- STREETLIGHT DUCT
- BASE MOUNTED 15FT POLE C/W PEDESTRIAN LUMINAIRE
- GROUND ROD/PLATE

GENERAL NOTES:

- VERIFY LOCATIONS OF UTILITIES AND PROTECT AGAINST DAMAGE DURING CONSTRUCTION.
- COORDINATE POLE FOOTING AND POWER LOCATIONS WITH CIVIL AND LANDSCAPE DRAWINGS.
- CONDUIT TRENCH LINE IS SHOWN FOR APPROXIMATE ROUTING. CONTRACTOR SHALL CONFIRM AND COORDINATE ROUTING OF CONDUIT WITH SITE CONDITIONS.
- WHERE CONDUITS ARE ROUTED UNDER ROADWAYS, COORDINATE DEPTH OF BURIAL WITH CITY OF WINNIPEG REQUIREMENTS AND UTILITY CROSSINGS.
- SOME ELECTRICAL SYMBOLS ARE ENLARGED FOR CLARITY AND DO NOT REPRESENT THEIR ACTUAL SIZE.
- SPARE LOOP FEED CONDUCTORS SHALL REMAIN NORMALLY OPEN AND BE INSULATED, CAPPED AND CLEARLY LABELED AT ALL ACCESS POINTS. ANY RECONNECTION SHALL BE PERFORMED BY QUALIFIED PERSONNEL AFTER CONFIRMING CIRCUITS ARE DE-ENERGIZED. THE SYSTEM SHALL NOT BE ENERGIZED IN A CLOSED-LOOP CONFIGURATION.
- POWER PEDESTAL 'A' AND PULL PITS JB3, JB4, JB5, JB6 WILL BE DONE BY OTHERS. SPARE CONDUITS WILL BE PROVIDED BY OTHERS BETWEEN THESE PITS FOR CABLE INSTALLATION.

ClickBefore
YouDigMB.com

PRELIMINARY

NO.	DATE	REVISIONS	BY
0	2026-05-13	ISSUED FOR TENDER	W.H.

PREPARED FOR: PREPARED BY:



DESCRIPTION: STREET LIGHTING LAYOUT

LOCATION: SARGENT AVE
WINNIPEG, MB

DESIGNED BY: W.H.	DATE: 2026-05-13
DRAWN BY: M.M.	SIZE: ISO_A1
CONTRACTOR'S REFERENCE NO.: 0020782	SCALE: 1:250
CLIENT'S PROJECT NO.	PLAN: 1 OF 2