


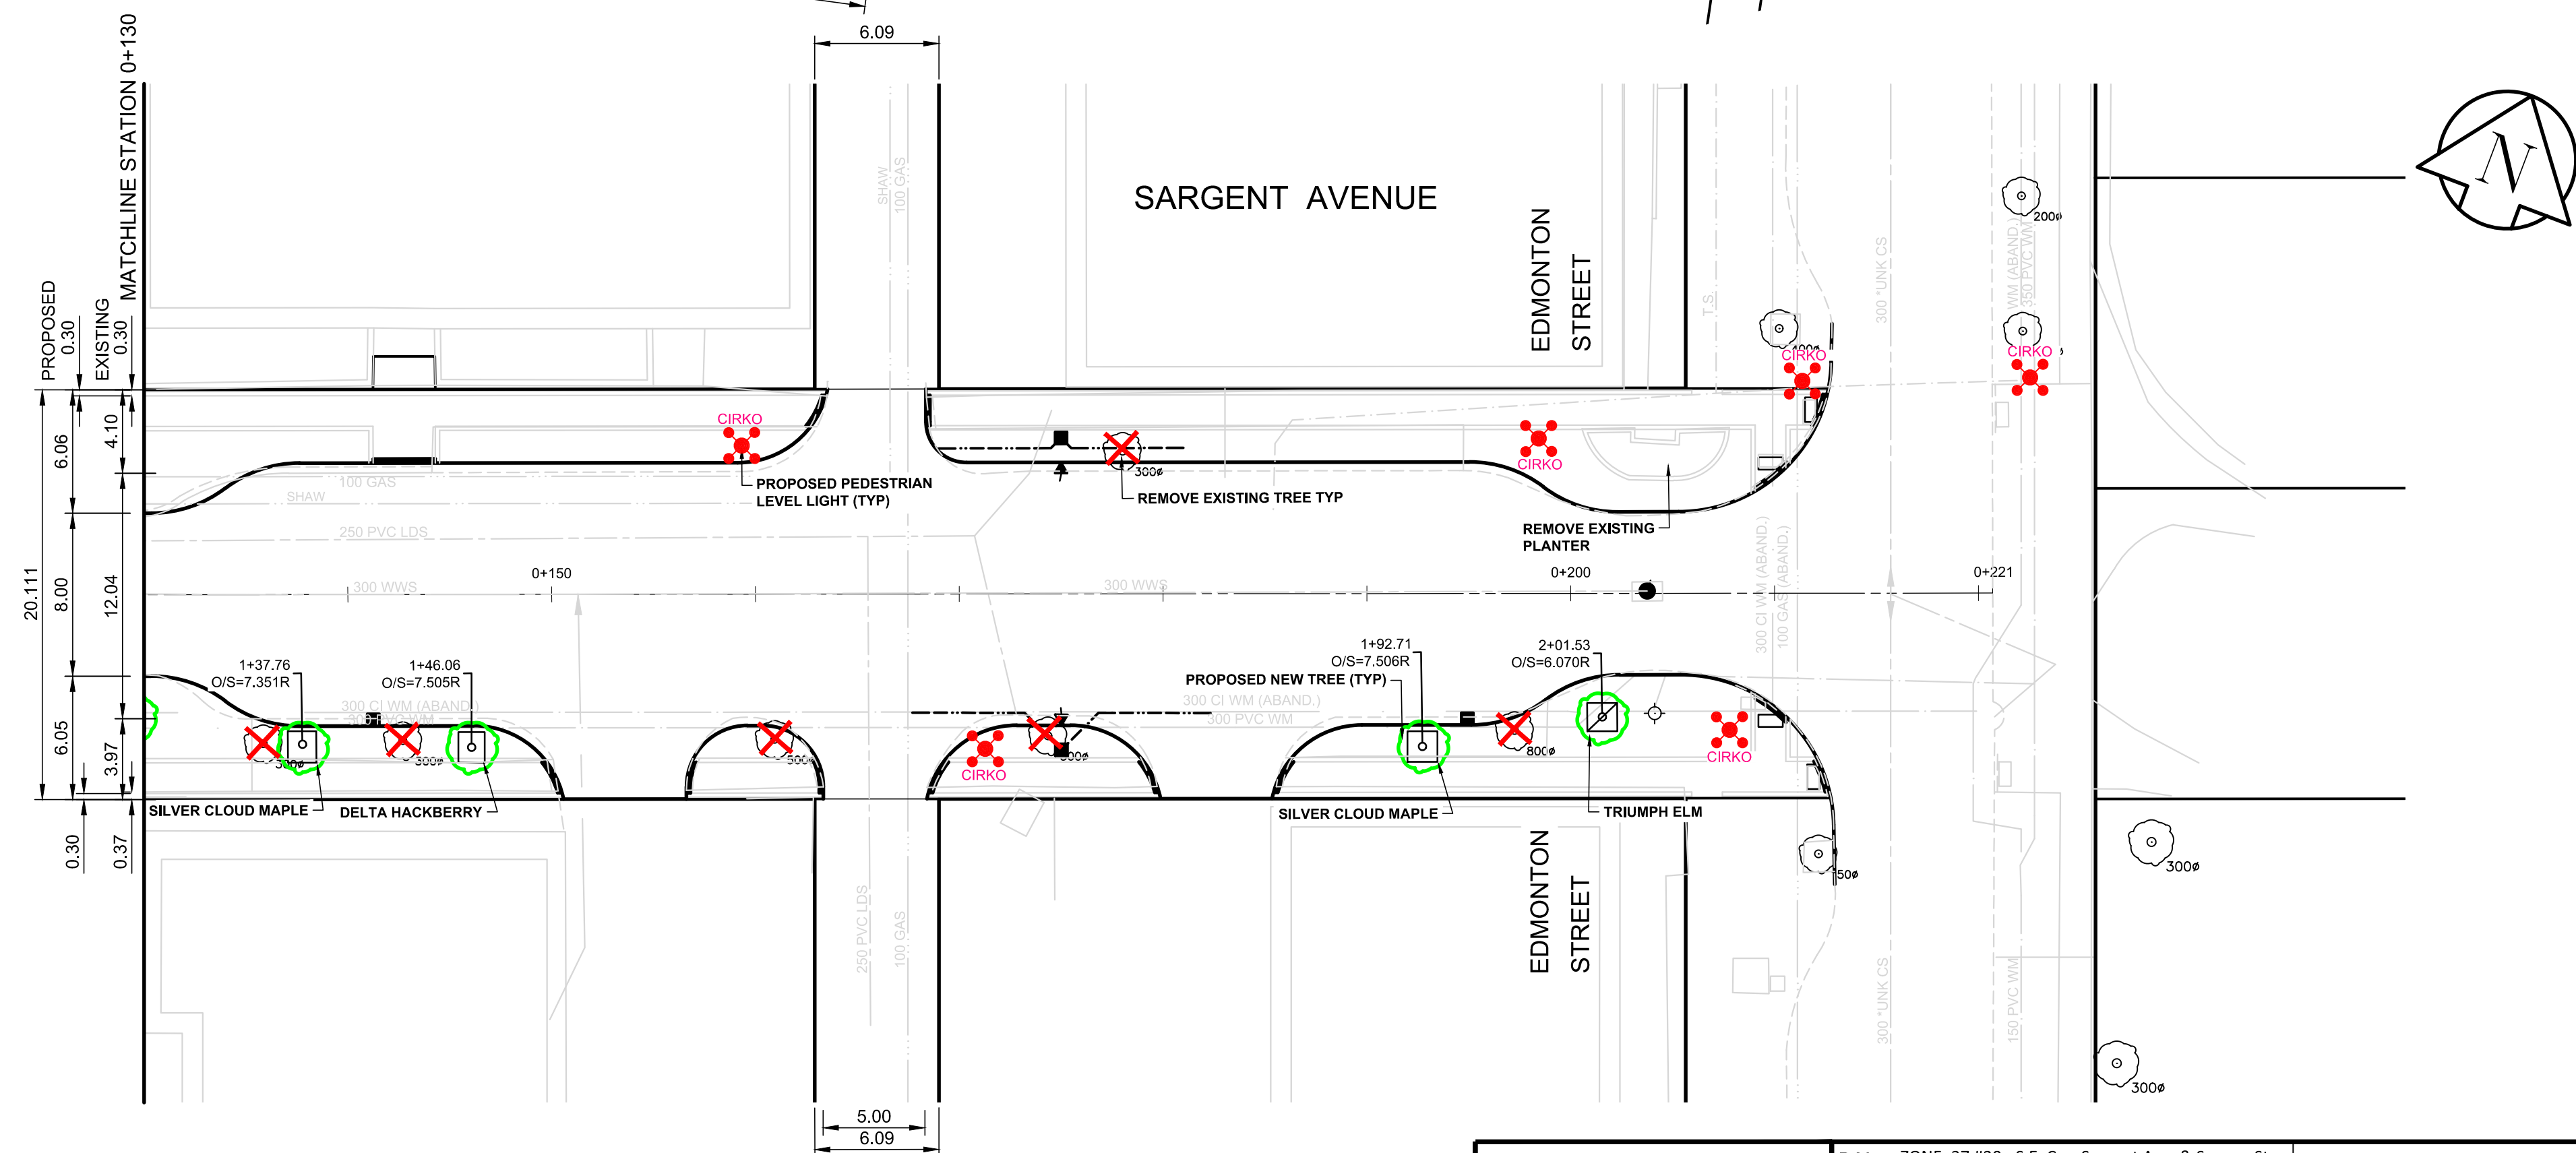

1. NEW TREES TO BE INSTALLED BY CITY OF WINNIPEG URBAN FORESTRY BRANCH, CONTRACTOR TO COORDINATE INSTALLATION TIMELINE
2. PEDESTRIAN LEVEL LIGHTING LAYOUT PROVIDED IS PRELIMINARY

METRIC
WHOLE NUMBERS INDICATE MILLIMETRES
DECIMALIZED NUMBERS INDICATE METRES

2026 REGIONAL STREET RENEWAL PROGRAM	CITY DRAWING NUMBER P-3603-11	
	SHEET 11	OF 13
SARGENT AVENUE - BALMORAL STREET TO EDMONTON STREET CONCRETE PAVEMENT RECONSTRUCTION PROPOSED TREE LAYOUT AND STREETSCAPING PLAN		