


EDMONTON ST

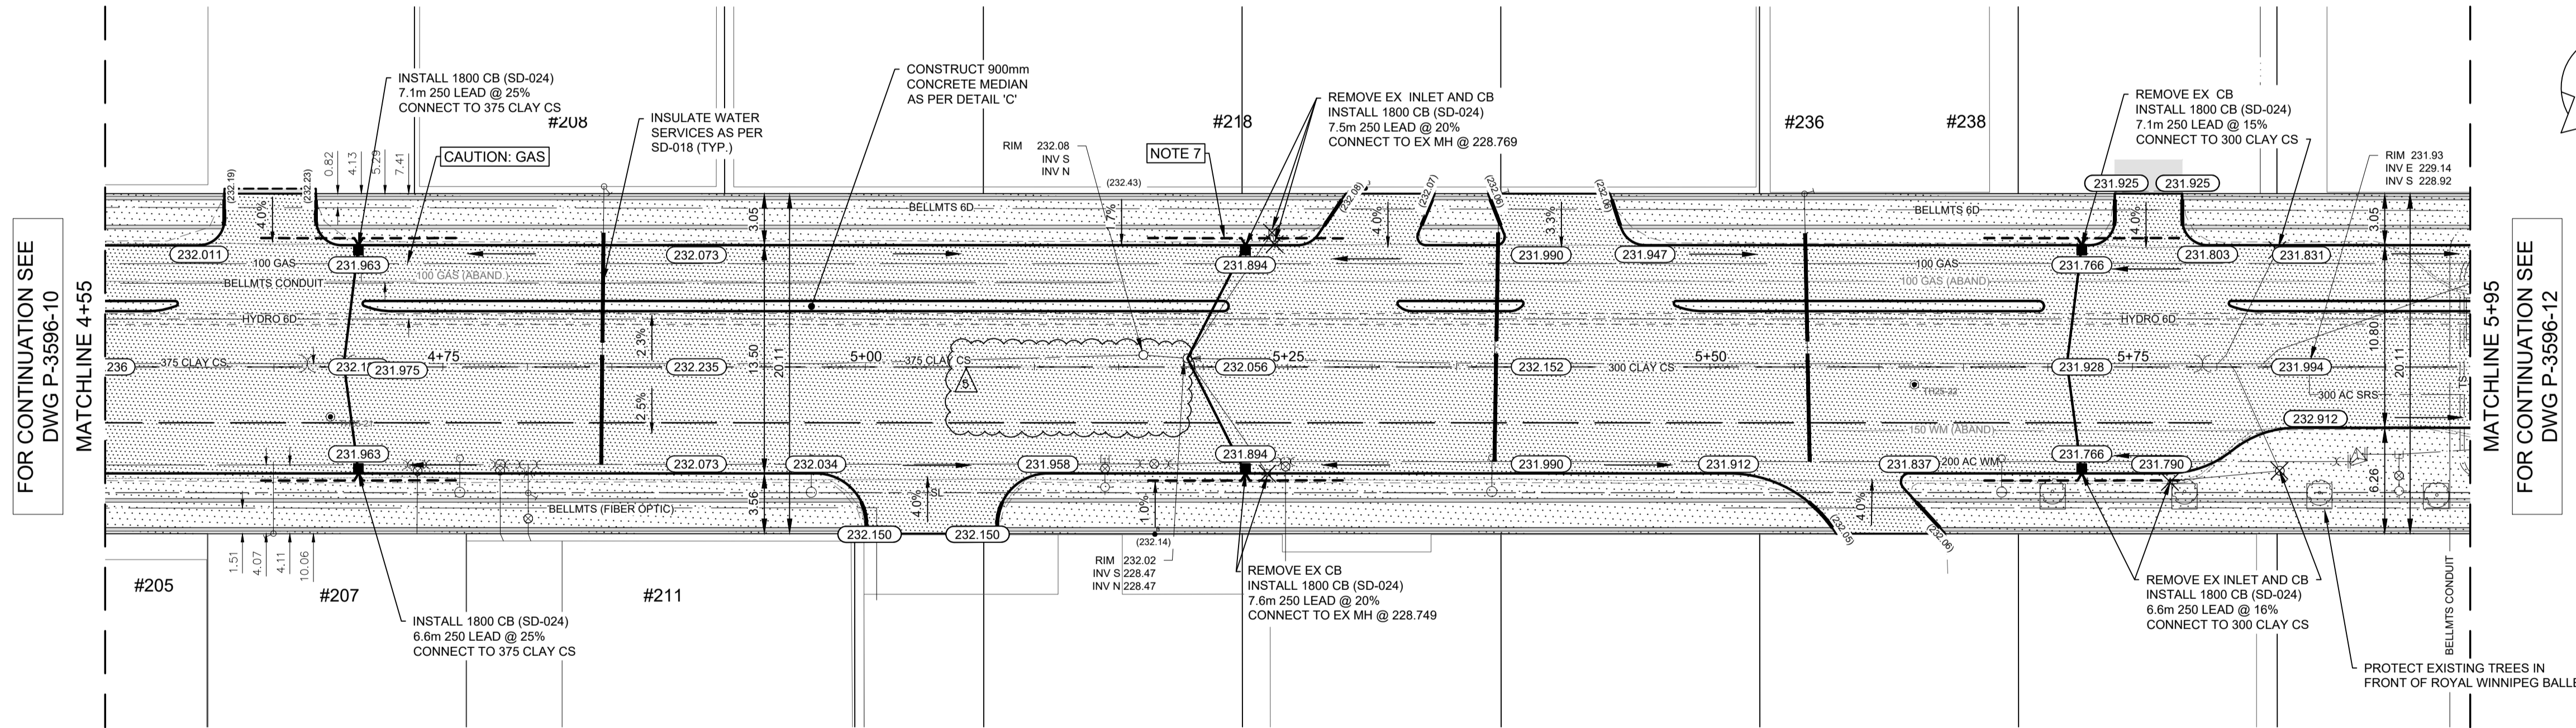

- NOTES:**
- ALL WORK AND MATERIALS TO BE IN ACCORDANCE WITH THE LATEST REVISION OF THE CITY OF WINNIPEG STANDARD CONSTRUCTION SPECIFICATIONS.
 - CONTRACTOR TO CONFIRM THE LOCATION OF ALL UTILITIES/SERVICES IN THE FIELD PRIOR TO CONSTRUCTION.
 - ALL ROADWAY DIMENSIONS SHOWN ARE TO BACK OF CURB.
 - MODIFIED BARRIER CURB TO BE CONSTRUCTED AT ALL INTERSECTION RADII AND ALLEY RADII.
 - RENEW CURB AND SIDEWALK AS IDENTIFIED BY CONTRACT ADMINISTRATOR.
 - CONSTRUCT 200 REINFORCED CONCRETE APPROACHES WITH 75mm GRANULAR BASE COURSE, 300mm - 50mm GRANULAR A SUB-BASE AND SEPARATION/FILTRATION GEOTEXTILE.
 - INSTALL 6.0m SUBDRAINS IN EACH DIRECTION AT ALL CATCH BASIN INSTALLATIONS AS PER CW-3120.
 - CONTRACTORS TO TAKE PRECAUTIONARY STEPS TO PROTECT EXISTING TREES WITHIN THE LIMITS OF CONSTRUCTION FROM DAMAGE FROM CONSTRUCTION ACTIVITIES AS OUTLINED IN THE SPECIFICATIONS.
 - LAMP STANDARDS, HYDRO POLES, AND ANCHORS THAT REQUIRE TEMPORARY SUPPORT, REMOVAL OR REPLACEMENT, TO BE DONE SO AT THE EXPENSE OF THE CONTRACTOR AS NECESSARY.
 - ADJUST ALL WATER VALVES, HYDRANTS, MANHOLES, AND CATCH BASINS IN WORK AREA TO GRADE.
 - SEE STREETSCAPING SHEETS FOR STREETSCAPING PLANS.
 - SEE ELECTRICAL SHEETS FOR ROADWAY AND SIDEWALK LIGHTING PLANS.

METRIC
WHOLE NUMBERS INDICATE MILLIMETRES
DECIMALIZED NUMBERS INDICATE METRES

ENGINEERS GEOSCIENTISTS MANITOBA
Certificate of Authorization
WSP Canada Inc.
No. 5750

FOR TENDER PURPOSES ONLY
NOT FOR CONSTRUCTION

EXISTING	LEGEND-PLAN	PROPOSED	EXISTING	LEGEND-PLAN	PROPOSED	EXISTING	LEGEND-PLAN	PROPOSED
---	WATER MAIN	---	⊕	VALVE	⊕	---	EDGE OF SIDEWALK	---
---	LAND DRAINAGE SEWER	---	⊕	CURB STOP	⊕	---	EDGE OF ASPHALT	---
---	WASTE WATER SEWER	---	⊕	HYDRO POLE & LIGHT STANDARD	⊕	---	EDGE OF CONCRETE	---
---	HYDRO	---	⊕	LIGHT STANDARD OR TRAFFIC SIGNAL	⊕	---	MODIFIED BARRIER CURB	---
---	GAS	---	⊕	HYDRO POLE / ANCHOR	⊕	---	BARRIER CURB	---
---	COMMUNICATIONS	---	⊕	FENCE	⊕	---	BARRIER CURB AND GUTTER	---
---	SIGNALS	---	⊕	PROPERTY LINE	⊕	---	PAVING STONE	---
○	MANHOLE	●	⊕	TEST HOLE / PAVEMENT CORE	⊕	---	CONCRETE SIDEWALK	---
□	CATCH BASIN/CATCH PIT	■	⊕	ELEVATIONS	(231.000)	---	CONCRETE SLAB	---
△	CURB INLET	▽	⊕	CURB RAMP	⊕	---	ASPHALT	---
◇	UTILITIES ADJUSTED	◇	⊕	DETECTABLE WARNING SURFACE TILE	⊕	---	MILLED SURFACE	---
◇	HYDRANT	◆	⊕			---	PAVEMENT REPAIR FABRIC	---

LOCATIONS APPROVED UNDERGROUND STRUCTURES

SIGNED BY: _____ DATE: _____

SUPV U/G STRUCTURES: _____ DATE: _____

LOCATION OF UNDERGROUND STRUCTURES AS SHOWN ARE BASED ON THE BEST INFORMATION AVAILABLE BUT NO GUARANTEE IS GIVEN THAT ALL EXISTING UTILITIES ARE SHOWN OR THAT THE GIVEN LOCATIONS ARE EXACT CONFIRMATION OF EXISTENCE AND EXACT LOCATION OF ALL SERVICES. MUST BE OBTAINED FROM THE INDIVIDUAL UTILITIES BEFORE PROCEEDING.

NO.	REVISIONS	DATE	BY
1	ADDENDUM 5	20260309	M.V.
0	ISSUED FOR TENDER	20260206	S.S.

G.S.M. TO#8 @ NE CORNER BROADWAY AND EDMONTON ST
ELEV. 233.374

wsp

DESIGNED BY: M.V.
CHECKED BY: S.S.

DRAWN BY: K.C.W.D.
APPROVED BY: S.S.

HOR. SCALE: 1:250
VERTICAL: 1:10

RELEASED FOR CONSTRUCTION

DATE: APRIL 2025

WSP Canada Inc.
1600 Buffalo Place
Winnipeg, MB R3T 6B8
T. 204.477.6650
F. 204.474.2864
www.wsp.com

THE CITY OF WINNIPEG
PUBLIC WORKS DEPARTMENT
ENGINEERING SERVICES DIVISION

2026 DOWNTOWN STREET RENEWALS
EDMONTON STREET
CONCRETE RECONSTRUCTION
STA. 4+55 TO STA. 5+95

CITY DRAWING NUMBER: P-3596-11
SHEET 11 OF 36
TENDER NO. 3-2026

CONSULTANT ACAD DWG. NO. CA0051531.7175-11

Mar 06, 2026 - 11:40am L:\Projects\202502 - Transportation\CA0051531.7175 - Downtown Street Renewals\74-2024\A02 Drawings\03_Work_Dwg\CA0051531.7175_Edmonton_S_Plan_Profile.dwg - Job P-3596-11