



THE CITY OF WINNIPEG

WATER AND WASTE DEPARTMENT

WEWPCC FEEDER CABLE REPLACEMENT 2026



DRAWING INDEX

ELECTRICAL

1-0103-ESLD-ED03-002	WEWPCC ELECTRICAL AREA L - GENERAL SINGLE LINE DIAGRAM - DEMOLITION
1-0103-ESLD-E003-002	WEWPCC ELECTRICAL AREA L - GENERAL SINGLE LINE DIAGRAM
1-0103-EDTL-Y001-001	WEWPCC POLE MOUNTED EQUIPMENT INSTALLATION DETAILS
1-0103-EGAD-YD01-001	WEWPCC ELECTRICAL SITE PLAN - DEMOLITION
1-0103-EGAD-Y001-001	WEWPCC ELECTRICAL SITE PLAN
1-0103-EGAD-YD02-001	WEWPCC SITE LIGHTING AND POWER PLAN - DEMOLITION
1-0103-EGAD-Y002-001	WEWPCC SITE LIGHTING AND POWER PLAN

STRUCTURAL

1-0103-CLSC-YD01-001	WEWPCC SITE GRADING MODIFICATIONS - DEMOLITION
1-0103-CLSC-Y001-001	WEWPCC SITE GRADING MODIFICATIONS
1-0103-SFDW-Y001-001	WEWPCC CONCRETE PAD DETAIL
1-0103-SFNC-Y001-001	WEWPCC FENCE MODIFICATIONS DETAIL

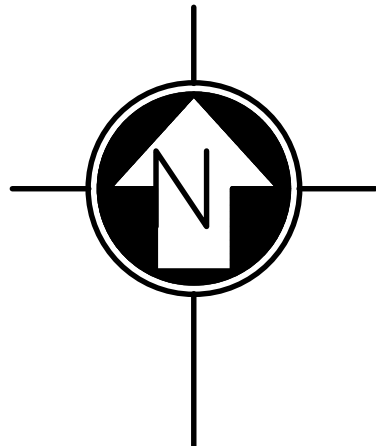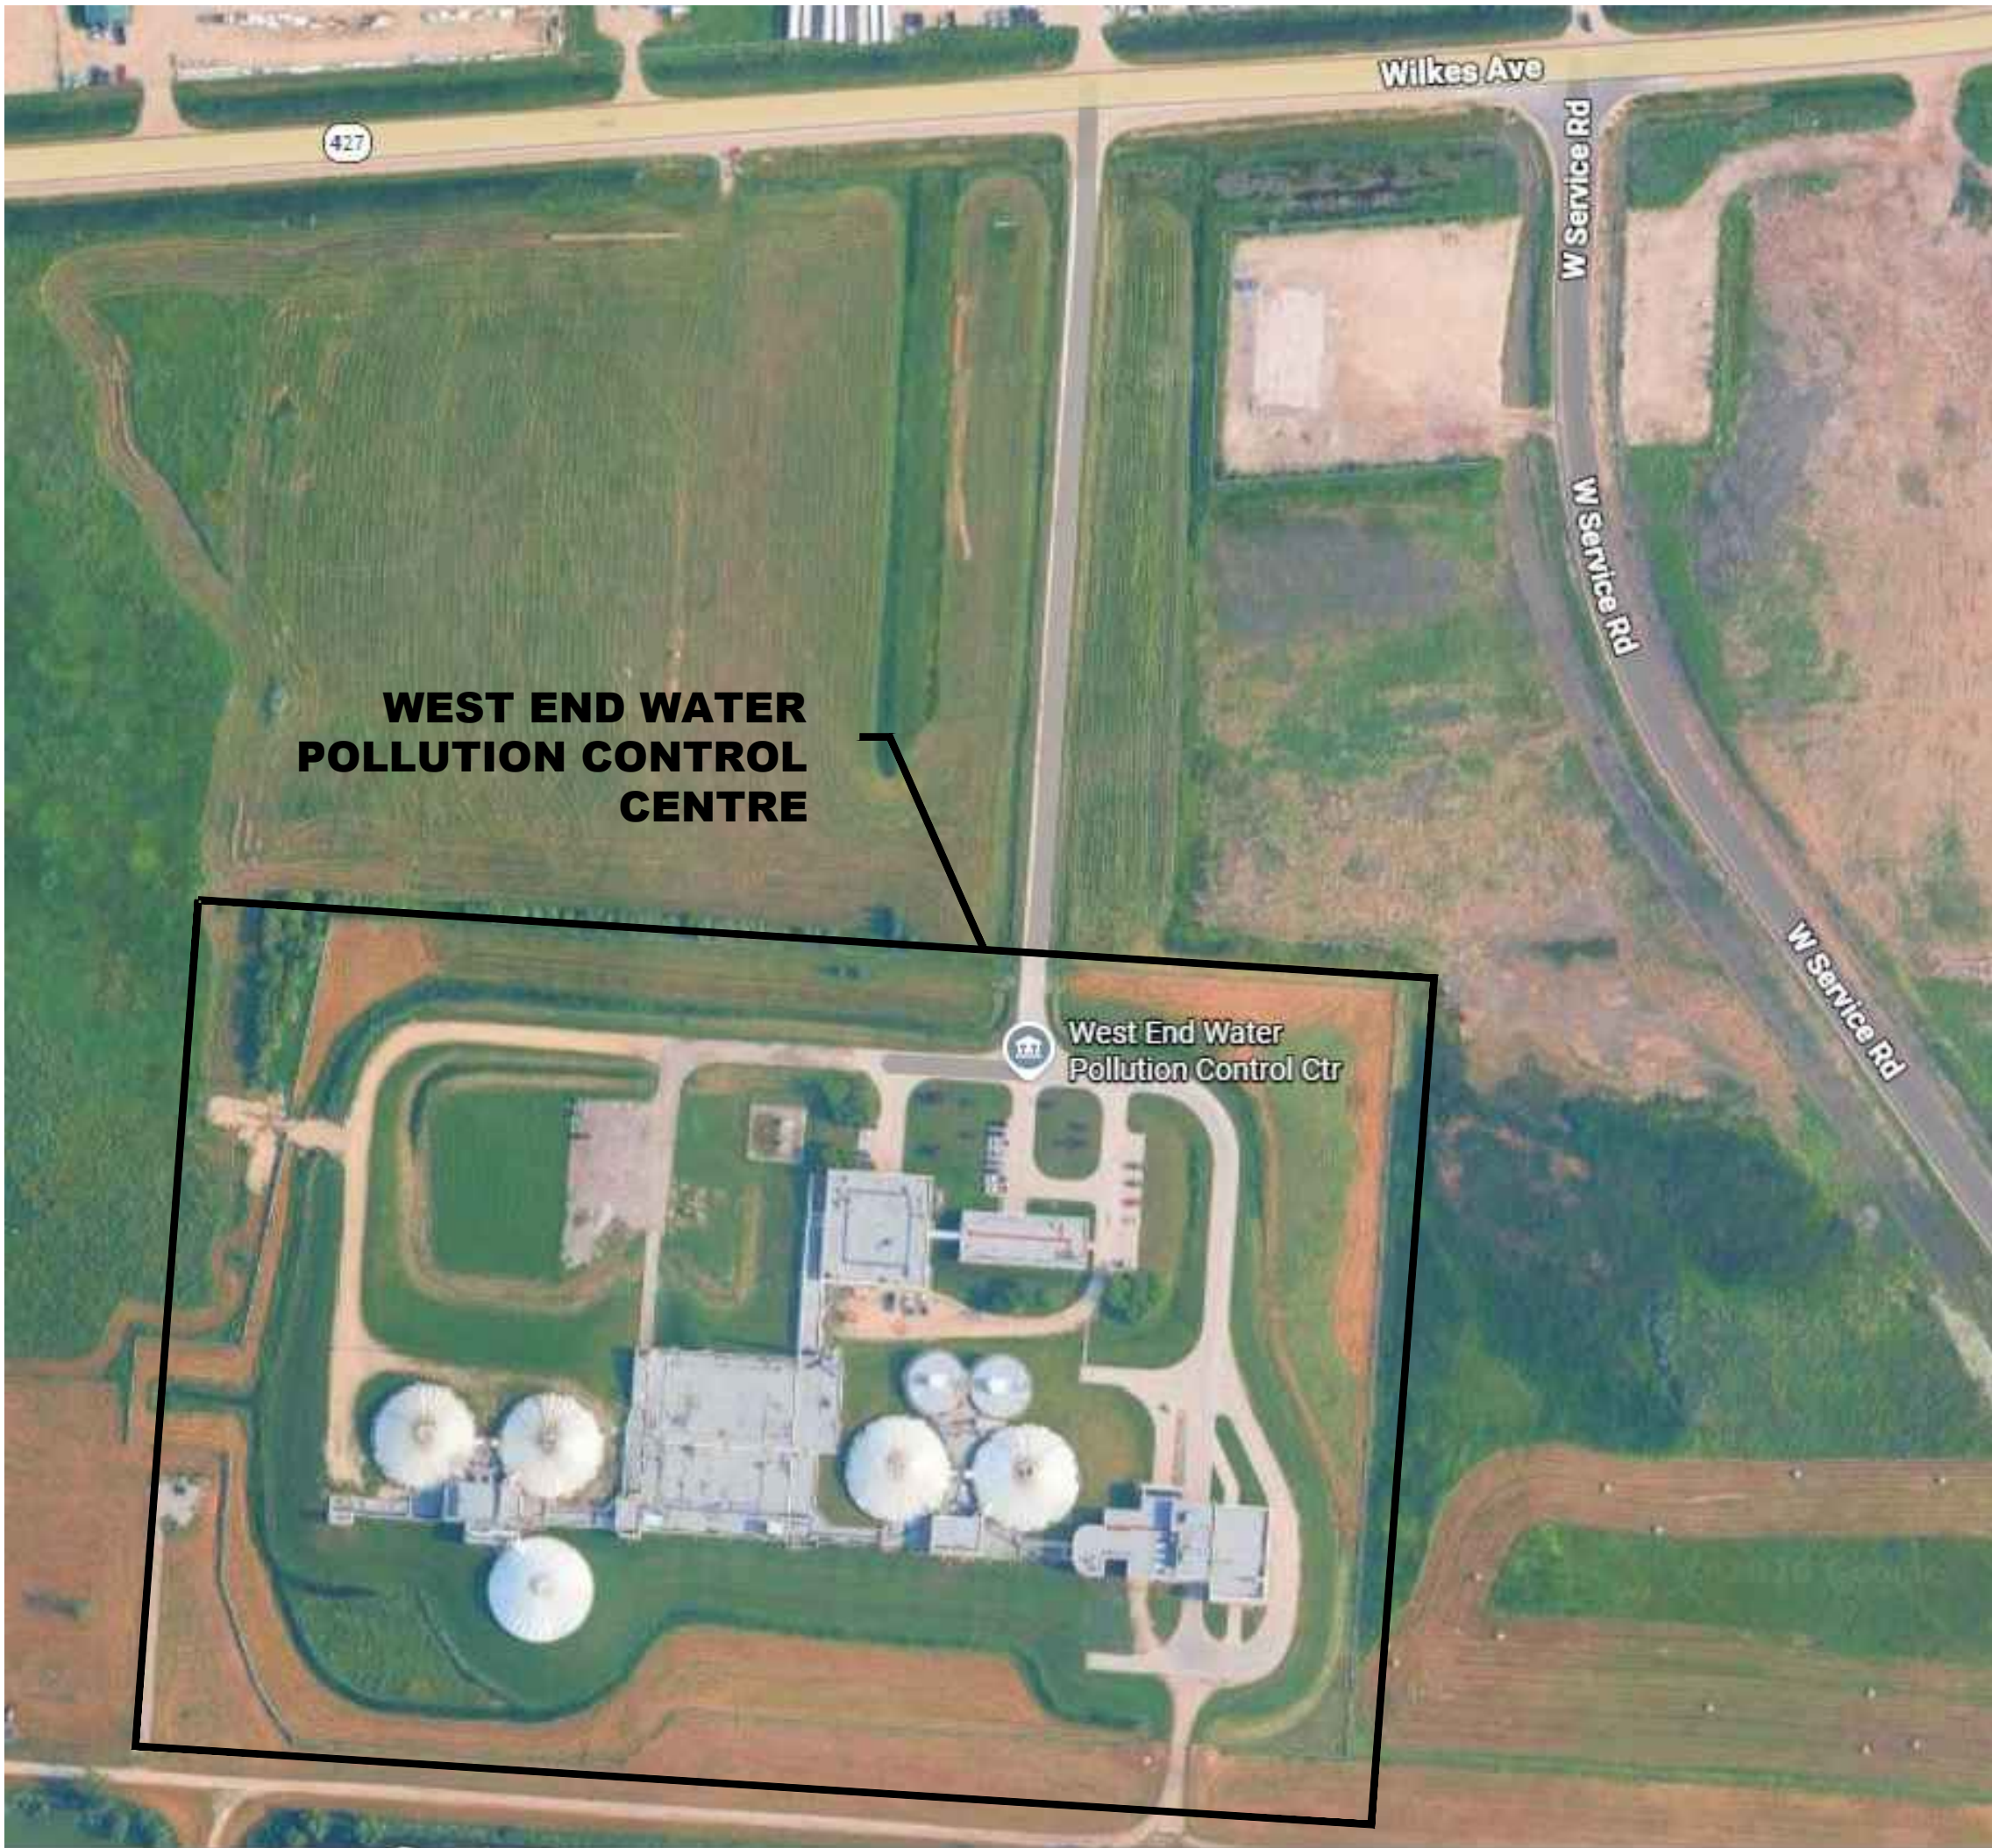

2026-04-14			
CITY DRAWING NUMBER	SHEET	REV.	SIZE
1-0103-DLIS-A001	001	00	A1