


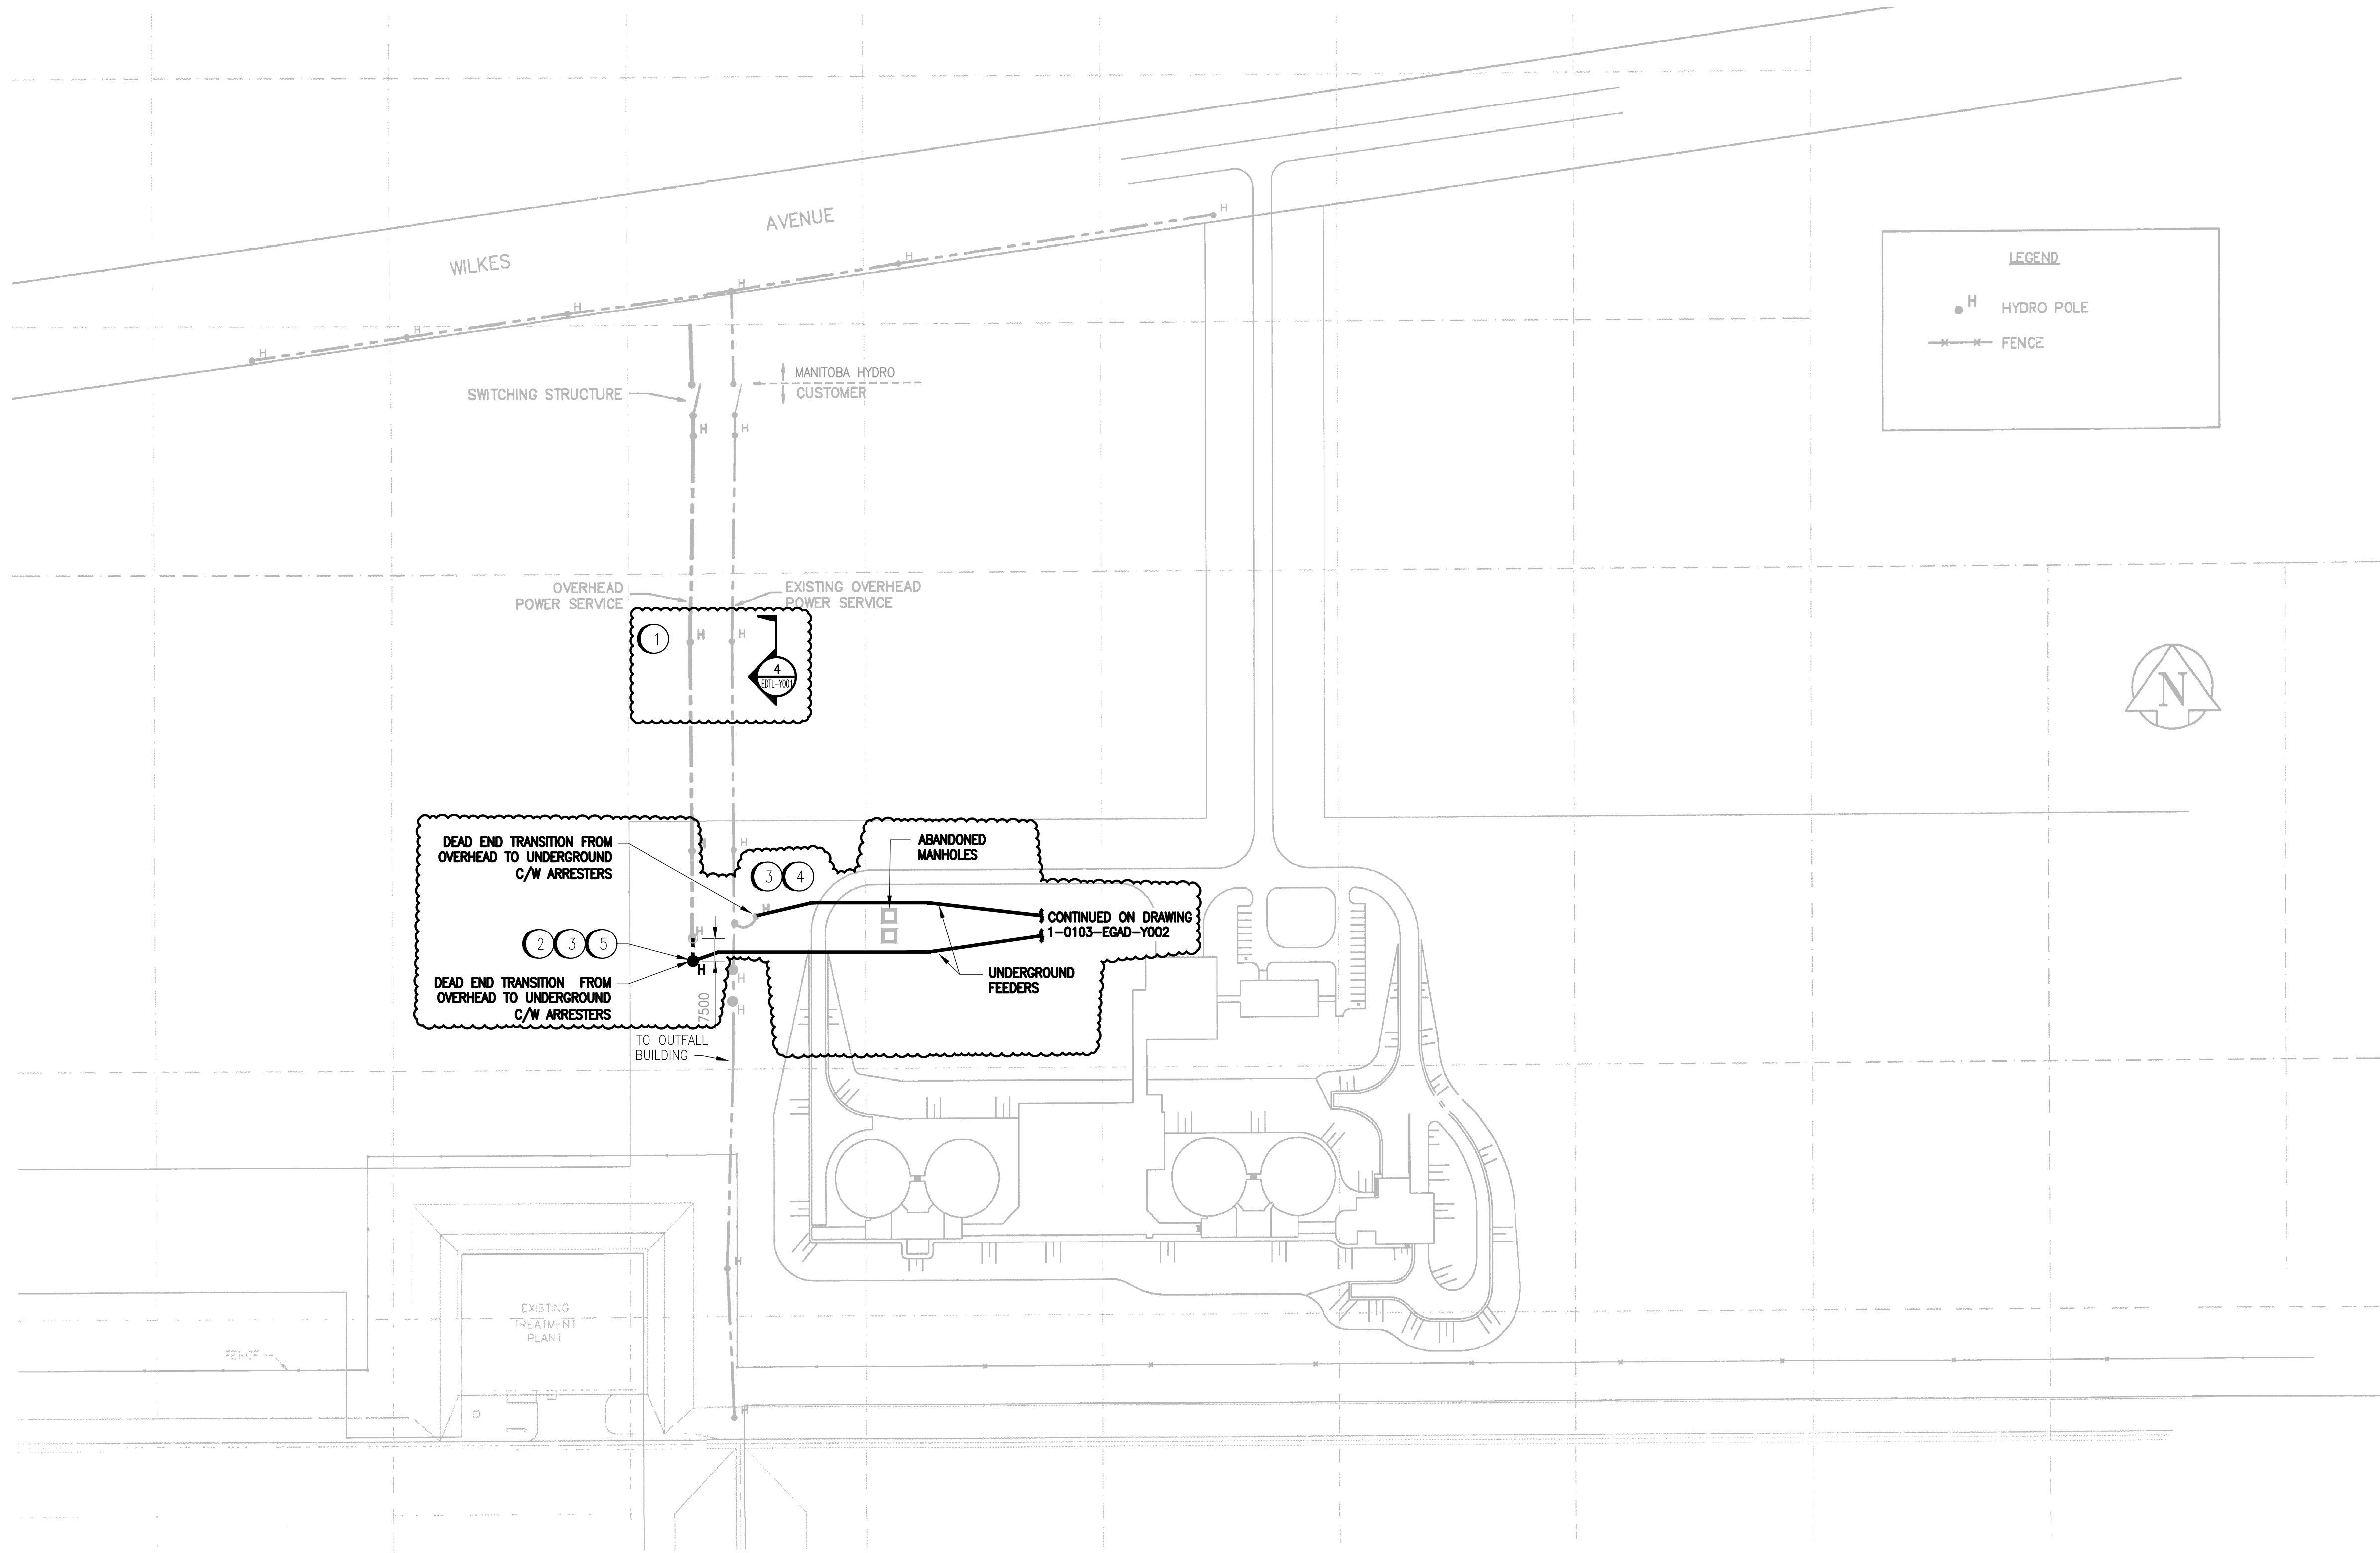

GENERAL NOTES:

1. CLOUDED PORTION OF THIS DRAWING INDICATES WORK TO BE COMPLETED. REFER TO CONSTRUCTION NOTES.
2. EXISTING CONDITIONS SHOWN ARE BASED ON RECORD DRAWINGS AND INFORMATION PROVIDED BY CITY OF WINNIPEG. INFORMATION IS FOR REFERENCE ONLY AND MAY NOT BE COMPLETE OR ACCURATE. CONTRACTOR SHALL VERIFY ALL DIMENSIONS, RATINGS, AND EXISTING CONDITIONS PRIOR TO TENDER AND MAKE ALLOWANCES AS REQUIRED.
3. REFER TO DRAWING 1-0103-EDTL-Y001 FOR POLE MOUNTED EQUIPMENT DETAILS.
4. REFER TO DRAWING 1-0103A-E0003-002-03 FOR SINGLE LINE DIAGRAM.

CONSTRUCTION NOTES:

- 1 BYPASS EXISTING GANG OPERATED SWITCHES. REFER TO DETAIL 4 IN DRAWING 1-0103-EDTL-Y001.
- 2 PROVIDE NEW 45FT WESTERN CEDAR POLE, MINIMUM CLASS 3 TYPE.
- 3 PROVIDE NEW GANG OPERATED SWITCHES AND FUSES. REFER TO DETAILS IN 1-0103-EDTL-Y001 FOR FURTHER REQUIREMENTS.
- 4 PROVIDE NEW 25KV UNDERGROUND FEEDER FROM POLE MOUNTED FUSES TO EXISTING 2500kVA TRANSFORMER ASSOCIATED WITH RANNOCK SUB STATION FEEDER, COMPLETE WITH 25KV TERMINATION KITS ON BOTH ENDS. REFER TO DETAIL 6 IN DRAWING 1-0103-EDTL-Y001 FOR TRENCH DETAILS.
- 5 PROVIDE NEW 25KV UNDERGROUND FEEDER FROM POLE MOUNTED FUSES TO EXISTING 2500kVA TRANSFORMER ASSOCIATED WITH HEADINGLEY SUB STATION FEEDER, COMPLETE WITH 25KV TERMINATION KITS ON BOTH ENDS. REFER TO DETAIL 6 IN DRAWING 1-0103-EDTL-Y001 FOR TRENCH DETAILS.



ENGINEERS  
GEOSCIENTISTS  
MANITOBA  
Certificate of Authorization  
AtkinsRéalis Canada Inc.  
No. 4489



148 Nature Park Way, Winnipeg, Manitoba  
Canada R3P 0X7 204-786-8080

|                                |                                                               |
|--------------------------------|---------------------------------------------------------------|
| DESIGNED BY:<br>A. ENTZ ARAUJO | CHECKED BY:<br>V. ELIMBAN                                     |
| DRAWN BY:<br>A. NADRES         | APPROVED BY:<br>V. ELIMBAN                                    |
| SCALE:<br>1:1250               | ISSUED FOR CONSTRUCTION<br>BY: B. SOLOWAY<br>DATE: 2026/05/01 |
| DATE:<br>2026/02/19            |                                                               |
| CONSULTANT NO.: 708186         |                                                               |

|     |                         |            |        |       |
|-----|-------------------------|------------|--------|-------|
| 00  | ISSUED FOR CONSTRUCTION | 2026/05/01 | AEA    | VE    |
| NO. | REVISIONS               | DATE       | DESIGN | CHECK |

ENGINEER'S SEAL



2026-05-04



THE CITY OF WINNIPEG  
WATER AND WASTE DEPARTMENT

WEST END WATER POLLUTION CONTROL CENTRE  
ELECTRICAL FEEDER CABLE REPLACEMENT & UPGRADES  
ELECTRICAL SITE PLAN

|                     |       |      |      |
|---------------------|-------|------|------|
| CITY DRAWING NUMBER | SHEET | REV. | SIZE |
| 1-0103-EGAD-Y001    | 001   | 00   | A1   |