


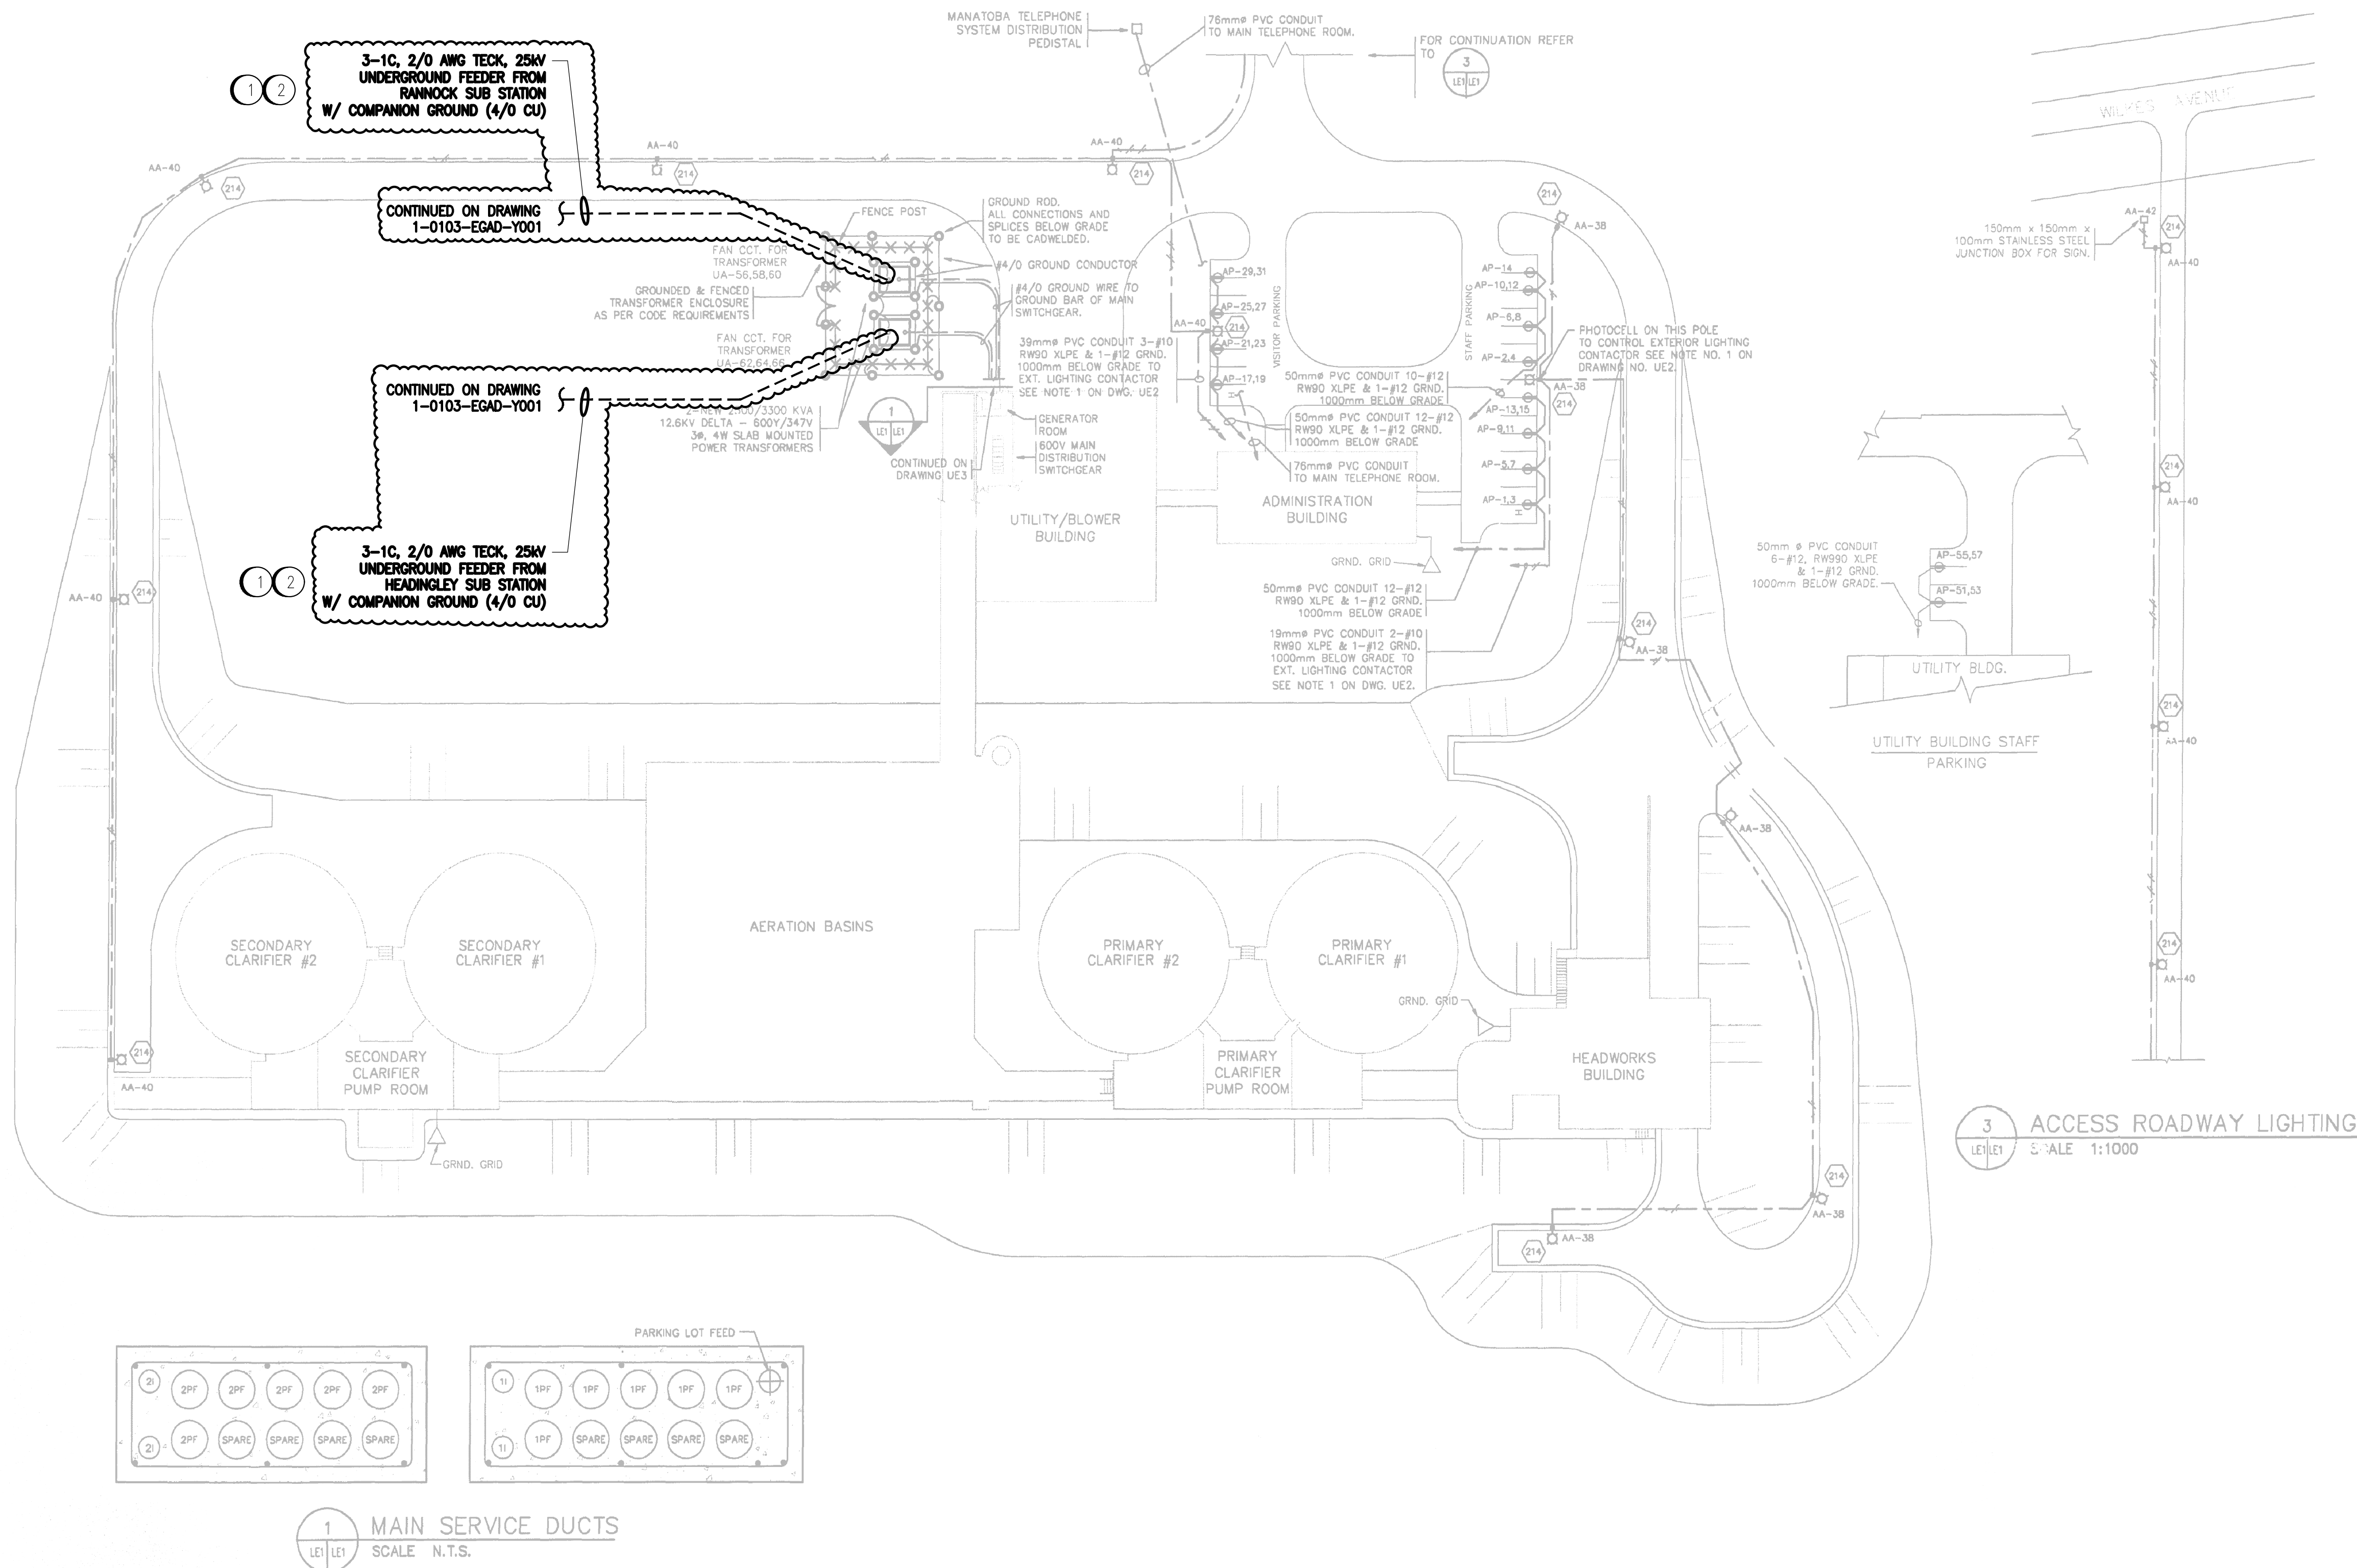

- GENERAL NOTES:
- CLOUED PORTION OF THIS DRAWING INDICATES WORK TO BE COMPLETED. REFER TO CONSTRUCTION NOTES.
 - EXISTING CONDITIONS SHOWN ARE BASED ON RECORD DRAWINGS AND INFORMATION PROVIDED BY CITY OF WINNIPEG. INFORMATION IS FOR REFERENCE ONLY AND MAY NOT BE COMPLETE OR ACCURATE. CONTRACTOR SHALL VERIFY ALL DIMENSIONS, RATINGS, AND EXISTING CONDITIONS PRIOR TO TENDER AND MAKE ALLOWANCES AS REQUIRED.

- CONSTRUCTION NOTES:
- PROVIDE NEW 25KV UNDERGROUND FEEDERS FROM TRANSFORMERS TO POLE MOUNTED FUSES. REFER TO DRAWING 1-0103-EGAD-Y001 FOR UPSTREAM POLE LOCATION. FEEDERS ROUTING SHALL ALLOW FOR MINIMUM 1M SLACK ON EACH FEEDER WITHIN 10M OF TRANSFORMERS. SERVICE LOOPS ARE NOT ACCEPTABLE.
 - TRANSITION CABLES UP AT TRANSFORMER CONCRETE PAD. PROVIDE STRUT SUPPORT AND PHYSICAL PROTECTION TO CABLES AS REQUIRED.

**ENGINEERS
GEOSCIENTISTS
MANITOBA**
Certificate of Authorization
AtkinsRéalis Canada Inc.
No. 4489

NO.	REVISIONS	DATE	DESIGN	CHECK
00	ISSUED FOR CONSTRUCTION	2026/05/01	AEA	VE

AtkinsRéalis
148 Nature Park Way, Winnipeg, Manitoba
Canada R3P 0X7 204-786-8080

DESIGNED BY: A. ENTZ ARAUJO
DRAWN BY: A. NADRES
SCALE: 1:500
DATE: 2026/02/23
CONSULTANT NO.: 708186

CHECKED BY: V. ELIMBAN
APPROVED BY: V. ELIMBAN
ISSUED FOR CONSTRUCTION
BY: B. SOLOWAY
DATE: 2026/05/01

ENGINEER'S SEAL
PROVINCE OF MANITOBA
A.L. ENTZ ARAUJO
Member
41796
2026-05-04

THE CITY OF WINNIPEG
WATER AND WASTE DEPARTMENT

WEST END WATER POLLUTION CONTROL CENTRE
ELECTRICAL FEEDER CABLE REPLACEMENT & UPGRADES
SITE LIGHTING AND POWER PLAN

CITY DRAWING NUMBER
1-0103-EGAD-Y002

SHEET
001

REV.
00

SIZE
A1