




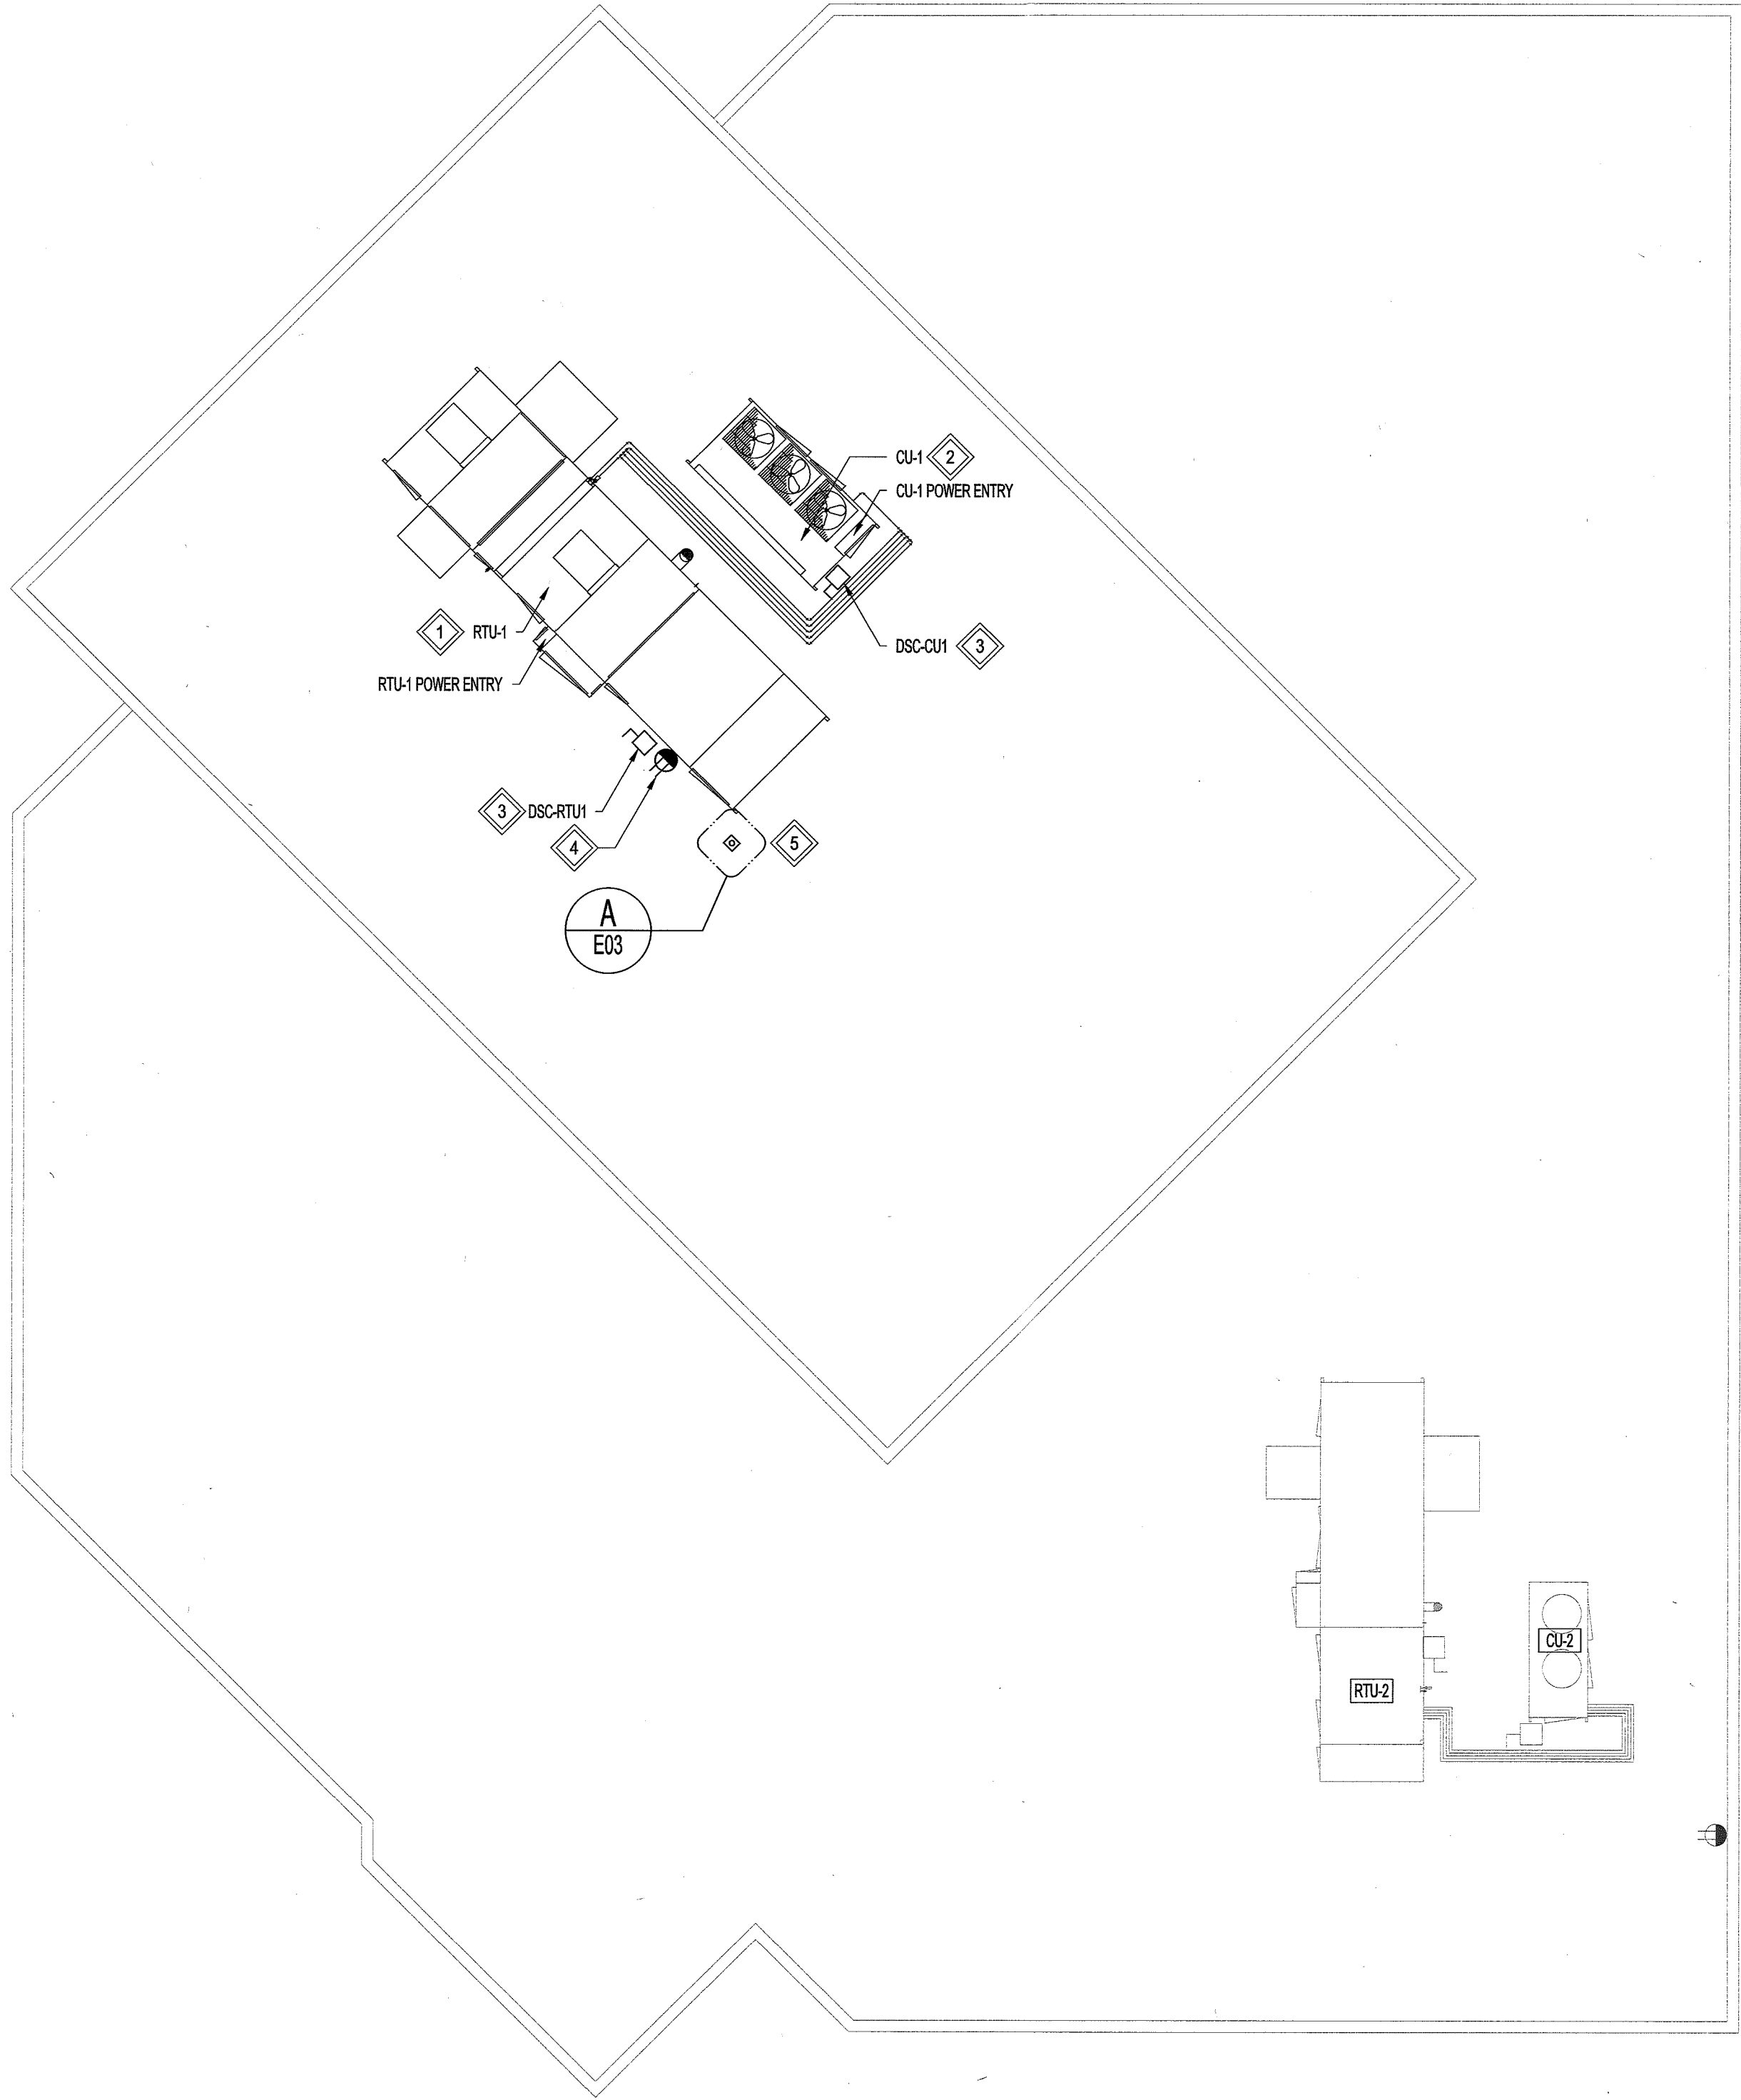

PARTIAL ROOF PLAN
SCALE: 1/8" = 1'

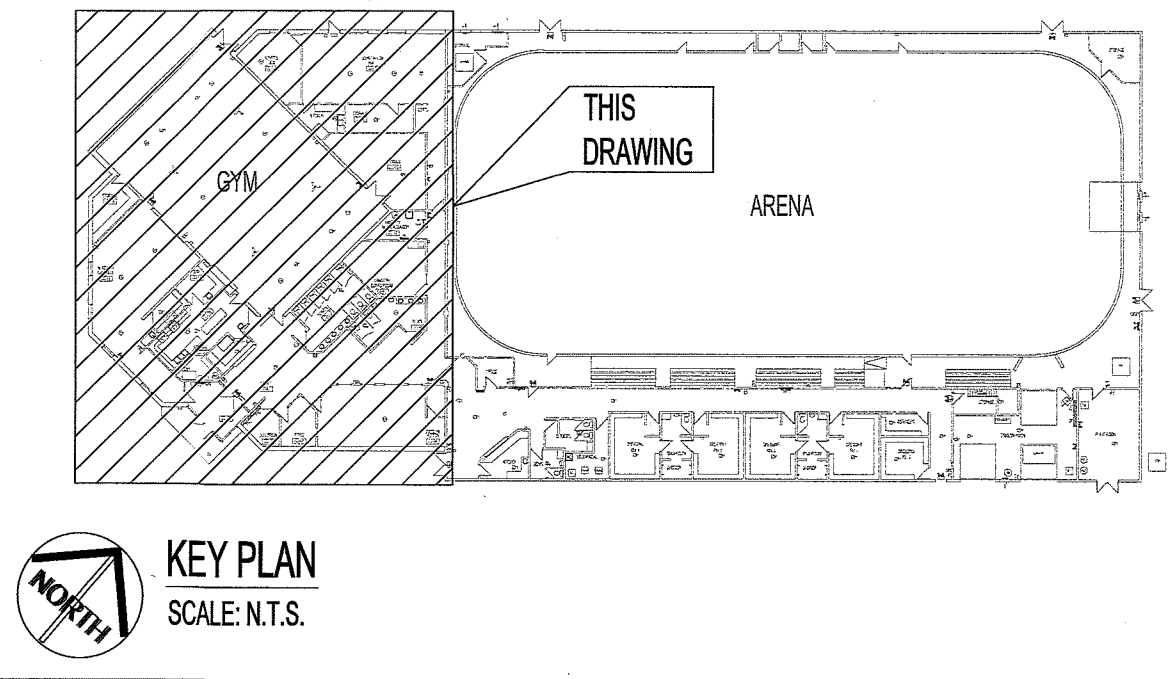

KEY PLAN
SCALE: N.T.S.

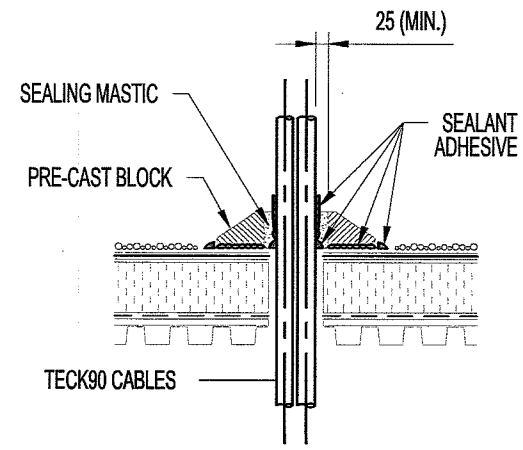

PITCH POCKET DETAIL
SCALE: N.T.S.

GENERAL NOTES:

- GREY ITEMS DENOTE EXISTING EQUIPMENT NOT INCLUDED WITHIN THE SCOPE OF WORK.
- THE CONTRACTOR SHALL COORDINATE EXACT LOCATIONS OF MECHANICAL EQUIPMENT WITH THE MECHANICAL DRAWINGS.

PITCH POCKET DETAIL NOTES:

- PITCH POCKET DETAIL IS APPLICABLE FOR ALL TYPE OF CABLE AND CABLE RUNS PENETRATIONS.
- RE-USE EXISTING HOLE OPENING IN THE ROOF BUT PROVIDE NEW SEAL AS PER PITCH POCKET DETAIL AND AS PER MANUFACTURER'S INSTRUCTIONS.
- CLEAN AND SCRAPE EXISTING ROOF SURFACE DOWN TO BARE FELTS.
- SEALANT AND ADHESIVE MUST EXCEED 25mm OVER PRE-CAST BLOCK.
- THE DISTANCE BETWEEN THE BLOCK INNER WALL AND PENETRATIONS MUST BE 25mm MINIMUM.

NOTES:

THESE DRAWINGS SHALL NOT BE SCALED.

THE CONTRACTOR SHALL VISIT THE SITE AND SATISFY ONESELF ALL DIMENSIONS, DATUM, AND DETAILED INFORMATION SHOWN ARE CORRECT.

THE CONTRACTOR IS TO REVIEW AND COORDINATE ALL ARCHITECTURAL, MECHANICAL, ELECTRICAL AND STRUCTURAL DRAWINGS FOR ADDITIONAL OPENINGS THROUGH FLOORS, WALLS, AND CEILINGS FOR DUCT, PIPE & ELECTRICAL RISERS AND ALL OPENINGS NOT SHOWN ON DRAWINGS.

ALL OPENINGS THROUGH THE FIRE SEPARATIONS AS A RESULT OF THE WORK OF THIS CONTRACT ARE TO BE FIRE STOPPED AND SEALED WITH U.L.C. APPROVED FIRE STOPPING TO MAINTAIN THE INTEGRITY OF THE FIRE SEPARATION, AND PROVIDE AND SMOKE-TIGHT BARRIER.

ALL PRODUCTS AND MATERIALS TO BE USED AND INSTALLED SHALL CONFORM WITH MANUFACTURER'S SPECIFICATIONS & APPLICABLE CODES.

THE CONTRACTOR SHALL BE RESPONSIBLE TO PATCH AND MAKE GOOD ALL EXISTING CONSTRUCTION AFFECTED BY THE REMOVAL OF ALL ITEMS FORMING THE PART OF THE RENOVATION WORK.

WHERE NEW FLOORING AND BASE IS TO BE INSTALLED IN EXISTING AREAS (REFER TO FLOOR PLAN AND ROOM SCHEDULE) THE EXISTING FLOORING SURFACE AND BASE MUST BE REMOVED, UNLESS OTHERWISE NOTED. ALL FLOOR SURFACES SHALL BE PREPARED IN ACCORDANCE TO MANUFACTURER'S RECOMMENDATIONS FOR INSTALLATION OF NEW FLOOR.

WHERE PAINTING OF EXISTING WALLS IS INDICATED ON THE ROOM SCHEDULE, THESE WALLS MUST BE CLEANED OF ANY EXISTING WALL COVERING, PATCHED & PREPARED TO ACCEPT NEW MATERIAL, UNLESS OTHERWISE NOTED.

KEYNOTES:

- WIRE AND CONNECT POWER WIRING TO THE NEW ROOF TOP AIR HANDLING UNIT (RTU-1).
- WIRE AND CONNECT POWER WIRING TO THE NEW ROOF TOP CONDENSER UNIT (CU-1).
- CONTRACTOR TO COORDINATE LOCATION OF THE DISCONNECT SWITCHES ON SITE.
- PROVIDE AND INSTALL A NEW WEATHERPROOF CLASS 'A' TYPE (5-20R) GFCI RECEPTACLE *dw* IN-USE COVER PLATE. RECEPTACLE MUST BE WITHIN 7.5 m OF HVAC EQUIPMENT, MORE THAN 750 mm ABOVE THE FINISHED ROOF ELEVATION, INSTALLED FACING DOWNWARD AT A 45° ANGLE, AND PROTECTED FROM MECHANICAL DAMAGE. CONTRACTOR TO COORDINATE THE FINAL LOCATION OF THE RECEPTACLE ON SITE.
- PITCH POCKETS SHOWN ON THE DRAWINGS ARE IN PROPOSED LOCATIONS ONLY. CONTRACTOR TO FINALIZE LOCATION OF THE PITCH POCKETS. CONTRACTOR TO ROUTE ALL CABLING THROUGH SHARED ROOF PENETRATION (e.g. RTU-1, CU-1, AND EQUIPMENT RECEPTACLE POWER).

LEGEND	
	LOCAL DISCONNECT SWITCH
	EQUIPMENT LOAD
	GROUND FAULT CIRCUIT INTERRUPT RECEPTACLE

No.	REVISION/DESCRIPTION	BY	DATE
0	ISSUED FOR CONSTRUCTION	CAL	28/04/22

SEAL

DRAWN	FA	CAL	CAL
DATE	28.03.26	CHECKED	DESIGNED
USER APPROVAL		APPROVED	

THE CITY OF WINNIPEG
PLANNING, PROPERTY AND
DEVELOPMENT DEPARTMENT
MUNICIPAL ACCOMMODATIONS DIVISION
3-65 GARRY STREET, R3C 4K4

PROJECT
AIR HANDLING UNIT REPLACEMENT
GLENWOOD COMMUNITY CENTRE
27 OVERTON ST.

SHEET
TITLE
ELECTRICAL
PARTIAL ROOF PLAN AND DETAILS

SCALE	PROJECT No:	SHEET No:
AS SHOWN	26-0107-005	E03

ENGINEERS
GEOSCIENTISTS
MANITOBA
Certificate of Authorization
KGS Group
No. 245

KGS
GROUP