


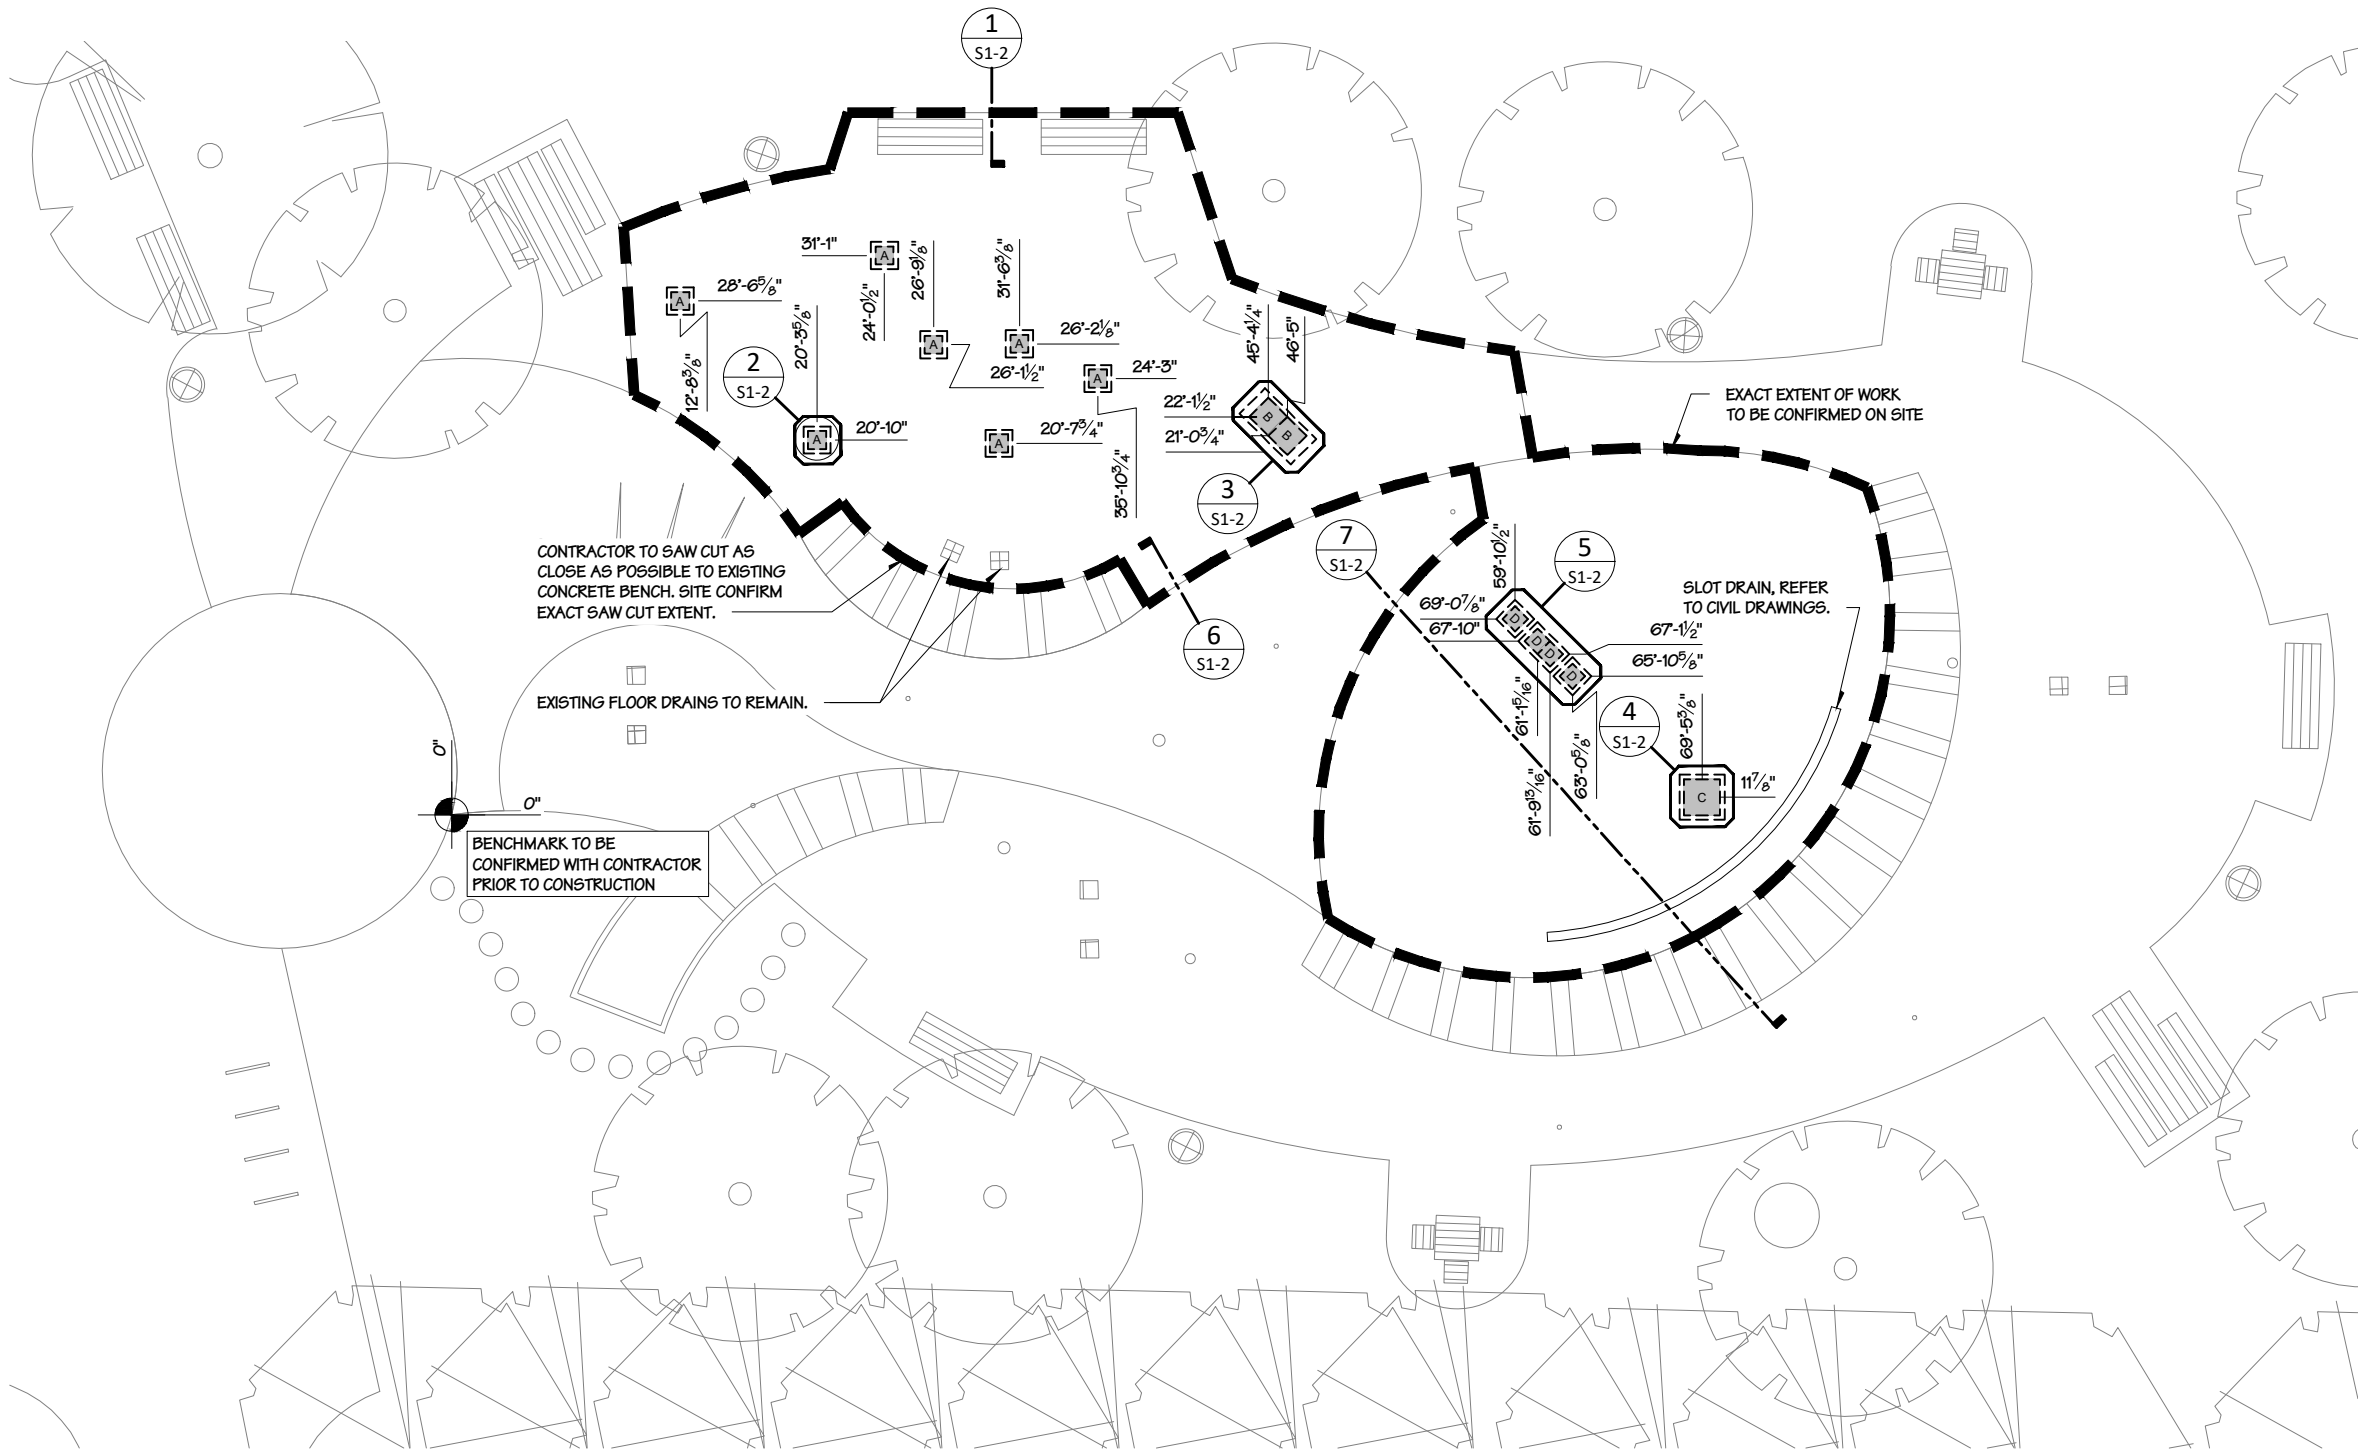

ERECTION PADS FOR EQUIPMENT MOUNTS SCHEDULE (#)

TYPE	SPECIFICATION	INFORMATION
A	12"x12"x4" BLOCK	2 S1-2
B	18"x18"x4" BLOCK SET	3 S1-2
C	24"x24"x4" BLOCK	4 S1-2
D	12"x12"x4" BLOCK SET	5 S1-2

NOTES:

1. FEATURE LAYOUT TO BE VERIFIED BY DWA SITEWORKS PRIOR TO CONSTRUCTION.
2. COORDINATES ARE TO CENTER OF PRECAST CONCRETE BLOCKS.
3. CONCRETE SLAB TO SLOPE AWAY FROM FEATURES TO DRAINS AS PER SUPPLIERS SPECIFICATIONS & LANDSCAPE PLAN. SITE VERIFY FEATURE ELEVATIONS PRIOR TO POURING SLAB.
4. REFER TO MECHANICAL PLANS FOR FEATURE LOCATIONS.

SPLASH PAD - PLAN VIEW


SCALE: 3/32" = 1'-0"

ENGINEERS
GEOSCIENTISTS
MANITOBA
Certificate of Authorization
DGH Engineering Ltd.
o/a Parsus Engineering
No. 540

ISSUED FOR CONSTRUCTION

NO.	DATE	DESCRIPTION	INITIAL(S)
01	2026-06-09	ISSUED FOR CONSTRUCTION	JF
02	2026-06-09	ISSUED FOR REVIEW	JF
03	2026-06-09	ISSUED FOR REVIEW	JF
04	2026-06-09	ISSUED FOR REVIEW	JF

PRINTED DATE: 6/9/2026 3:51:23 PM

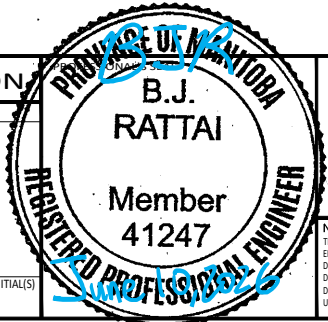

NOTE TO CONTRACTOR:
THE CONTRACTOR SHALL CHECK AND VERIFY ALL DIMENSIONS AND REPORT ALL ERRORS AND OMISSIONS TO CONSULTANT IN WRITING. DO NOT RELY ON SCALED DIMENSIONS. WRITTEN DIMENSIONS SHALL HAVE PRECEDENCE OVER SCALED DIMENSIONS. CONTACT THE CONSULTANT FOR CLARIFICATIONS IF NECESSARY. THIS DRAWING SHALL NOT BE USED FOR BUILDING PERMIT OR CONSTRUCTION PURPOSES UNLESS IT IS SEALED AND SIGNED BY THE CONSULTANT RESPONSIBLE FOR THE WORK.

COPYRIGHT 2026
THIS DRAWING AND THE DESIGN REPRESENTED IN IT IS AND AT ALL TIMES REMAINS THE EXCLUSIVE PROPERTY OF DGH ENGINEERING LTD. (DGH) AND SHALL NOT BE REPRODUCED WITHOUT PERMISSION FROM DGH. ANY REPRODUCTION MUST NOT BE ALTERED IN ANY WAY AND SHALL BE COMPLETE INCLUDING THIS NOTICE AND ALL TITLE BLOCK INFORMATION. ALL INFORMATION SHOWN ON THIS DRAWING IS FOR USE ON THE SPECIFIED PROJECT ONLY, AND SHALL NOT BE USED OTHERWISE WITHOUT THE WRITTEN PERMISSION OF DGH.

CLIENT

DWAsitework

WINNIPEG MB.

DESIGNED
NSB

DRAWN
FK

COORDINATOR
JC

DATE
MAR/2026

SCALE
AS NOTED

SSM

PROJECT TITLE	WADING POOL CONVERSION AT MICHAELLE JEAN PARK/NORQUAY COMMUNITY CENTRE
PROJECT LOCATION	65 GRANVILLE ST. WINNIPEG, MB.
PROJECT NUMBER:	4289-001
SPLASH PAD - FOUNDATION PLAN	S1-1
REV. 000	