


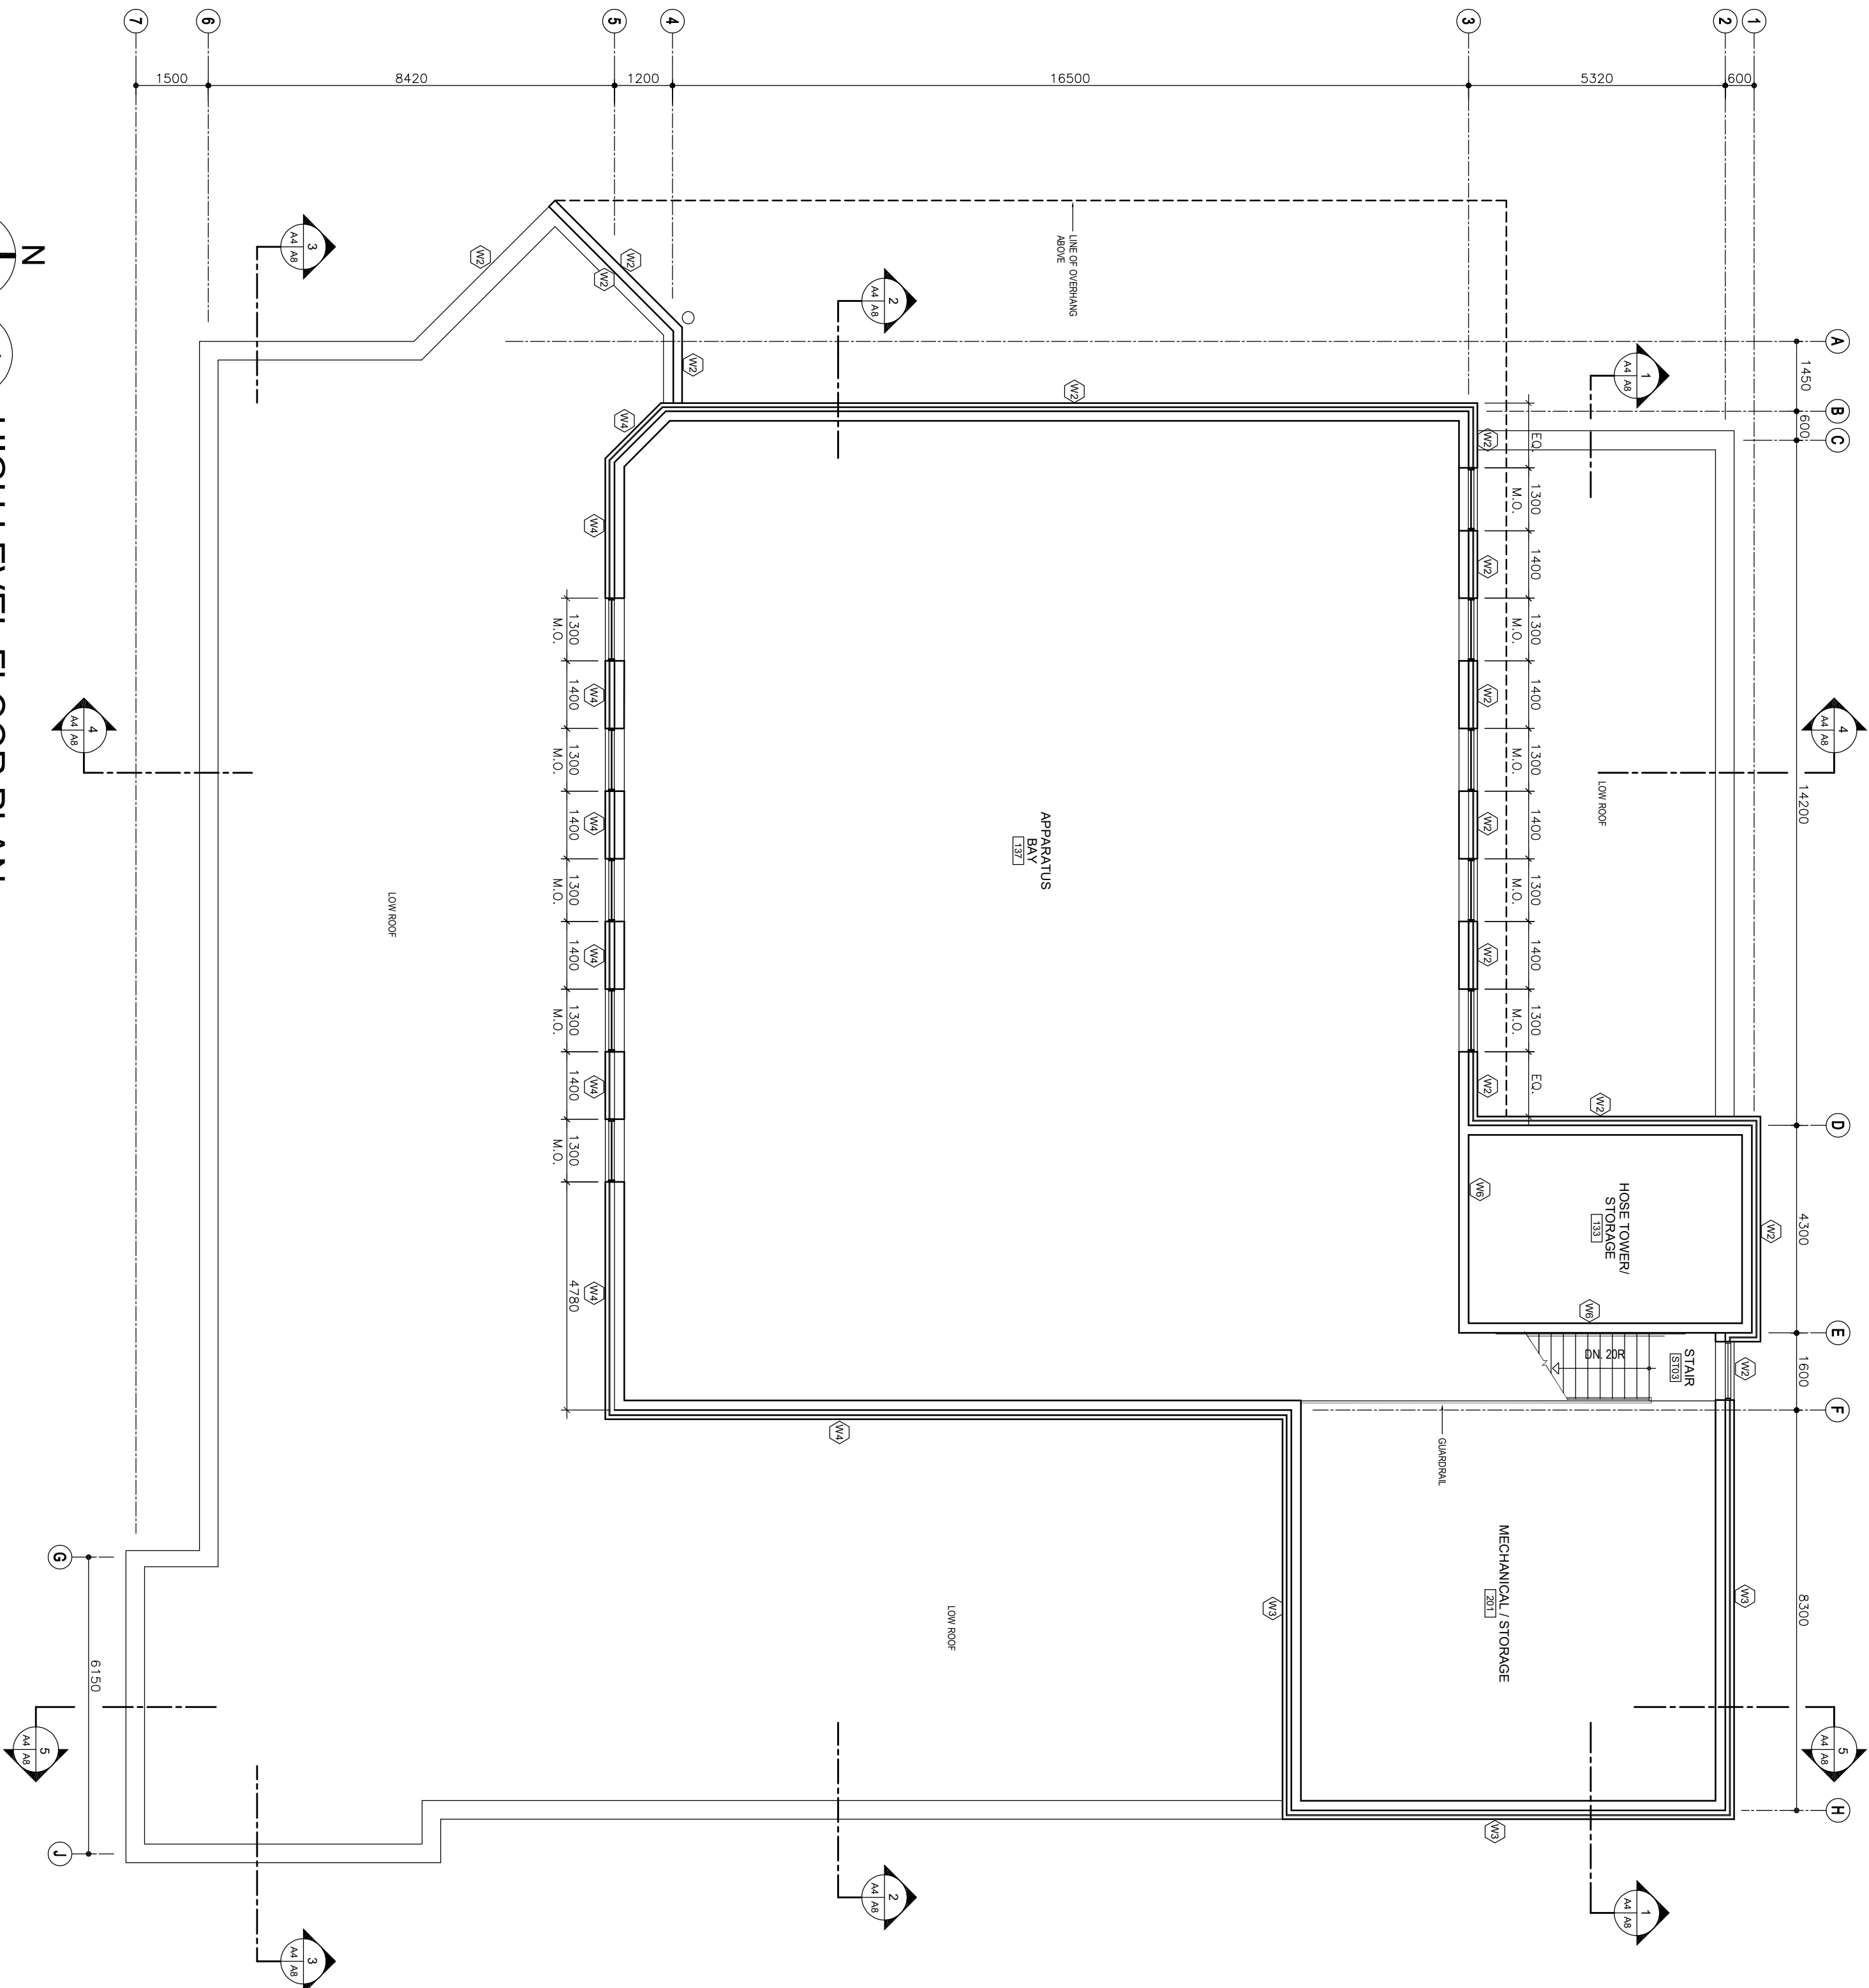

1 HIGH LEVEL FLOOR PLAN
SCALE: 1:100

B	ISSUED FOR DESIGN BUILD RFP	PS	MAR 7 2025
A	ISSUED FOR CLASS 3 ESTIMATE	PS	MAY 24 2024
No.	REVISION / DESCRIPTION	BY	DATE

SEAL

2024.03.25	BP / PS	PS	
DATE	DESIGNED	DRAWN	CHECKED / APPROVED

THE CITY OF WINNIPEG
ASSETS & PROJECT MANAGEMENT
DEPARTMENT
MUNICIPAL ACCOMMODATIONS DIVISION
3-65 GARRY STREET, R3C 4K4

PROJECT
WINNIPEG FIRE PARAMEDIC SERVICE
STATION 15

RUTH CROSSING AT BISON DRIVE

SHEET TITLE

HIGH LEVEL FLOOR PLAN

PRELIMINARY ONLY
NOT FOR CONSTRUCTION

SCALE	PROJECT No.	SHEET No.
AS SHOWN	2022-097	A4

DRAWING SHEET SIZE: A1 (594x841) PLOT 1:1