


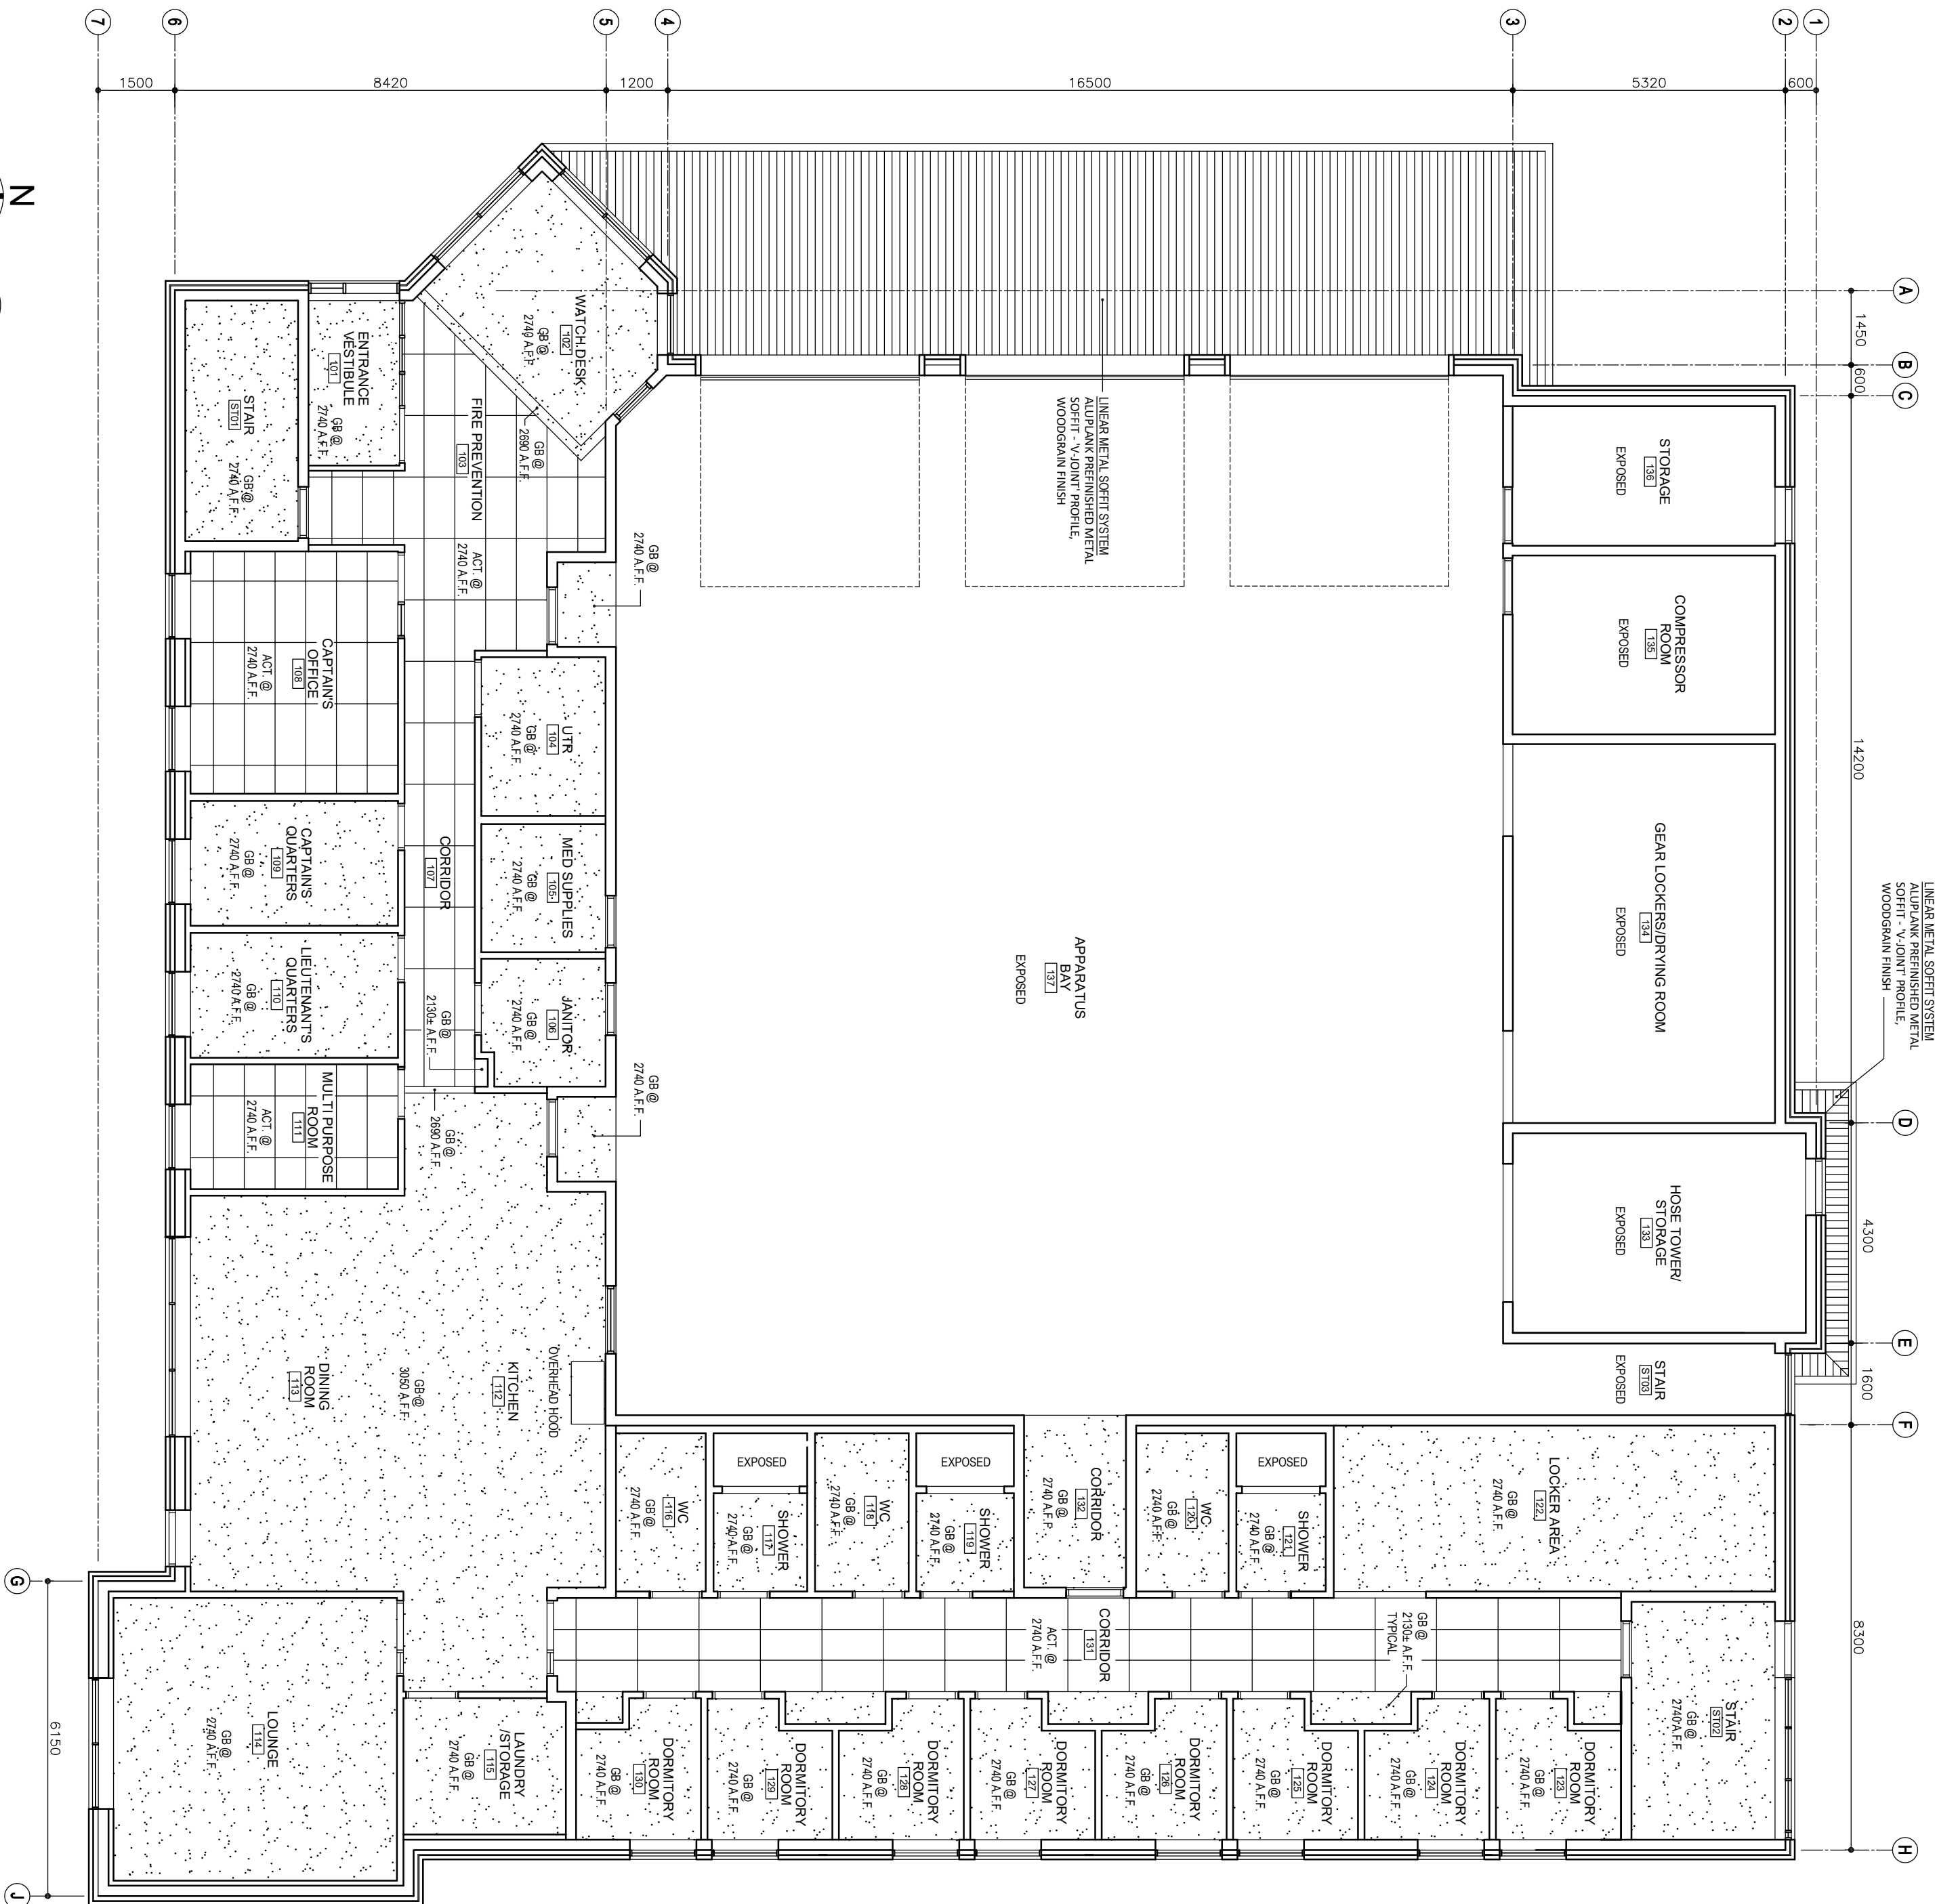

1 REFLECTED CEILING PLAN - MAIN FLOOR
SCALE: 1:100

- ACOUSTIC TILE CEILING SYSTEM (ACT)
- GYP SUM BOARD CEILING SYSTEM (GB)

B	ISSUED FOR DESIGN BULD RFP	PS	MAR 7 2025
A	ISSUED FOR CLASS 3 ESTIMATE	PS	MAY 24 2024
No.	REVISION / DESCRIPTION	BY	DATE

SEAL

2024.03.25	BP / PS	PS	
DATE	DESIGNED	DRAWN	CHECKED
			APPROVED

THE CITY OF WINNIPEG
ASSETS & PROJECT MANAGEMENT
DEPARTMENT
MUNICIPAL ACCOMMODATIONS DIVISION
3-65 GARRY STREET, R3C 4K4

PROJECT
WINNIPEG FIRE PARAMEDIC SERVICE
STATION 15

RUTH CROSSING AT BISON DRIVE

SHEET TITLE
REFLECTED CEILING PLAN - MAIN FLOOR

SCALE	PROJECT No.	SHEET No.
AS SHOWN	2022-097	A6

PRELIMINARY ONLY
NOT FOR CONSTRUCTION

DRAWING SHEET SIZE: A1 (594x841) PLOT 1:1