


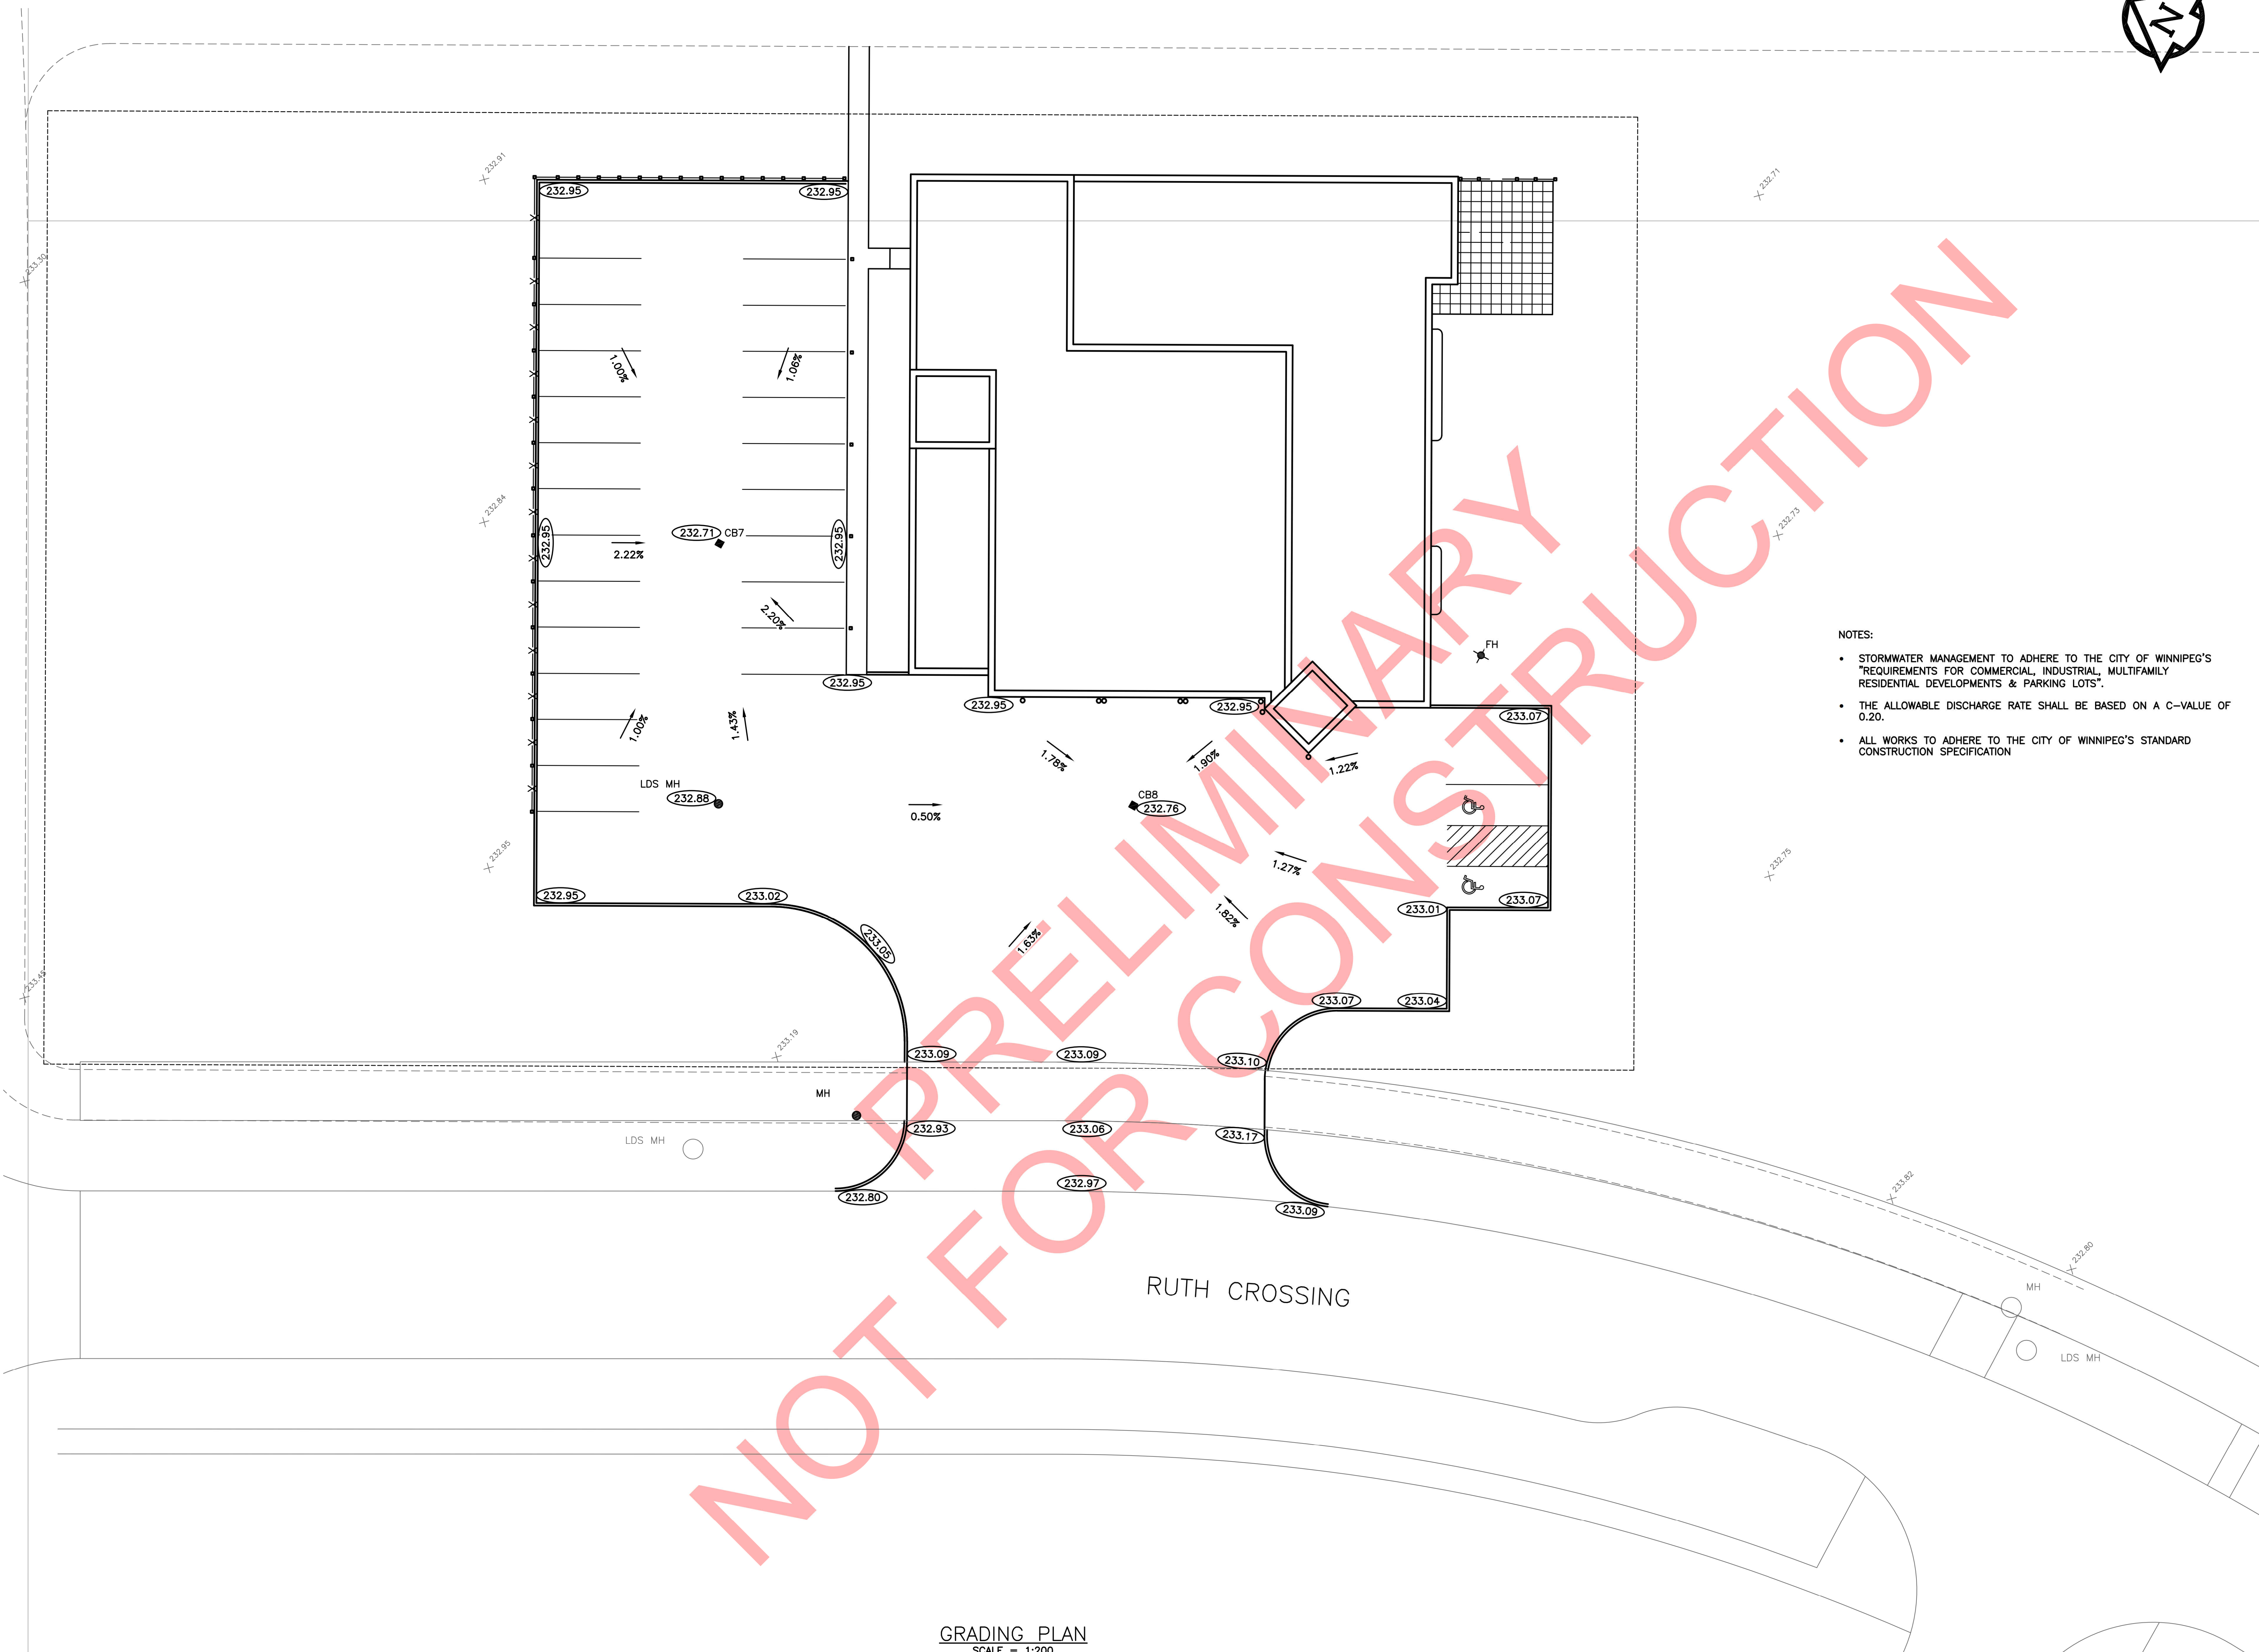


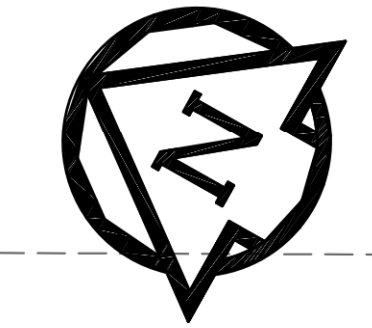

- NOTES:
- STORMWATER MANAGEMENT TO ADHERE TO THE CITY OF WINNIPEG'S "REQUIREMENTS FOR COMMERCIAL, INDUSTRIAL, MULTIFAMILY RESIDENTIAL DEVELOPMENTS & PARKING LOTS".
 - THE ALLOWABLE DISCHARGE RATE SHALL BE BASED ON A C-VALUE OF 0.20.
 - ALL WORKS TO ADHERE TO THE CITY OF WINNIPEG'S STANDARD CONSTRUCTION SPECIFICATION

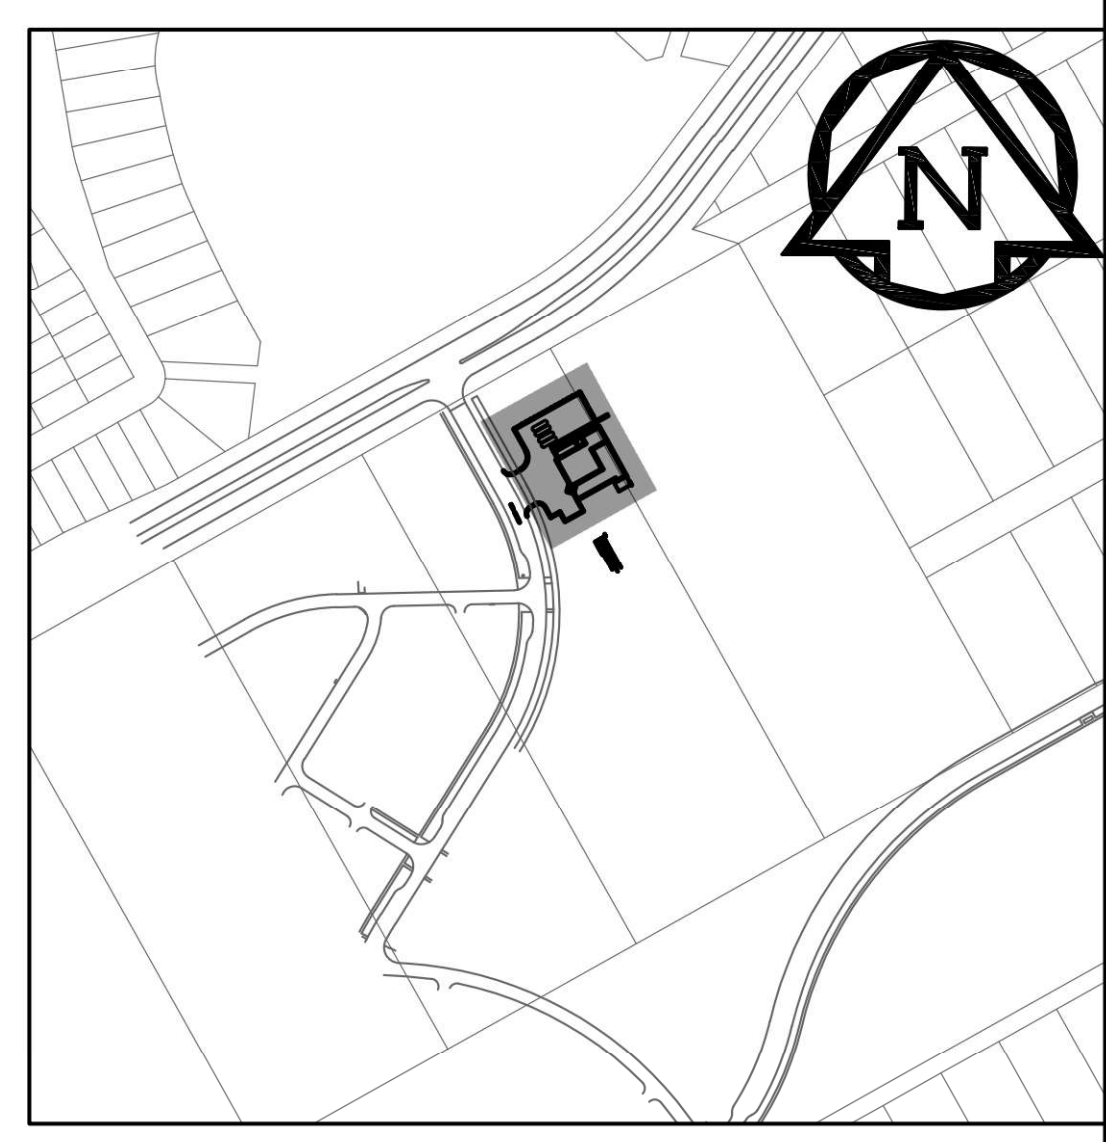

KEY PLAN
SCALE = NTS

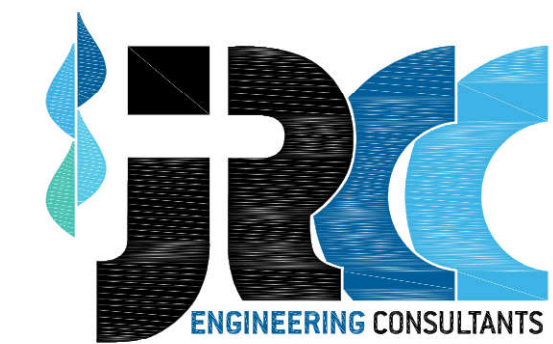

JR Cousin Consultants Ltd.
91A Scurfield Blvd. Winnipeg MB R3Y 1G4
p. (204) 489-0474
f. (204) 489-0487
www.jrcc.ca
ENGINEERING CONSULTANTS ENGINEERING EXCELLENCE SINCE 1981

1	-		-
0	ISSUED FOR DESIGN BUILD RFP-	DT	03-07 2025
A	ISSUED FOR CLASS 3 ESTIMATE	DT	05-23 2024
No.	REVISION/DESCRIPTION	BY	DATE

SEAL

2024.05.23	BP / PS	PS	CHECKED	APPROVED
DATE	DESIGNED	DRAWN		

 THE CITY OF WINNIPEG
ASSETS & PROJECT MANAGEMENT
DEPARTMENT
MUNICIPAL ACCOMMODATIONS DIVISION
3-65 GARRY STREET, R3C 4K4

PROJECT
WINNIPEG FIRE PARAMEDIC SERVICE
STATION 15

RUTH CROSSING AT BISON DRIVE
SHEET TITLE

GRADING PLAN

SCALE	PROJECT No:	SHEET No:
AS SHOWN	2022-097	C2

DRAWING SHEET SIZE: A1 (594x841) PLOT 1:1

GRADING PLAN
SCALE = 1:200