


RUTH CROSSING

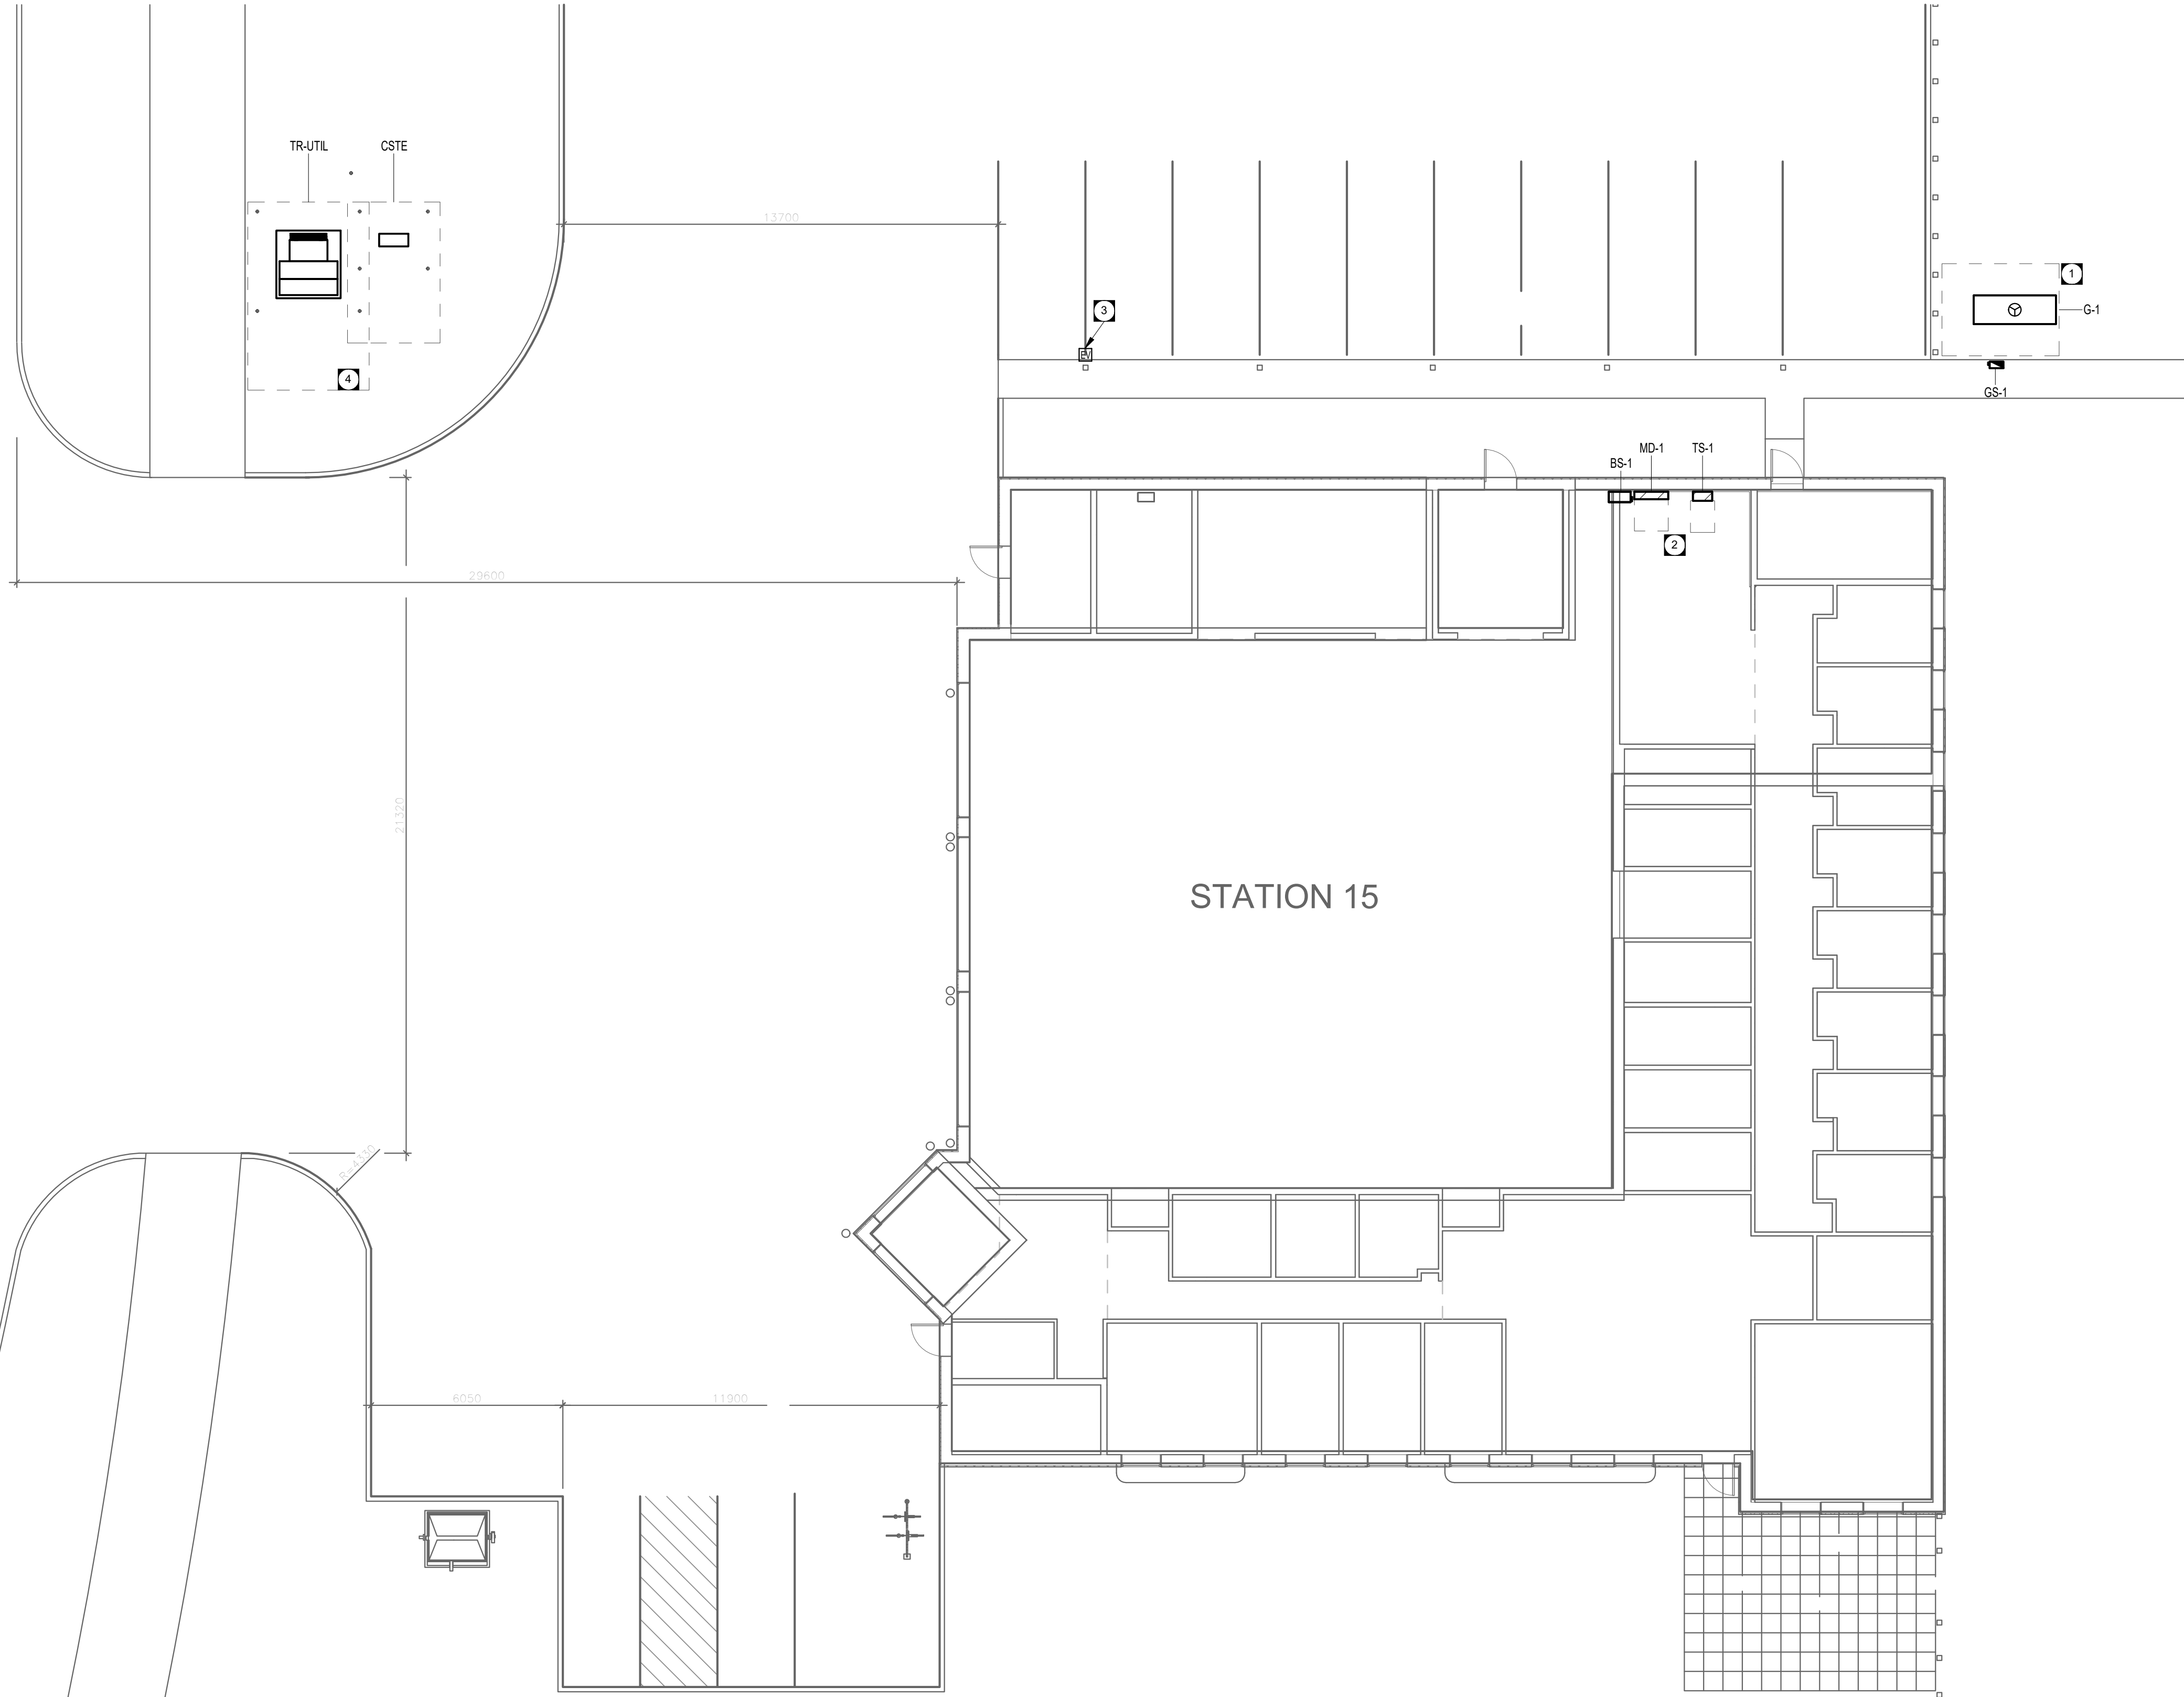

- KEY NOTES
- 1 PROPOSED LOCATION OF PORTABLE EMERGENCY GENERATOR AND DISCONNECT SWITCH. PROVIDE RACKING OR PEDESTAL FOR DISCONNECT AS REQUIRED.
 - 2 ELECTRICAL DISTRIBUTION EQUIPMENT LOCATED IN BASEMENT ELECTRICAL ROOM.
 - 3 PROPOSED LOCATION FOR 2 POST, LEVEL 2 EVSE CHARGER.
 - 4 PROPOSED LOCATION FOR MANITOBA HYDRO UTILITY TRANSFORMER AND CSTE.

1
E1.1 ELECTRICAL SITE PLAN
SCALE: 1 : 125

PRELIMINARY
NOT FOR CONSTRUCTION

es e epp siepman
engineering
400 - 136 Market Avenue
Winnipeg, MB R3B 0P4
T 204 453 1080

A	Issued for Review		24-06-16
No.	REVISION/DESCRIPTION	BY	DATE

SEAL

PRELIMINARY
NOT FOR CONSTRUCTION

Author DRAWN	Checker CHECKED	Designer DESIGNED	Approver APPROVED
DATE 12-07-24	USER APPROVAL		

Winnipeg THE CITY OF WINNIPEG
ASSETS & PROJECT MANAGEMENT
DEPARTMENT
MUNICIPAL ACCOMMODATIONS DIVISION
3-65 GARRY STREET, R3C 4K4

PROJECT
WINNIPEG FIRE PARAMEDIC SERVICE
STATION 15

RUTH CROSSING AT BISON DRIVE

SHEET TITLE
ELECTRICAL SITE
PLAN

SCALE 1:125	PROJECT No: 2022-97	SHEET No: E1.1
----------------	------------------------	-------------------

DRAWING SHEET SIZE: A1 (594x841) PLOT 1:1