


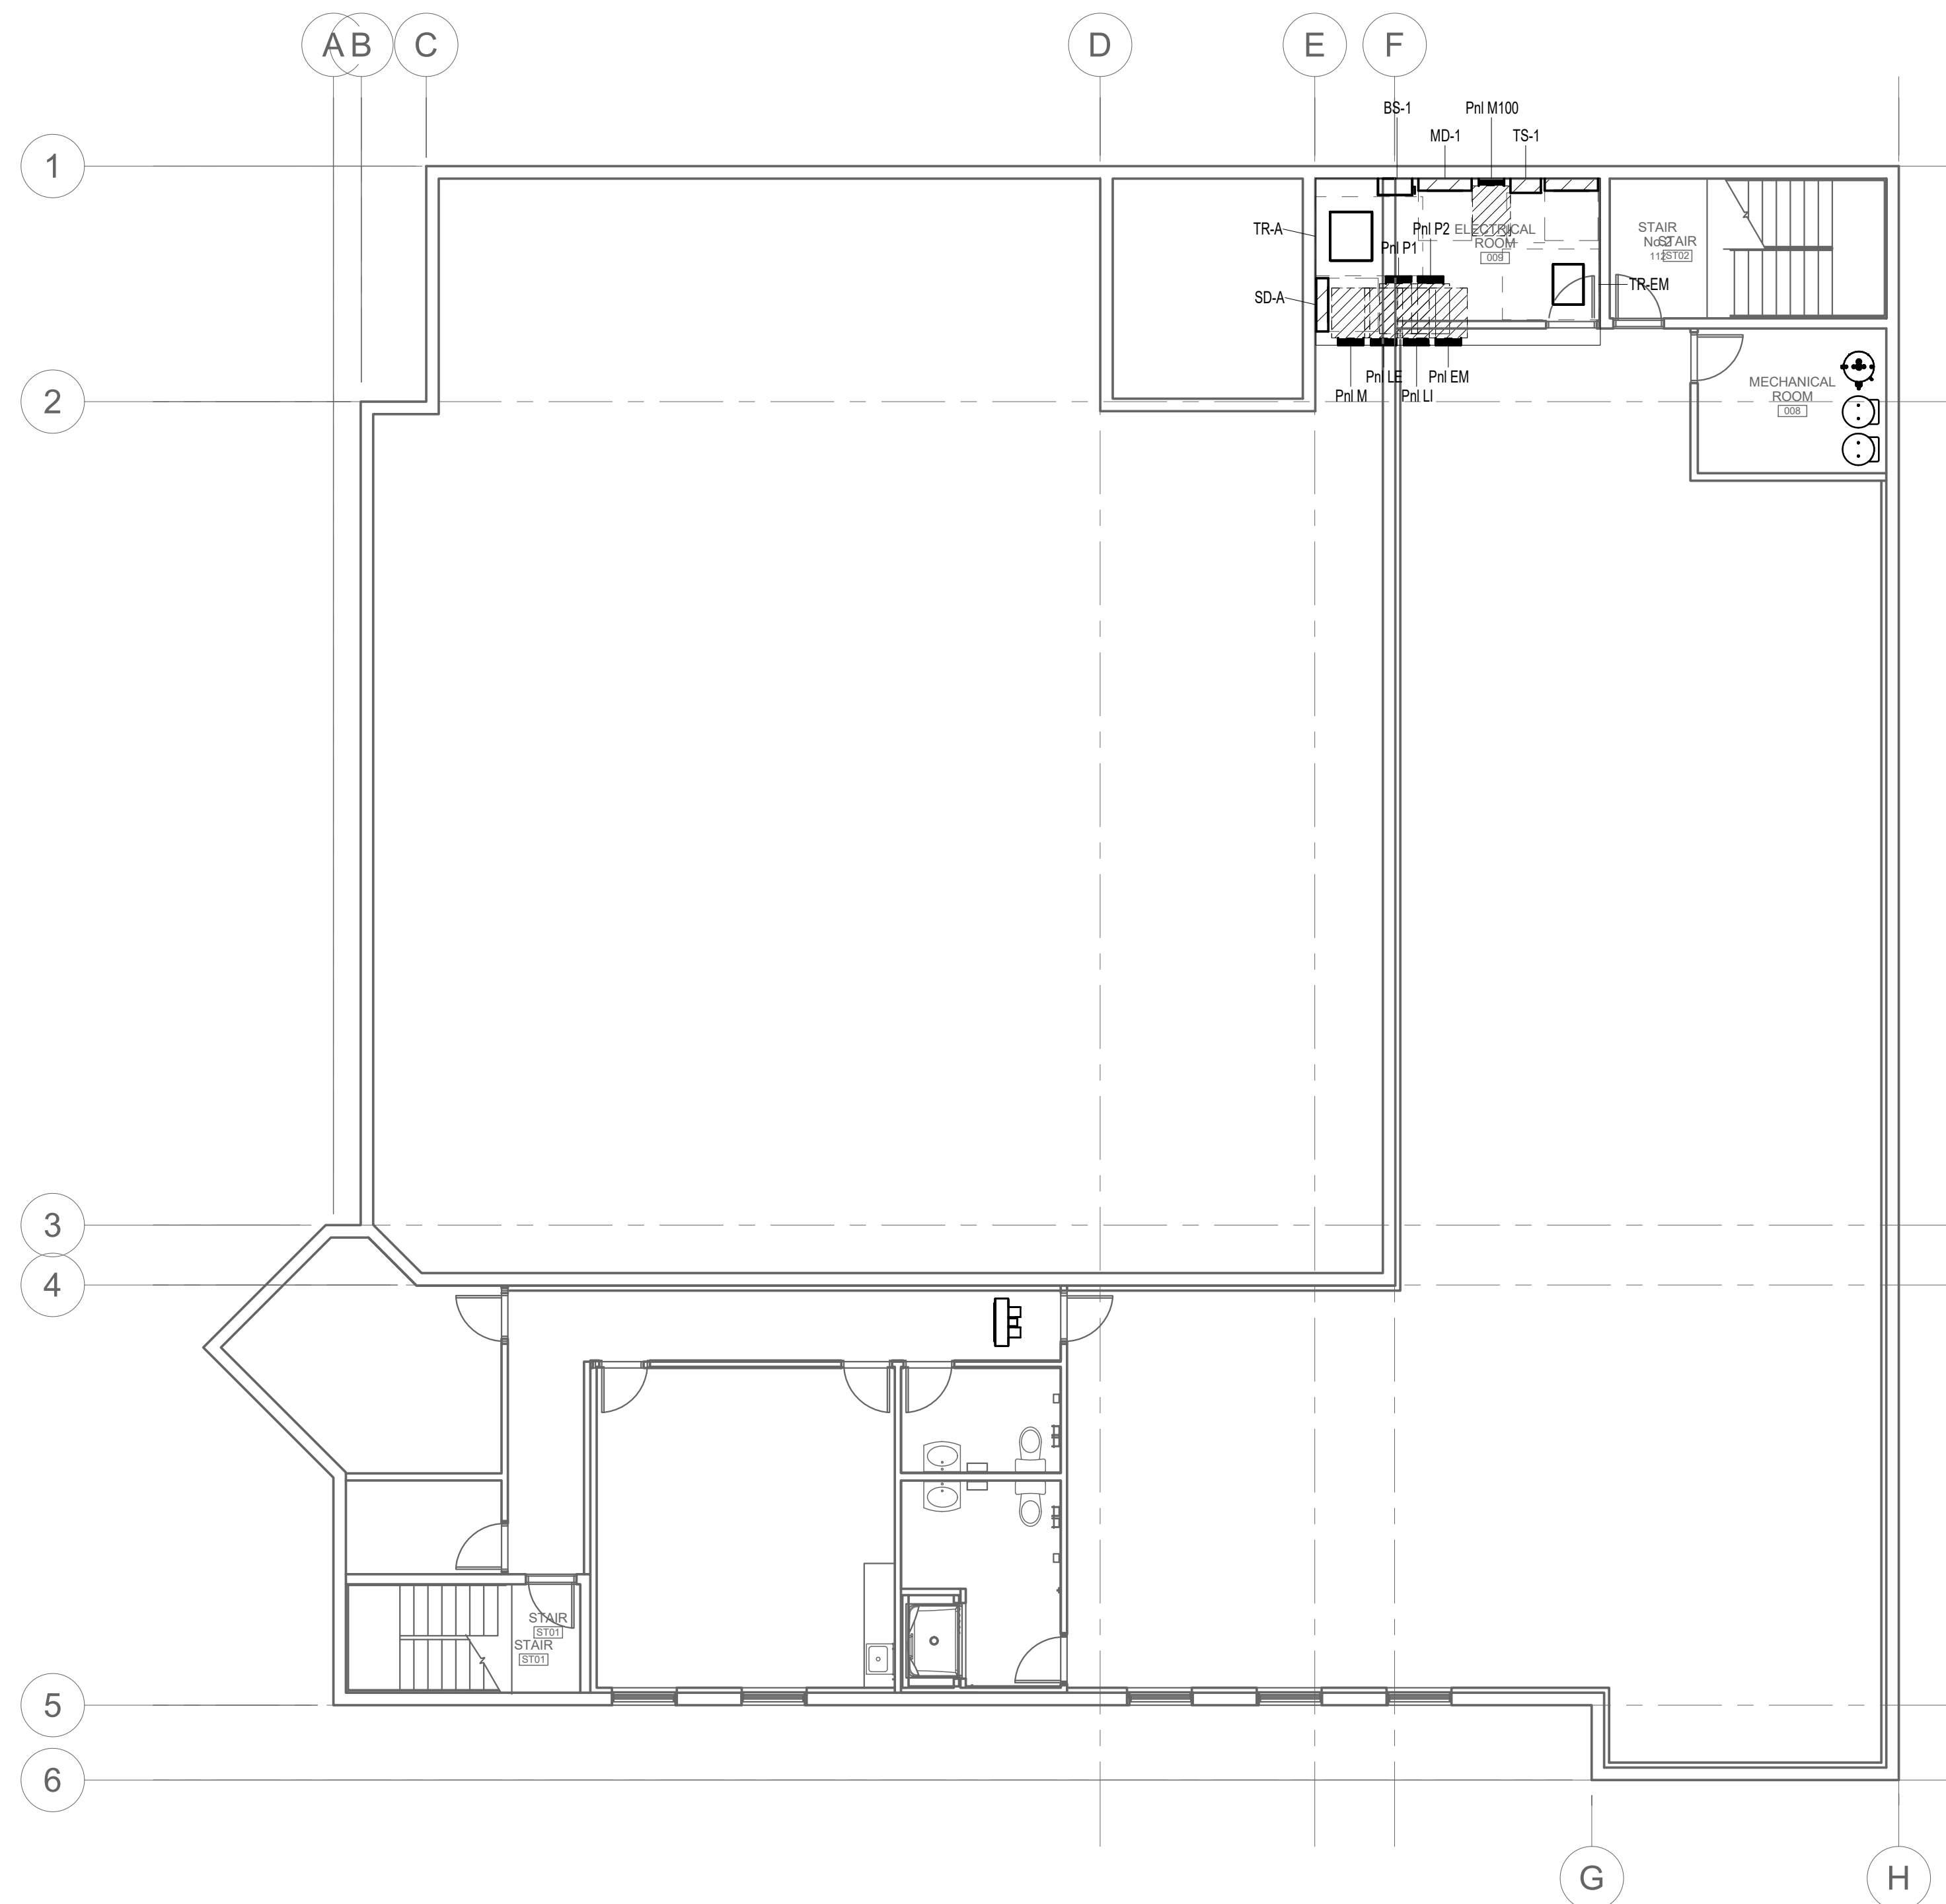

1 BASEMENT FLOOR PLAN - POWER & SYSTEMS
EP2.0 SCALE: 1 : 100

KEY NOTES

PRELIMINARY
NOT FOR CONSTRUCTION

es e **epp siepman**
engineering
400 - 136 Market Avenue
Winnipeg, MB R3B 0P4
T 204 453 1080

A	Issued for Review		24-06-16
No.	REVISION/DESCRIPTION	BY	DATE

SEAL

PRELIMINARY
NOT FOR CONSTRUCTION

Author DRAWN	Checker CHECKED	Designer DESIGNED	Approver APPROVED
DATE 12-07-24	USER APPROVAL		
 Winnipeg	THE CITY OF WINNIPEG ASSETS & PROJECT MANAGEMENT DEPARTMENT MUNICIPAL ACCOMMODATIONS DIVISION 3-65 GARRY STREET, R3C 4K4		
PROJECT WINNIPEG FIRE PARAMEDIC SERVICE STATION 15			
RUTH CROSSING AT BISON DRIVE			
SHEET TITLE BASEMENT FLOOR - POWER PLAN			
SCALE 1:100	PROJECT No: 2022-97		SHEET No: EP2.0