


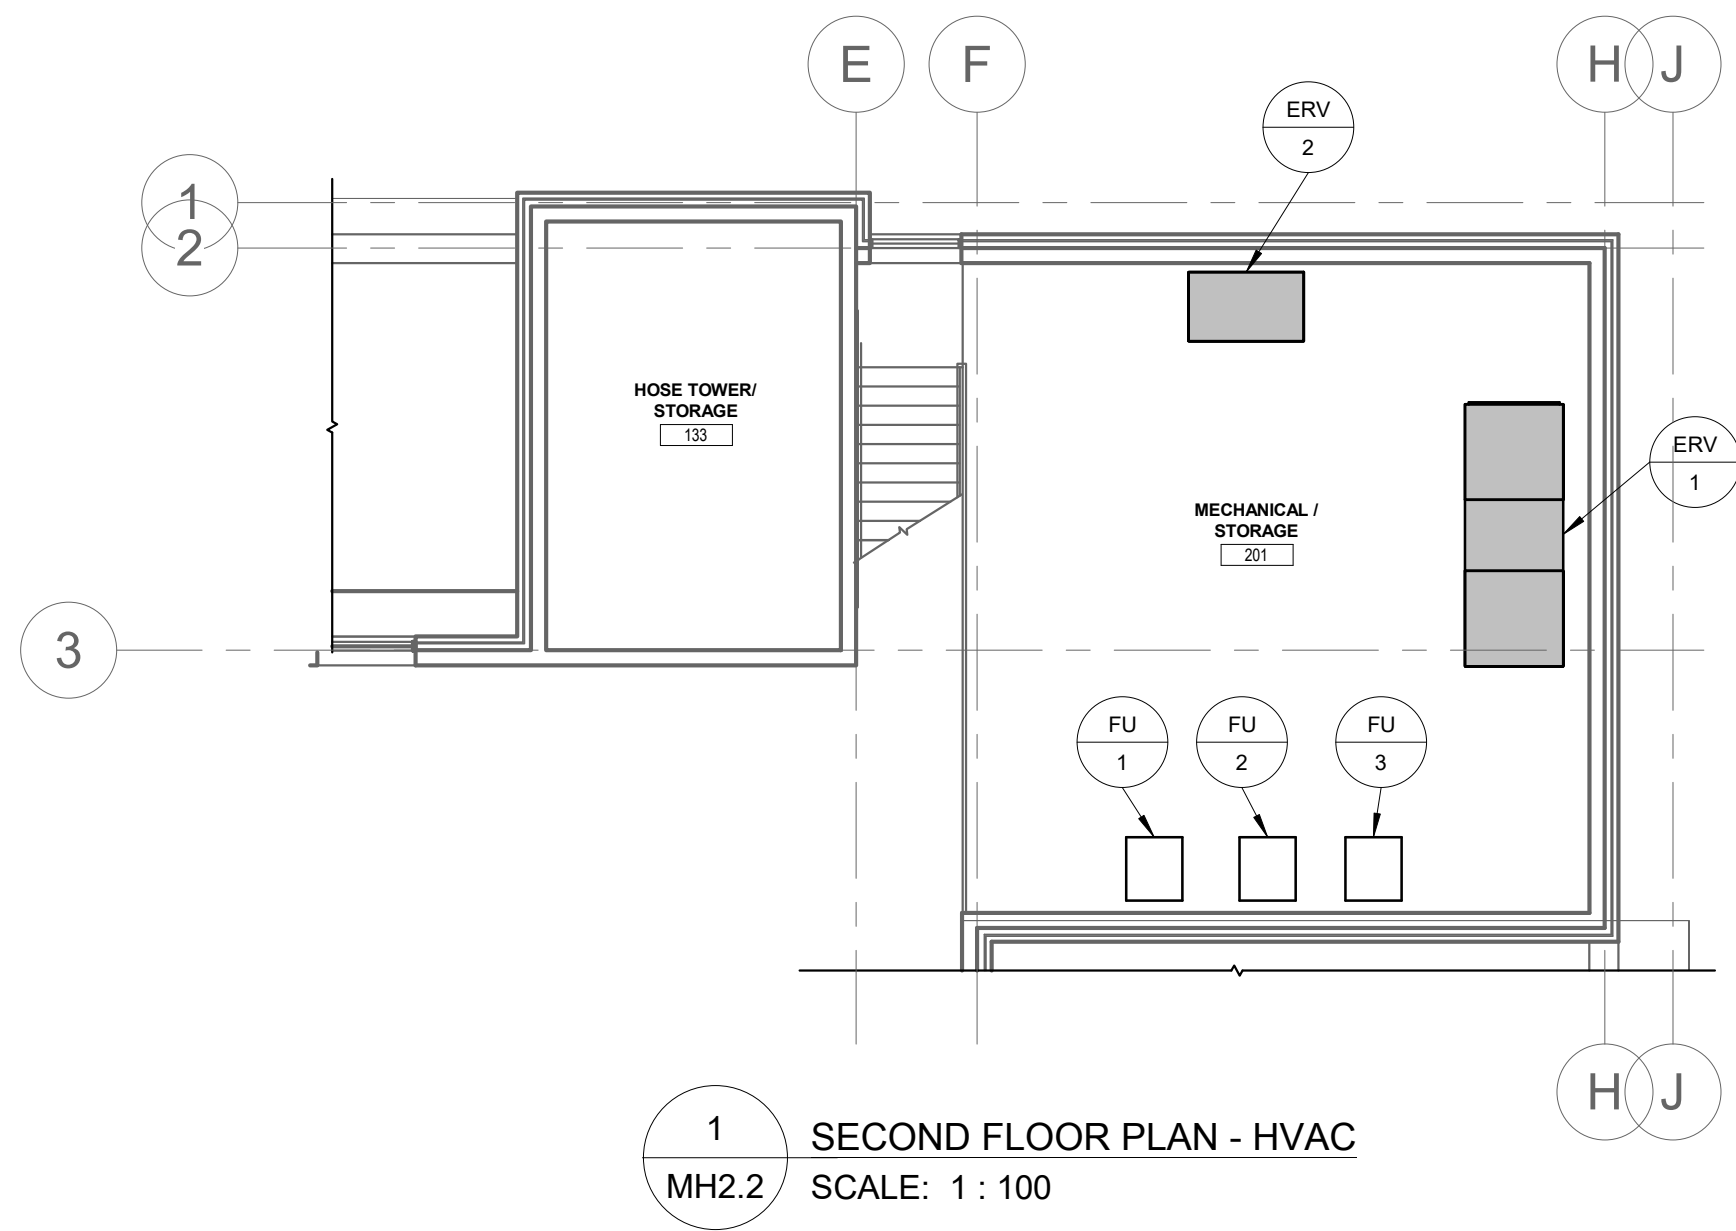

1
MH2.2 SECOND FLOOR PLAN - HVAC
SCALE: 1 : 100

PRELIMINARY
NOT FOR CONSTRUCTION



400 - 136 Market Avenue
Winnipeg, MB R3B 0P4
T 204 453 1080

0	ISSUED FOR DESIGN BUILD RFP		25.03.07
No.	REVISION/DESCRIPTION	BY	DATE

SEAL

PRELIMINARY
NOT FOR CONSTRUCTION

25.03.07	Designer	Author	Checker	Approver
DATE	DESIGNED	DRAWN	CHECKED	APPROVED



THE CITY OF WINNIPEG
ASSETS & PROJECT MANAGEMENT
DEPARTMENT
MUNICIPAL ACCOMMODATIONS DIVISION
3-65 GARRY STREET, R3C 4K4

PROJECT
WINNIPEG FIRE PARAMEDIC SERVICE
STATION 15

RUTH CROSSING AT BISON DRIVE

SHEET TITLE

MEZZANINE FLOOR HVAC PLAN

SCALE	PROJECT No:	SHEET No:
1 : 100	2022-097	MH2.2

DRAWING SHEET SIZE: A1 (594x841) PLOT 1:1